


45.0 M. WIDE ROAD

20.0 M. WIDE GREEN BELT

PHASE - 01  
TOWER - A  
TOTAL AREA = 20637.626 SQMT. LAND  
APPLIED FOR RERA REGISTRATION

WATER SUPPLY PLAN

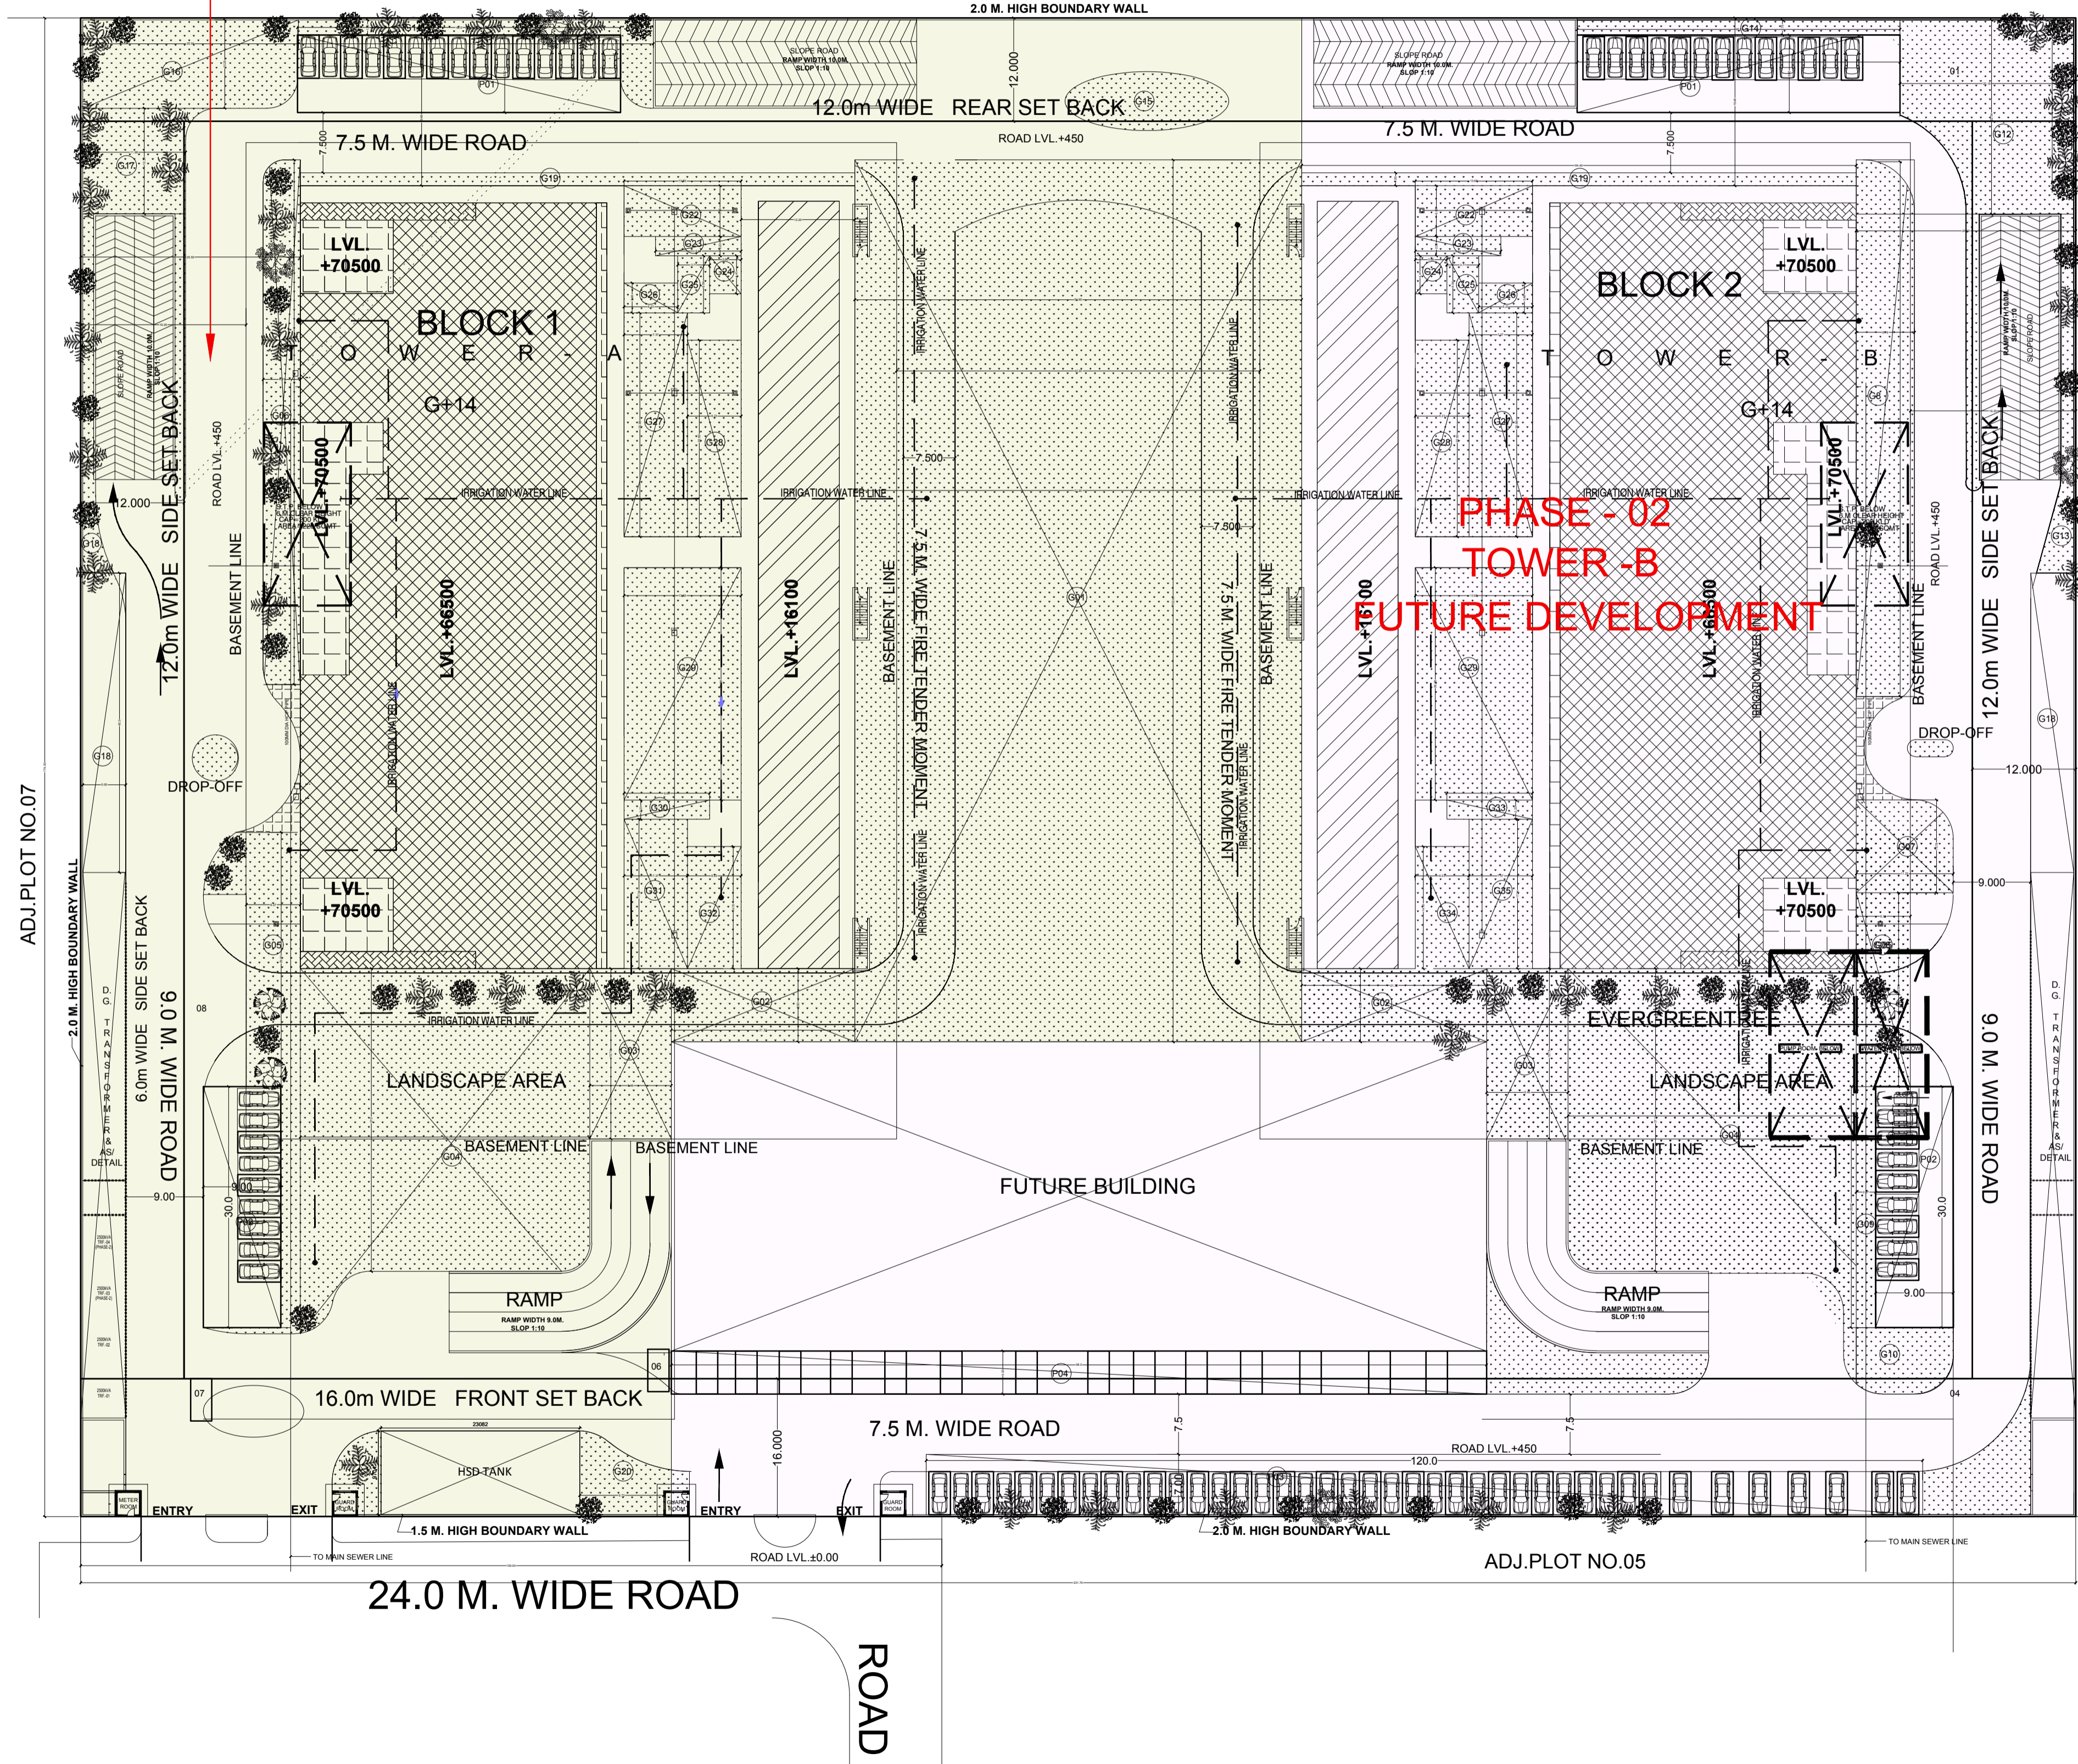

TOTAL PLOT AREA	%	40315.8	SQMT
PERMISSIBLE FAR	2	80631.6	SQMT
PERMISSIBLE GREEN AREA @5% ON 2.0 F.A.R.	0.05	4031.58	SQMT
<b>GRAND TOTAL (FAR+GREEN BUILDING)</b>		<b>84663.18</b>	SQMT
PERMISSIBLE SERVICES AREA @15% OF 2.0 FAR	15	12094.74	SQMT
PERMISSIBLE FACILITY AREA @10% OF 2.0 FAR	10	8063.16	SQMT
PERMISSIBLE GROUND COVERAGE @30% OF PLOT.	30	12094.74	SQMT
REQUIRED PARKING		1694	ECS

PROPOSED GROUND COVERAGE	9577.188	SQMT
PROPOSED FAR	84663.072	SQMT
PROPOSED SERVICE AREA	12028.826	SQMT
PROPOSED FACILITY FAR	8060.212	SQMT
PROPOSED IT FAR	76602.86	SQMT
PROPOSED PARKING	1700	ECS

TOTAL AREA	GREEN AREA			AREA	SQMT.
	LENGTH	WIDTH	NO		
G1	51.9	102.4	1	5314.560	SQMT.
G2	21.32	8.5	2	362.440	SQMT.
G3	9.46	19.78	2	374.238	SQMT.
G4	36	37	2	2664.000	SQMT.
G5	6.27	29.51	1	185.028	SQMT.
G6	4.31	60.92	1	262.565	SQMT.
G7	11.25	10.78	1	121.275	SQMT.
G8	6.3	22.5	1	141.750	SQMT.
G9	2.27	28	1	63.560	SQMT.
G10	AS/PLINE		1	250.000	SQMT.
G11	AS/PLINE		1	350.000	SQMT.
G12	20.18	22.54	1	454.857	SQMT.
G13	AS/PLINE		1	200.000	SQMT.
G14	48	1.75	2	168.000	SQMT.
G15	AS/PLINE		1	200.000	SQMT.
G16	25.04	10.25	1	256.660	SQMT.
G17	11.96	12.26	1	146.630	SQMT.
G18	AS/PLINE		1	125.000	SQMT.
G19	64.4	1.5	2	193.200	SQMT.
G20	9.73	7.88	1	76.770	SQMT.
G21	AS/PLINE		1	250.000	SQMT.
G22	13.6	5.9	2	160.480	SQMT.
G23	9.94	2.23	2	44.332	SQMT.
G24	3.66	4.41	2	32.281	SQMT.
G25	3.71	6.64	2	49.269	SQMT.
G26	6.23	3.48	2	43.361	SQMT.
G27	7.37	25.98	2	382.945	SQMT.
G28	6.23	22.82	2	284.337	SQMT.
G29	13.6	26.983	2	733.928	SQMT.
G30	9.94	2.23	1	22.166	SQMT.
G31	7.37	17.337	1	127.774	SQMT.
G32	6.23	14.177	1	88.323	SQMT.
G33	9.94	2.23	1	22.166	SQMT.
G34	6.23	14.177	1	88.323	SQMT.
G35	7.37	17.337	1	127.774	SQMT.
TOTAL GREEN AREA	TOTAL	TOTAL	TOTAL	14368.000	SQMT.

PLUMBING LEGEND

SYMBOL	DESCRIPTION
[Symbol]	450x500mm STORM CATCH BASIN
[Symbol]	600x600mm STORM CATCH BASIN
[Symbol]	900 & 1200mm DIA STORM & SEWER MANHOLE
[Symbol]	SAUCER DRAIN
[Symbol]	SEWERAGE PIPE
[Symbol]	STORM WATER PIPE
[Symbol]	SLOPE
[Symbol]	MUNICIPAL DOMESTIC LINE
[Symbol]	IRRIGATION LINE

20.0 M. WIDE GREEN BELT

45.0 M. WIDE ROAD

OWNER'S SIGN.

ARCHITECTS SIGN

PROJECT  
PROPOSED PLAN FOR INSTITUTIONAL BUILDING ON PLOT NO.06 SECTOR - 142 NOIDA, FOR SPLENDOR INFORMATION TECHNOLOGY PVT.LTD

DRAWING TITLE  
**WATER SUPPLY PLAN**

Scale 1:250

Date

SHEET. NO. DRG. NO.  
JOB. NO. A01