



PARK

ROAD

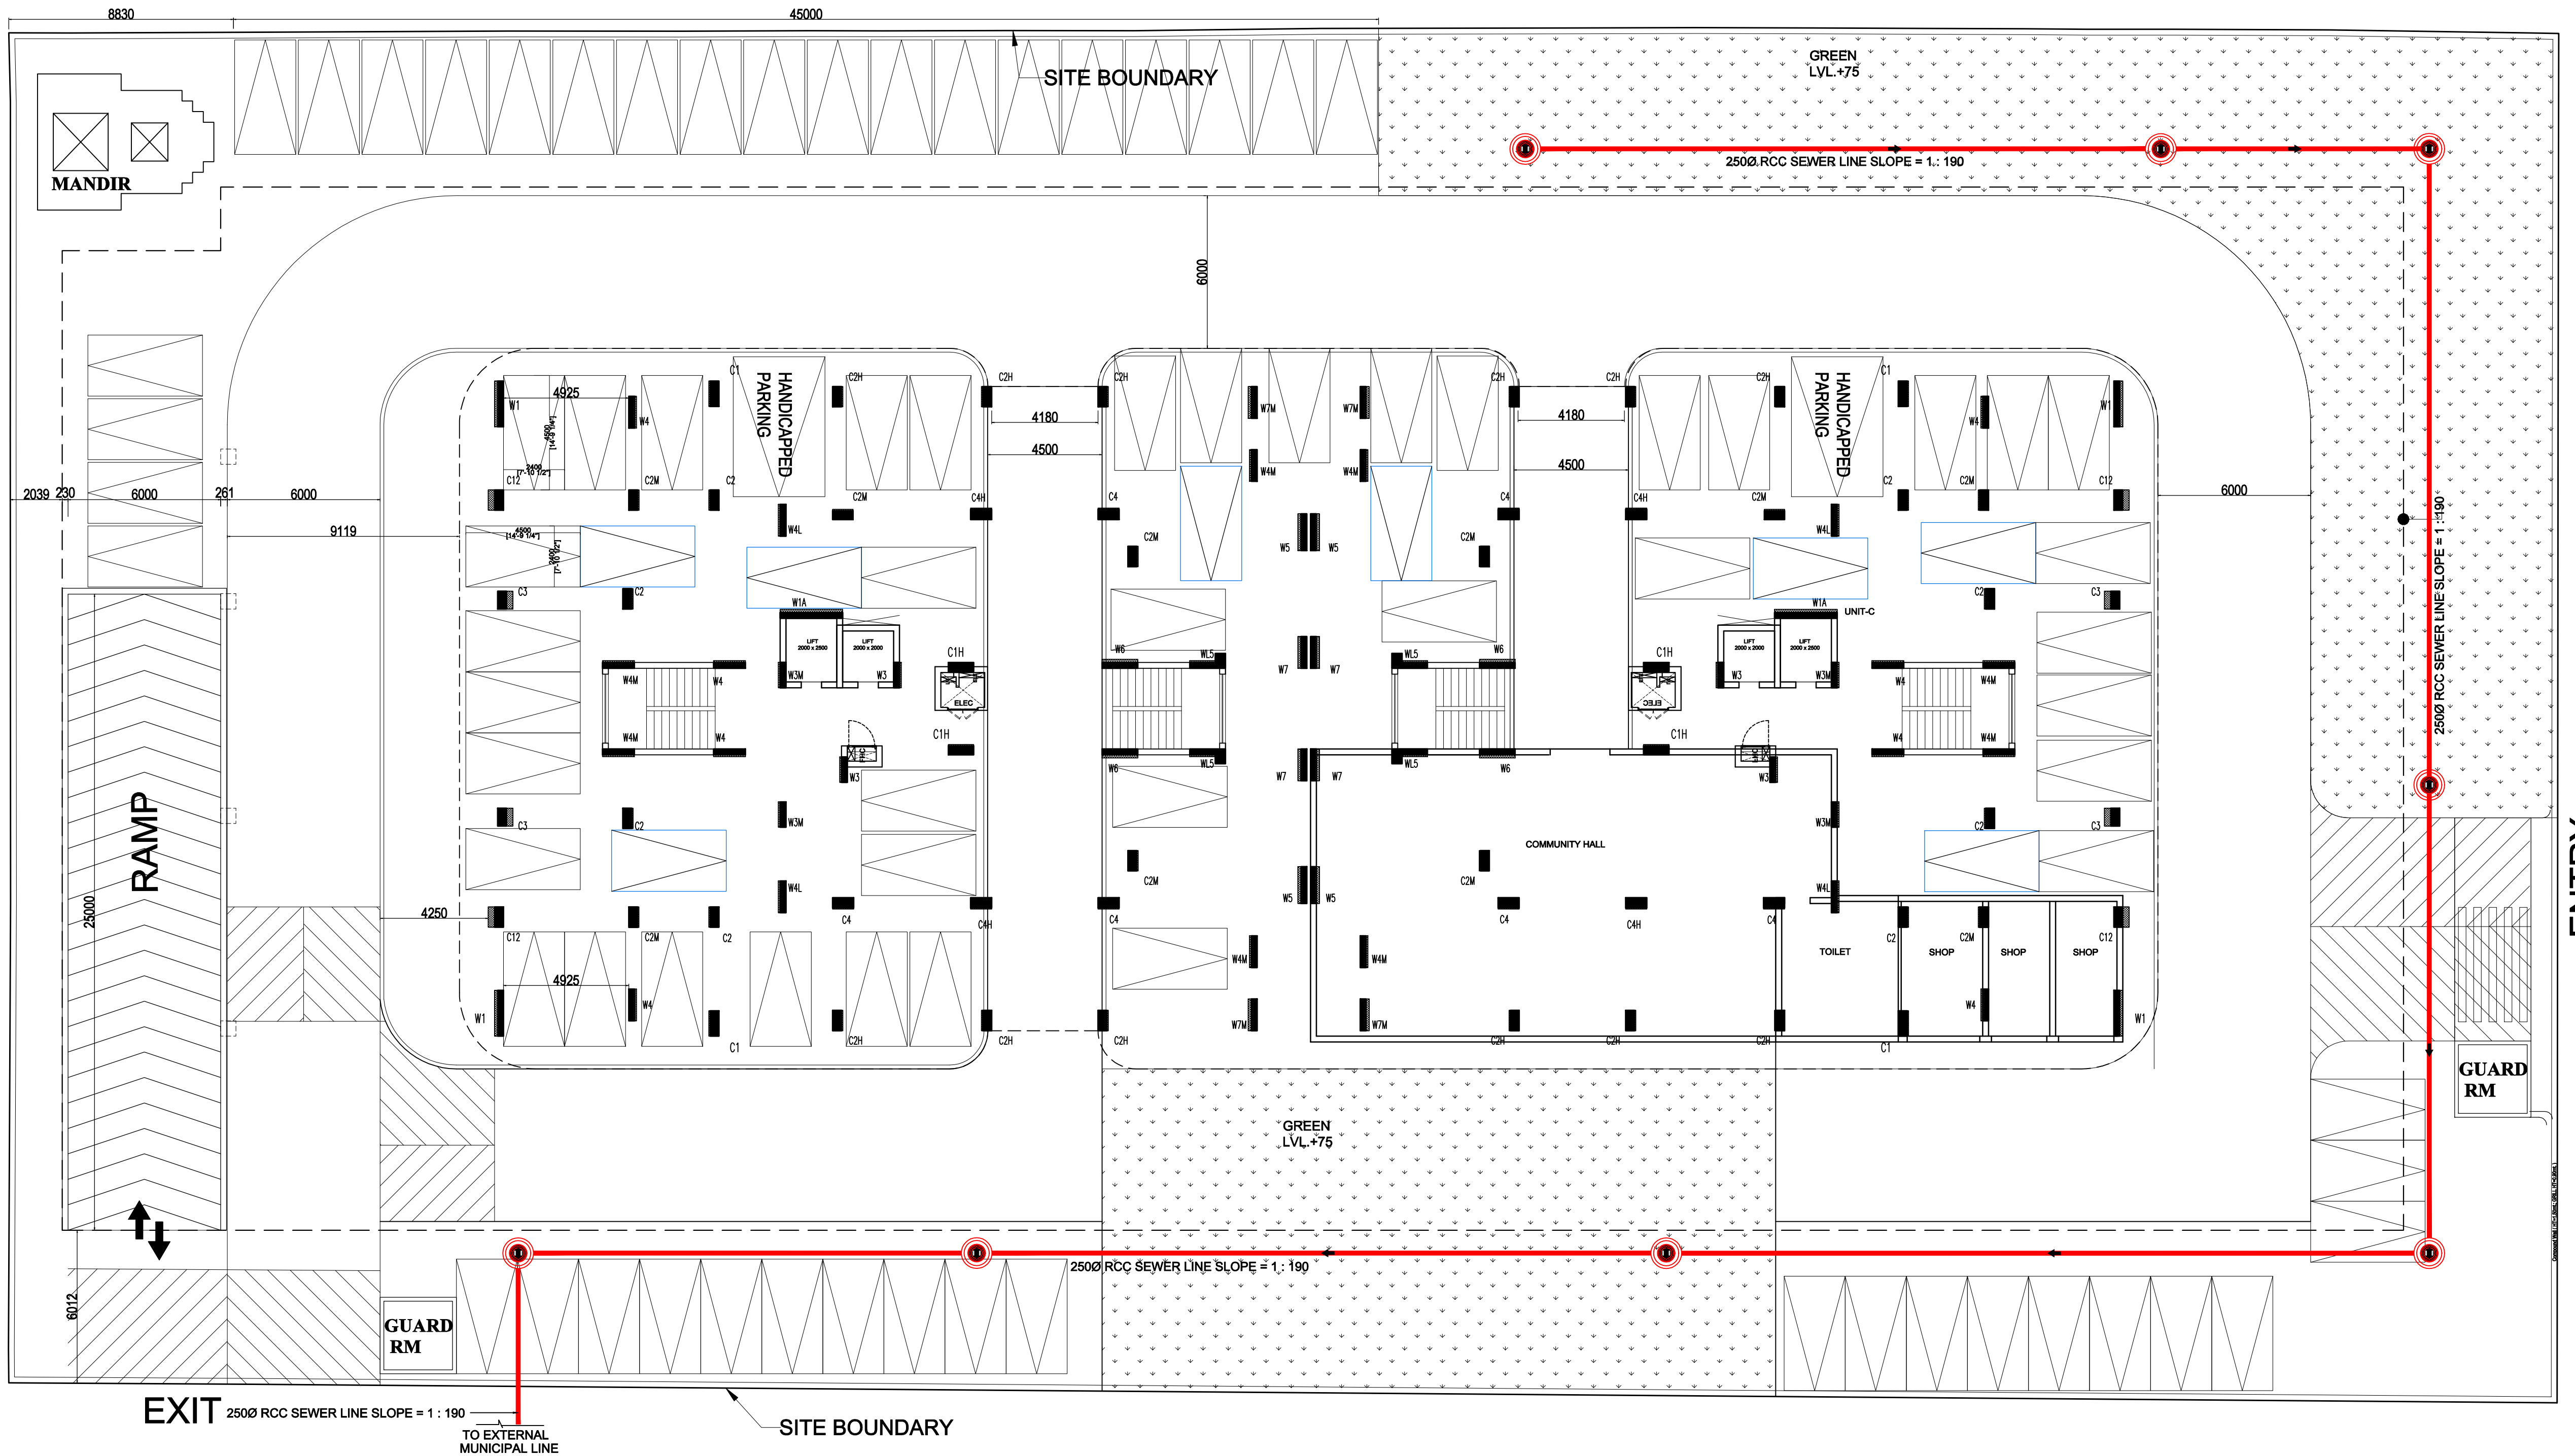

STILT FLOOR PLAN

LEGEND:-	
	MAIN SEWER LINE
	MAIN SEWER & STORM MANHOLE

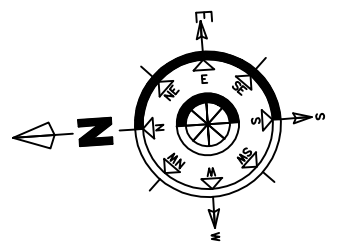

				CONSULTANTS	ARCHITECTS	PROJECT TITLE	DRAWING TITLE	SCALE:-	DRAWING NO.
				 SONI CONSULTANTS Plumbing & Fire Suppression Consultants B-2A/138, Janak Puri, New Delhi - 110058 P: +91 11 45501899, 41403781 e-mail: info@soniconsultants.in Website: www.soniiconsultants.in	 Manish Jain & Associates E-131, lower Ground floor, East of Kailash, New Delhi, India, 110065 P: +91 11 41084019	GROUP HOUSING AT LUCKNOW	EXTERNAL SERVICE LAYOUT PLAN SEWAGE PLAN	Date: 30-08-2024	GH/LKO/PL-ST-01
REVISIONS	DATE	DESCRIPTION	REMARKS						
R0	25-08-24	GFC							