



# ELECTRICAL LAYOUT

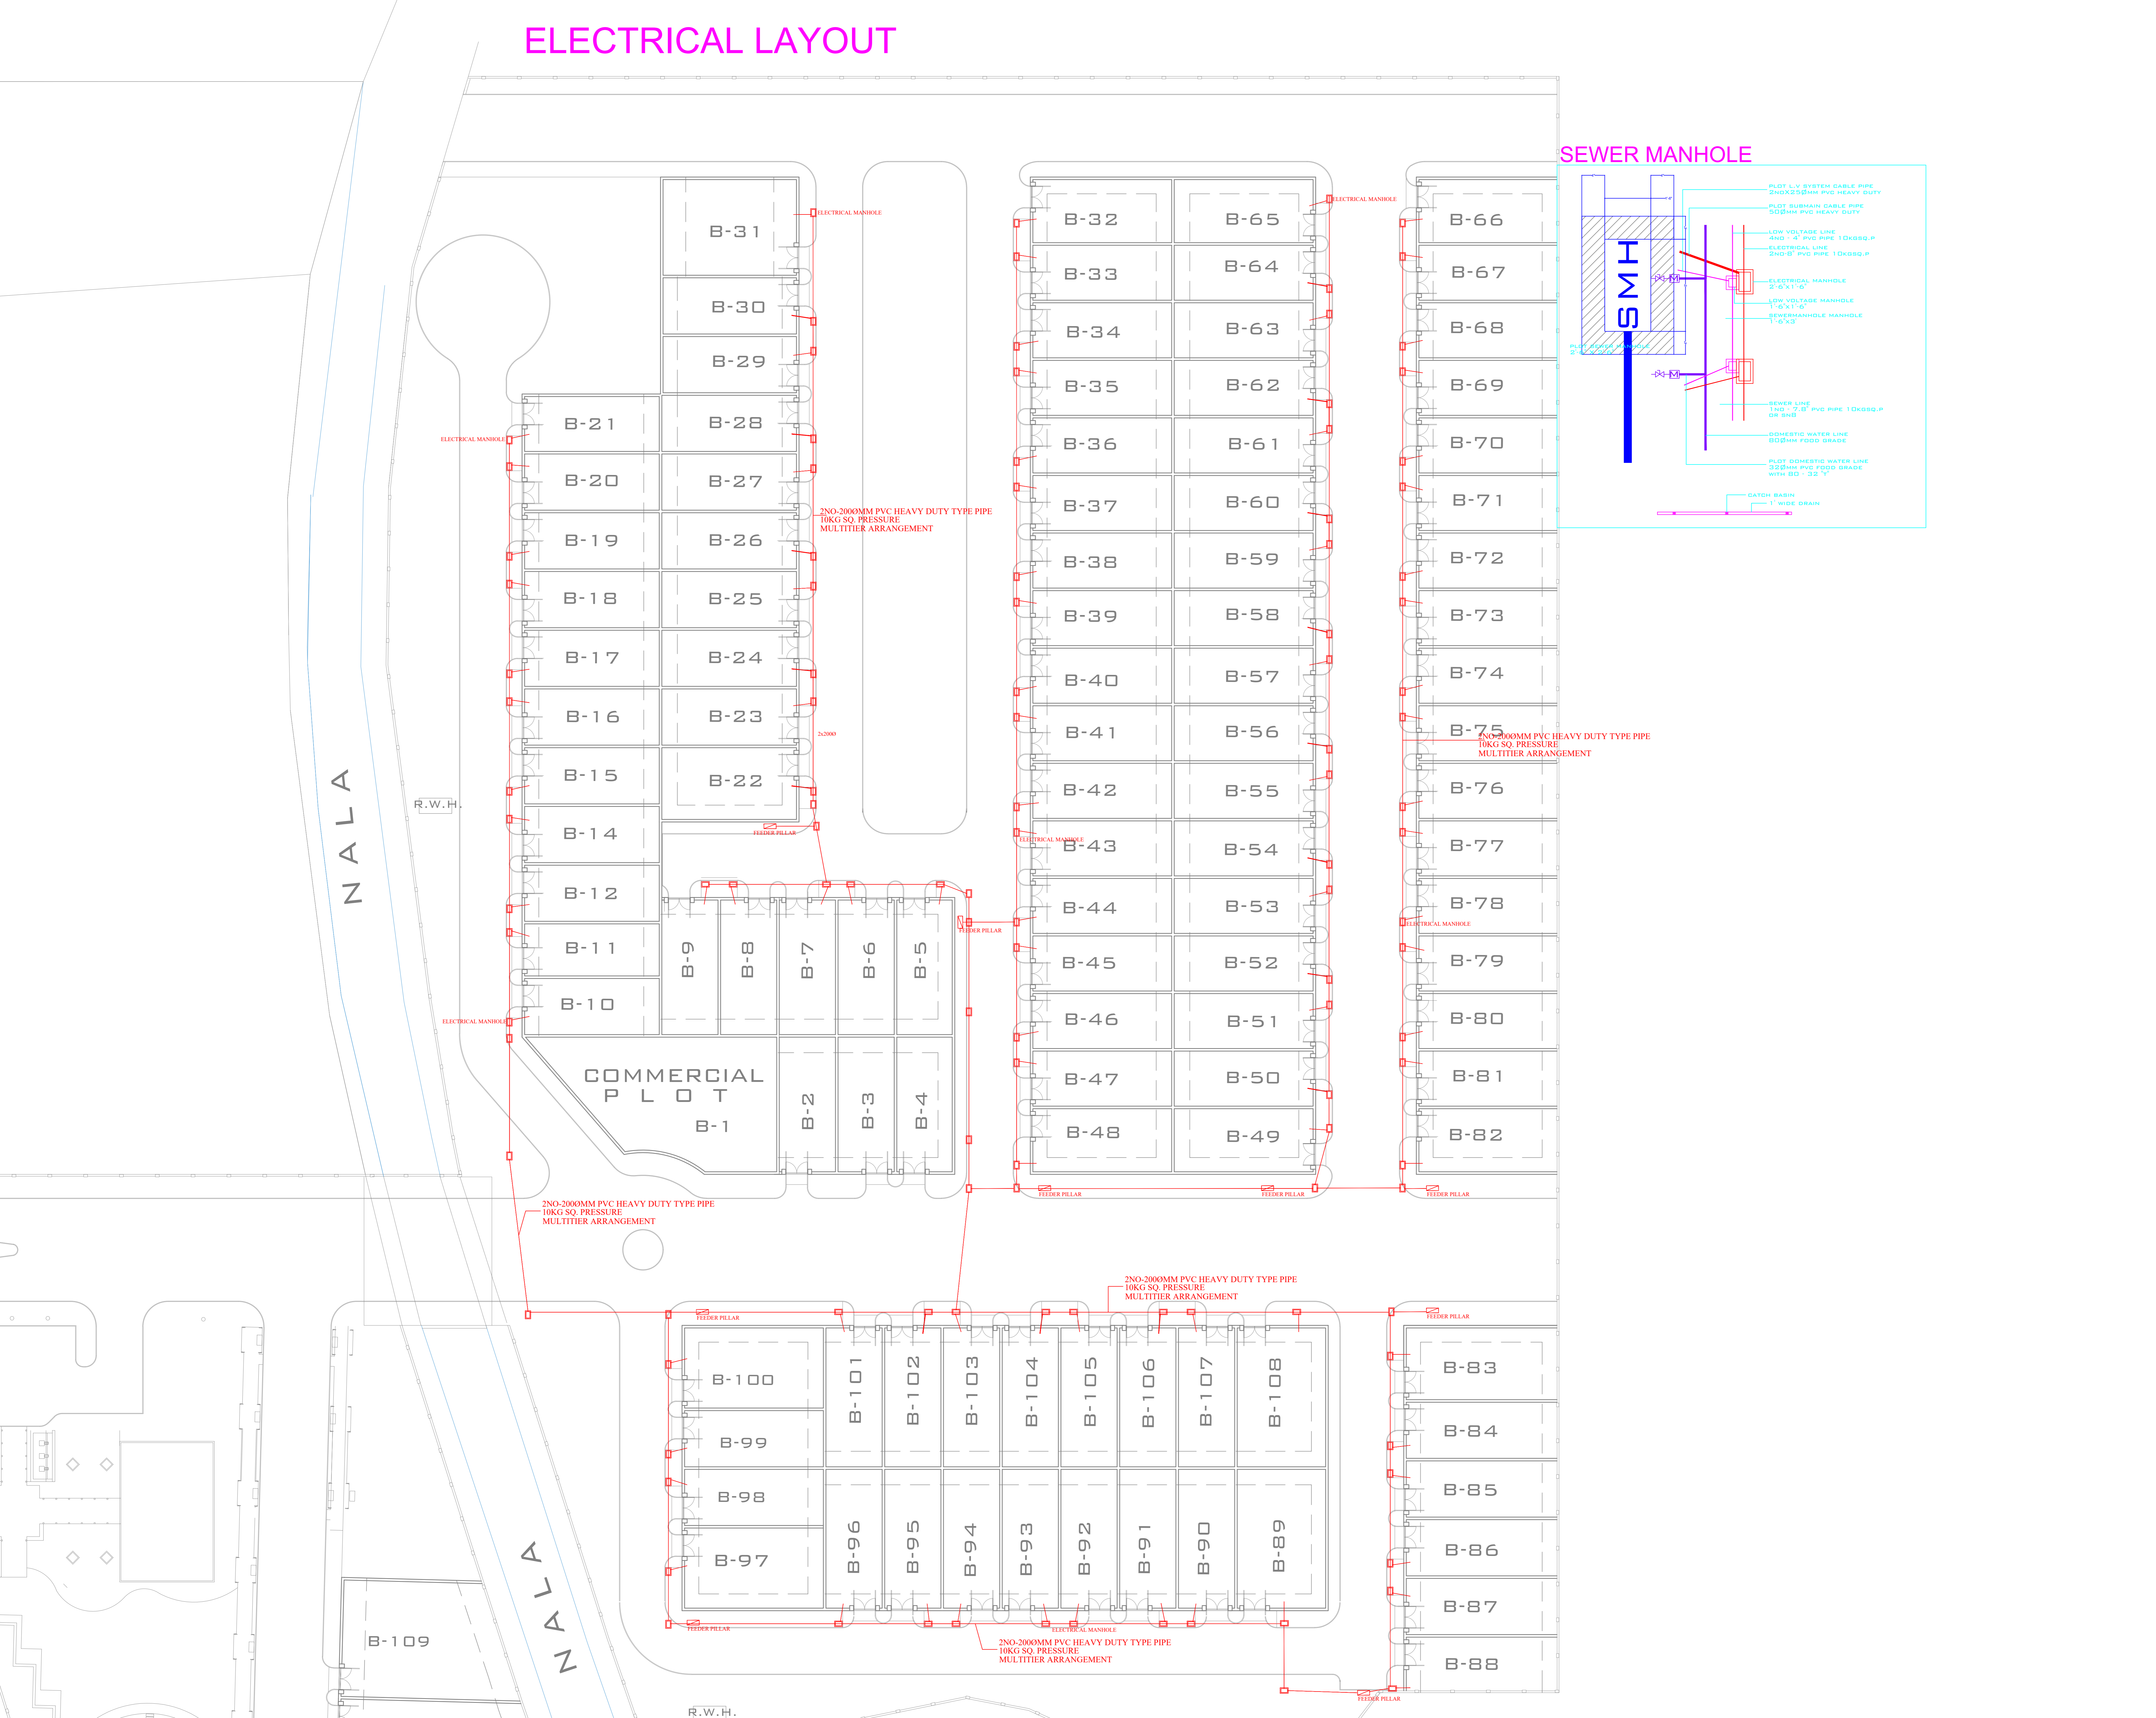

## SEWER MANHOLE

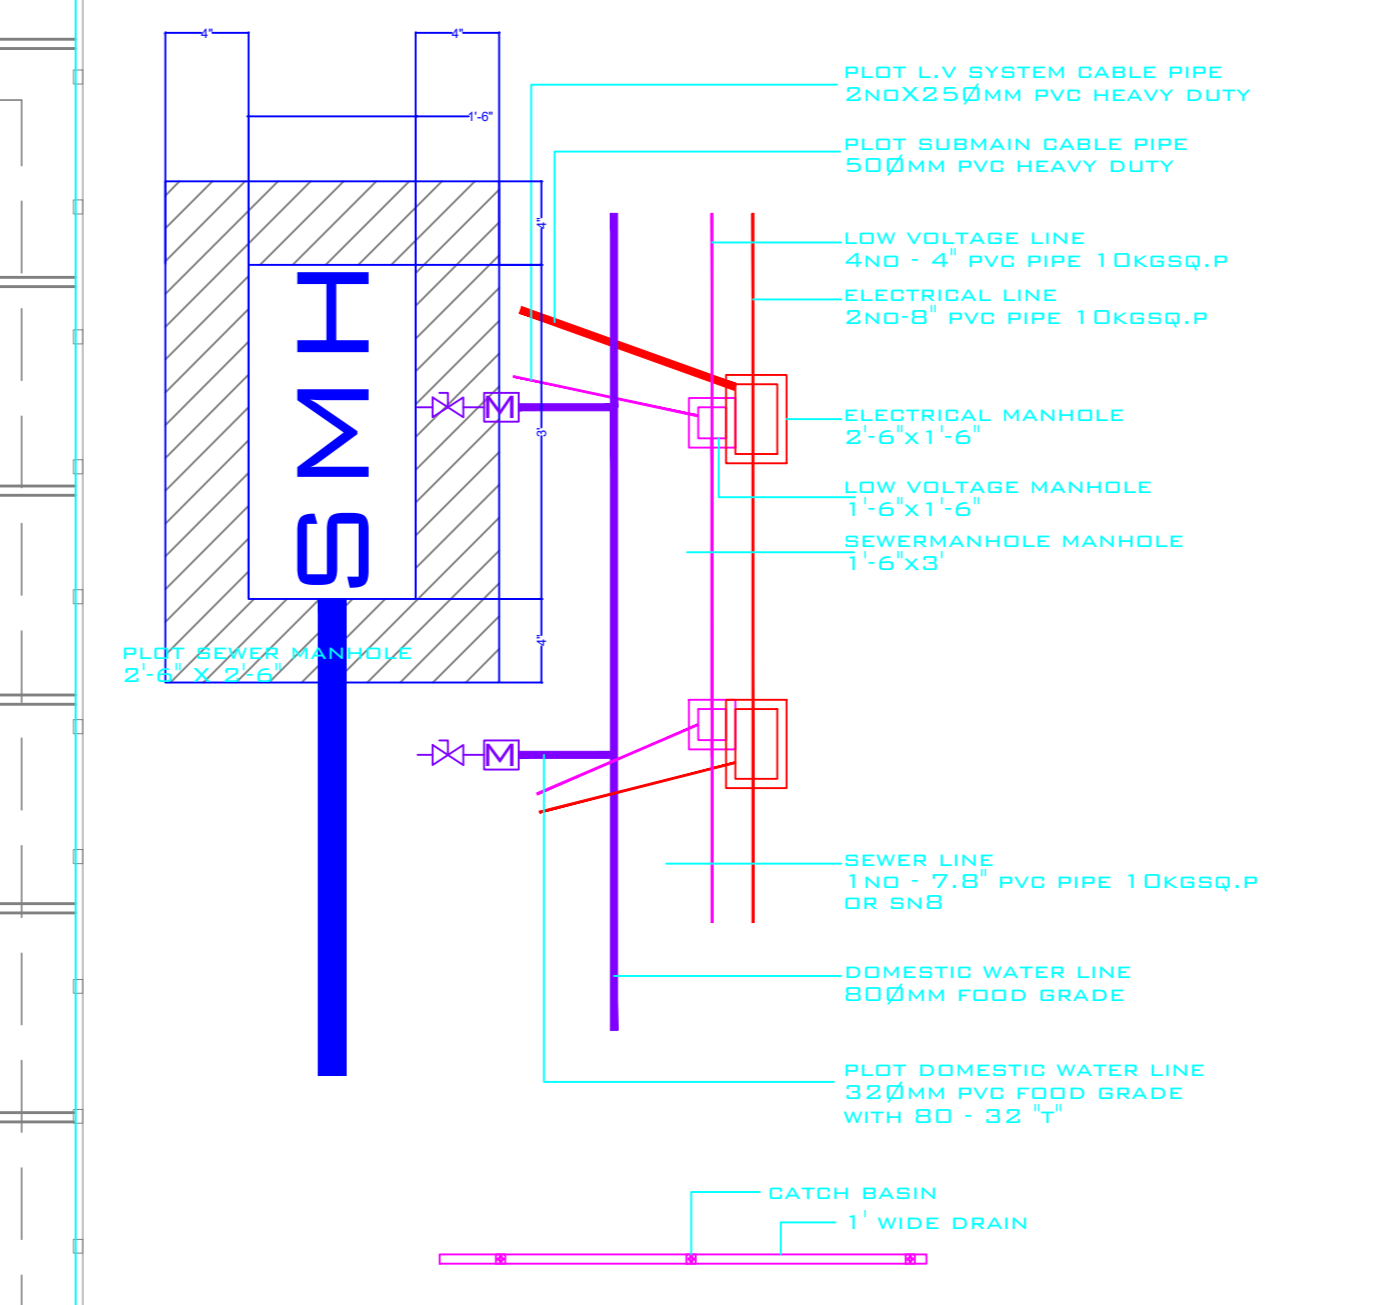

- NOTE**
1. THIS DRAWING IS THE COPYRIGHT OF THE DESIGN FIRM AND SHOULD NOT BE REPRODUCED WITHOUT THE PERMISSION OF THE ARCHITECT.
  2. DRAWINGS ARE NOT TO BE SCALED.
  3. ALL DIMENSIONS ARE IN INCHES UNLESS SPECIFIED OTHERWISE.
  4. ANY DISCREPANCIES IN THE DRAWING SHOULD BE IMMEDIATELY BROUGHT INTO THE NOTICE OF THE ARCHITECT.
  5. CONTRACTOR MUST VERIFY ALL DIMENSIONS AT SITE BEFORE COMMENCEMENT OF ANY WORK.

**ARCHITECT**  
**ASPIRE DESIGNS**  
 INTERIOR ARCHITECTURE LANDSCAPE

A-402, SANSAD VIHAR,  
 SECTOR 3, DWARKA - 110078  
 CONTACT: +91-9958767700  
 EMAIL: design.aspire@yahoo.co.in  
 des.aspire@gmail.com

**art**  
 CONSULTANTS  
**M. E. P CONSULTATION**  
 ADDRESS:- A-140, SUIT 101, SECTOR-63 NOIDA U.P. 201301  
 EMAIL:- art@artconsultantsmep.com  
 MOB :- 91-9910473339

CLIENT

PROJECT TITLE  
**PLOTTED DEVELOPMENT**

DRAWING TITLE  
**ELECTRICAL ROUTE LAYOUT**

DRAWING NUMBER  
**ART-03**

DATE  
**22-07-2024**

DEALT -----  
 SCALE  
**AS SHOWN**

