


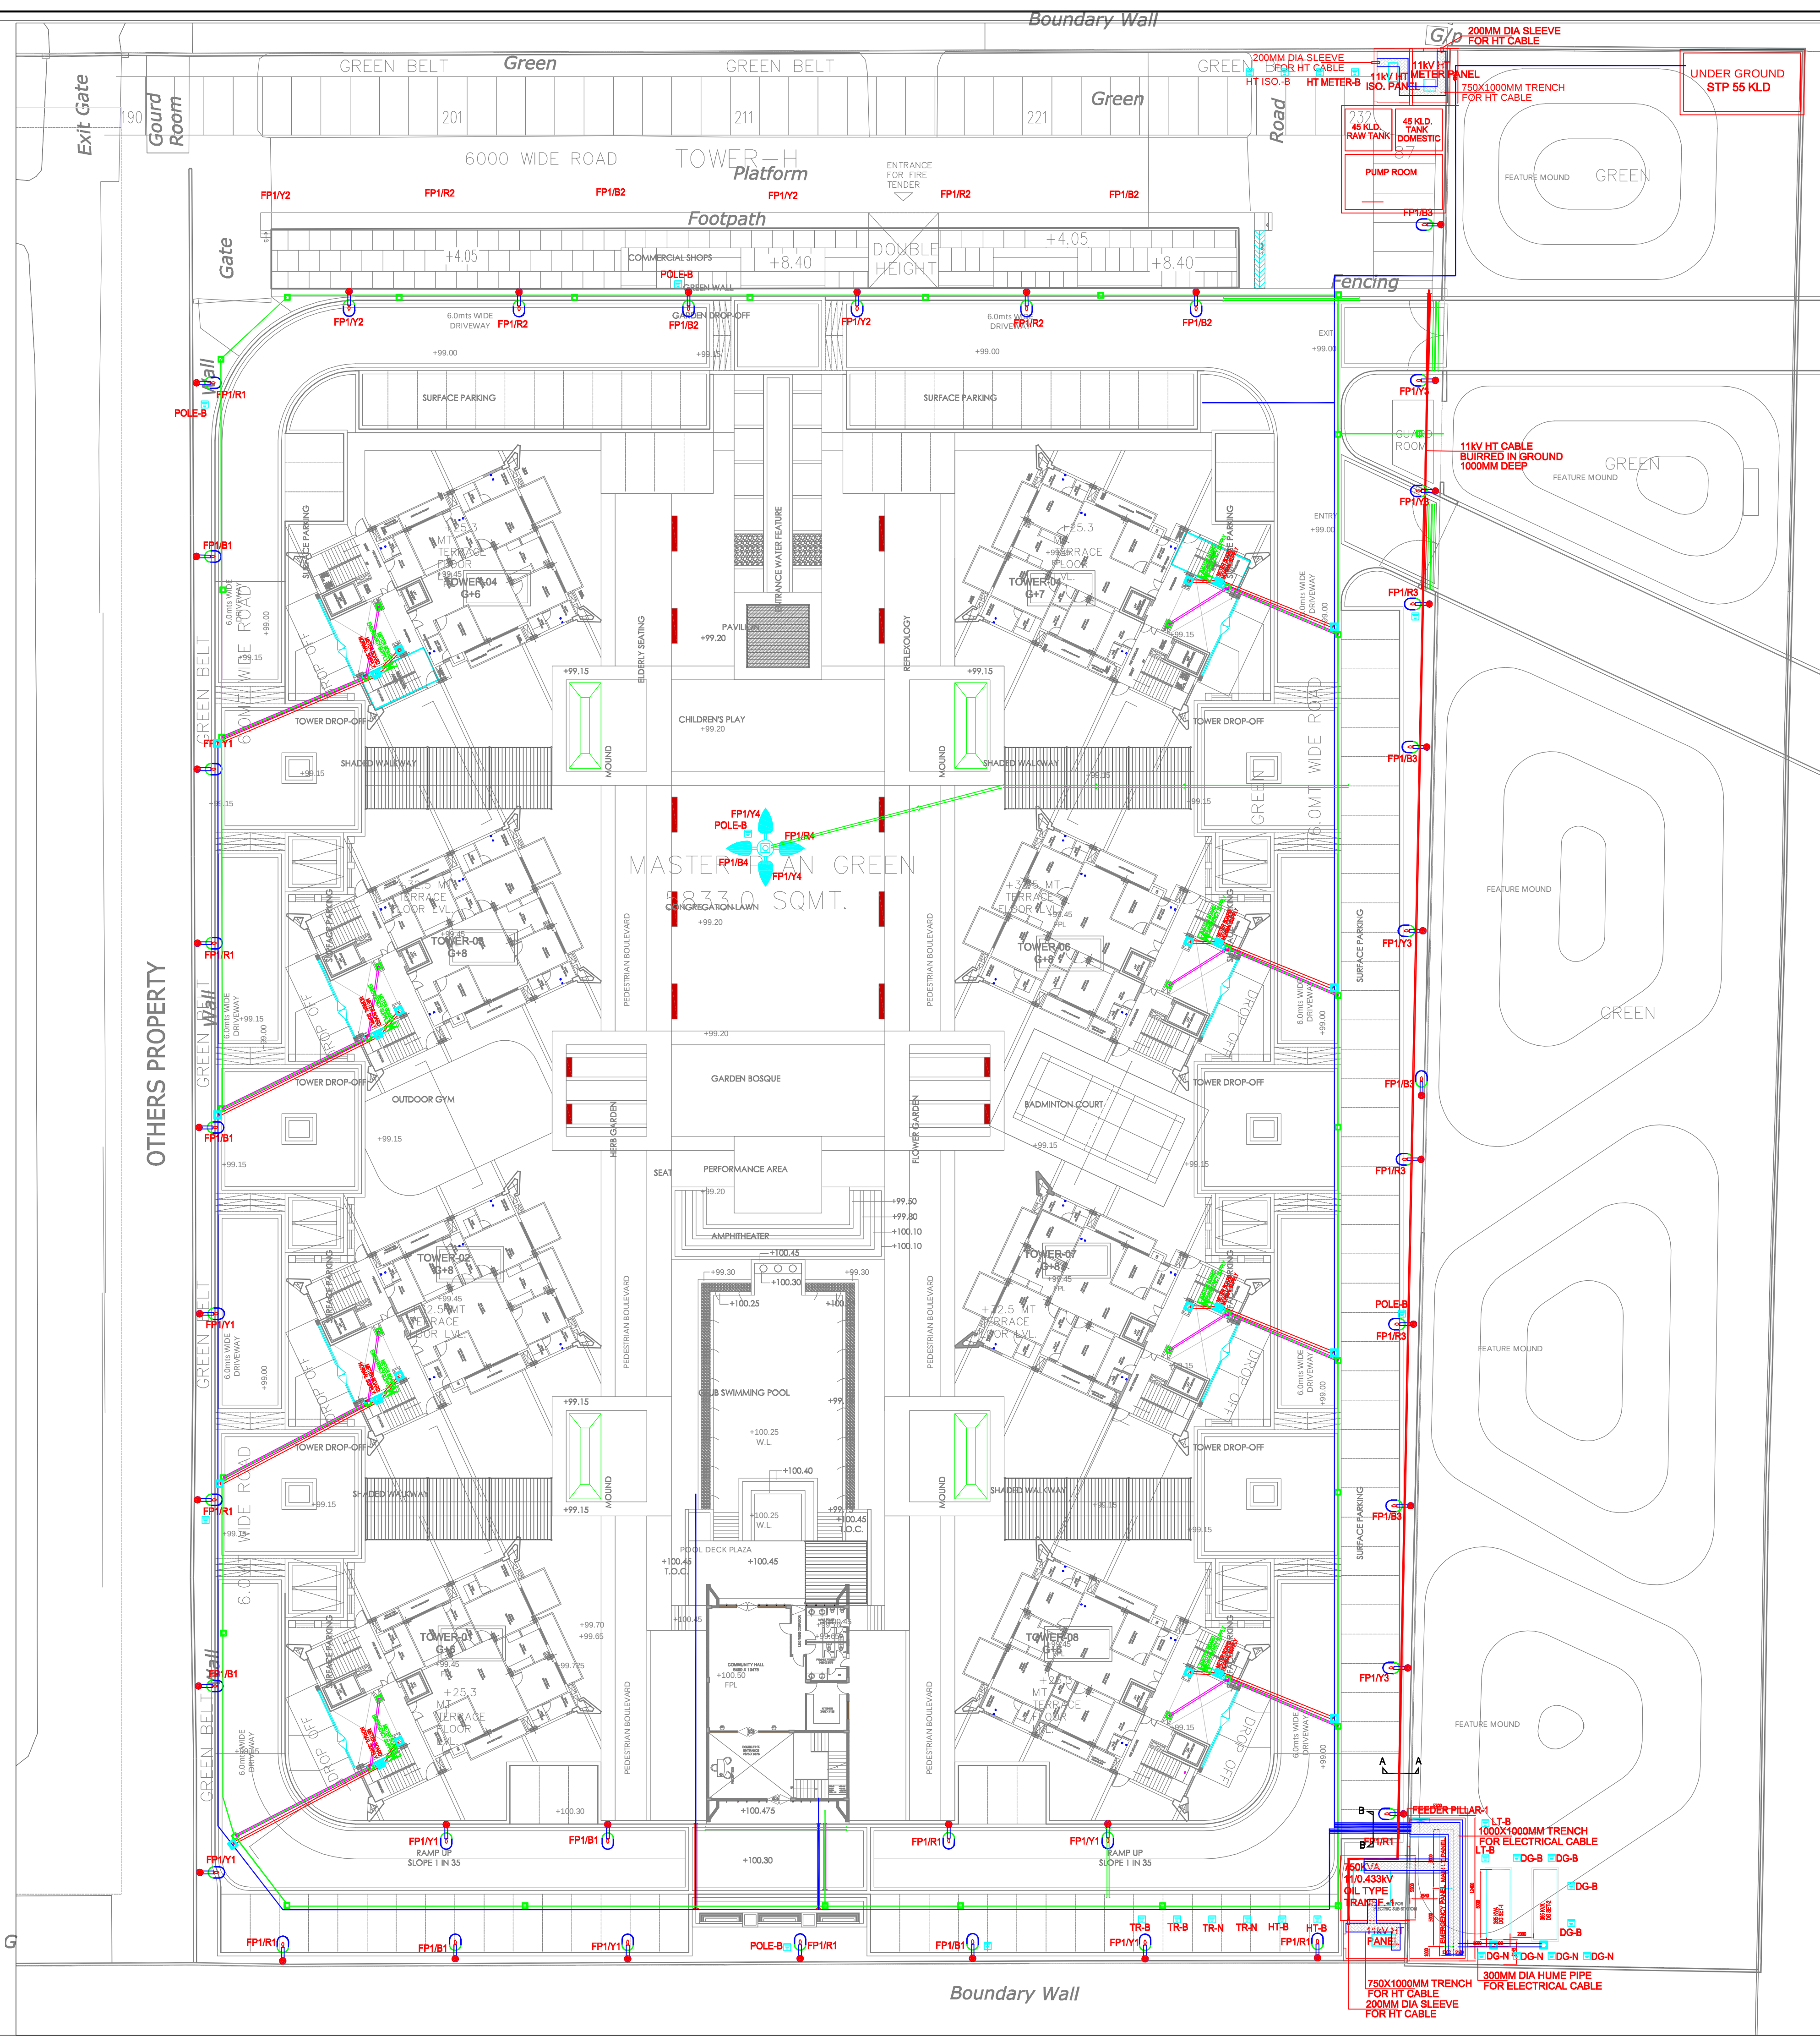

LEGEND:-	
	FEEDER PILLAR
	300/250/200mm DIA HUME PIPES FOR ELECTRICAL CABLES
	150mm DIA HUME PIPES FOR LV CABLES
	450X450MM MANHOLE FOR ELECTRICAL CABLES
	300X300MM MANHOLE FOR LV CABLES
	ELECTRICAL CABLE BURIED IN GROUND 900MM DEEP
	11kV HT CABLE BURIED IN GROUND 1000MM DEEP
	150mm DIA HDPE PIPE 500MM DEEP
	ONT
	EARTH PIT

CLIENT

M/s AGARWAL ASSOCIATES PROMOTERS LTD.
10,NEW RAJDHANI ENCLAVE,VIKAS MARG
NEW DELHI-110092

MEP CONSULTANT:

MULTIPLE SERVICE CONSULTANT

263/B, Rajpur Khurd Extension,
Chhatrapur, New Delhi-110068,
Ph. no.-8820225677/8920228058
mscgoe@gmail.com

PROJECT- SUBMISSION DRAWINGS FOR

GROUP HOUSING AT PLOT NO GH-1
ADITYA WORLD CITY, INTEGRATED TOWNSHIP,
SHAHUPUR-BAMHETA,GAZIABAD, (U.P.)
KHASRA NO=1910,1911,1912/2m,1912/1m,1915,
1916,1917,1918,1919,1920,1921,1922,
1930,1938,2285,2286m,2286m,2287
2288,2289,2295

SHEET TITLE

SITE PLAN
ELECTRICAL LAYOUT

DEALT

SCALE

DRG. NO

CHECKED

DATE

MSC/AWGT/ESP/EL-01

ARCHITECT

DESIGN FORUM INTERNATIONAL

K-47 , KAILASH COLONY, NEW DELHI-110048
PH. NO:-011-46556600, FAX:-011-46556601
www.designforuminternational.com.