
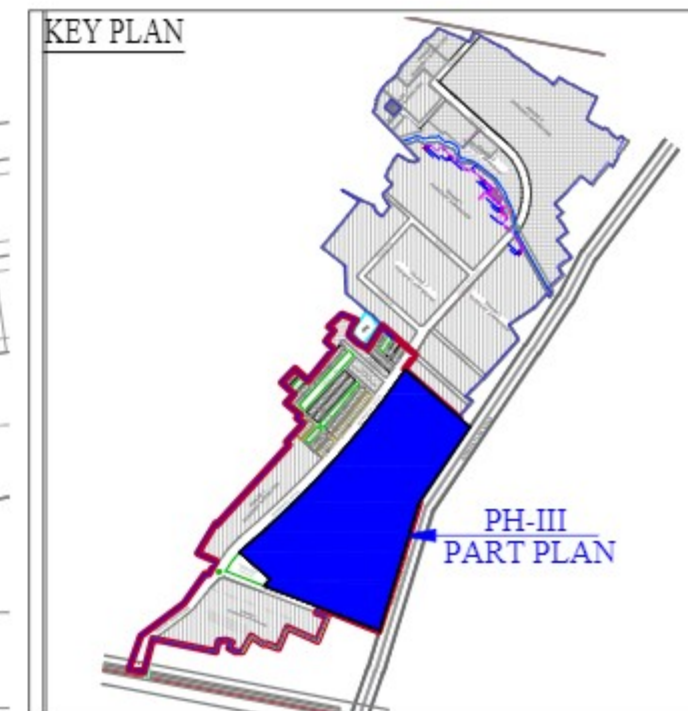


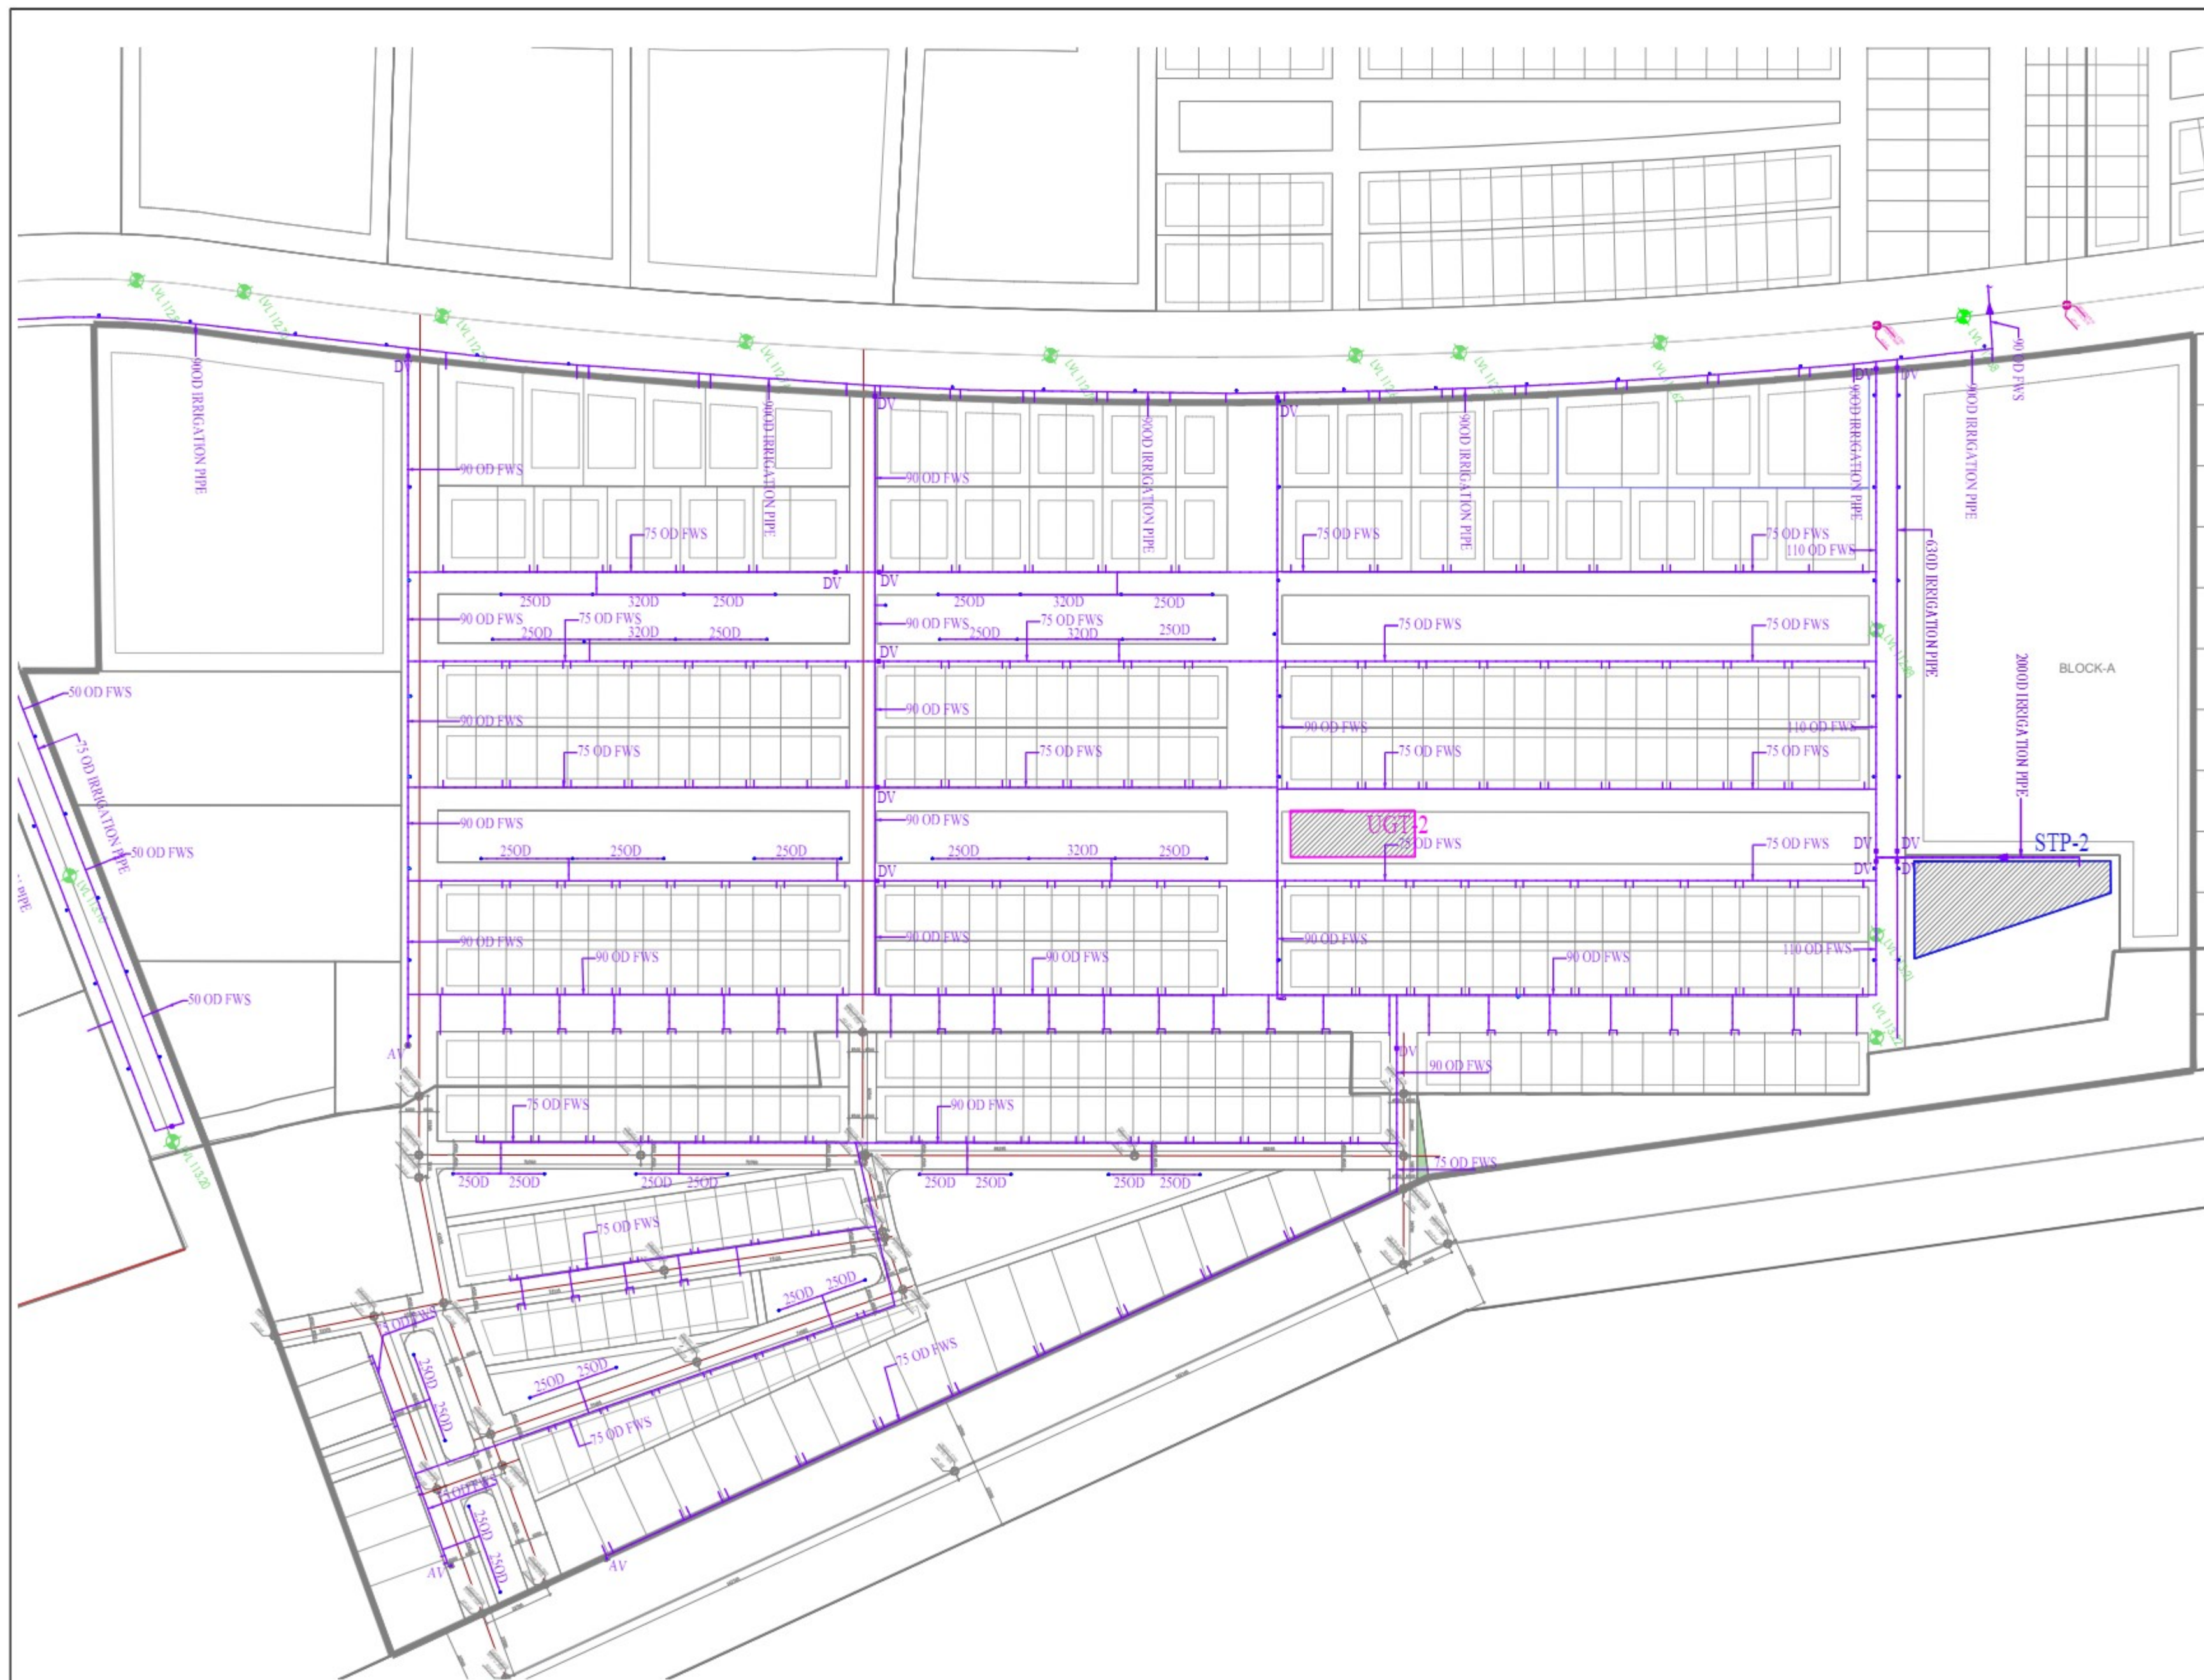

PLUMBING LEGEND:-

	IRRIGATION WATER SUPPLY LINE FROM STP-2
	GARDEN HYDRANT
	AIR VALVE
	DRAIN VALVE

SUBMISSION DRAWING

PROJECT :
PARK CITY
AN INTEGRATED TOWNSHIP
AT SULTANPUR ROAD,LUCKNOW.

BUILDING MEP CONSULTANT :
VIZICON
FLAT NO.-14/34 YAMAN
SAHARA STAES LUCKNOW
triveniconsultants.lko@gmail.com

ARCHITECT PLANNER
AR . TRIPTIE AWASTHI

CLIENT:-
PINTAIL
Regd Office:-
705-708, 7th Floor,
Eideco Corporate Tower
Viharhi Khana Gomti Nagar,
Lucknow-226010

PLUMBING AND FIRE SUPPRESSION CONSULTANT :
 C P Vidya and Associates
312A, UNITECH ARCADIA, SOUTH CITY-II,
SECTOR-49, NEAR PARK HOSPITAL(GURGAON)
Haryana-122018 (INDIA)
Email :- cpvidyaassociates@gmail.com


NORTH:-

DEALT BY:-
ASHISH
SCALE:-
1:1500@A2

CHECKED:-
VINEETH
DATE:-
11 MAY 2023

DRAWING TITLE:-
PH-III PART PLAN
FLUSHING/IRRIGATION
SUPPLY SCHEME LAYOUT
DRAWING NO:-
PL/P3-PP/FWS/02
REV. NO.
R0

 
REVISIONS			
REV	DATE	DESCRIPTION	
R0	23.05.2023	FOR SUBMISSION	

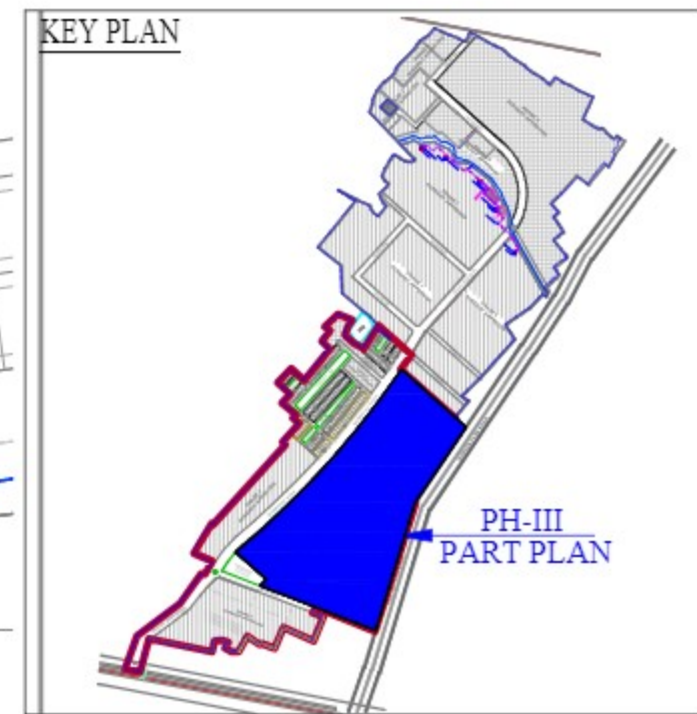


PLUMBING LEGEND:-


	STORM WATER LINE
	DRAINAGE MANHOLE
	RAIN WATER HARVESTING PIT

SUBMISSION DRAWING

PROJECT : PARK CITY AN INTEGRATED TOWNSHIP AT SULTANPUR ROAD,LUCKNOW.	BUILDING MEP CONSULTANT : VIZICON FLAT NO.-14/34 YAMAN SAHARA STAES LUCKNOW triveniconsultants.lko@gmail.com	ARCHITECT PLANNER AR . TRIPTIE AWASTHI	CLIENT:- PINTAIL Regd Office:- 705-706, 7th Floor, Edeco Corporate Tower Viharini Khana Gomti Nagar, Lucknow-226010	PLUMBING AND FIRE SUPPRESSION CONSULTANT : CPA C P Vidya and Associates 312A, UNITECH ARCADIA, SOUTH CITY-II, SECTOR-49, NEAR PARK HOSPITAL(GURGAON) Haryana-122018 (INDIA) Email :- cpvidyaassociates@gmail.com	NORTH:- 	DEALT BY:- ASHISH	CHECKED:- VINEETH	DRAWING TITLE:- PH-III PART PLAN STORM WATER SCHEME LAYOUT		REVISIONS <table><tr><th>REV</th><th>DATE</th><th>DESCRIPTION</th><th></th><th></th></tr><tr><td>R0</td><td>23.05.2023</td><td>FOR SUBMISSION</td><td></td><td></td></tr><tr><td></td><td></td><td></td><td></td><td></td></tr><tr><td></td><td></td><td></td><td></td><td></td></tr><tr><td></td><td></td><td></td><td></td><td></td></tr><tr><td></td><td></td><td></td><td></td><td></td></tr></table>				REV	DATE	DESCRIPTION			R0	23.05.2023	FOR SUBMISSION																						
						REV	DATE	DESCRIPTION																																			
						R0	23.05.2023	FOR SUBMISSION																																			
SCALE:- 1:1500@A2	DATE:- 11 MAY 2023	DRAWING NO:- PL/P3-PP/ST/04	REV. NO. R0																																								

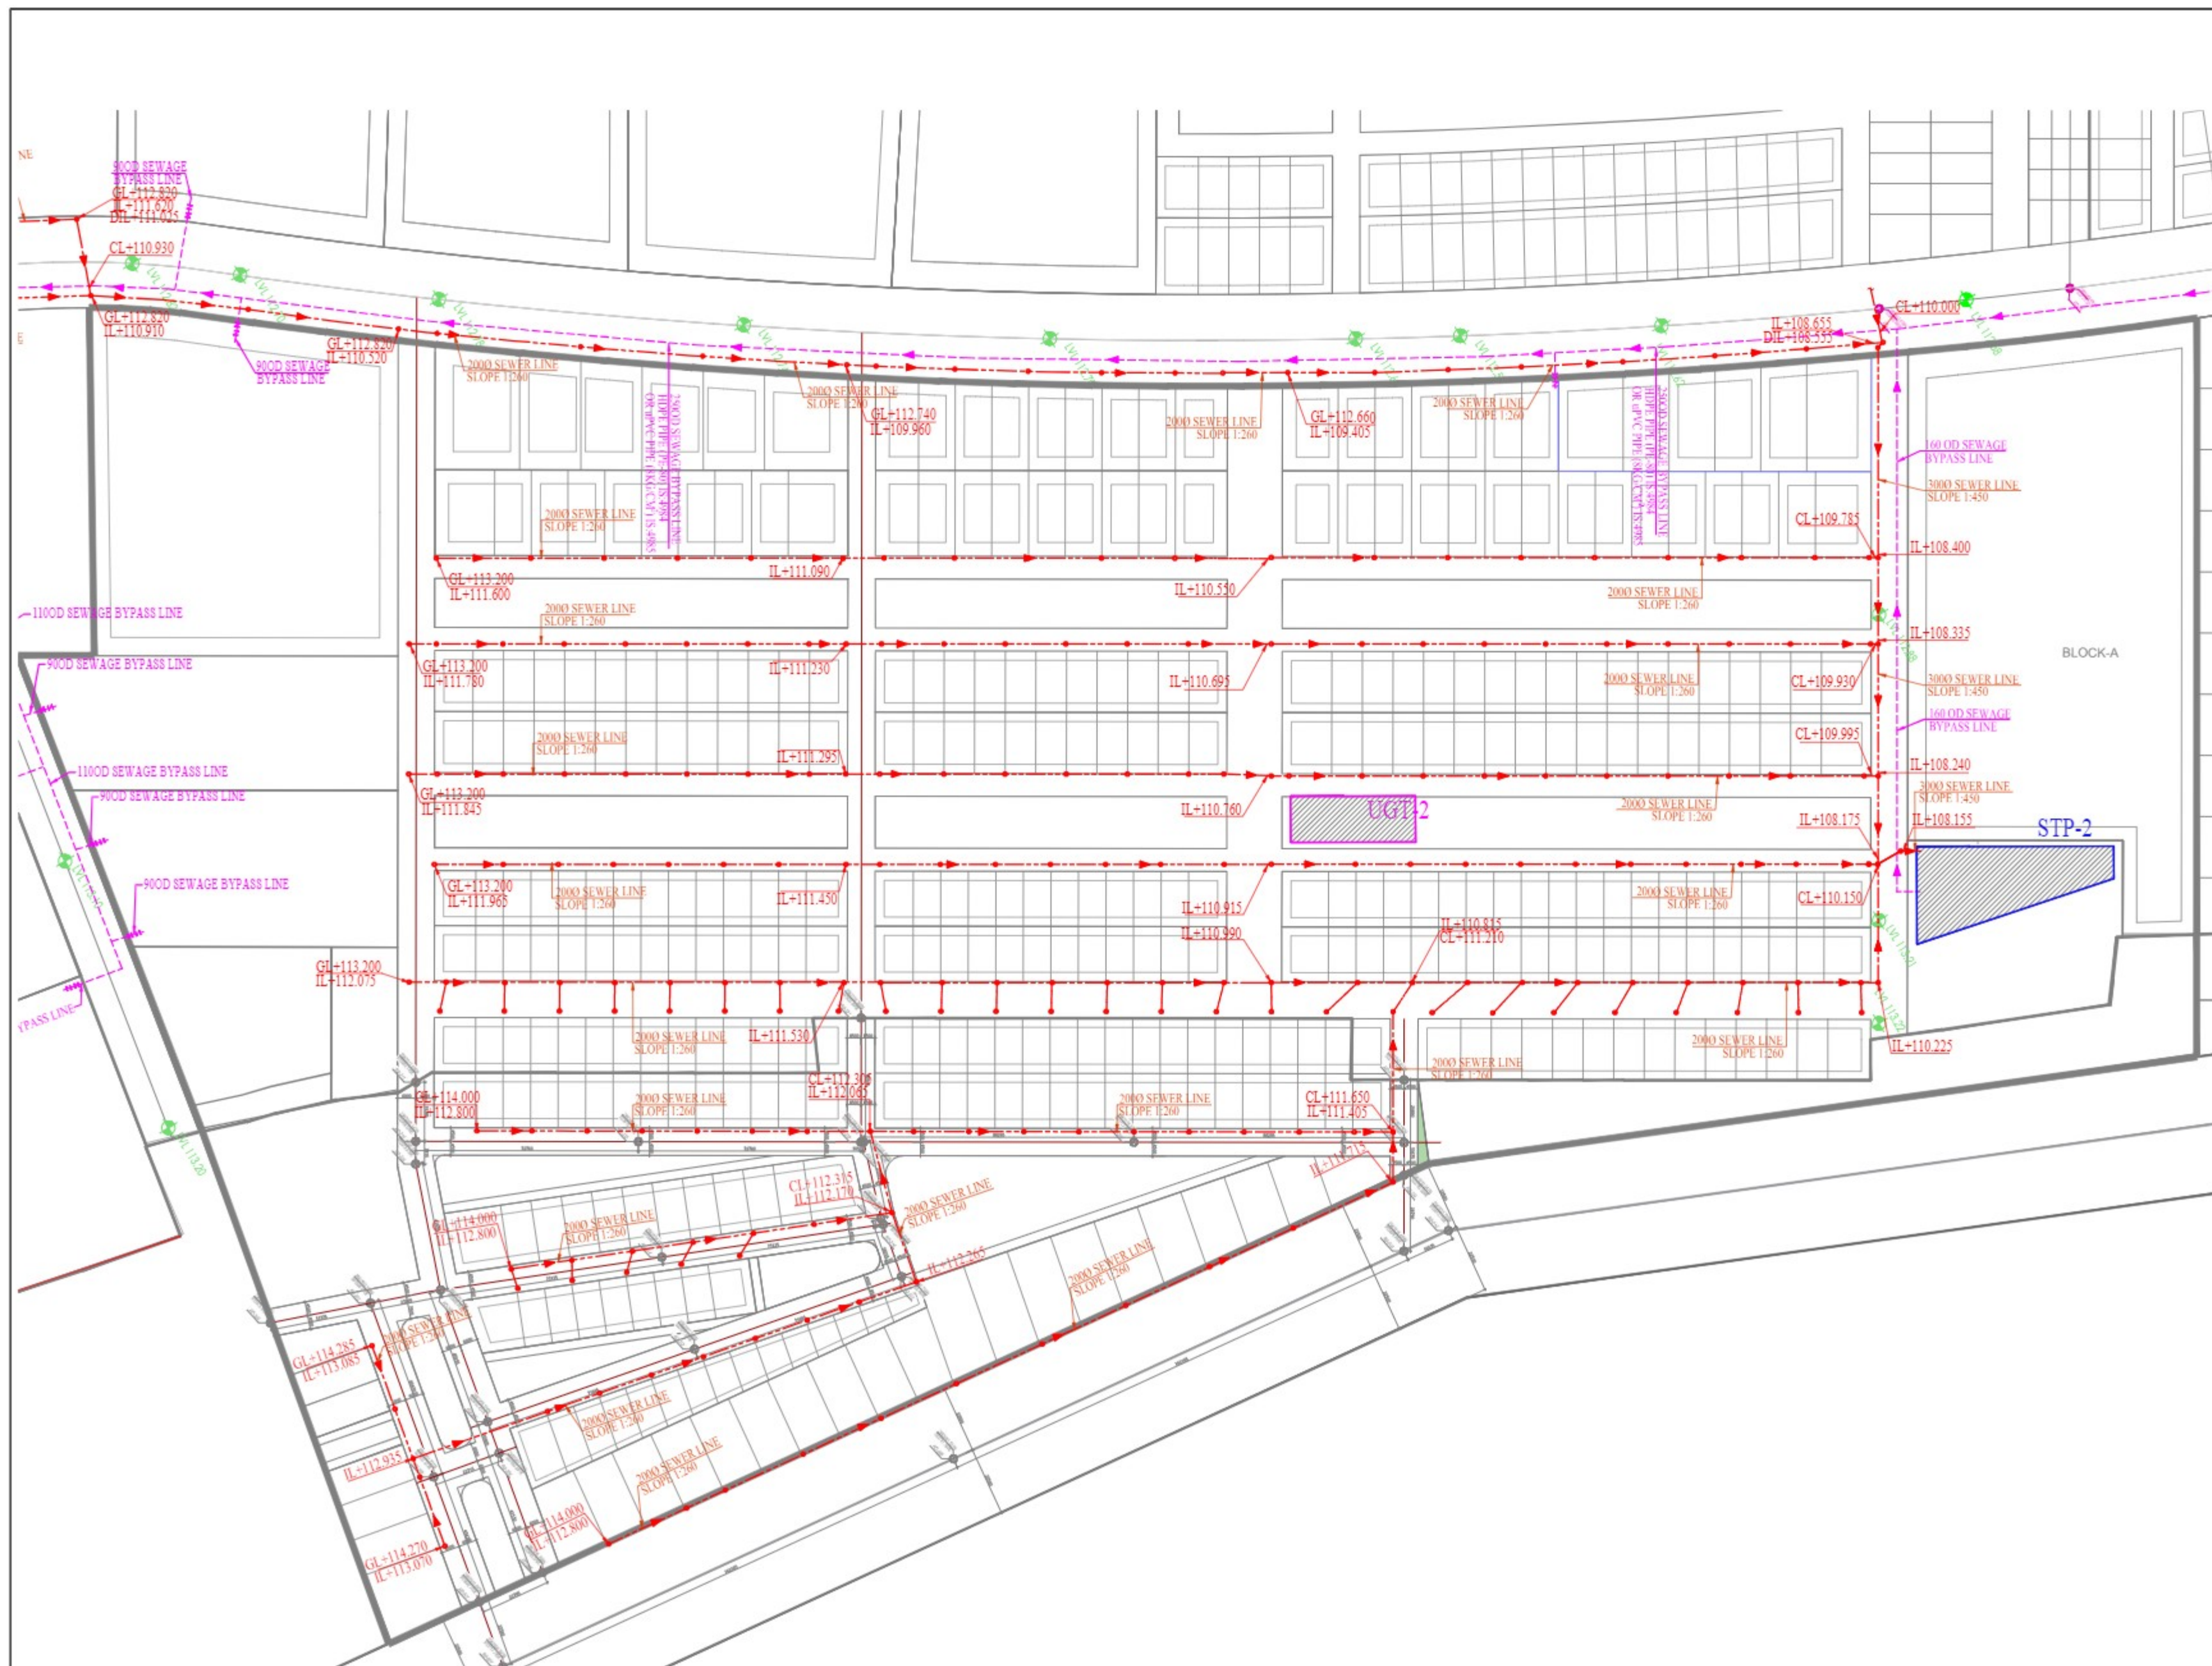

KEY PLAN

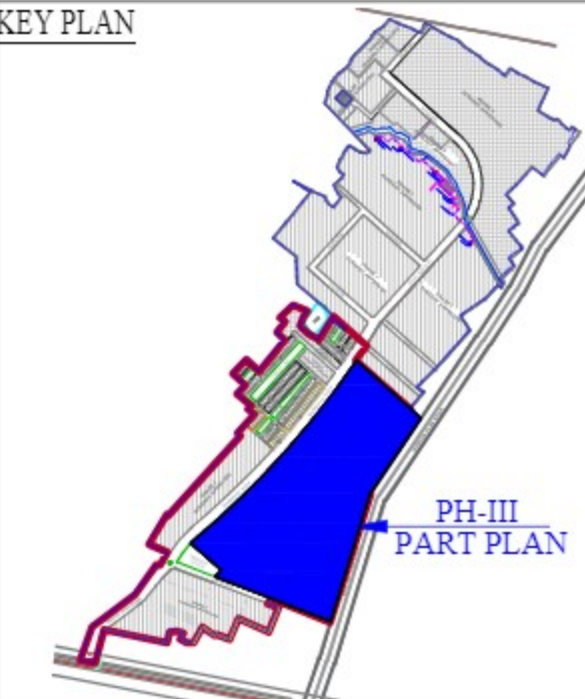

PLUMBING LEGEND:-

	SEWERAGE LINE
	SEWERAGE BYPASS LINE
	SEWER MANHOLE

SUBMISSION DRAWING

PROJECT:
PARK CITY
AN INTEGRATED TOWNSHIP
AT SULTANPUR ROAD,LUCKNOW.

BUILDING MEP CONSULTANT :
VIZICON
FLAT NO.-14/34 YAMAN
SAHARA STAES LUCKNOW
triveniconsultants.lko@gmail.com

ARCHITECT PLANNER
AR. TRIPTIE AWASTHI

CLIENT:-
PINTAIL
Regd Office:-
705-708, 7th Floor,
Eideco Corporate Tower
Viharuti Khana Gamti Nagar,
Lucknow-226010

PLUMBING AND FIRE SUPPRESSION CONSULTANT :
CPA C P Vidya and Associates
312A, UNITECH ARCADIA, SOUTH CITY-II,
SECTOR-49, NEAR PARK HOSPITAL(GURGAON)
Haryana-122018 (INDIA)
Email :- cpvidyaassociates@gmail.com



DEALT BY:-
ASHISH
SCALE:-
1:1500@A2

CHECKED:-
VINEETH
DATE:-
11 MAY 2023

DRAWING TITLE:-
PH-III PART PLAN
SEWERAGE SCHEME
LAYOUT

DRAWING NO:-
PL/P3-PP/SW/03
REV. NO.
R0

REVISIONS			
REV	DATE	DESCRIPTION	
R0	23.05.2023	FOR SUBMISSION	