


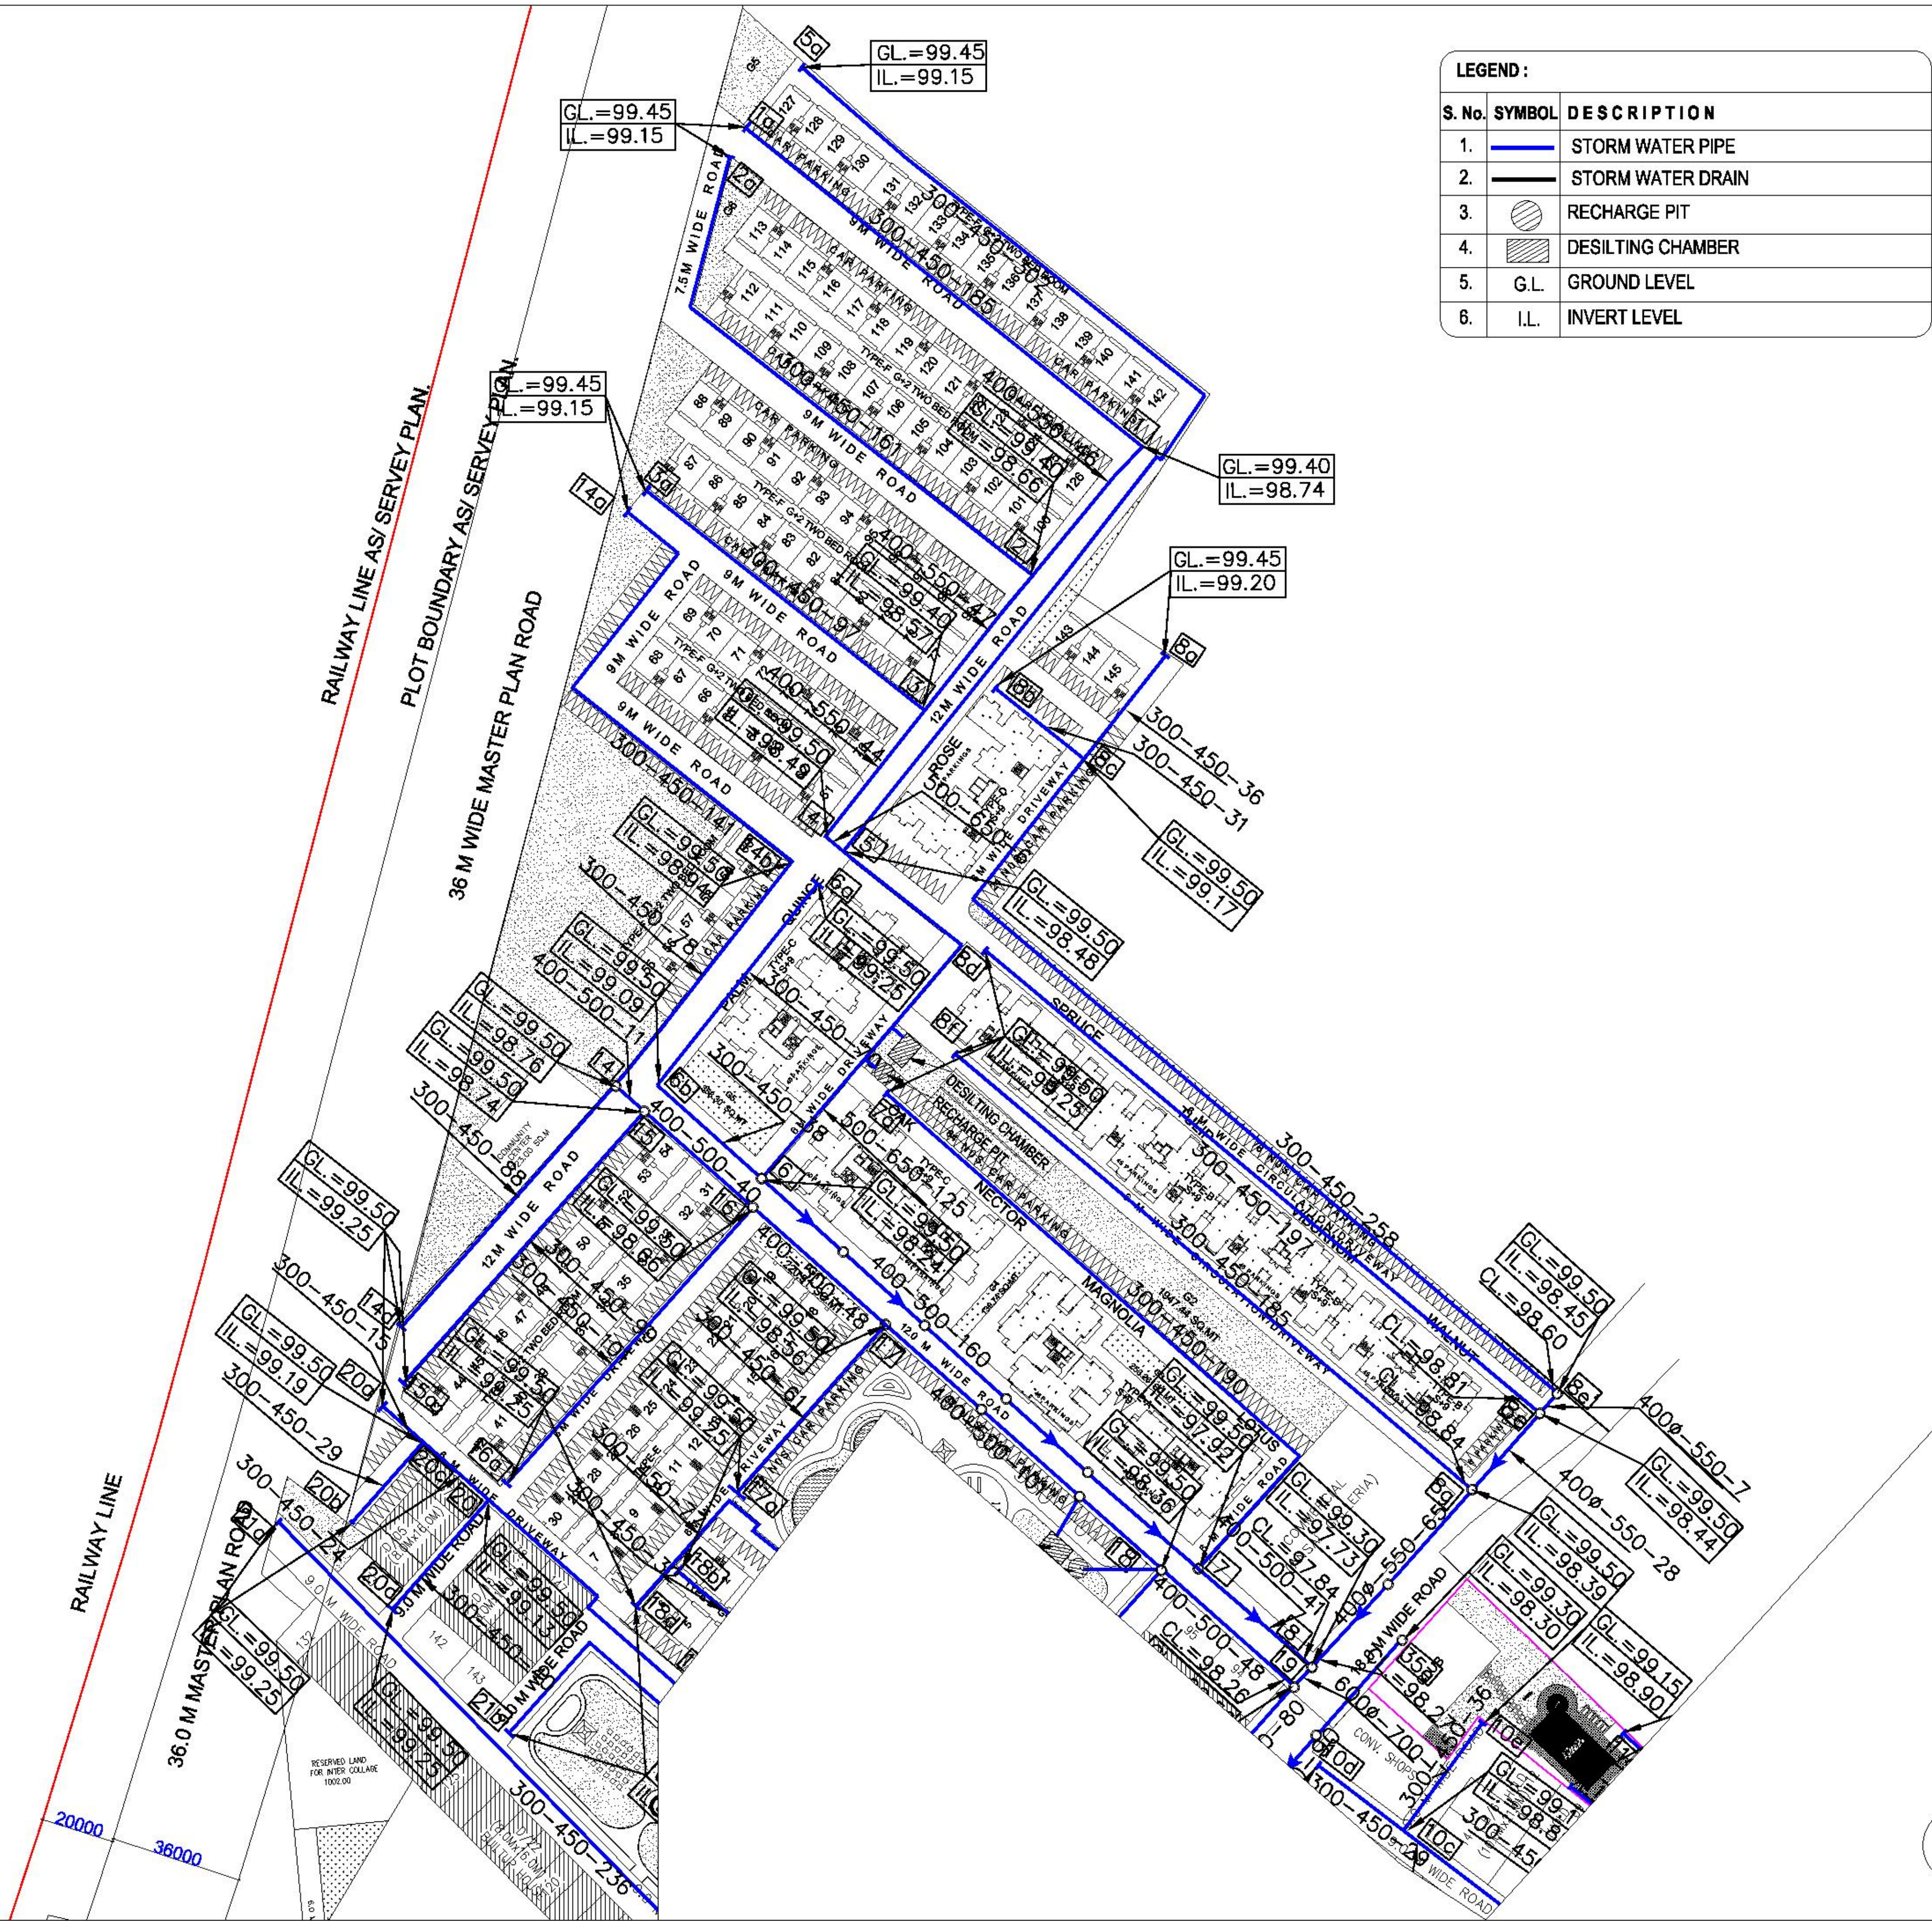

WIDTH-SLOPE-LENGTH		
IN MM.	IN MM.	IN M.

PIPE DIA -SLOPE- LENGTH		
IN MM.	IN MM.	IN M.

S.N.	REVL	DATE	DESCRIPTION	
PROJECT				
PROPOSED RESIDENTIAL COLONY AT ANSAL TOWN MEERUT. (PHASE-3)				
TITLE				
PHASE-3 EXTERNAL STORM WATER DRAINAGE LAYOUT				
DEALT BY.		DATE	B4	
P.K.		25.05.2010		
CHECKED BY.		SCALE	1:1000	
M.K.				
DRG NO.				
SERV/1052/MEERUT.AT/PART PH-3/S/03				
MANOJ KUMAR DESIGN ENGINEER (SERVICES)		ADITYA KUMAR GUPTA SR. G.M (SERVICES)		
ANSAL HOUSING & CONSTRUCTION LTD. 15, UGF INDRA PRAKASH 21 BARAKHAMBA ROAD NEW DELHI - 110 001				