

THIS DRAWING IS CONFIDENTIAL AND SHOULD NOT BE
DISCLOSED, COPIED OR LENT TO A THIRD PARTY WITHOUT
WRITTEN CONSENT OF SKYLINE ARCHITECTURAL CONSULTANTS
EXCEPT THE SYSTEM FOR WHICH THE DRAWING IS MEANT.

DO NOT SCALE DRAWING ONLY WRITTEN DIMENSIONS ARE TO BE FOLLOWED

CLIENT	LUCKNOW DEVELOPMENT AUTHORITY
PROJECT	THE AIRSBACH SQUARE AT MILL ROAD LUCKNOW

SKYLINE
INFRAWORLD PVT. LTD.

INTEGRATED PAPER, LTD.



OFFICE : 3rd FLOOR, LAXMI VARDAN COMMERCIAL
COMPLEX AT PATRAKARPIRAM CROSSING,
GOMTINAGAR, LUCKNOW, U.P. INDIA

PHONE : 0522-23641/23 23631/23 4041/23 fax 0522-23631/25


E-MAIL : kv.vine@skvinedworld.in

EMAIL : skysinh@skysineworld.in
ARCHITECT : SANJAY & VIJAY SINHA

TITLE	SCALE	DATE
ESS & EXTERNAL STREET LIGHT DRAWING	PHOTO	08-05-2025
	CHNO BP	08-05-2025
	AS VISIT	08-05-2025
	APPRO BP	08-05-2025
DRAWING NO.	REV.	
SHEET NO.	R0	

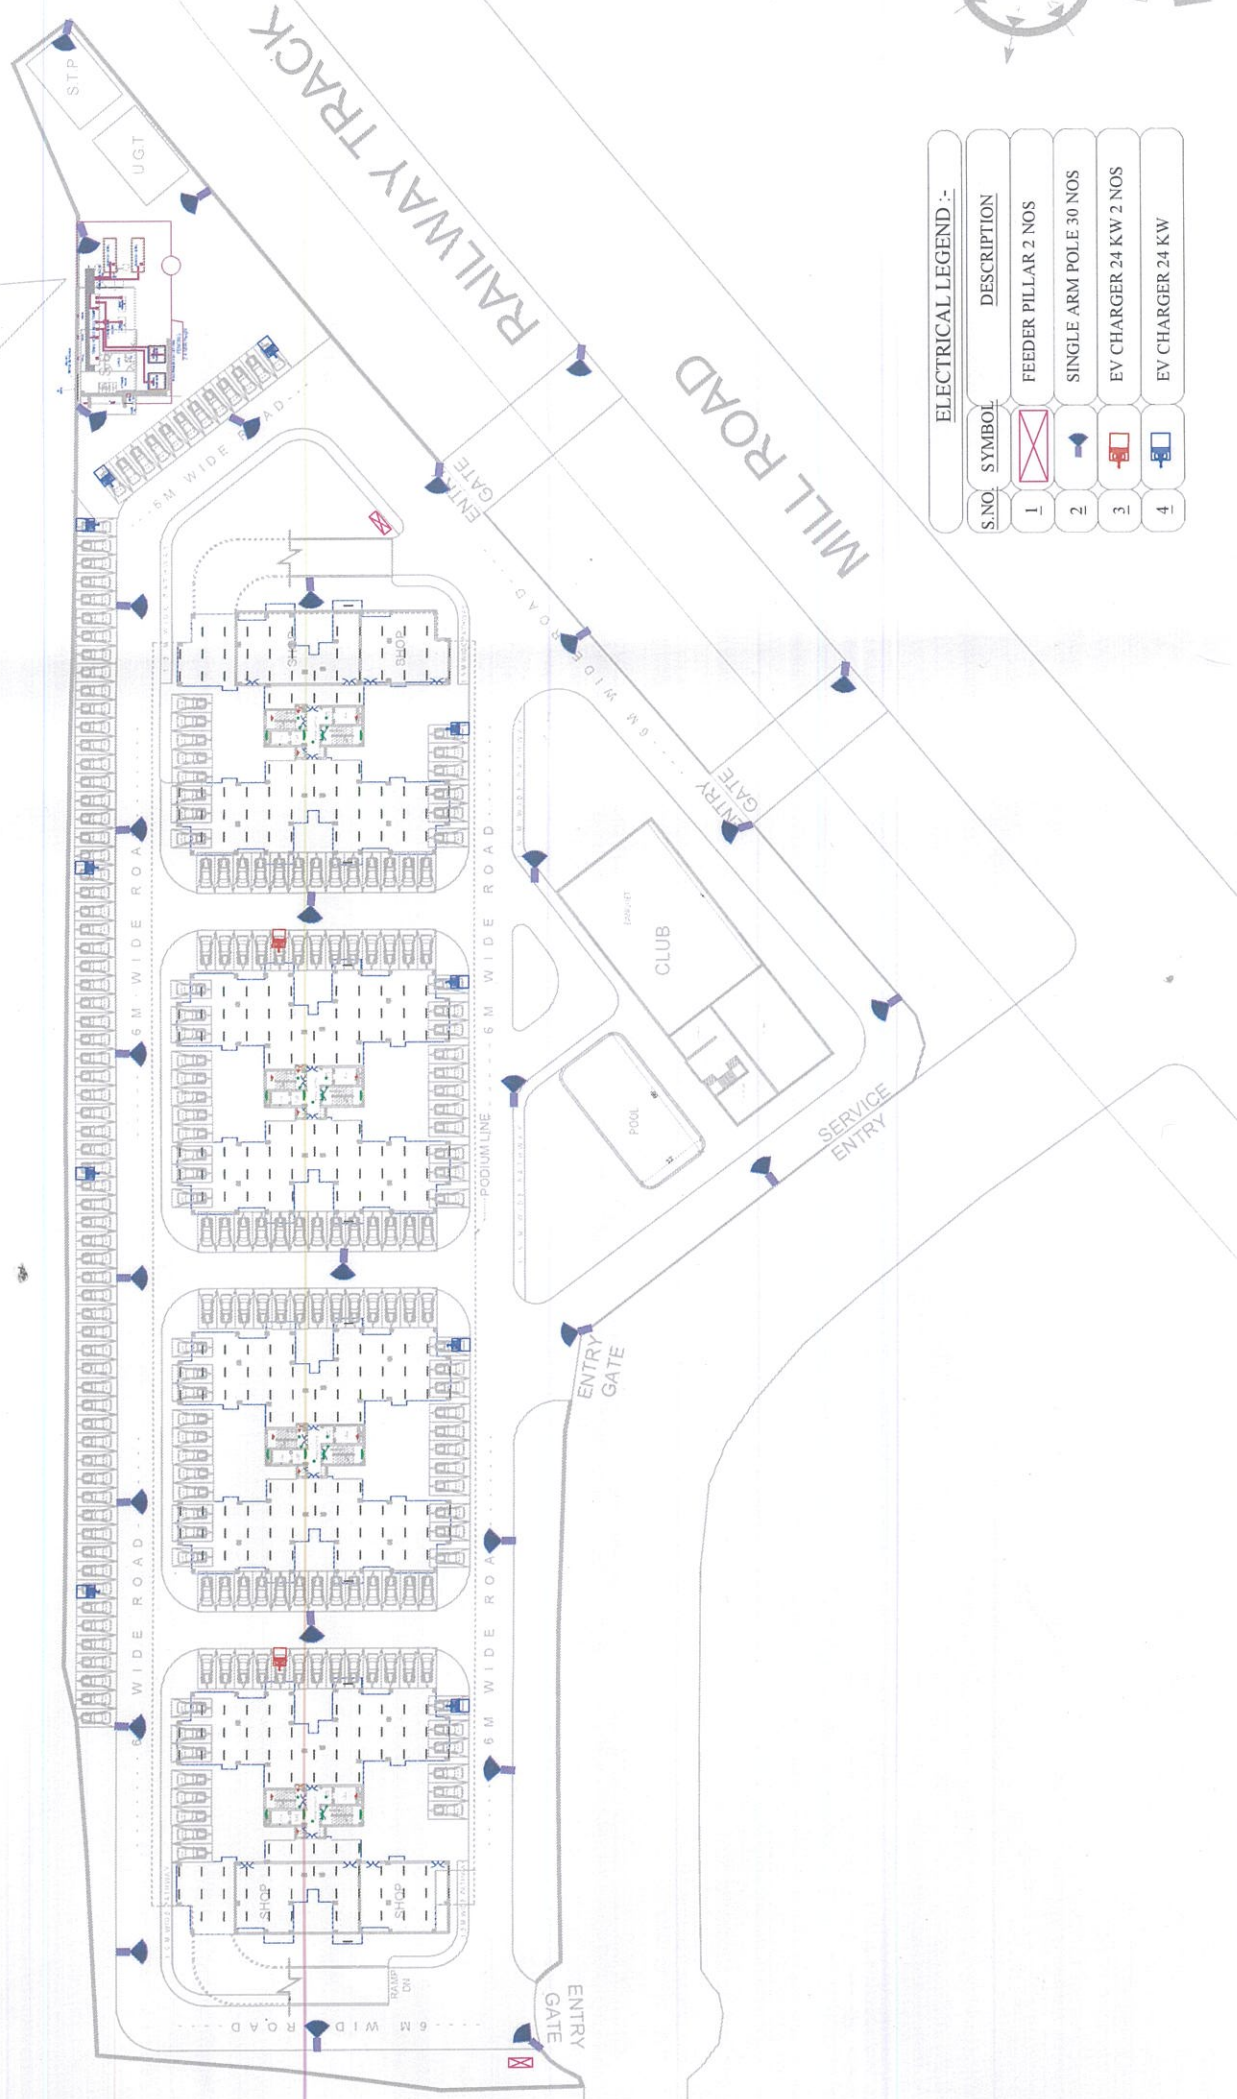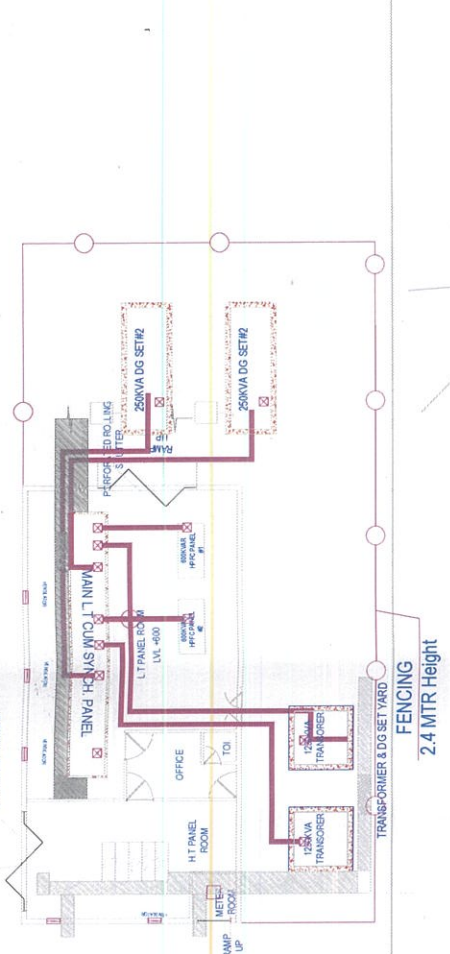

ELECTRICAL LEGEND :-		
S.NO.	SYMBOL	DESCRIPTION
1		FEEDER PILLAR 2 NOS
2		SINGLE ARM POLE 30 NOS
3		EV CHARGER 24 KW 2 NOS
4		EV CHARGER 24 KW

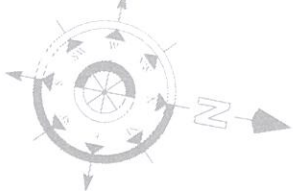

Nishal
अधिशासी अभियन्ता
नावनंद दिवाण प्रभिकरण