


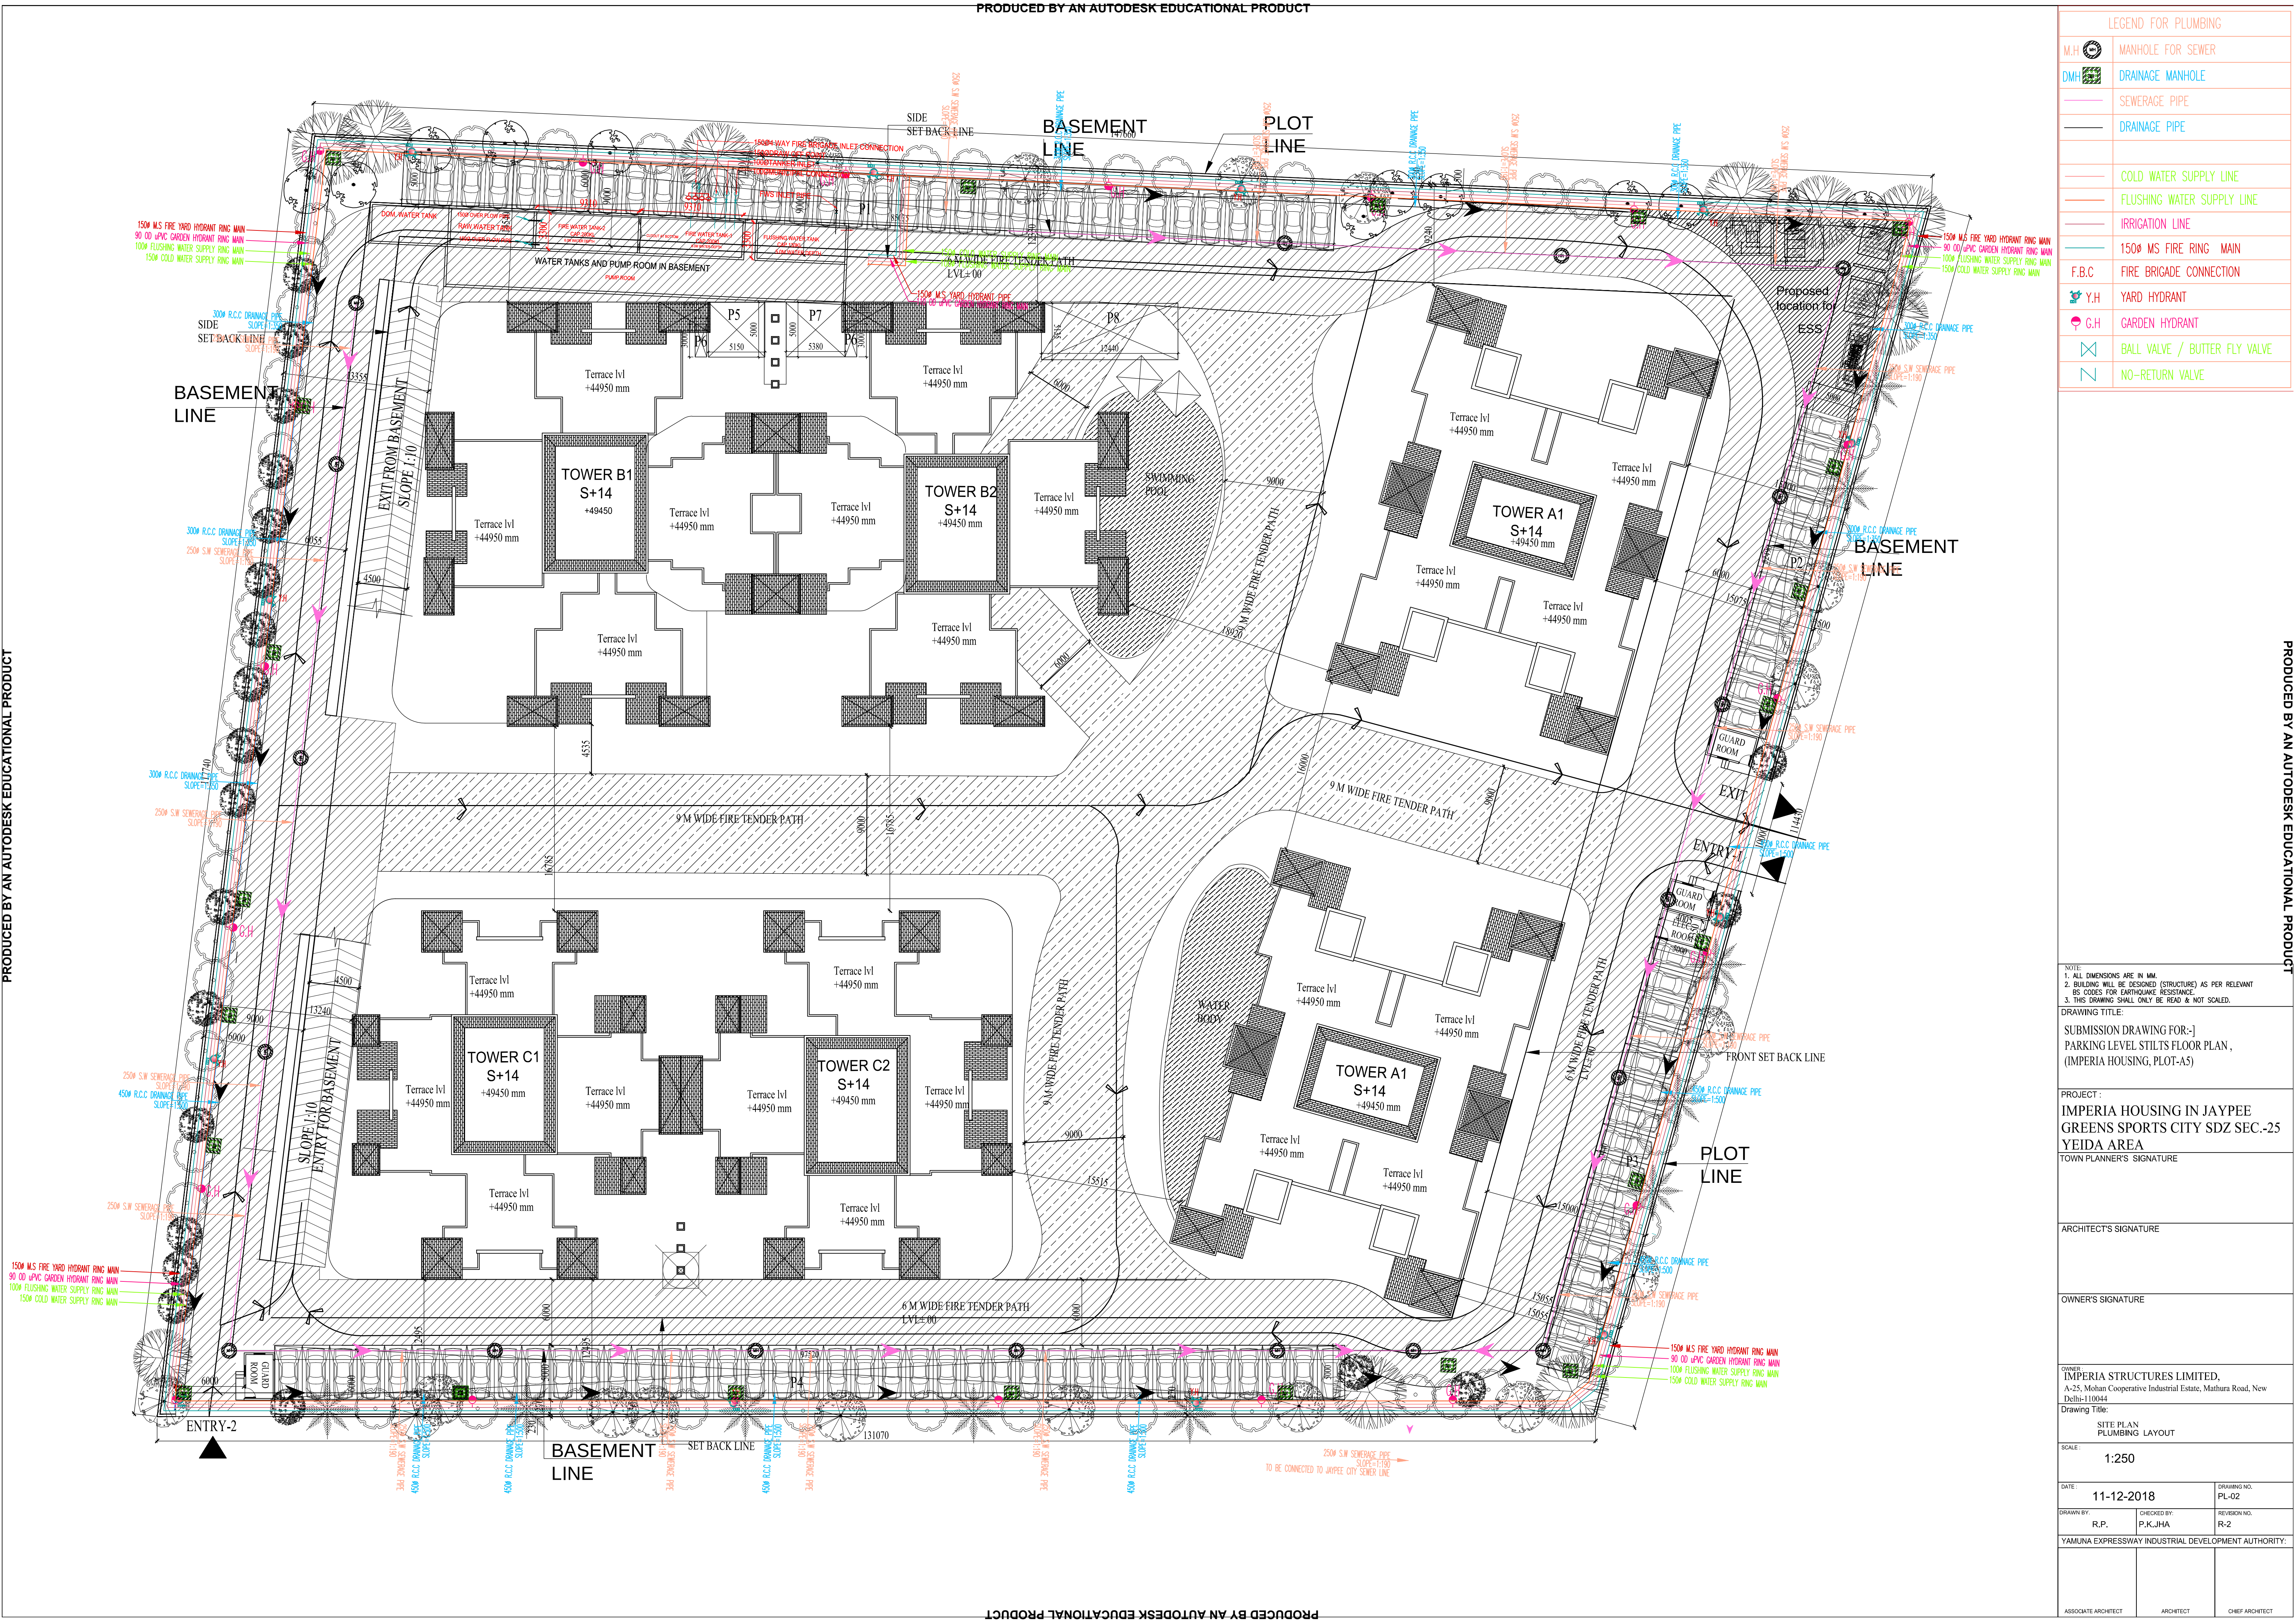

PRODUCED BY AN AUTODESK EDUCATIONAL PRODUCT

PRODUCED BY AN AUTODESK EDUCATIONAL PRODUCT

LEGEND FOR PLUMBING	
M.F.	MANHOLE FOR SEWER
DMF	DRAINAGE MANHOLE
	SEWERAGE PIPE
	DRAINAGE PIPE
	COLD WATER SUPPLY LINE
	FLUSHING WATER SUPPLY LINE
	IRRIGATION LINE
	1500 MS FIRE RING MAIN
F.B.C	FIRE BRIGADE CONNECTION
Y.H	YARD HYDRANT
G.H	GARDEN HYDRANT
	BALL VALVE / BUTTER FLY VALVE
	NO-RETURN VALVE

NOTE: 1. ALL DIMENSIONS ARE IN MM. 2. BUILDING WILL BE DESIGNED (STRUCTURE) AS PER RELEVANT IS CODES FOR EARTHQUAKE RESISTANCE. 3. THIS DRAWING SHALL ONLY BE READ & NOT SCALED.	
DRAWING TITLE: SUBMISSION DRAWING FOR:- PARKING LEVEL STILTS FLOOR PLAN, (IMPERIA HOUSING, PLOT-A5)	
PROJECT : IMPERIA HOUSING IN JAYPEE GREENS SPORTS CITY SDZ SEC.-25 YEIDA AREA TOWN PLANNER'S SIGNATURE	
ARCHITECT'S SIGNATURE	
OWNER'S SIGNATURE	
OWNER: IMPERIA STRUCTURES LIMITED, A-25, Mohan Cooperative Industrial Estate, Mathura Road, New Delhi-110044 Drawing Title: SITE PLAN PLUMBING LAYOUT SCALE: 1:250	
DATE: 11-12-2018	DRAWING NO. PL-02
DRAWN BY: R.P.	CHECKED BY: P.K.JHA
YAMUNA EXPRESSWAY INDUSTRIAL DEVELOPMENT AUTHORITY:	
ASSOCIATE ARCHITECT	ARCHITECT
	CHIEF ARCHITECT