


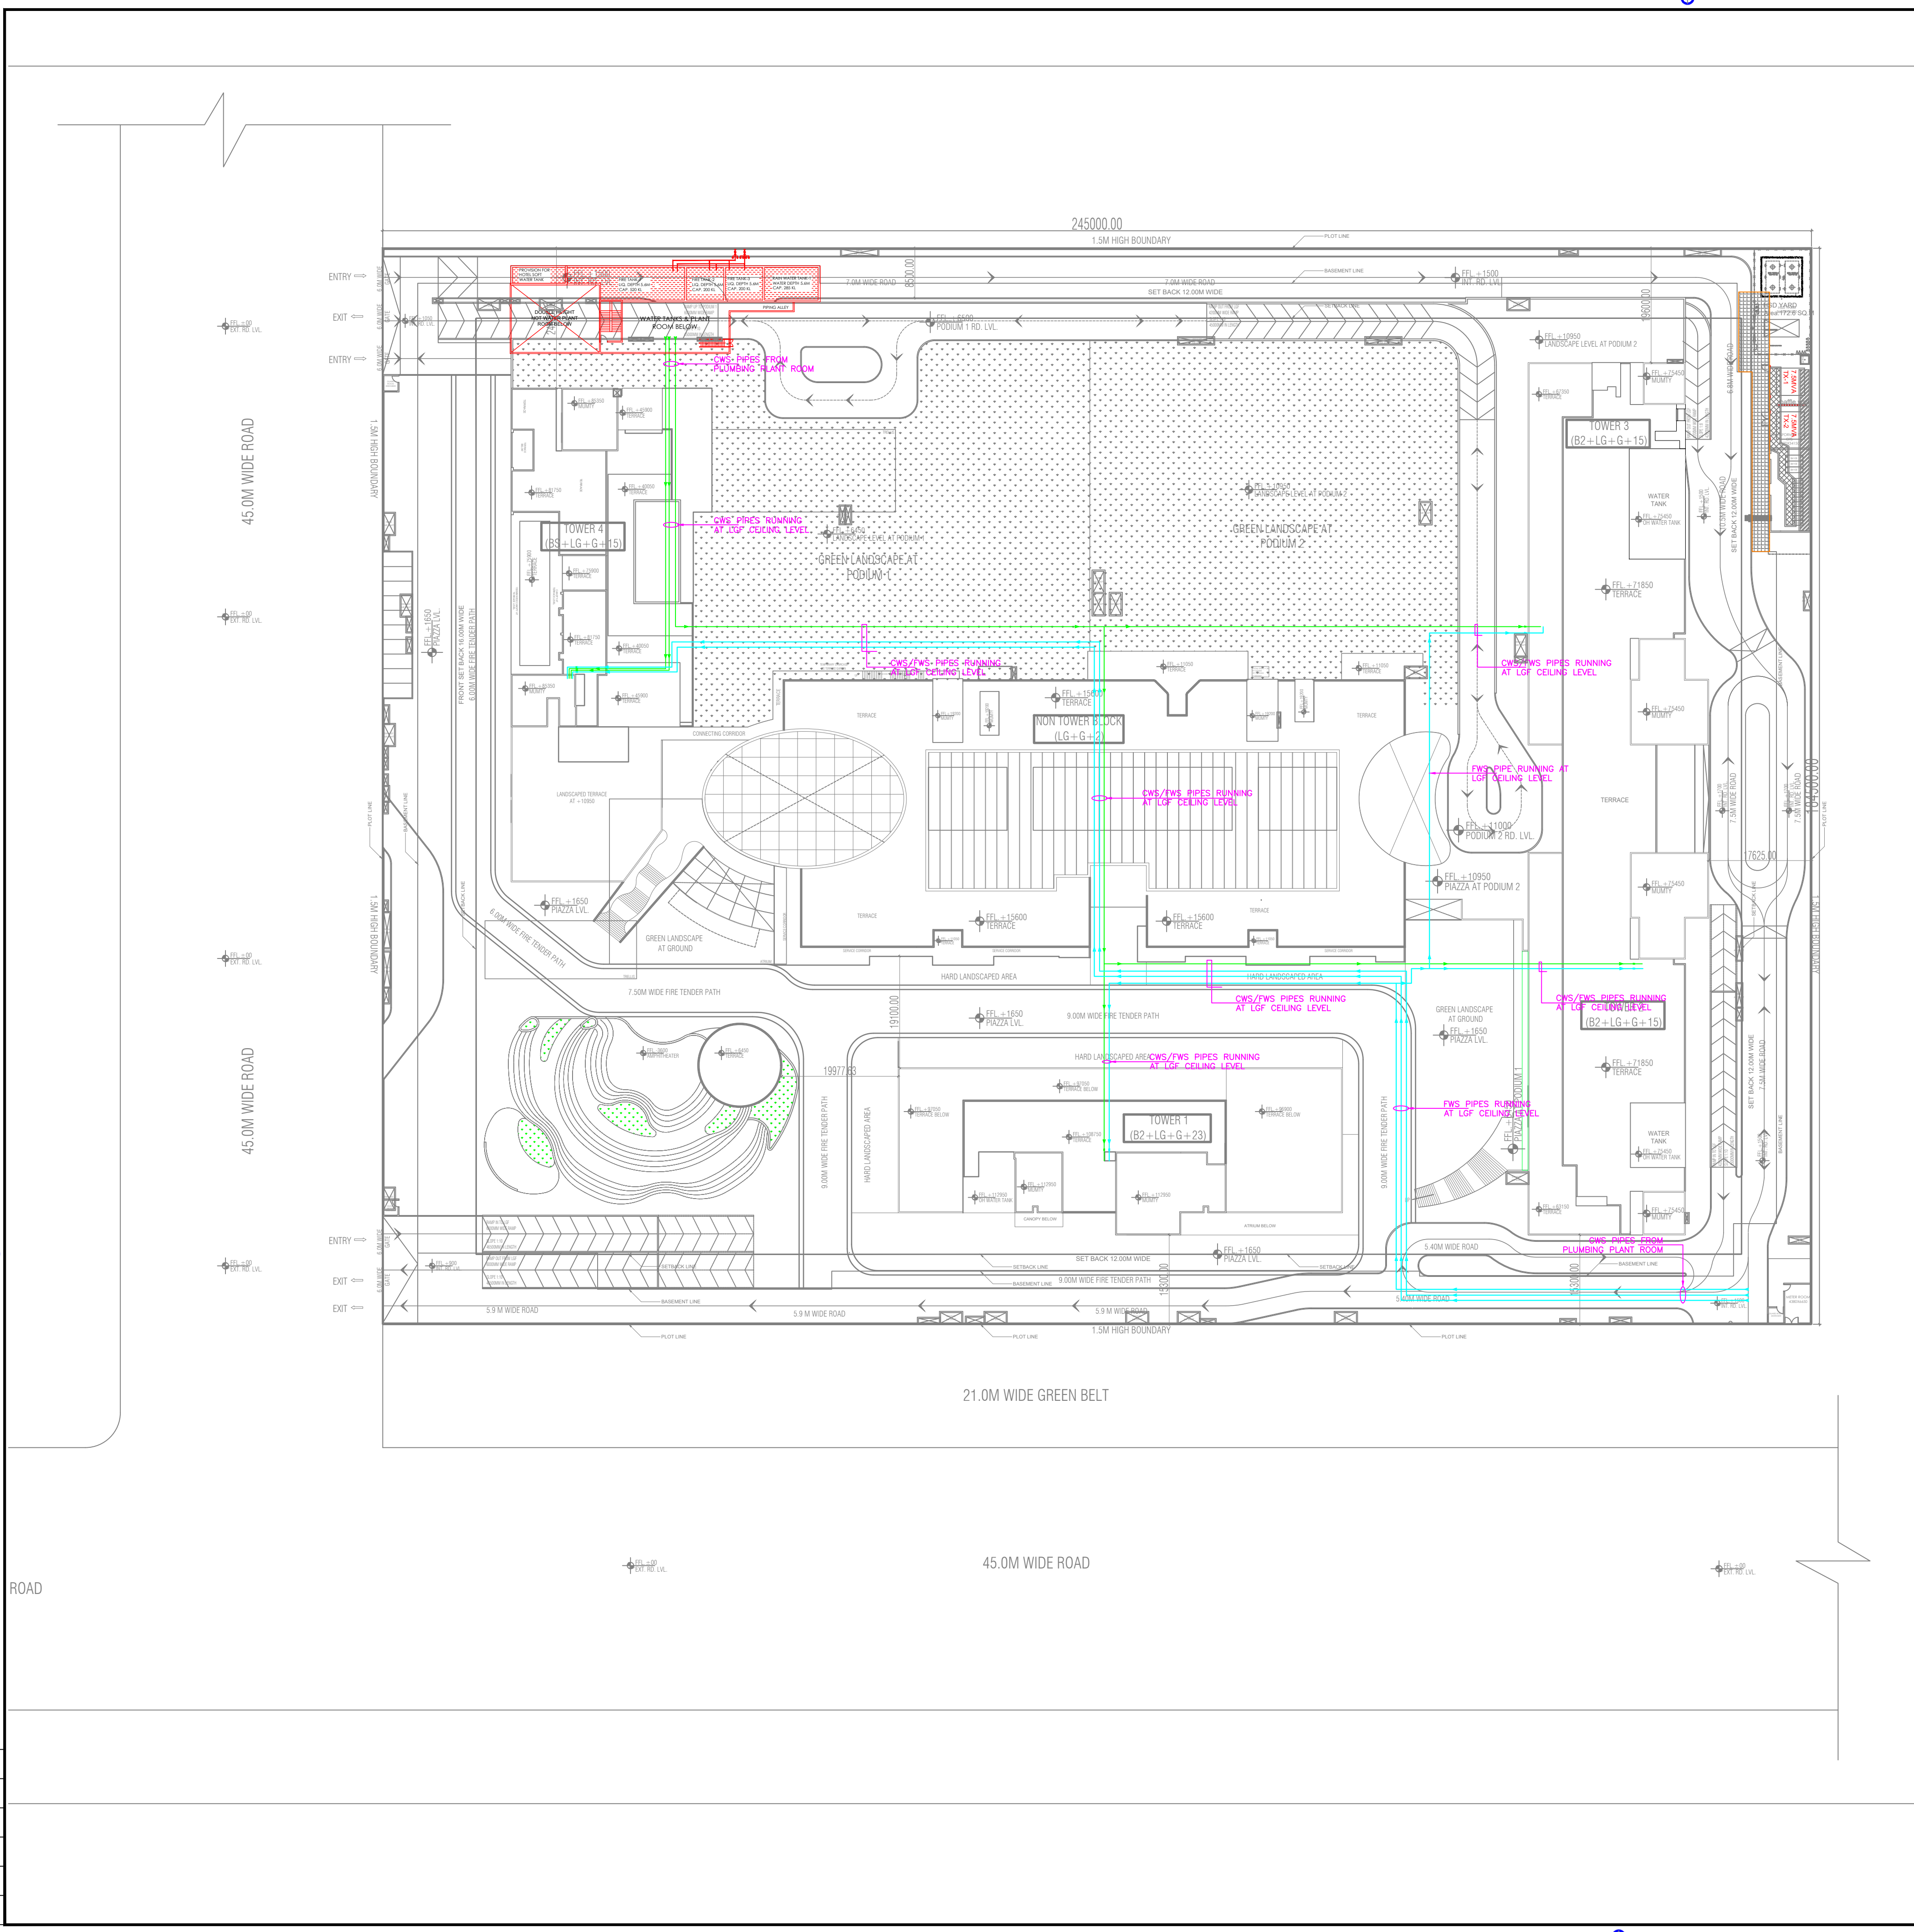

LEGEND FOR WATER SUPPLY

DESCRIPTION	SYMBOL
DOMESTIC WATER SUPPLY PIPE	
FLUSHING WATER SUPPLY PIPE	
VALVE	

PROJECT
PROPOSED BUILDING FOR
IT INFRASTRUCTURE PARK PVT.LTD.AT
PLOT NO. 1B, SECTOR 140A, NOIDA

OWNERS
IT INFRASTRUCTURE PARK PVT.LTD.
2ND FLOOR, PLOT NO. 140A, SAUVEER BHAWAN
AROCKY MARKET
PREET VIHAR, NEW DELHI, 110086

PRINCIPAL ARCHITECT
VASTUNIDHI
Vastunidhi
108 BLOCK B, SECTOR - 46
NOIDA, 101301, PRADEEP DHRI NAG, NOIDA
T: +91 9898 181 589

SERVICES CONSULTANTS
Proion Consultants Private Limited
Building Services - MEP Consulting
82, Sukhdev Vihar,
New Delhi 110 025, India.
Tel: 26324400, www.proion.net

ARCHITECT'S SIGNATURE

OWNER'S SIGNATURE

DWG TITLE
SITE PLAN
WATER SUPPLY LAYOUT

NORTH

SUBMISSION DRAWING

DRAWN BY
DATE
SHEET SIZE

YOGENDRA
02-11-2022
A0

CHECKED BY
SCALE
SHEETS

P.G.
1:400
1

NUMBER

PC-CRC-140A-PL-102

REV. NO.