

 
SANITARY DRAWING

PROJECT
PROPOSED GROUP HOUSING, AT
RAJAN KHAND, RAIBAREILLY ROAD,
LUCKNOW.



DWG TITLE
GROUND TO 8TH FLOOR PLAN
TYPICAL FLAT PIPE LAYOUT PLAN

BLOCK - 2



DATE
MARCH-2017

DWG NO.
HMA/SHU

CHECKED BY
AKSRI

SHUBHENDRA BAJPAL

ARCHITECTURAL CONSULTANTS -


ARCH DOT CREATION
(LUCKNOW OFFICE):-

4/404 VIVEK KHAND, GOMTI NAGAR,
LUCKNOW. Ph - 40715122, 9415021936.
e-mail add - adcrea@rediffmail.com

(GHAZIABAD OFFICE):-
2160-2161, Roma no. Manojpur,
Masood Crossing, Republic, Ghaziabad.
Ph : 09871599836
e-mail add - adcreation2@yahoo.co.in

VIEW CONSULTANTS

LUCKNOW
Ph No - 91-9629290682
email viewconsultants@yahoo.in

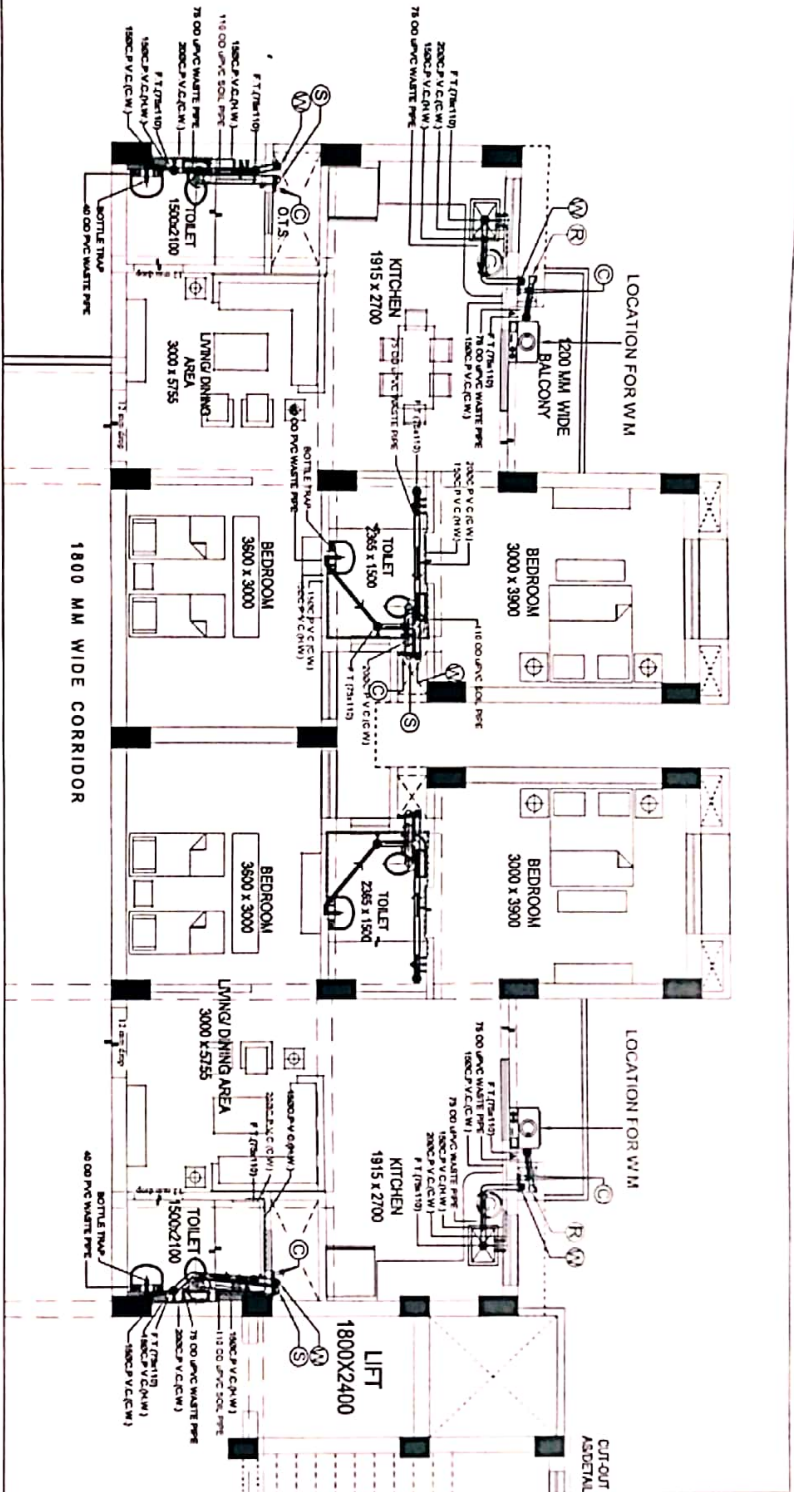

PIPE LAYOUT PLAN TYPICAL FLAT

LEGEND-(SANITARY)

S NO	SYMBOL	DESCRIPTION
1	Q.R	110 OD UPVC RAIN WATER PIPE
2	Q.S	110 OD UPVC SOIL AND VENT PIPE
3	Q.W	110 OD UPVC WASTE AND VENT PIPE
4	Q.C	WATER SUPPLY PIPE FROM TERRACE
5	---	PIPE FOR COLD WATER SUPPLY
6	---	PIPE FOR HOT WATER SUPPLY
7	● F T	FLOOR TRAP
8	● T B C C	TAP BIB COCK
9	● W B	WASH BASIN
10	● S H	SHOWER
11	● E N G	ENGLISH W.C
12	● K S	KITCHEN SINK
13	● G	GEYSER
14	● W M	WASHING MACHINE
15	● B V	BAL VALVE
16	● H W	HOT WATER SUPPLY
17	● C W	COLD WATER SUPPLY

HEIGHT OF FIXTURES:-
SHOWER HEAD-2000MM
SINGLE/TWO WAY BIB COCK-350MM
GEYSER ANGLE VALVE-1750MM
WASH BASIN ANGLE VALVE-450MM
W.C. CISTERN ANGLE VALVE-250MM
WALL MIXTURE-950 MM
DIVERTOR-1050 MM
SPOUT-750 MM
WASHING MACHINE TAP-900MM
C.P.V.C. BALL VALVE ABOVE FALSE CEILING IN TOILET
C.P.V.C. BALL VALVE OUTSIDE KITCHEN-1650MM
ALL HT. ABOVE FINISH FLOOR LVL.

NOTE - USE 16MM DIA PVC PIPE FOR KITCHEN/TOILET SLEEVE IF REQUIRED

GROUND TO 8TH FLOOR PLAN