


Devi Height - Development

THIS DRAWING IS THE PROPERTY OF
PARADISE CONSULTANTS AND SHALL NOT BE
COPIED OR USED IN ANY WAY WITHOUT
THEIR PRIOR PERMISSION.

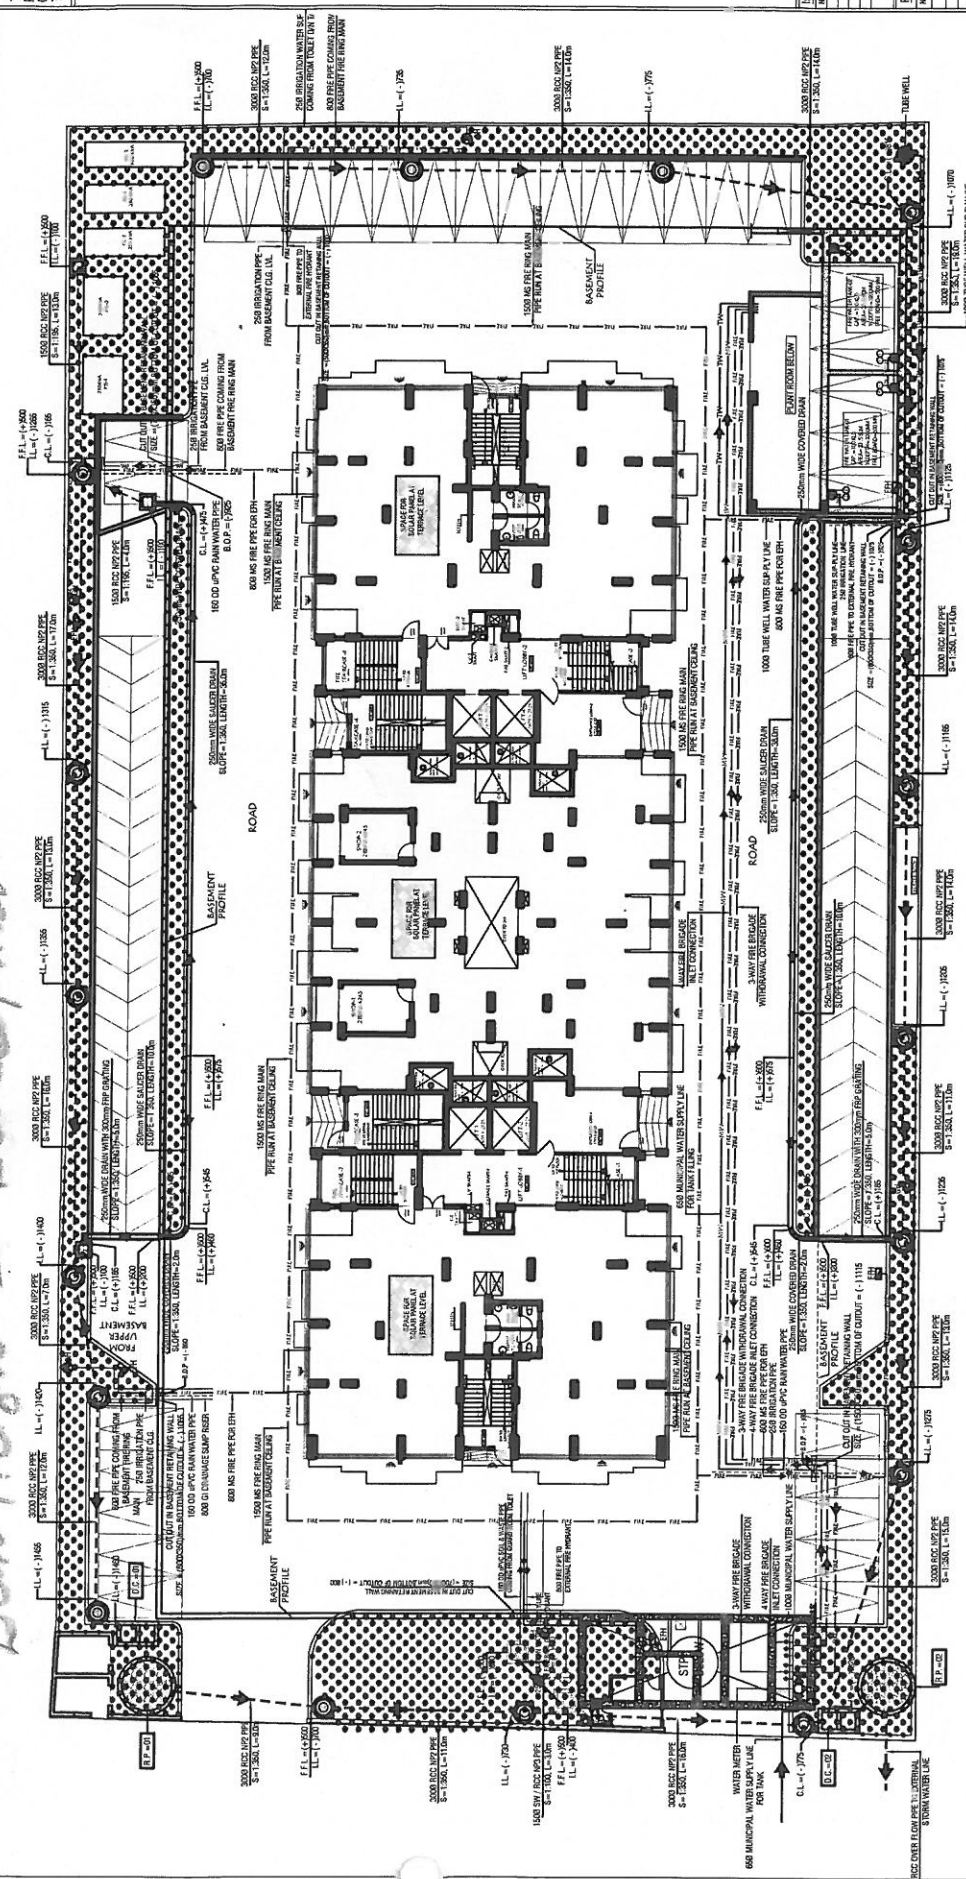

WORKING DRAWING		
OWNER'S NAME	Mr. Vijay kumar & Mr. Ashok Wadia	
PROJECT	PROPOSED GROUP HOUSING NAMED GRAND ROYALE AT SEC 14, T.H.A., NEAR SHRI RAM SAKSHI AWAS SAMITI KAUSHAMBI GHATASAD	
ARCHITECTS	MEHTA & ASSOCIATES C-74, ANAND VIHAR, DELHI - 110095 PH: 22147326, 22144521	
SUPERCASE CONSULTANTS	PARADISE CONSULTANTS Plot No. 96, Bawana, New Living Style Ind. Jangir War New Delhi - 110025 Landline - 411 2642601, 2642675 E-mail: paradiseconsultants@gmail.com	
DRAWING TITLE	External Site Plan Plumbing & Fire Layout	
Scale	1:150 (A3)	
date	26/05/17	
checked by	MAN SINGH	
approved by	MAN SINGH	
DESIGNED BY	MAN SINGH	
REVISIONS		
No.	Date	Description
1		
2		
3		
100		

PLUMBING LEGEND:	
(1)	STORM WATER MANHOLE WITH 500mm PREPARED MANHOLE COVER
(2)	900mm MANHOLE UP TO 1.57m DEPTH
(3)	1200mm MANHOLE UP TO 2.25m DEPTH
(4)	1500mm MANHOLE ABOVE 2.25m DEPTH
(5)	SEWER MANHOLE SIZE = (600x900)mm
(6)	STORM WATER CATCH BASIN SIZE = (600x900)mm
(7)	EXTERNAL FIRE HYDRANT
(8)	EXTERNAL FIRE HYDRANT
(9)	GROUND LEVEL
(10)	INVERT LEVEL
(11)	CONNECTION LEVEL

PLUMBING LEGEND:	
---	EXTERNAL SINK LINE
---	EXTERNAL STORM WATER LINE
---	DOMESTIC WATER SUPPLY LINE
---	FROM MUNICIPAL / TANKER LINE
---	IRRIGATION WATER SUPPLY LINE
---	TUBE WELL WATER SUPPLY LINE
---	EXTERNAL FIRE HYDRANT LINE
---	RECHARGE PIT (1000mm DIA)
---	D.C. DESALTING CHAMBER (1000 x 2000mm DIA)
---	VALVE WITH CHAMBER
---	NON RETURN VALVE WITH CHAMBER