


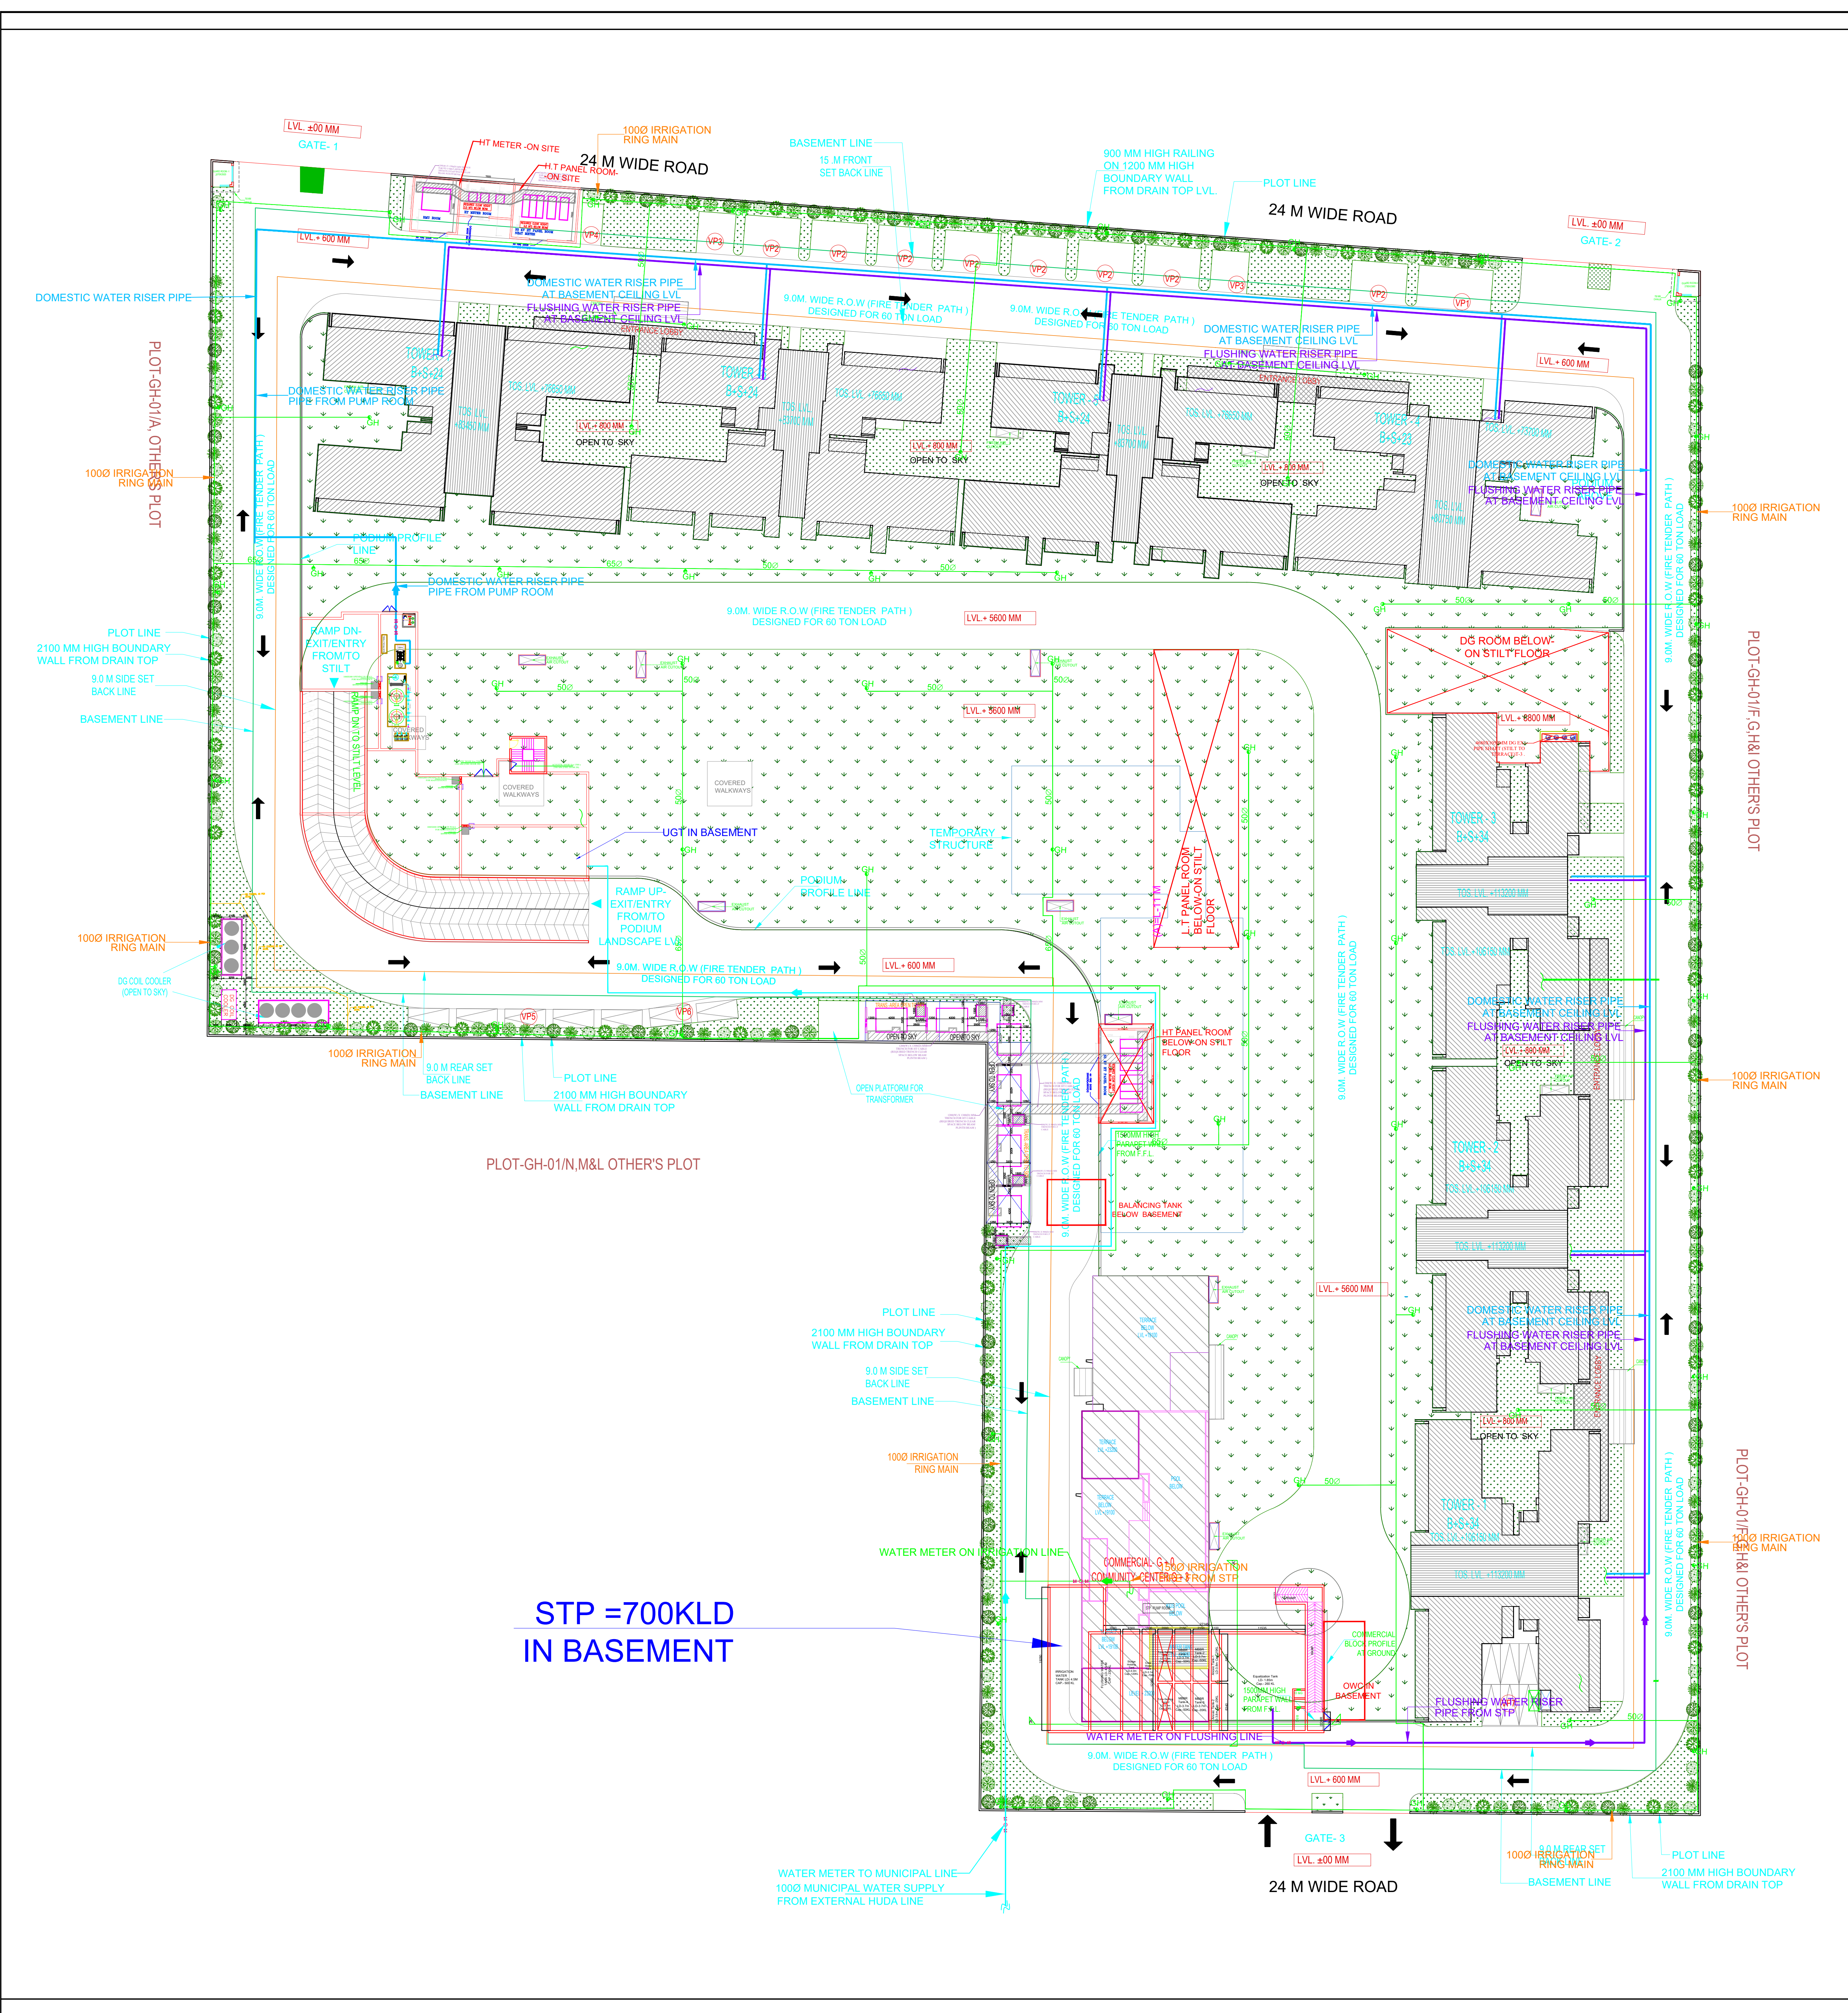

DESCRIPTION	SYMBOL
IRRIGATION LINE	
DOMESTIC WATER SUPPLY PIPE	
FLUSHING WATER SUPPLY PIPE	
WATER METER	
(GH) GARDEN HYDRANT	

OWNER SIGN

ARCHITECT SIGN

TOWN PLANNER SIGN

MEP CONSULTANT

DESIGN CENTRE CONSULTING ENGINEERS
PVT.LTD
OFFICE NO. 44 TO 47, 4TH FLOOR
ANSAI PLAZA, DABUR CHOWK
VAISHALI, GHAZIABAD, UP
PHONE: 0120-4333451,4333452

OWNER

GODREJ PROPERTIES LIMITED

SUBMISSION DRAWING

KEY PLAN

PROJECT

PROPOSED GROUP HOUSING FOR
PLOT NO :- GH-01/B,C,D,E,J & K SECTOR -12,
GREATER NOIDA, G.B. NAGAR, (U.P.)

DATE

PROJECT INCH.

CHECKED BY

23 - 01 -2025

BALRAJ SINGH

BALRAJ SINGH

SCALE

DEALT BY

APPROVED BY

1:100

ABDRESH JHA

VISHAL SHARMA

DRAWING TITLE

WATER SUPPLY LAYOUT LAYOUT
SITE PLAN

SITE PLAN

ARCHITECTS

GOLDEN INDA ARCHITECTS
THE TEAM OF ARCHITECTS
FF-37, KADAMBA SHOPPING COMPLEX
GAMMA-1 GREATER NOIDA
CON... + 91-94-1585-6777

DESIGN BY:

Confluence
NEW DELHI, INDIA
F-1, FIRST FLOOR, MIRA CORPORATE SUITES,
ISHWAR NAGAR, NEW DELHI 110065
Ph +91-11-26925684 ccs@inconfluence.com Member of IGBC
Ph +91-11-40564768 www.inconfluence.com ISO - 9001 : 2000
architecture urban design hospitality interiors

DRAWING NO. DCCE/1446/PL-SP-WS-03

REVISION