


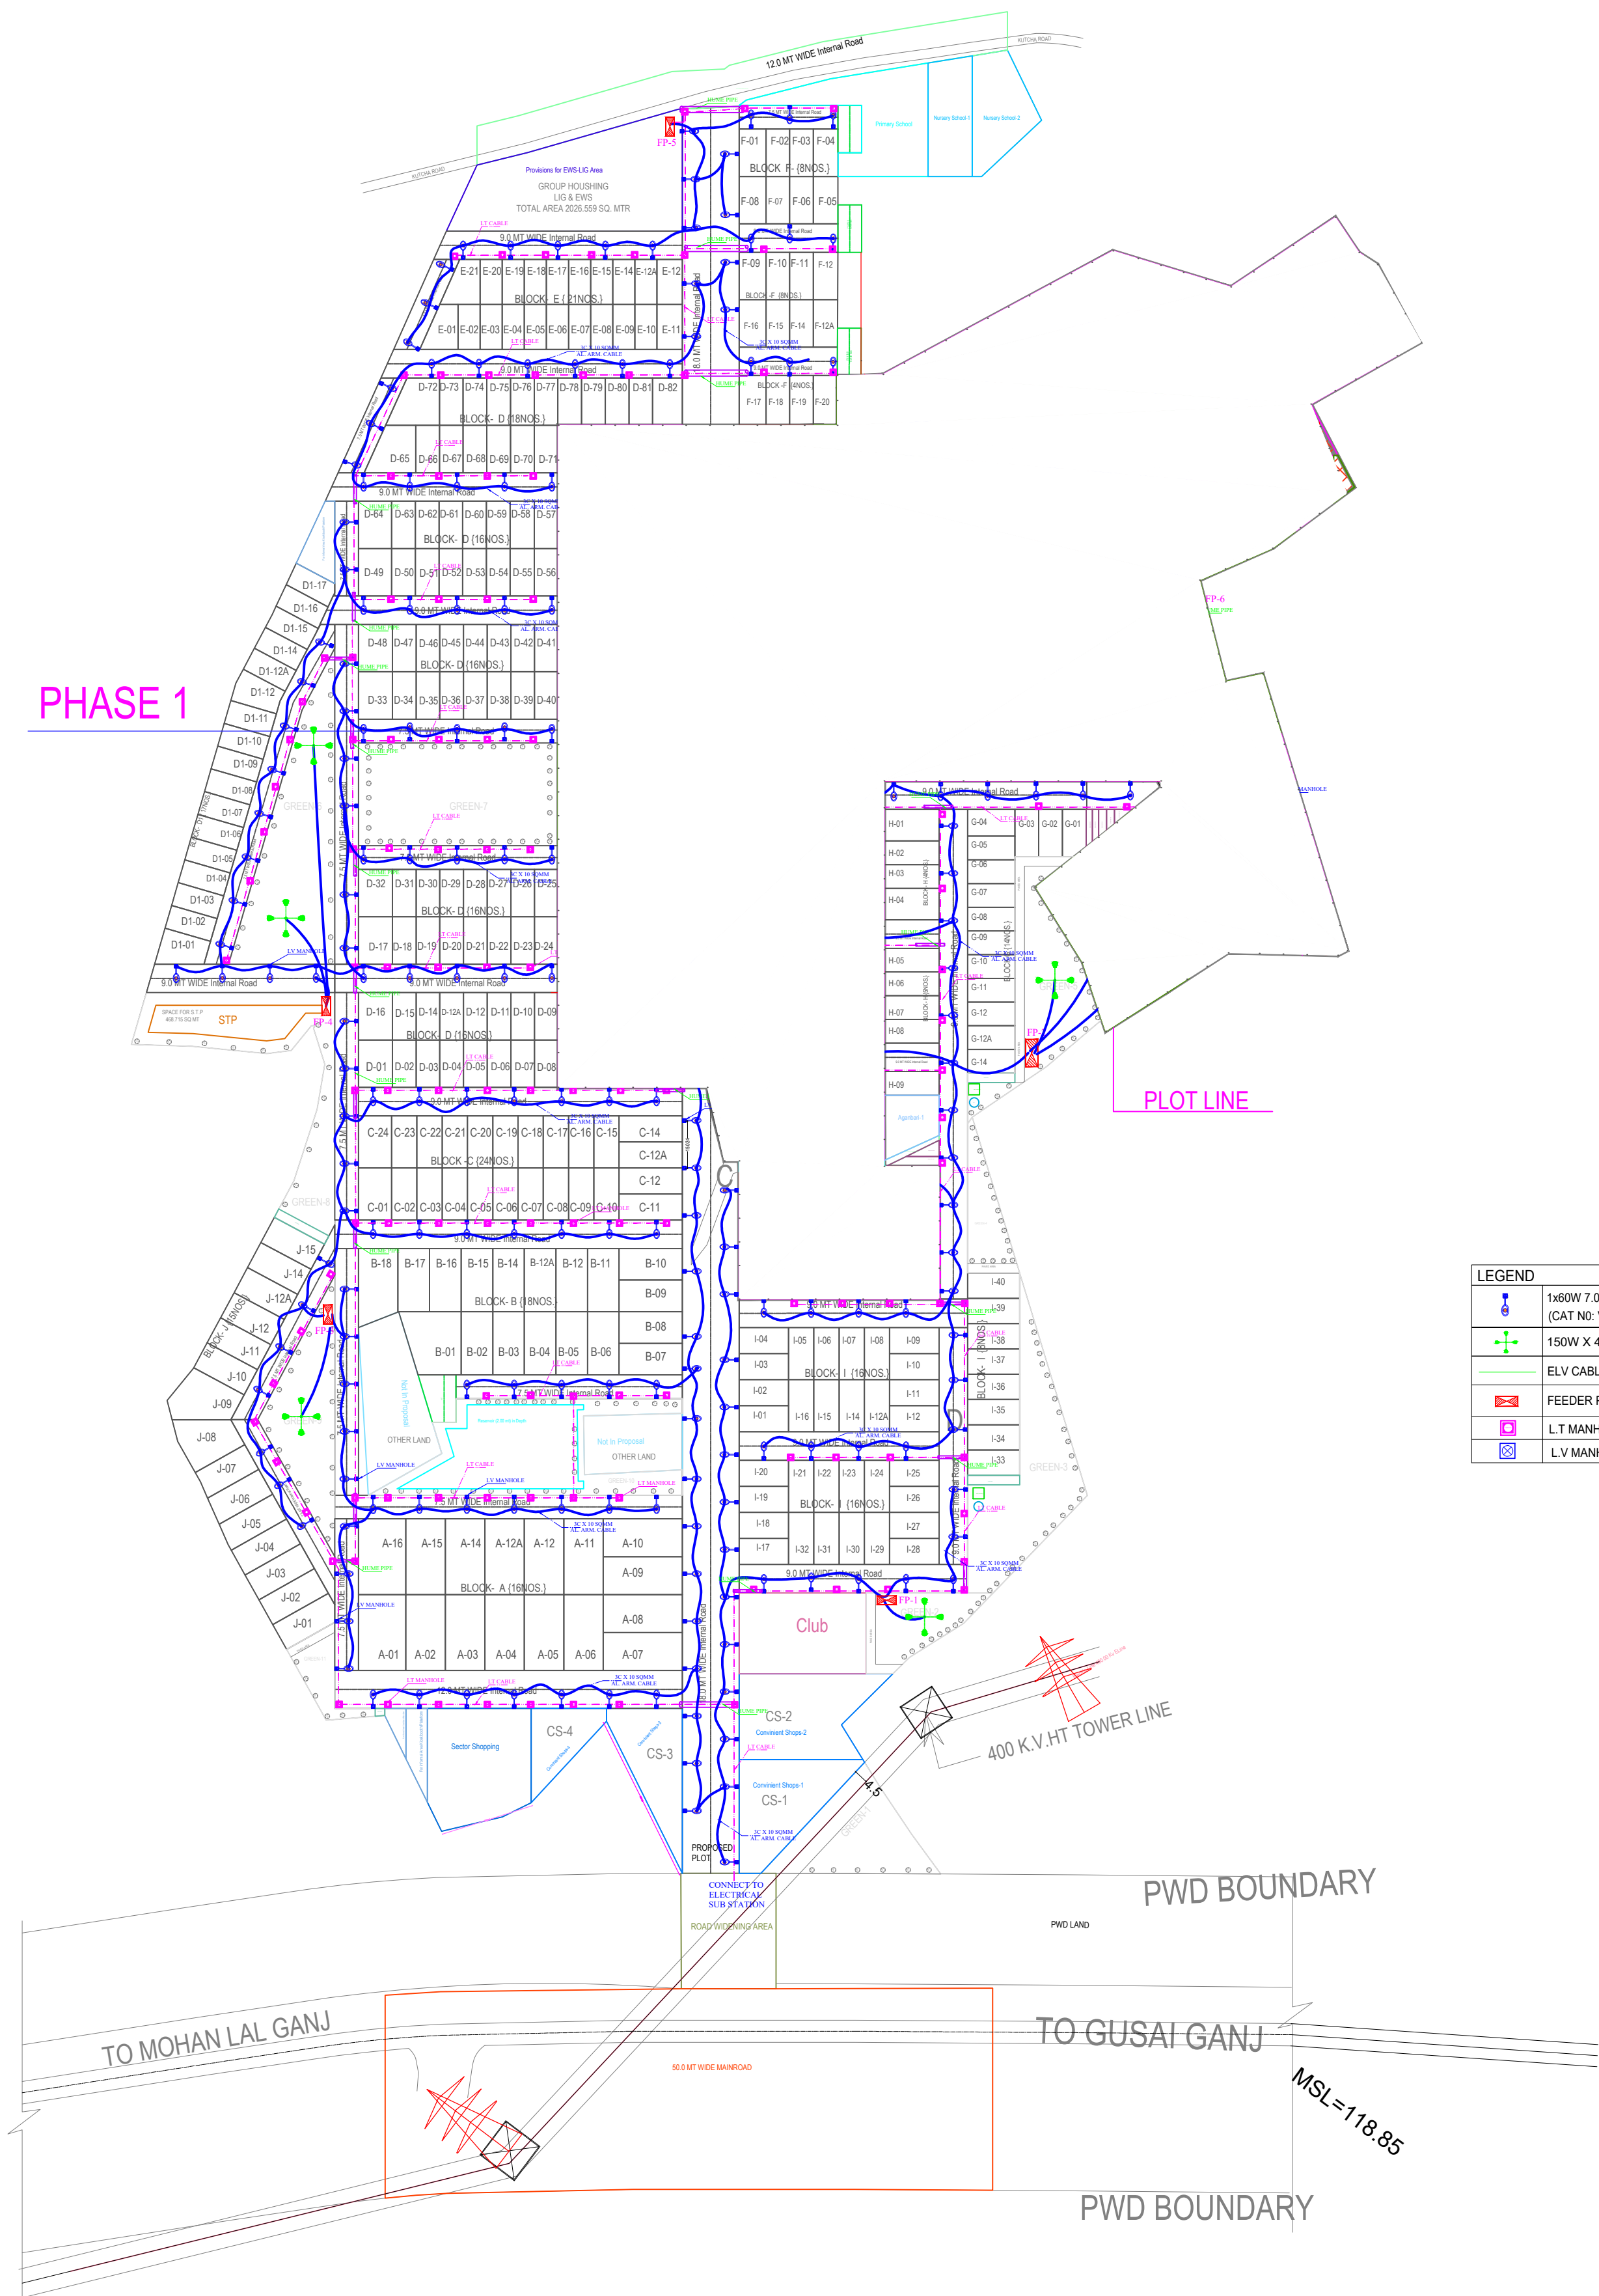

LEGEND	
	1x60W 7.0M OCTAGONAL POLE FOR LIGHT LED FIXTURE (CAT NO: VAK-ST-EAG-POLE-60)
	150W X 4, 15 MTR. HIGH MAST FLOOD LIGHT FIXTURE SET
	ELV CABLE AL, ARM. XLPE CABLE
	FEEDER PILLAR
	LT MANHOLE
	LV MANHOLE

MEP CONSULTANT:
M.S ASSOCIATES
MEP CONSULTANT ENGINEERS
B-400, Gali No.-10, Veerbazar Road Near Krishna Dramsala,
Gaurav Nagar, Prem Nagar Part-II, Nangloi, New Delhi-110086
E-Mail: msassociates95@gmail.com, ajay20051978@yahoo.com
Tel. 09213274289, 09555954522

PROJECT:
Aashrayam Ph-1
DEVELOPER:
M/s Agrasheel Infratech Private Limited
DRAWING
TITLE:
**LT CABLE ROUTING & EXTERNAL LIGHTING LAYOUT PLAN
ELECTRICAL DRAWING**

DRG. NO.
EL-01
ORGL. DATE:
30-08.2024

ARCHITECTURE CONSULTANT -
RAGHAVA ARCHITECTS
Head office Indirapuram :
Plot No. Cs-09, 2nd floor, Commerical Market, Gyan Khand-II,
Near St. Thomas School, Indirapuram Ghaziabad-201014 (U.P.)
Branch office Wave City
Shop No. 43, Dream Bazar, Dreams Homes, Housing Society, Sector-5,
57 Meter Road, Wavecity, NH-24, Ghaziabad - 201002
Indirapuram, Wave City, Lucknow Meerut
+91 9810379715, 9891146128
www.raghavaarchitects.com raghavaarchitects@gmail.com