



GREEN

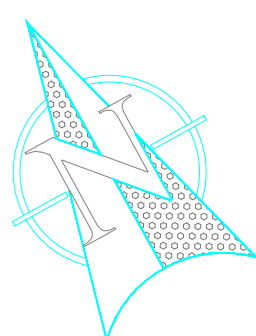

PLOT.E4

PLOT.E4

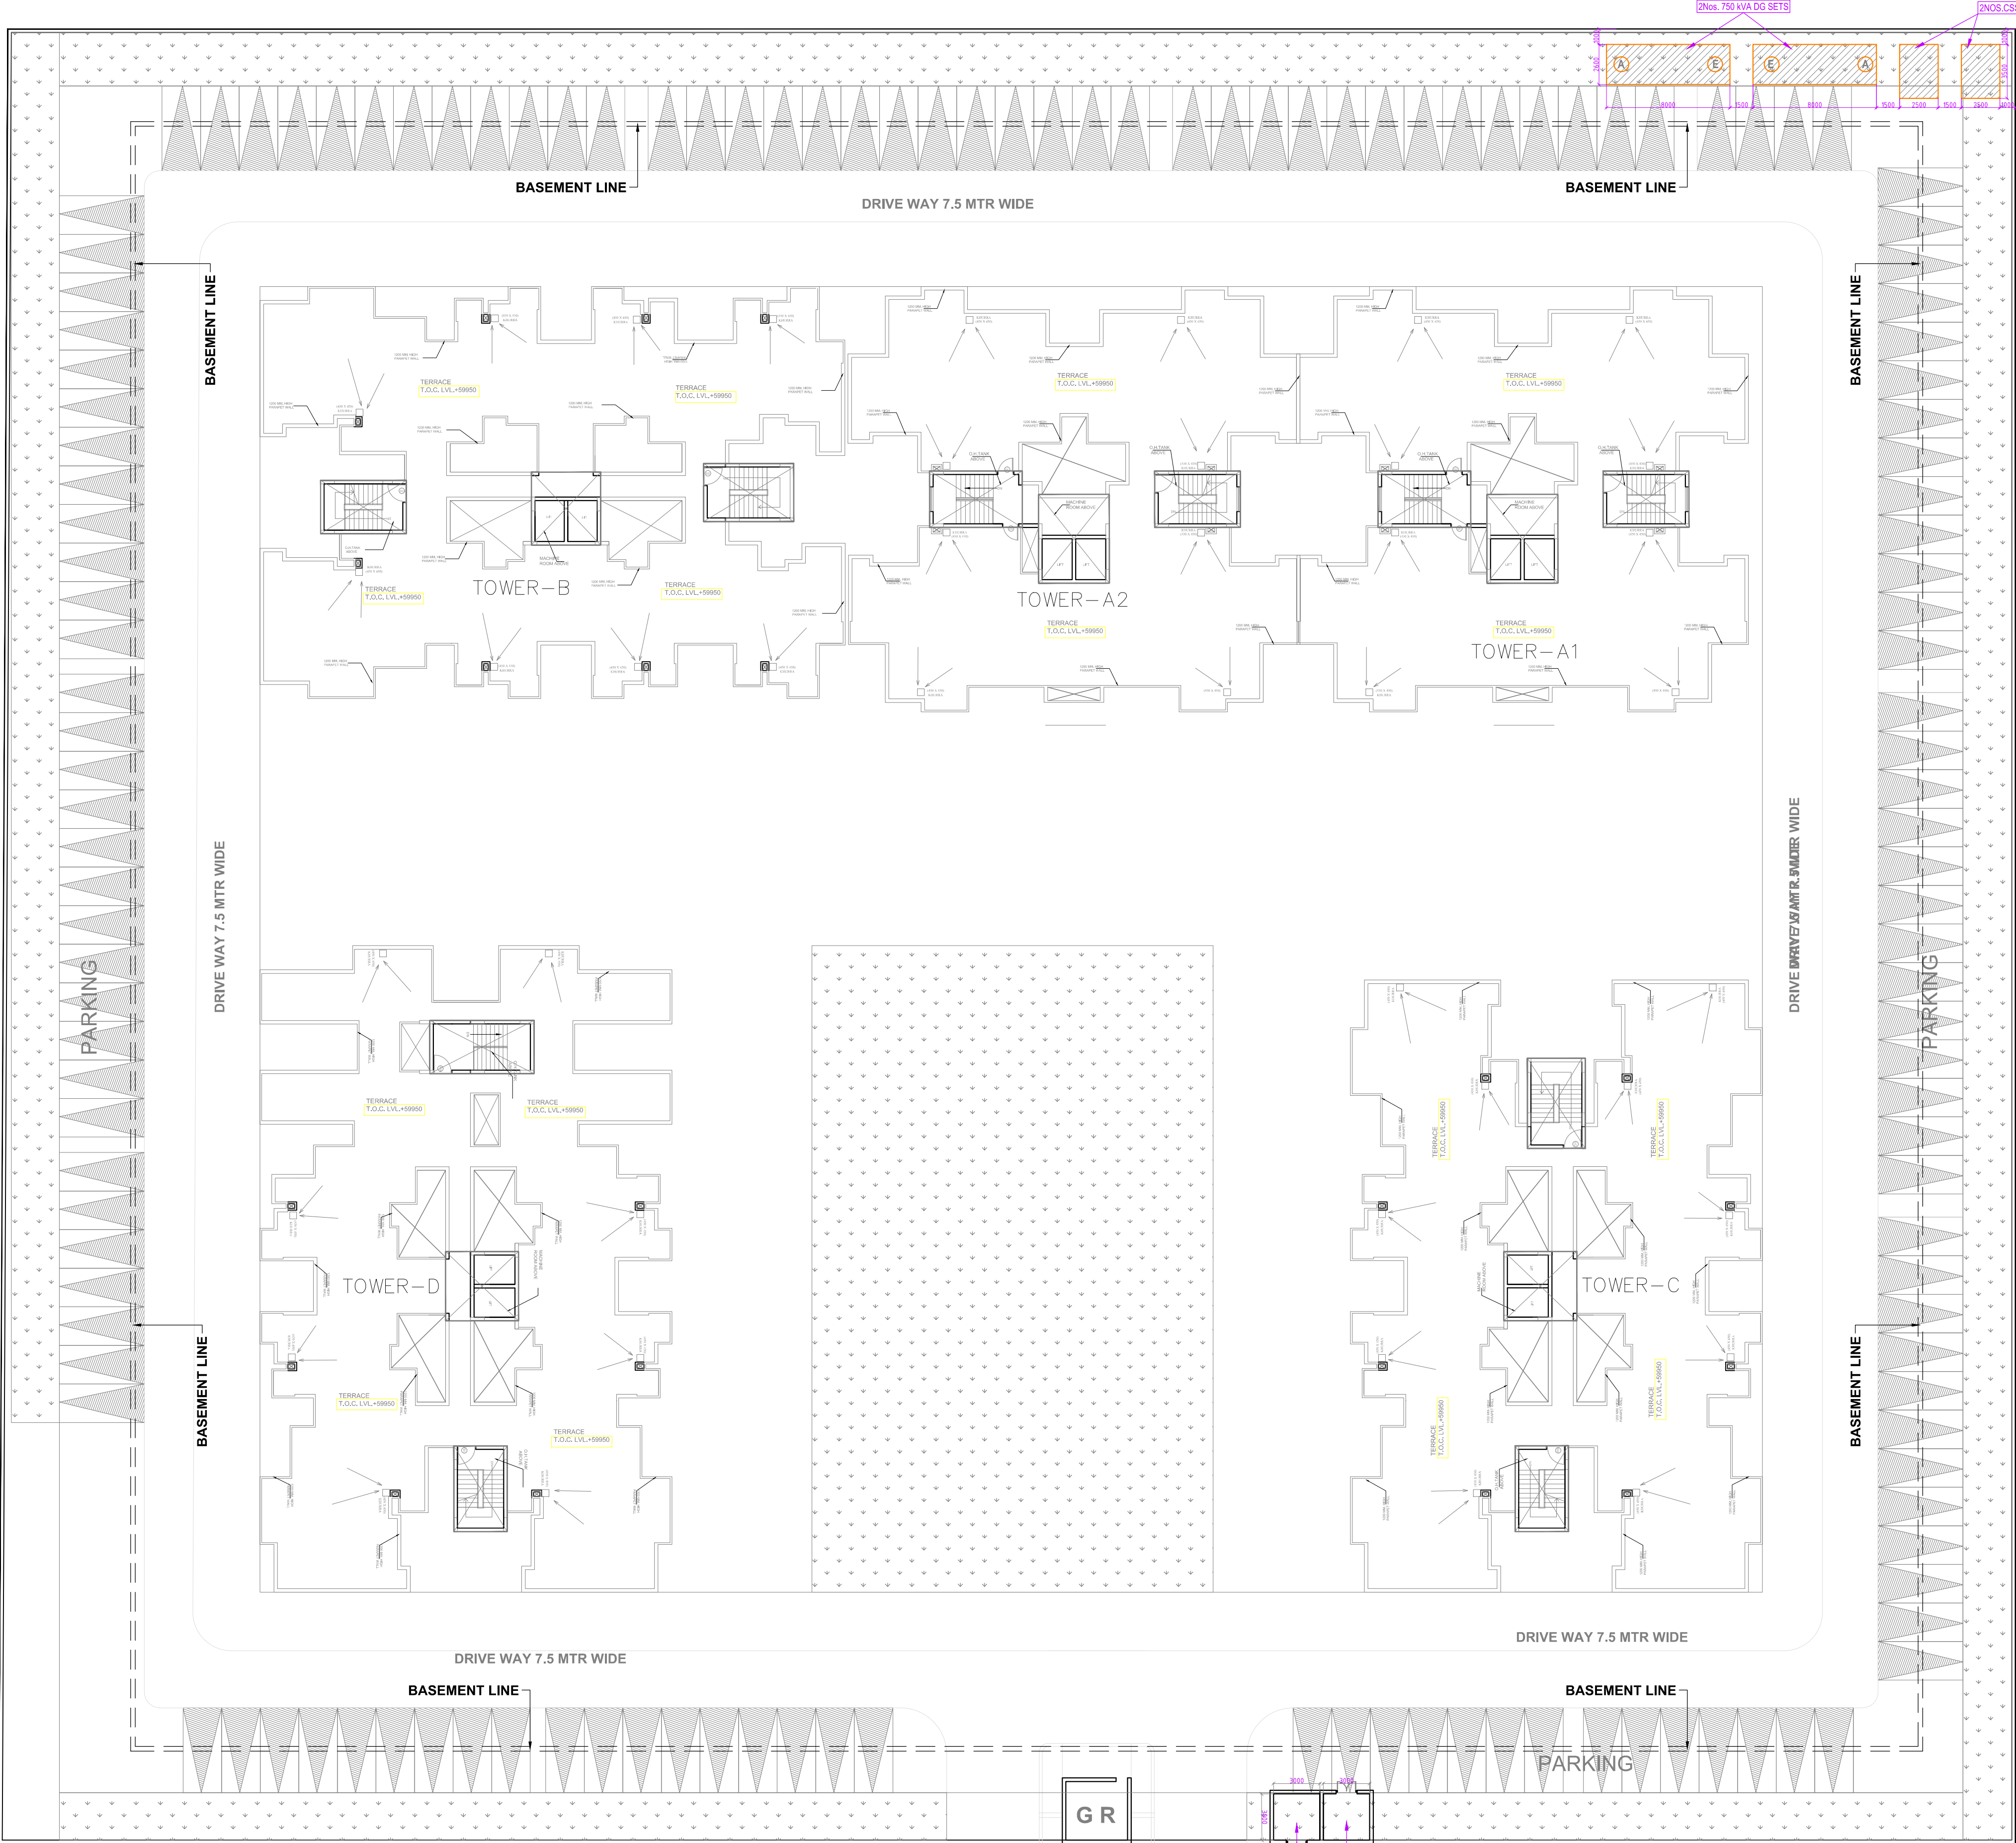

GR

11KV METER ROOM
11 KV SINGLE VCB ROOM

30 MTR WIDE ROAD

10.0MT. WIDE PATHWAY/GREEN

rev. no.	date	revision
..	..	..

project
**PROPOSED GROUP HOUSING AT PLOT NO.-D.1,
CHAK GANJARIA SCHEME,GOMTINAGAR EXTENSION,LUCKNOW**

title
SITE PLAN

subtitle
EXTERNAL ELECTRICAL LAYOUT

drawing released for
☐ APPROVAL ☒ SUBMISSION
☐ ADVANCE COPY ☐ CONSTRUCTION

drg. no. CES / D.1 / SP / P-05 drawn by Sandeep

scale 1:250 @ A1 designed by Shakir Shabbir

date 12.11.2020 checked by Anand Havela

architects : GIAN P. MATHUR AND ASSOCIATES (P) LTD.
C - 55, East Of Kailash, New Delhi-110065
ARCHITECTS T : 46599599 I F 46599512
& PLANNERS E : info@gpmindia.com I W : www.gpmindia.com

services consultant
Consummate Engineering Services (P) Ltd.
Noida Office : B - 67, Sector - 67, Noida - 201 301
Tel : (0120) 2303500 (30 Lines)
Lko. Office : R 006, Rohitas Plumeria, Gomti Nagar, Lucknow
e mail : mail@cespl.in, website : www.cespl.in