


PLUMBING LEGEND:-	
	EXTERNAL SEWER LINE
	EXTERNAL STORM WATER LINE
	DOMESTIC WATER SUPPLY FILLING LINE FROM MUNICIPAL / TANKER LINE.
	IRRIGATION WATER SUPPLY LINE
	TUBE WELL WATER SUPPLY LINE
	EXTERNAL FIRE HYDRANT LINE
R.P.	RECHARGE PIT (3000 MM DIA)
D.C.	DESILTING CHAMBER (1000 x 2000 MM DIA)
	VALVE WITH CHAMBER
	NON RETURN VALVE WITH CHAMBER

PLUMBING LEGEND:-	
	SEWER MANHOLE WITH 560Ø MANHOLE COVER.
	STORM WATER CATCH BASIN SIZE = (600x600)MM
	STORM WATER MANHOLE WITH 560Ø PERFORATED MANHOLE COVER.
(I)	910 DIA MANHOLE UPTO 1.67 M DEPTH
(II)	1220 DIA MANHOLE UPTO 2.29 M DEPTH
(III)	1520 DIA MANHOLE ABOVE 2.29 M DEPTH
 EFH	EXTERNAL FIRE HYDRANT
 GH	GARDEN HYDRANT
G.L.	GROUND LEVEL
I.L.	INVERT LEVEL
C.L.	CONNECTION LEVEL

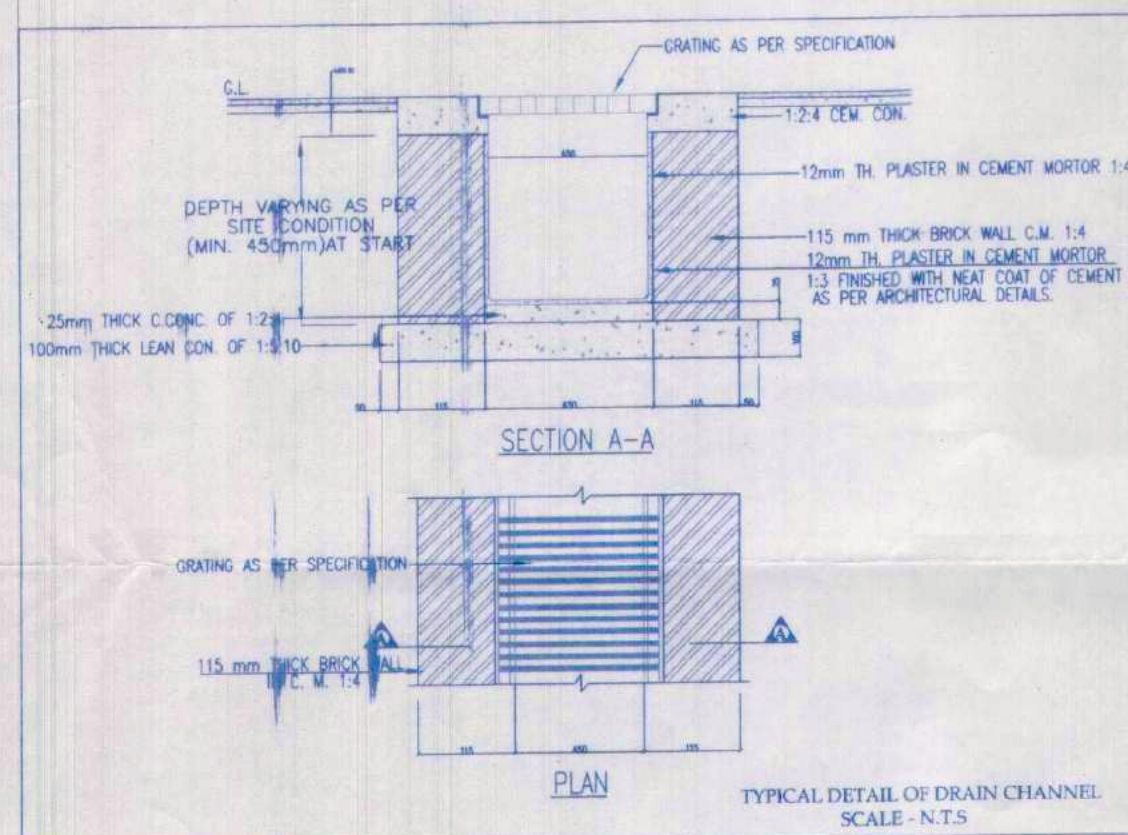

AREA LEFT FOR NON
CONFIRM ZONE :


SPACE FOR ELECTRIC
SUB - STATION AREA
= 50.00 sq.mt.

EXISTING WAZZIRABAD ROAD (60.00 MT.)


CENTRE LINE OF ROAD

30000

SUB - STA
= 50.00 sq

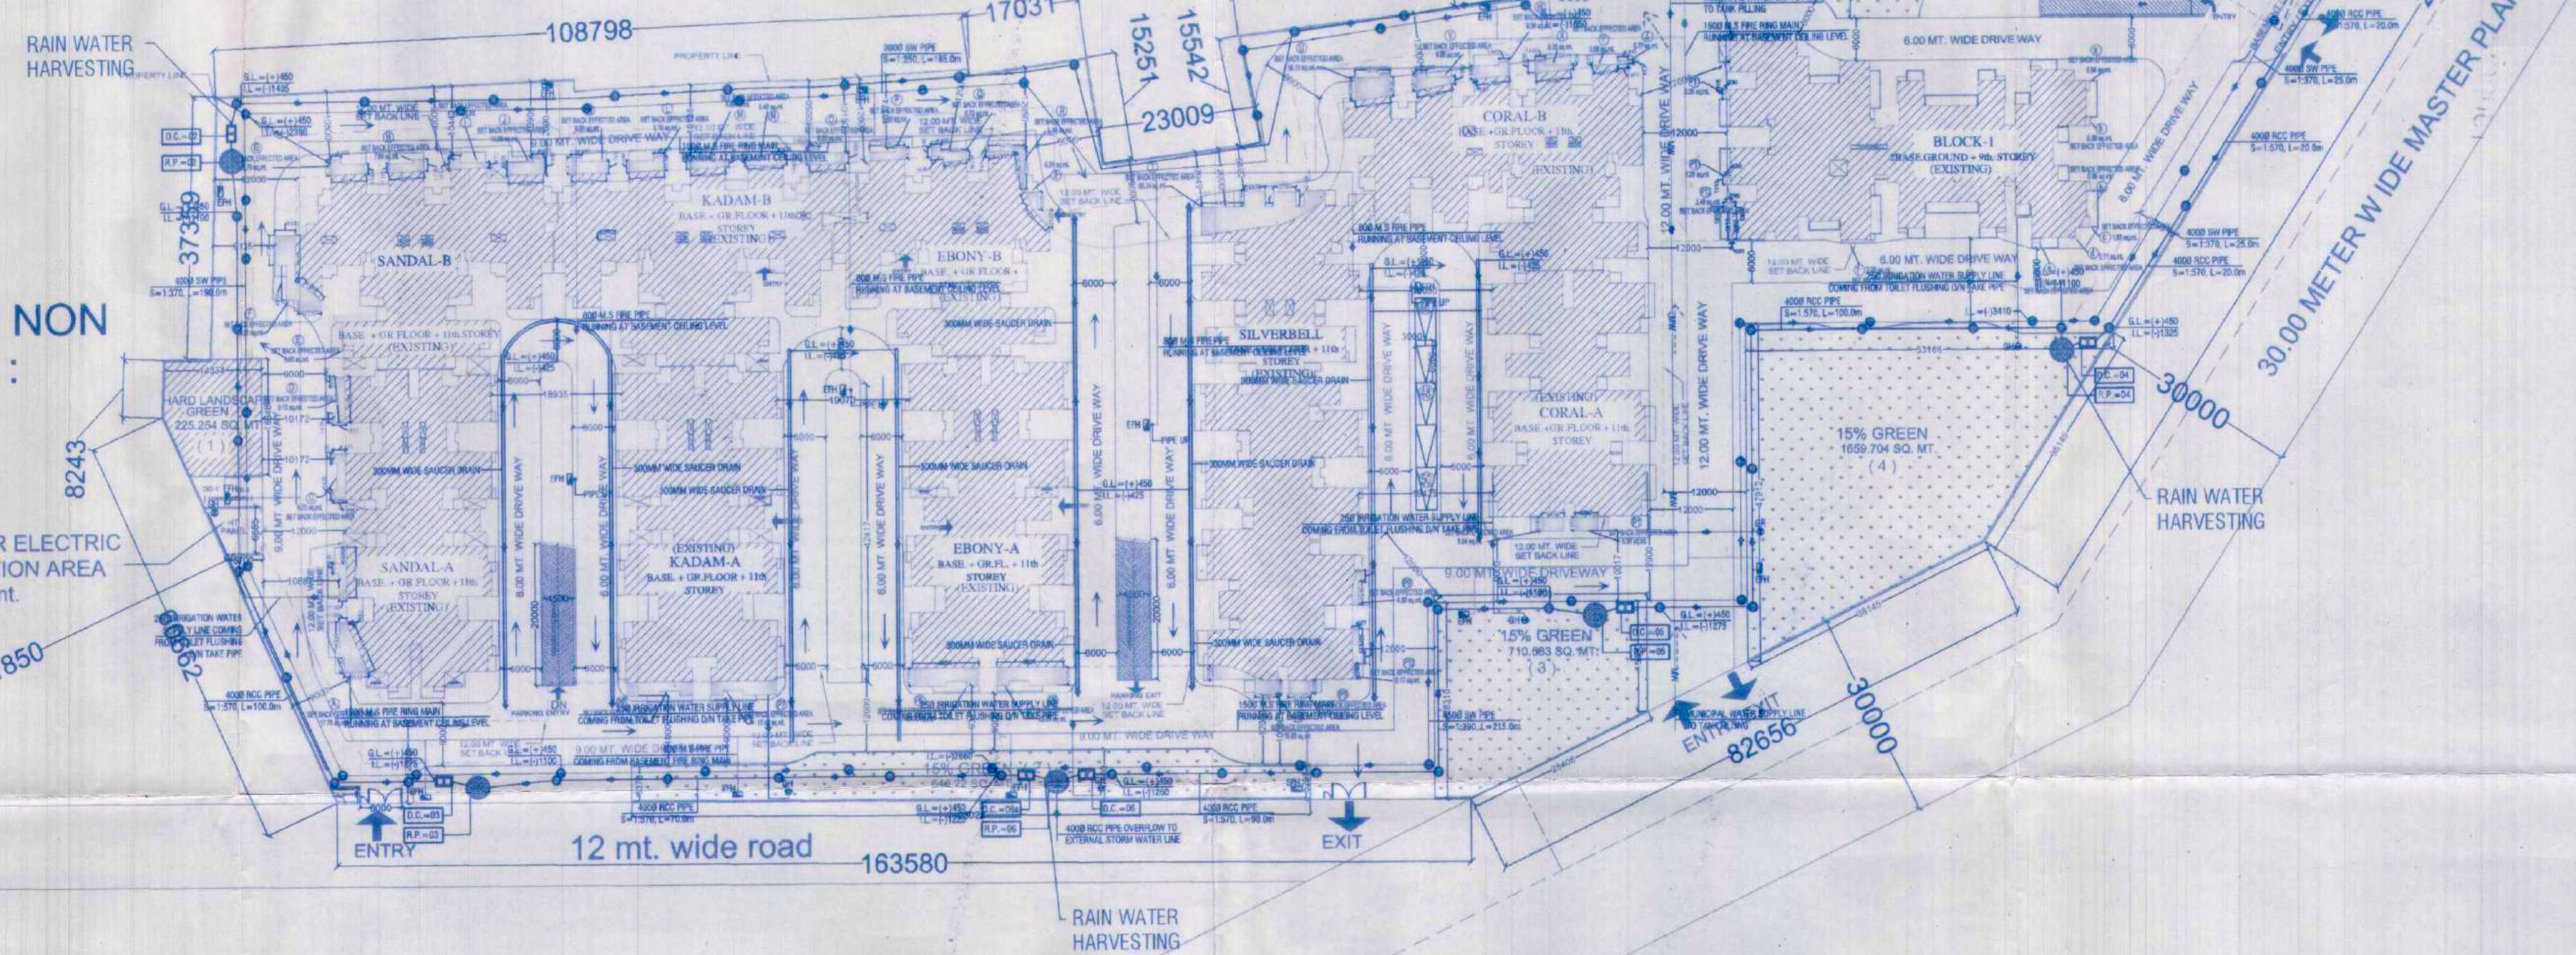

SERVICE PLAN

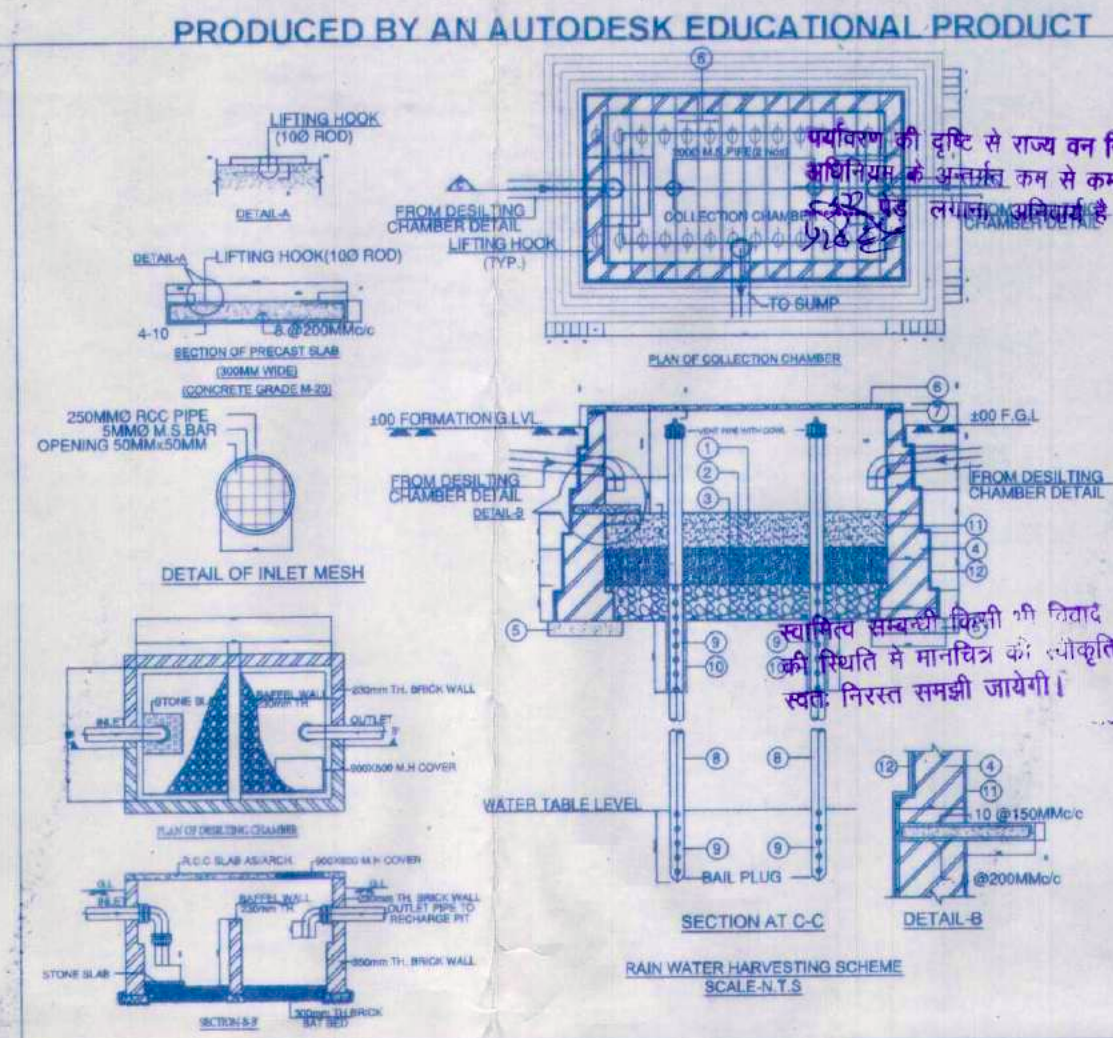

राजघाट विकास प्राधिकरण
संख्या 667/मा/प्र/1205
दिनांक 16/7/20
स्वीकृत
मौ 100 टन

शांति निरीक्षक
 शांतिबाबाद विकास प्राधिकरण,
 शांतिबाबाद

बहालक जलियन्त
बायबिल अनुबाय



स्थल पर एक बोर्ड पर स्वीकृत मानचित्र की
सूचना व दिनांक लिखना अनिवार्य होगा।

विद्यमान विहसले के सम्पत्ति सुरक्षित रूप
छोकर ही निष्पक्ष कार्य किया जाये
AREA = 30.00 sq. mt

सम्पत्ति प्रकार के भवन / स्ट्रक्चर का सूचना हेतु
विभिन्न स्तरों पर समस्त दीवारों के ऊपर
जाहिराती दी गई है। जलना सफा / वायुमय
है। जो दीवारों पर तब सिस्टम व प्रत्येक
के नीचे चला जाये।

एह मानचित्र स्वीकृति से केवल पाँच वर्ष तक बेल

मानचित्र स्वीकृत पत्र पर अंकित शर्तों के
अधीन मानचित्र निर्गत किया जाता है।

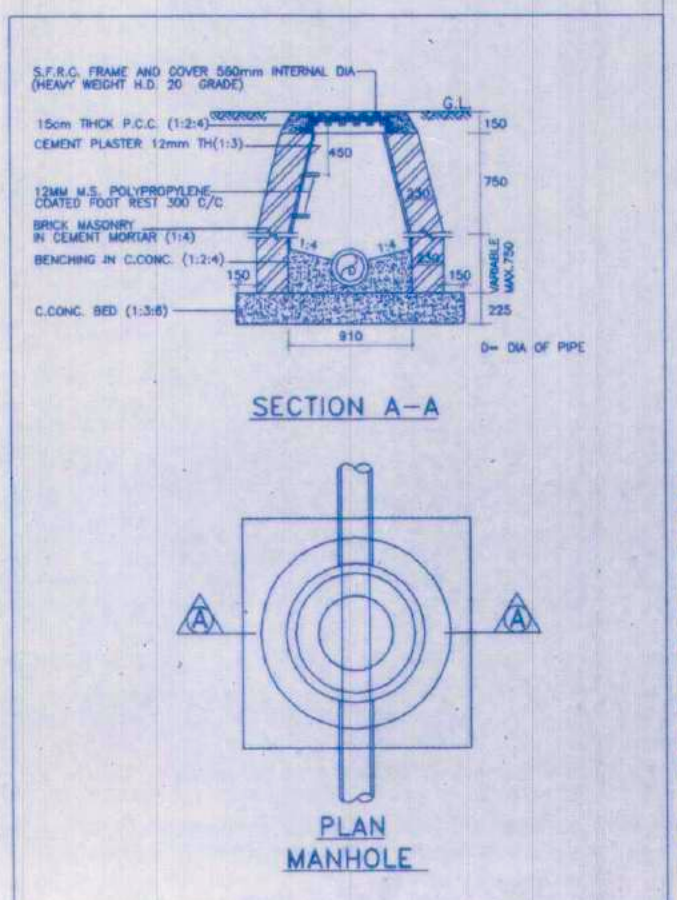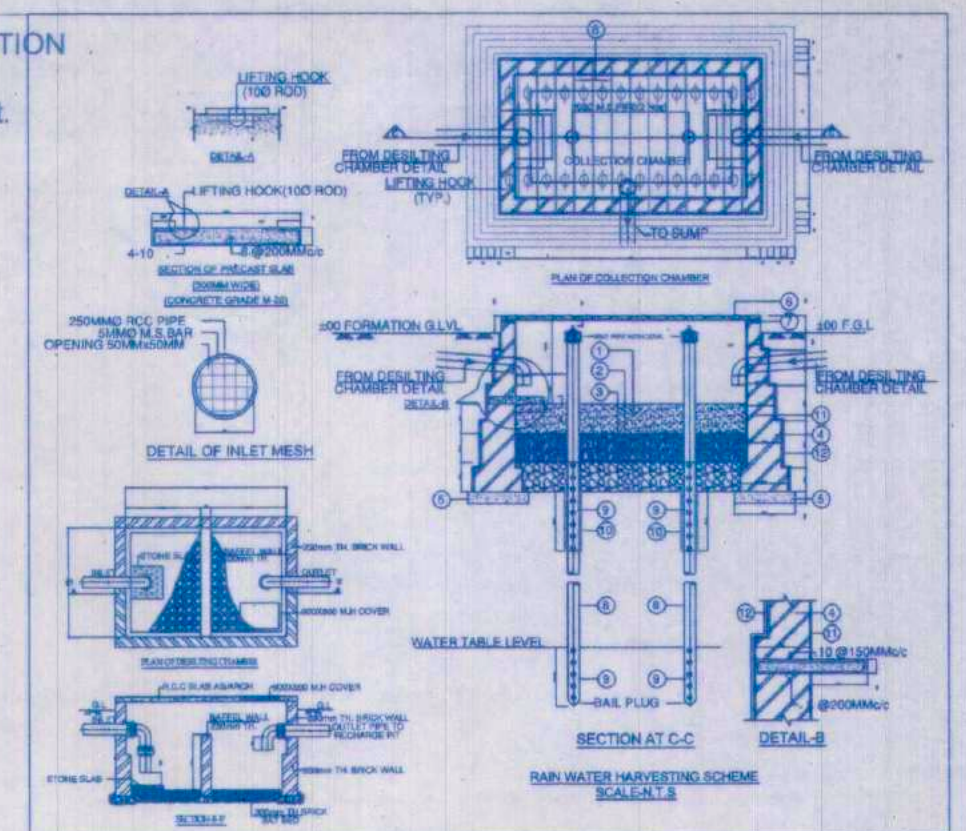

SERVICES LINE DETAIL		
1		150 Ø WASTE WATER LINE
2		450 Ø SEWER LINE
3		300 Ø RAIN WATER LINE

Sadanand
ER. SADANAND OJHA
ME (Civil)
Structural Consultants
Swati Structural Solution Pvt. Ltd
H.O. 503, 5th Floor, Corporate Tower
Plot No. 1, Centre
Sector-8, Rohini, Delhi-110085

PROJCT
REVISED SUBMISSION DRAWING FOR
GROUP HOUSING ' SHALIMAR CITY' AT
KH. NO. 376,378,377,VILLAGE SIKANDERPUR
GZB. & KH.NO.293,342 TO 360, 462,493,494&495
VILLAGE PASONDA, GHAZIABAD

PROMOTER:-
M.R. PROVUEY SHALIMAR CITY

OWNER:-
M/s. M.R.PROVUEY REALTECH (P.)LTD.,
MR. VIJAY KUMAR , MR.RAM NARESH MR.SUDAN
KUMAR, MR. PUSHPENDER KUMAR & MR. MANG
RAM

OWNER SIGN _____
DRAWING TITLE: _____

ARCHITECT SIGN:

SERVICE PLAN



AA
SERVICES PRIVATE LTD.

Aashirwad Architectural Services Pvt. Ltd.
Architects, Engineers, Interior Designers, Vastu Consultant
Office: 5/1, FLAT NO 5, ROOP NAGAR, DELHI-110007
Phone: 88713878, 88710771
Email: aashirwadarchitects@yahoo.com

SCALE	DEALT BY	CHECKED BY	DATE	DRI. NO.
NTS				SD-01A