


ROAD AS WELL.

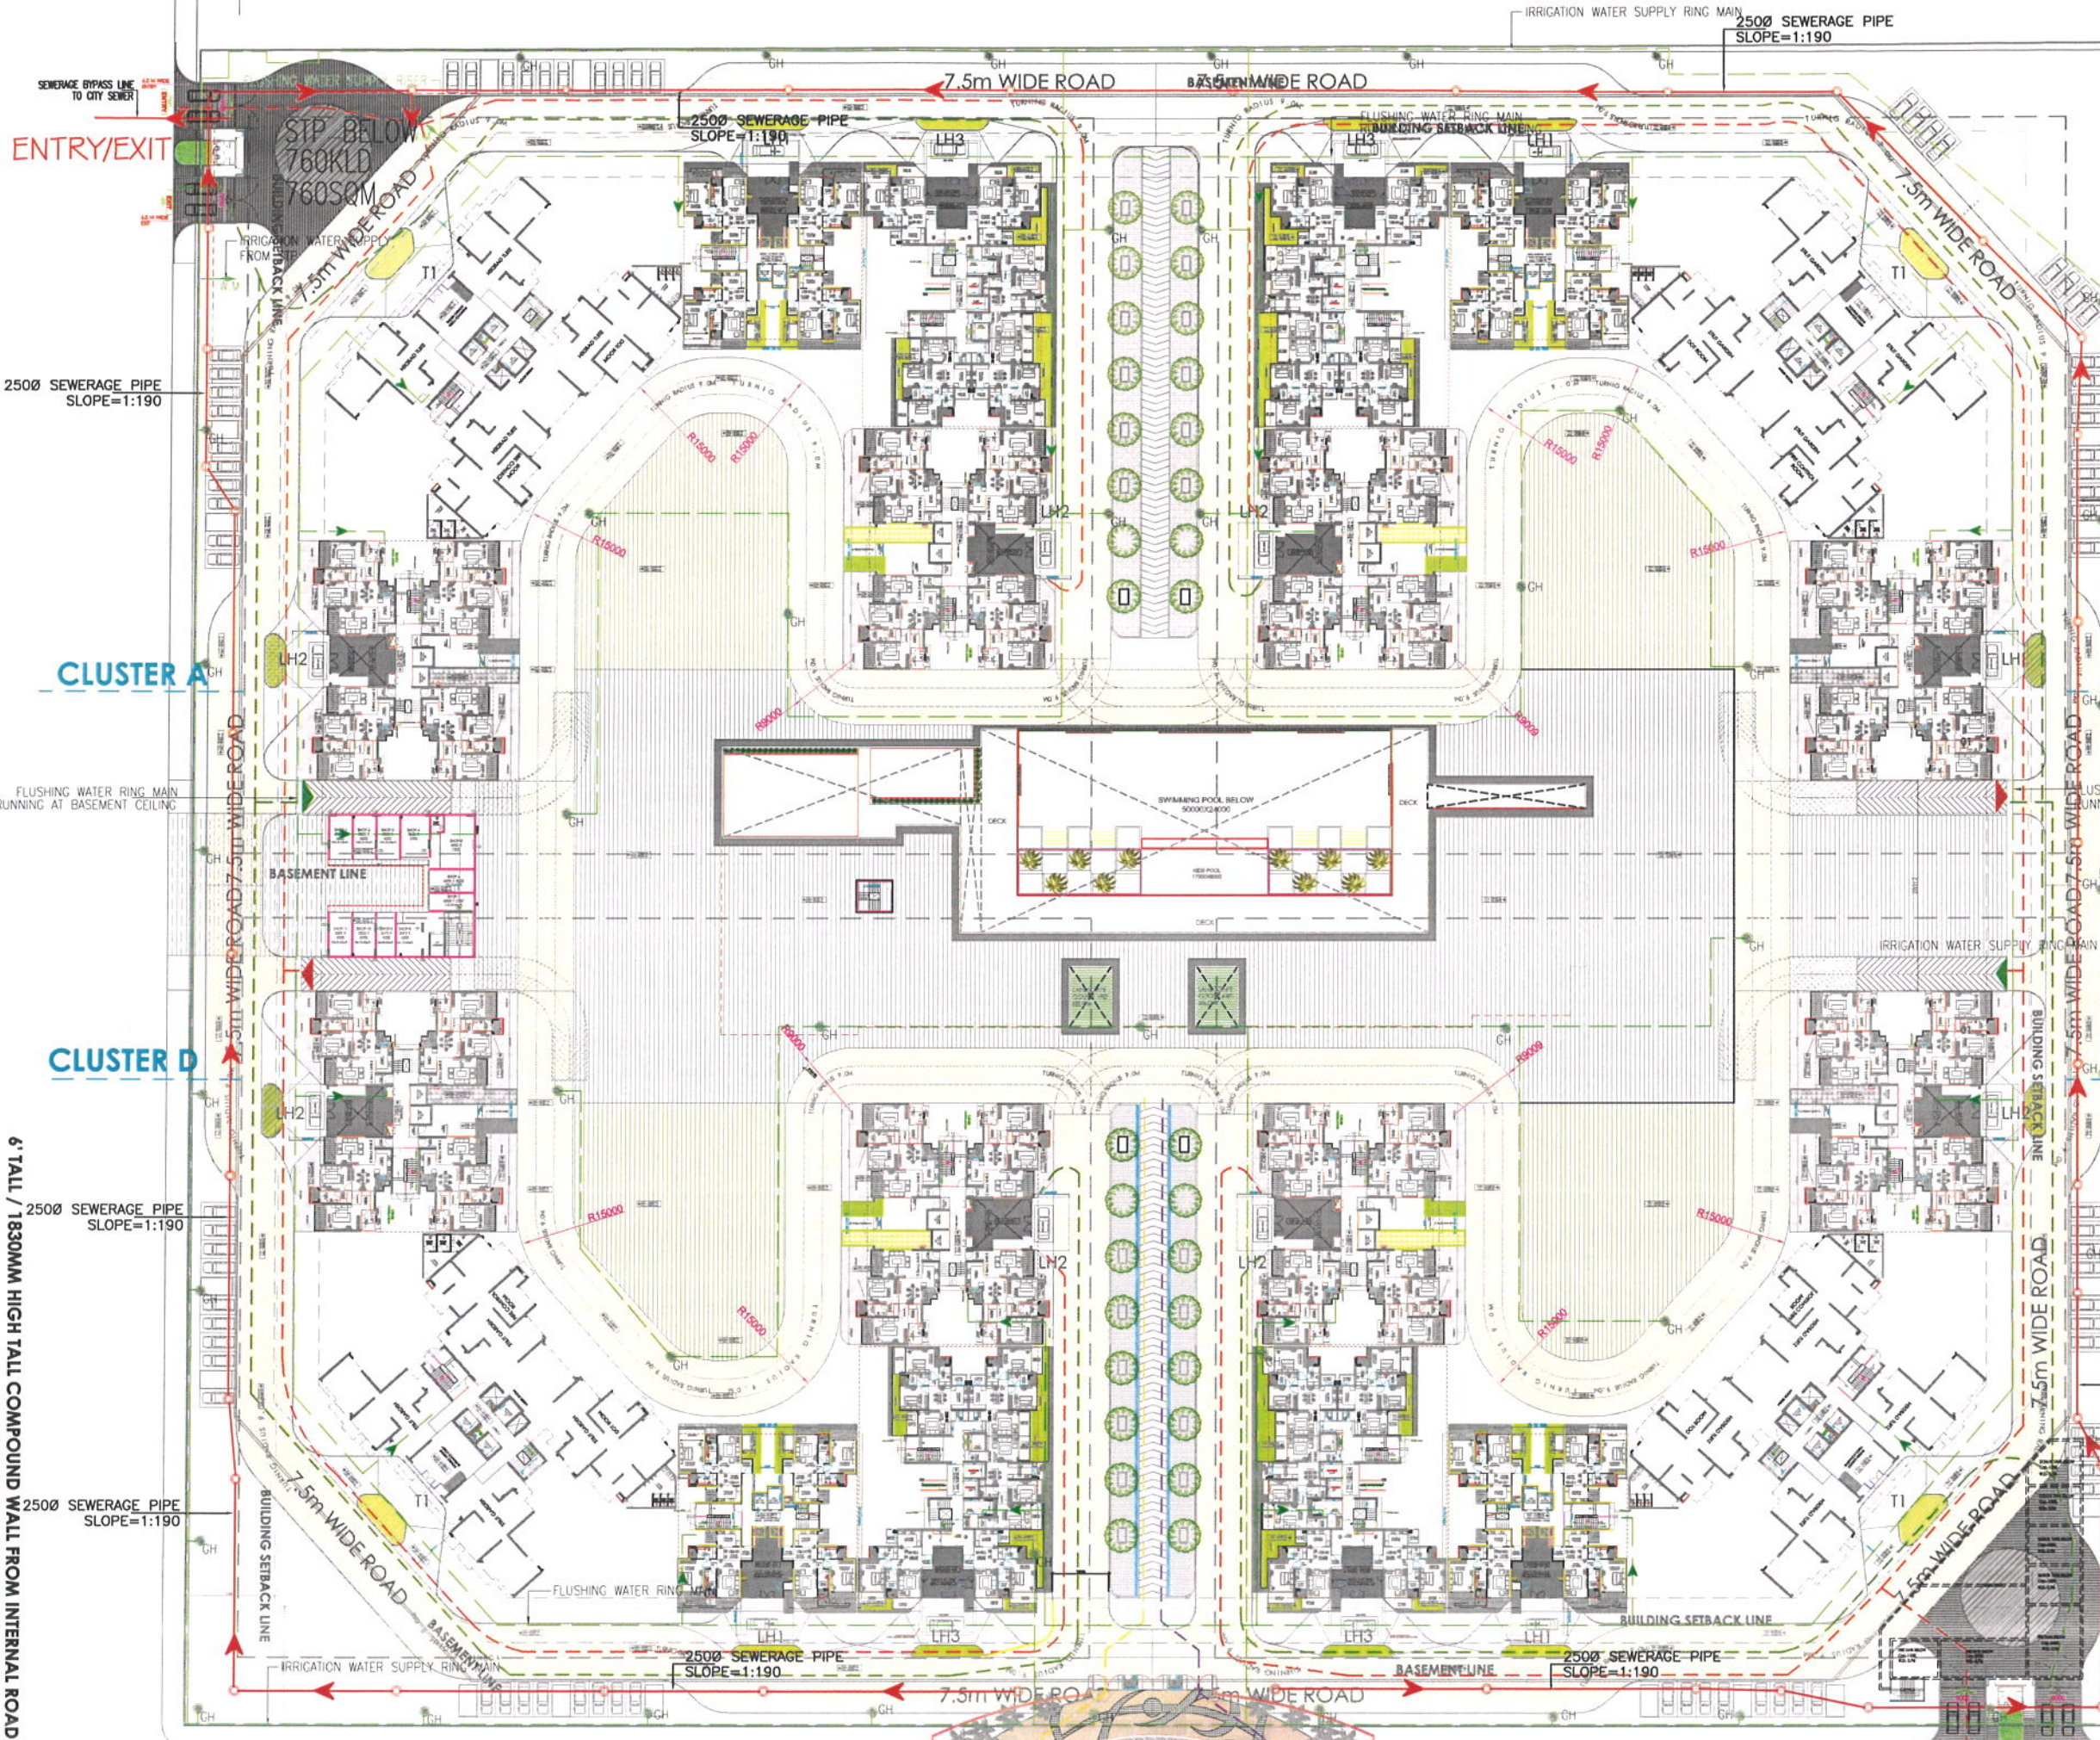

	SEWERAGE MANHOLE
	SEWERAGE PIPE

LEGEND GARDEN HYDRANT

DESCRIPTION	SYMBOL
GARDEN HYDRANT WATER SUPPLY PIPE	
GARDEN HYDRANT	
WATER METER	
FLUSHING WATER SUPPLY RISER PIPE	

--PHA

CLUSTER B

CLUSTER C

--PHA

2500 SEWERAGE PIPE
SLOPE=1:190

MEP CONSULTANT
SUNIL NAYYAR CONSULTING ENGINEERS LLP.
Head Office : 204, 204A & 305A-305B, 2nd & 3rd Floor,
Time Centre, DLF Golf Course Road,
Sector-54, Gurgaon-122002, Haryana (India)
Tele : +91-124-4803800 (30 Lines)
Fax : +91-124-4803817
E-mail : sncgurgaon@snc.co.in
URL : www.snc.co.in

SUBMISSION
DRAWINGS

PROJECT TITLE
M/S ACE INFRASTRUCTURE DEVELOPERS PVT. LTD.
PLOT NO. -SC-02F
SEC 150,
NOIDA-201301

SHEET TITLE

DUAL PLUMBING LAYOUT

OWNER'S SIGN ARCHITECT'S SIGN

DRAWN BY : ASIT CHECKED BY : MS DWG.NO. :

6' TALL / 1830MM HIGH TALL COMPOUND WALL FROM INTERNAL ROAD FFL

DUAL PLUMBING SITE PLAN

ENTRY/EXIT