

OTHERS PLOT

24M WIDE INTERNAL ROAD

DELHI


JAYPEE GREENS INTERNAL ROAD

SULTANPUR VILL.

OTHERS PLOT

PARI CHOWK

SITE LAYOUT PLAN

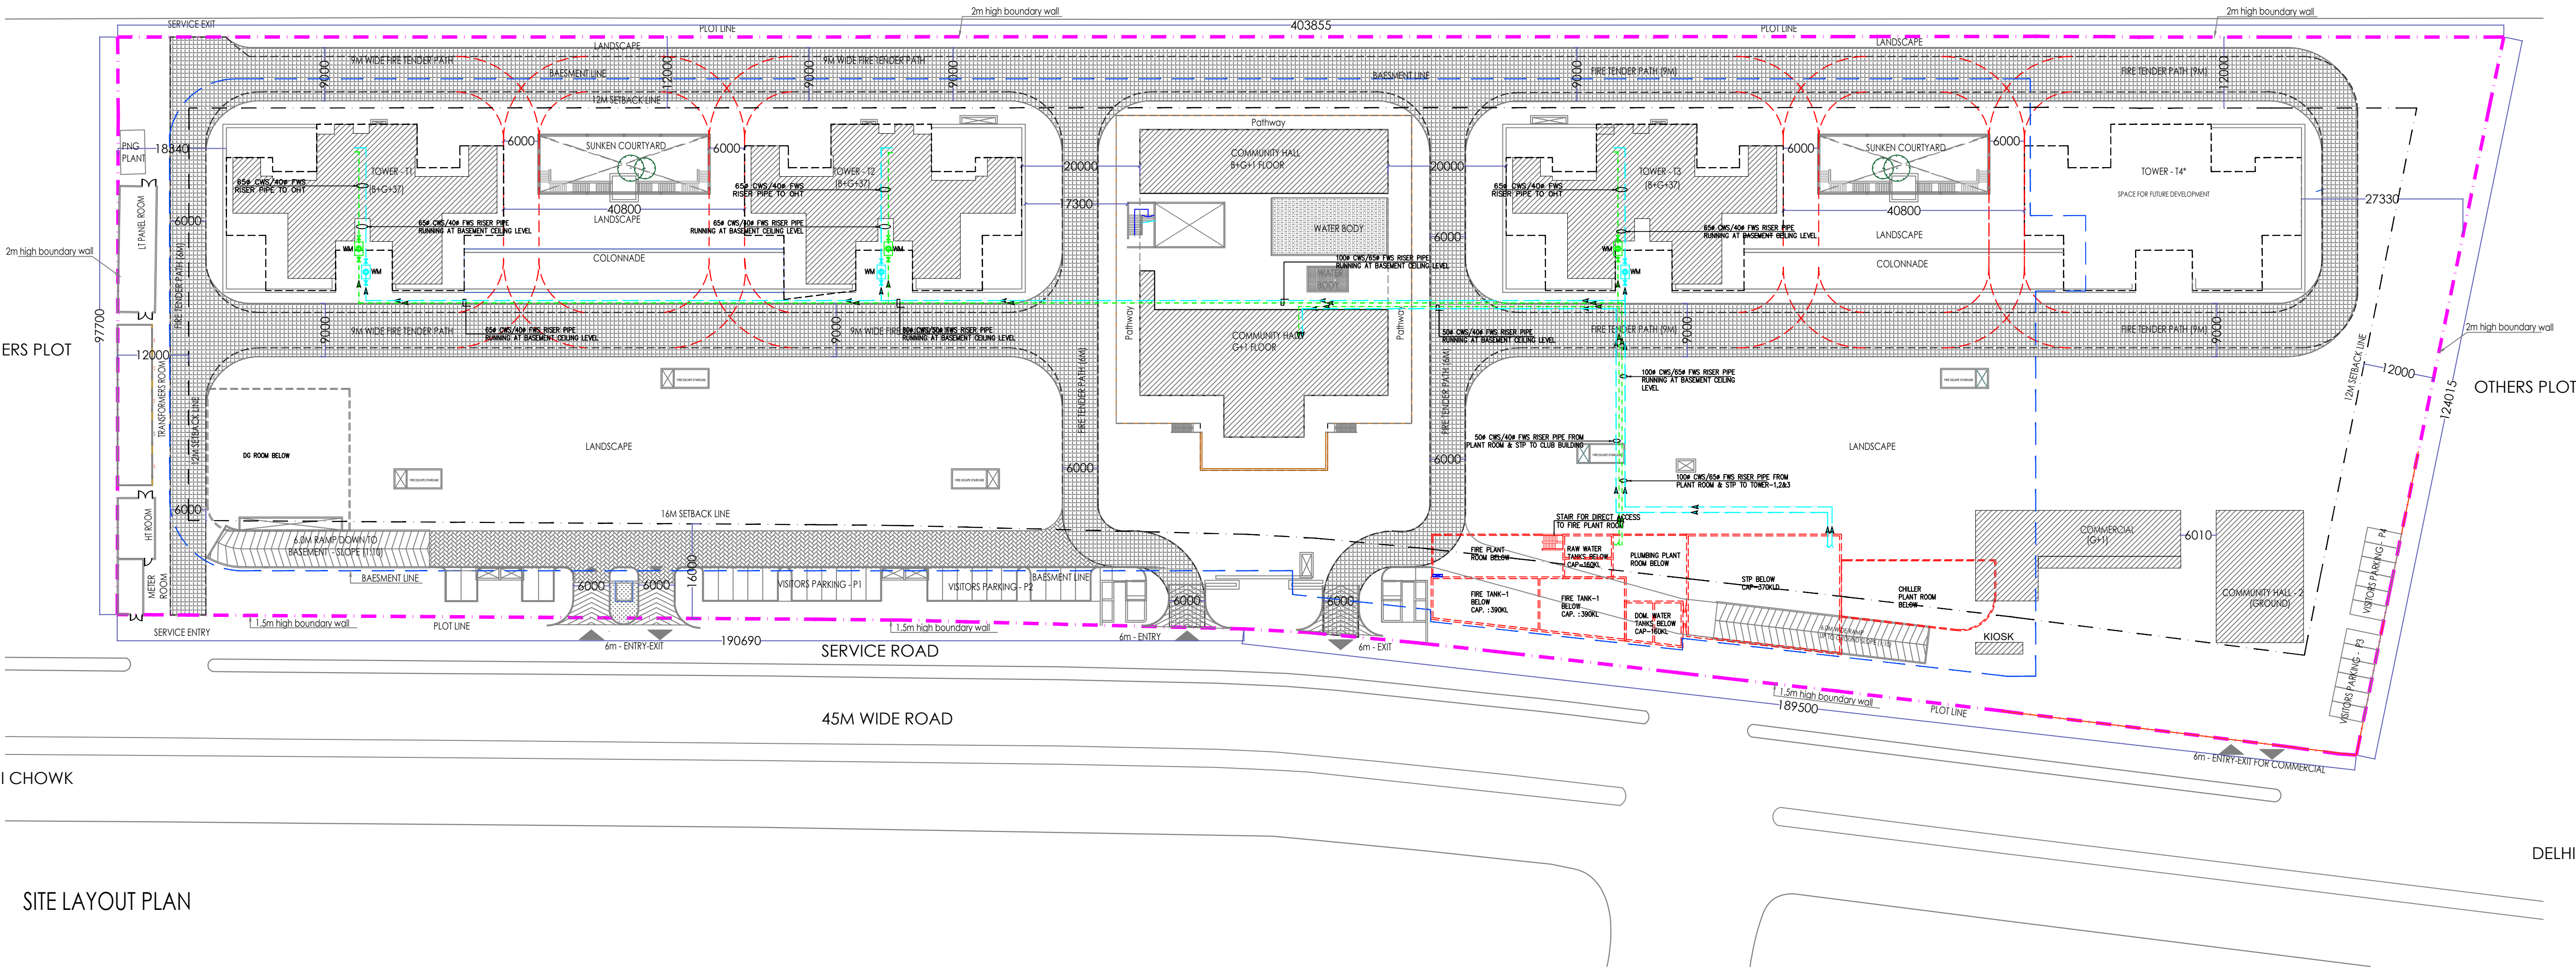

LEGEND FOR WATER SUPPLY

DESCRIPTION	SYMBOL
DOMESTIC WATER SUPPLY PIPE	
FLUSHING WATER SUPPLY PIPE	
WATER METER	WM
VALVE	
VALVE CHAMBER	

NOTE:
*Future development of Group Housing is subject to FAR being available on purchasable basis as and when approved by the relevant competent authority or government
**The Floor above 12th Level in the Project has been marked as 14th Floor and not as 13th Floor

NOTES

ALL DIMENSIONS ARE IN MILLIMETERS AND ALL LEVELS ARE IN METER UNL0
THIS DRAWING IS TO BE READ AND NOT SCALED.
THIS DRAWING IS A COPYRIGHT AND PROPERTY OF THE OWNER.
IS NOT TO BE PRODUCED, COPIED, HANDED OVER TO THIRD PARTY OR
USED FOR ANY OTHER PURPOSE OTHER THAN FOR WHICH IT IS INTENDED.

STATUTORY APPROVAL

ISSUE DESCRIPTION

Project No. 22106
First Issue date --

REVISION DESCRIPTION

No.	Date	Description

DESIGN CONSULTANT
studiolotus
F-301, First Floor, Lado- Sarai, Ch. Prem Singh House,
New Delhi - 110030
Phone + 91 11 4057 0808, + 91 11 4052 7979

ASSOCIATE DESIGN CONSULTANT
RSP
RSP Design Consultants Pvt. Ltd.
Unit 103, Bestech Business Tower, Sector-48
Sohna Road, Gurgaon-122018
Head Office: No 30, Museum Road, Bangalore - 560001
Tel: 25509880 Fax: 25509810
Email: rsp@rspindia.net, Web: www.rspindia.net

STRUCTURAL CONSULTANT
MELIOR
#2174/2, Sector 38C, Chandigarh - 160014
Tel : (120) 2544084, 85, 86, 87
E-mail : Projects@civiltech.in

MEP CONSULTANT
Proion
Proion Consultants Private Limited
Building Services - MEP Consulting
82, Sukhdev Vihar, New Delhi 110 025, India.
Tel: 011 26324400, E-mail : www.proion.net

LANDSCAPE CONSULTANT

ORACLES LANDSCAPE
G-98, GROUND FLOOR, KALKAJI, NEW DELHI, DELHI 110019

SHEET TITLE

SITE PLAN
WATER SUPPLY LAYOUT

DEVELOPER

M/S MAX ESTATES 128 PRIVATE LIMITED
(Formerly ACCORD HOTELS AND RESORT
PRIVATE LIMITED).

PROJECT

PROPOSED GROUP HOUSING AT PLOT
NO.-TS-02, AT JAYPEE WISH TOWN,
SECTOR-128 NOIDA (UP).

DRAWING NUMBER
SITE (WATER SUPPLY)

SCALE

REVISION



FILENAME: D:\MAX ESTATES PROJECT\MAX SECTOR 128\002\WYNA
REVISED_MAX128_ECC.DWG
LOGINNAME: DMC TO PDF.PCS
PLOTTER: DMC TO PDF.PCS
PLOT SIZE: DMC TO PDF.PCS
PLOT STYLE: DMC TO PDF.PCS
PLOT DATE: 2023/05/10