

E.S.S.-8
(2 D.G. SET & 2 TRANSFORMERS)

E.S.S.-5
(2 D.G. SET & 2 TRANSFORMERS)

E.S.S.-6
(3 D.G. SET & 2 TRANSFORMERS)

E.S.S.-1
(3 D.G. SET & 2 TRANSFORMERS)

E.S.S.-7
(2 D.G. SET & 2 TRANSFORMERS)


E.S.S.-4
(2 D.G. SET & 2 TRANSFORMERS)

E.S.S.-3
(2 D.G. SET & 2 TRANSFORMERS)

E.S.S.-2
(2 D.G. SET & 2 TRANSFORMERS)

DRAINAGE LEGENDS:-

1. DRAINAGE LINE	
2. DRAINAGE MANHOLE	
3. RECHARGE WELL	

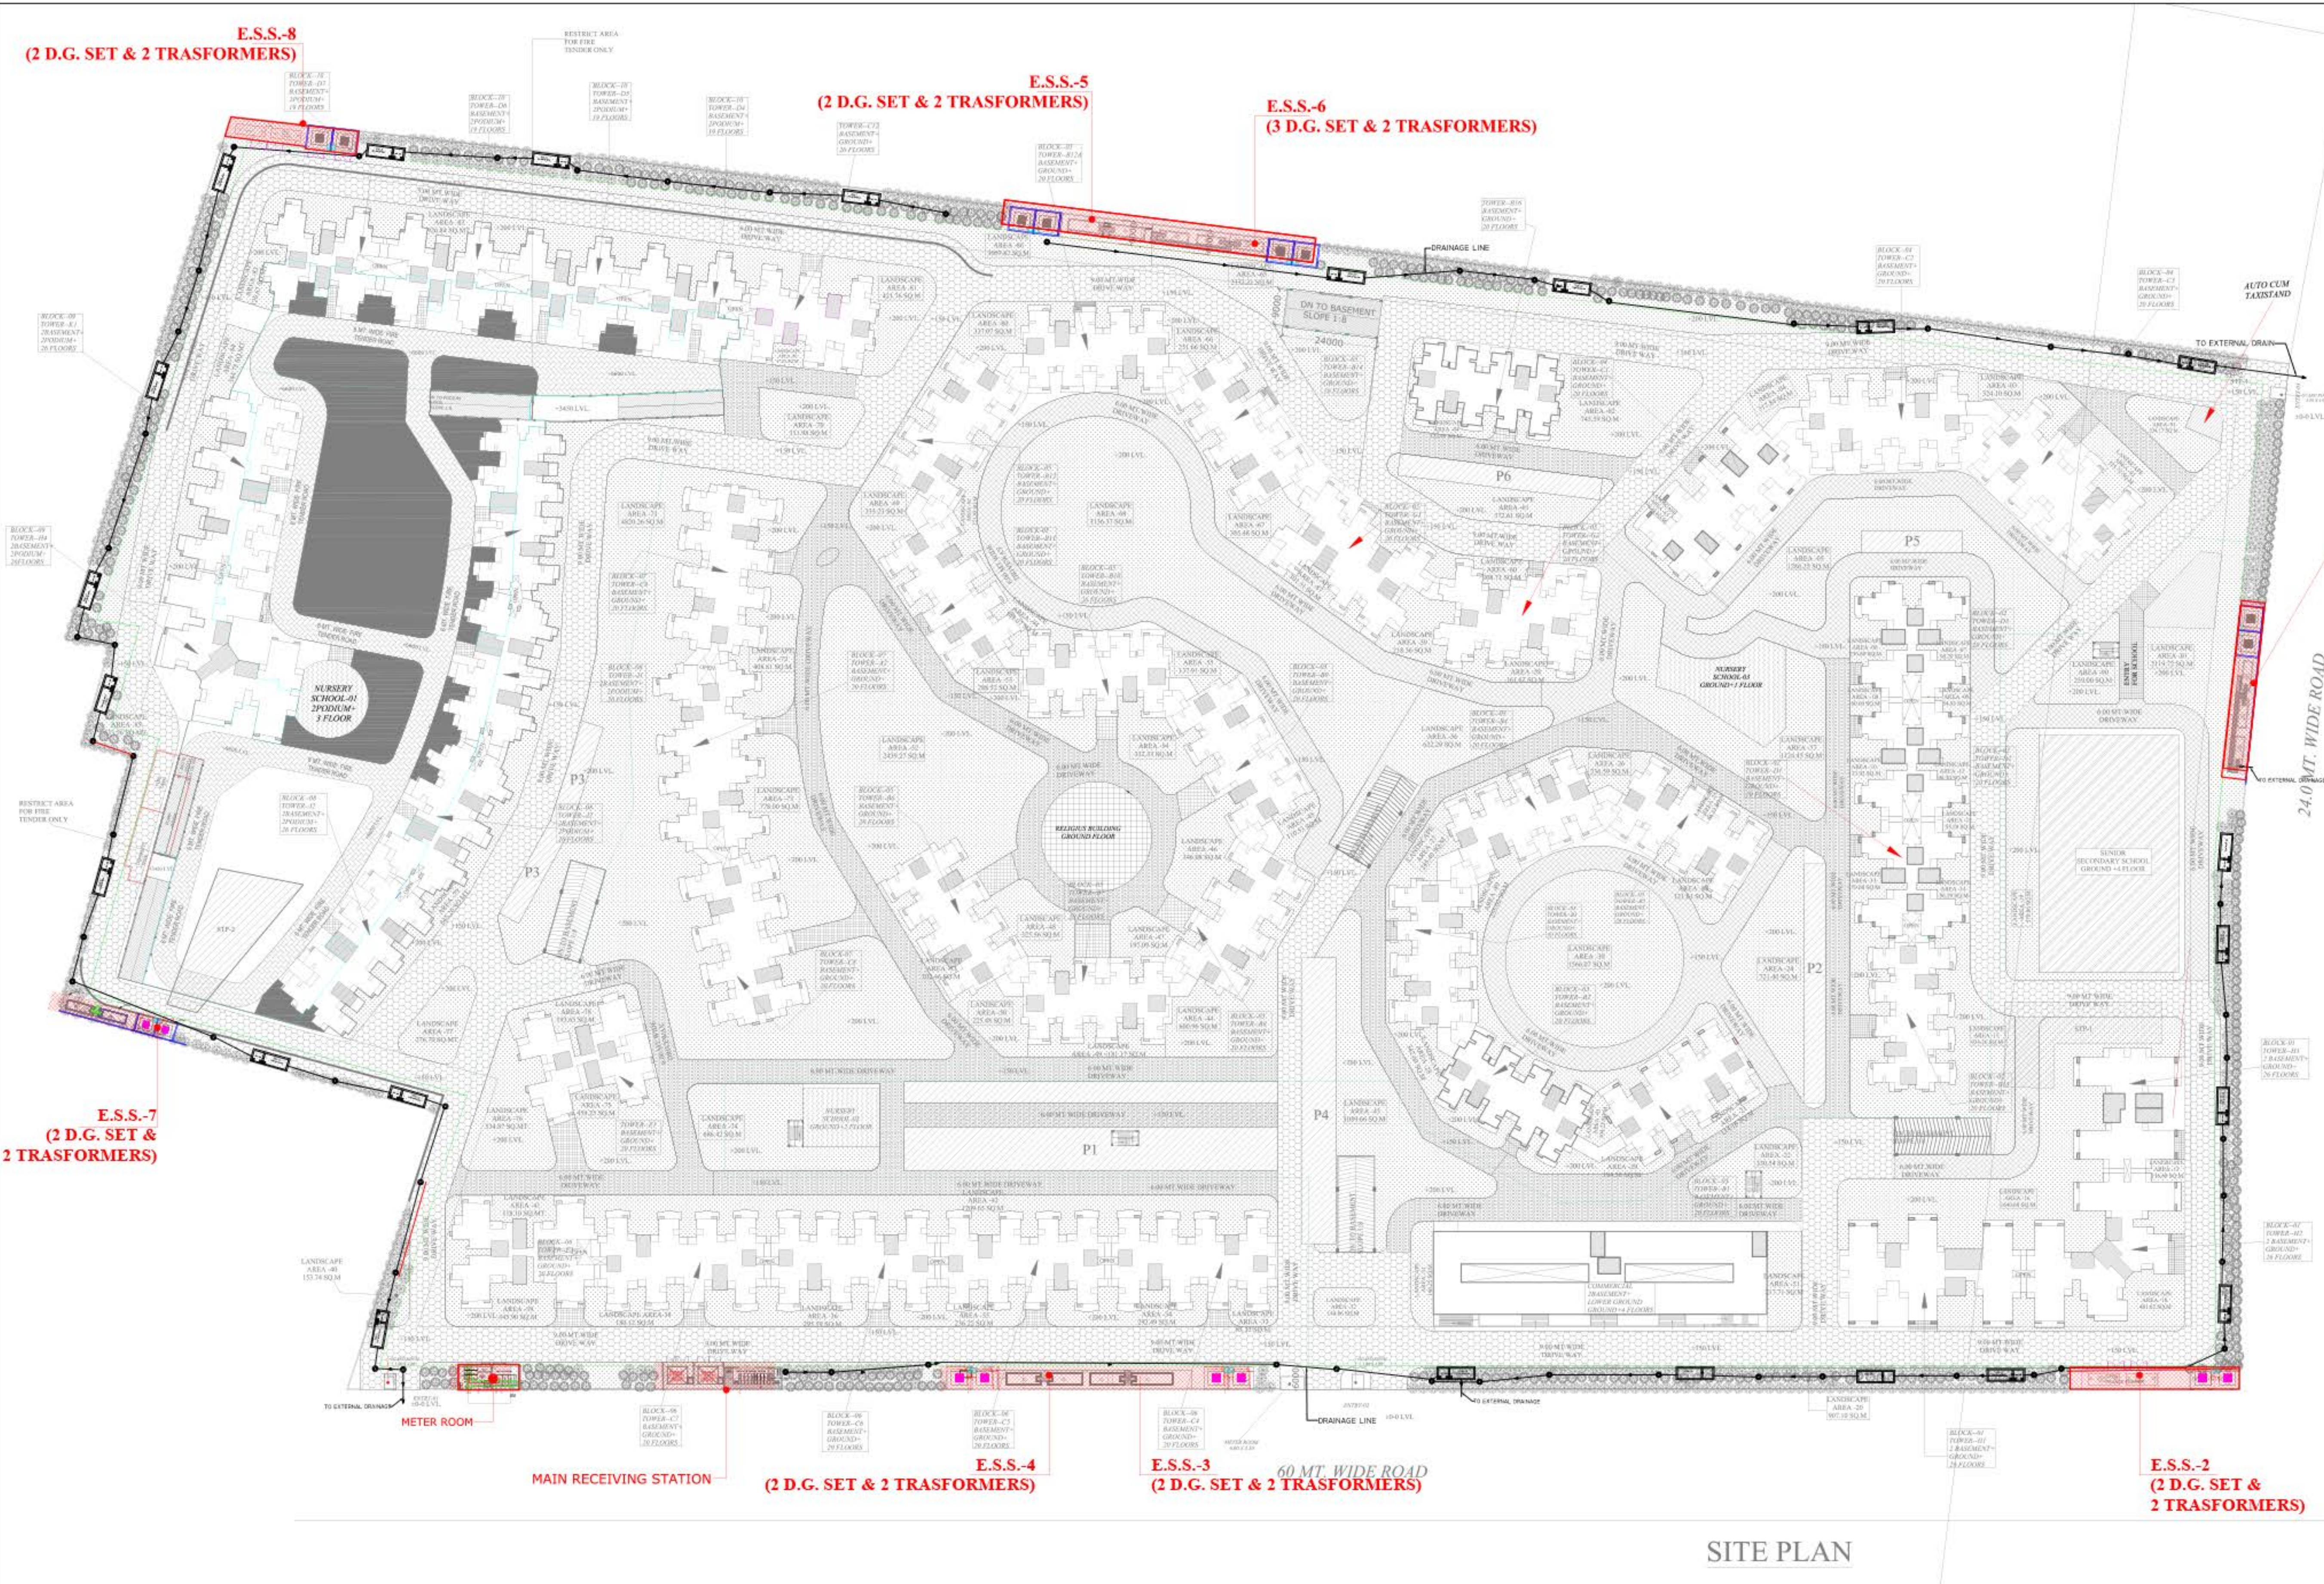

SITE PLAN

**PROJECT :- ECO VILLAGE - II
PROPOSED RESIDENTIAL COMPLEX
AT PLOT NO - GH - 01, SEC- 16B,
GREATER NOIDA (U.P)**

**BUILDERS & PROMOTER :-
M/s SUPERTECH LTD.
ADD. - B-28, 29 SECTOR-58
NOIDA - 201307**

DRAWING TITLE :-

ELECTRIC SUPPLY PLAN

**ARCHITECTS :-
Space Designers International
Architects Pvt. Ltd.
5 / 1306, VASUNDHARA, GHAZIABAD
PH. 0120-225214, 981010399, 981013424
architects & planners e-mail: spacesdi@gmail.com, www.spacesdi.com**

PLUMBING & FIRE FIGHTING CONSULTANTS :-

PEE CONSULTANTS
815-C, EAST OF LONI ROAD
SHAHADRA, DELHI-110093
PH: 011-22816297, 22815897
EMAIL: pdss_in@yahoo.com, nrcons@gmail.com

DRAWN BY :- DEEPAK **CHECKED BY :-** DINESH **SCALE** 1: 800 **DATE** 01-07-18

OWNER'S SIGN

**ARCHITECT'S SIGN
DRG. NO. - 02**