


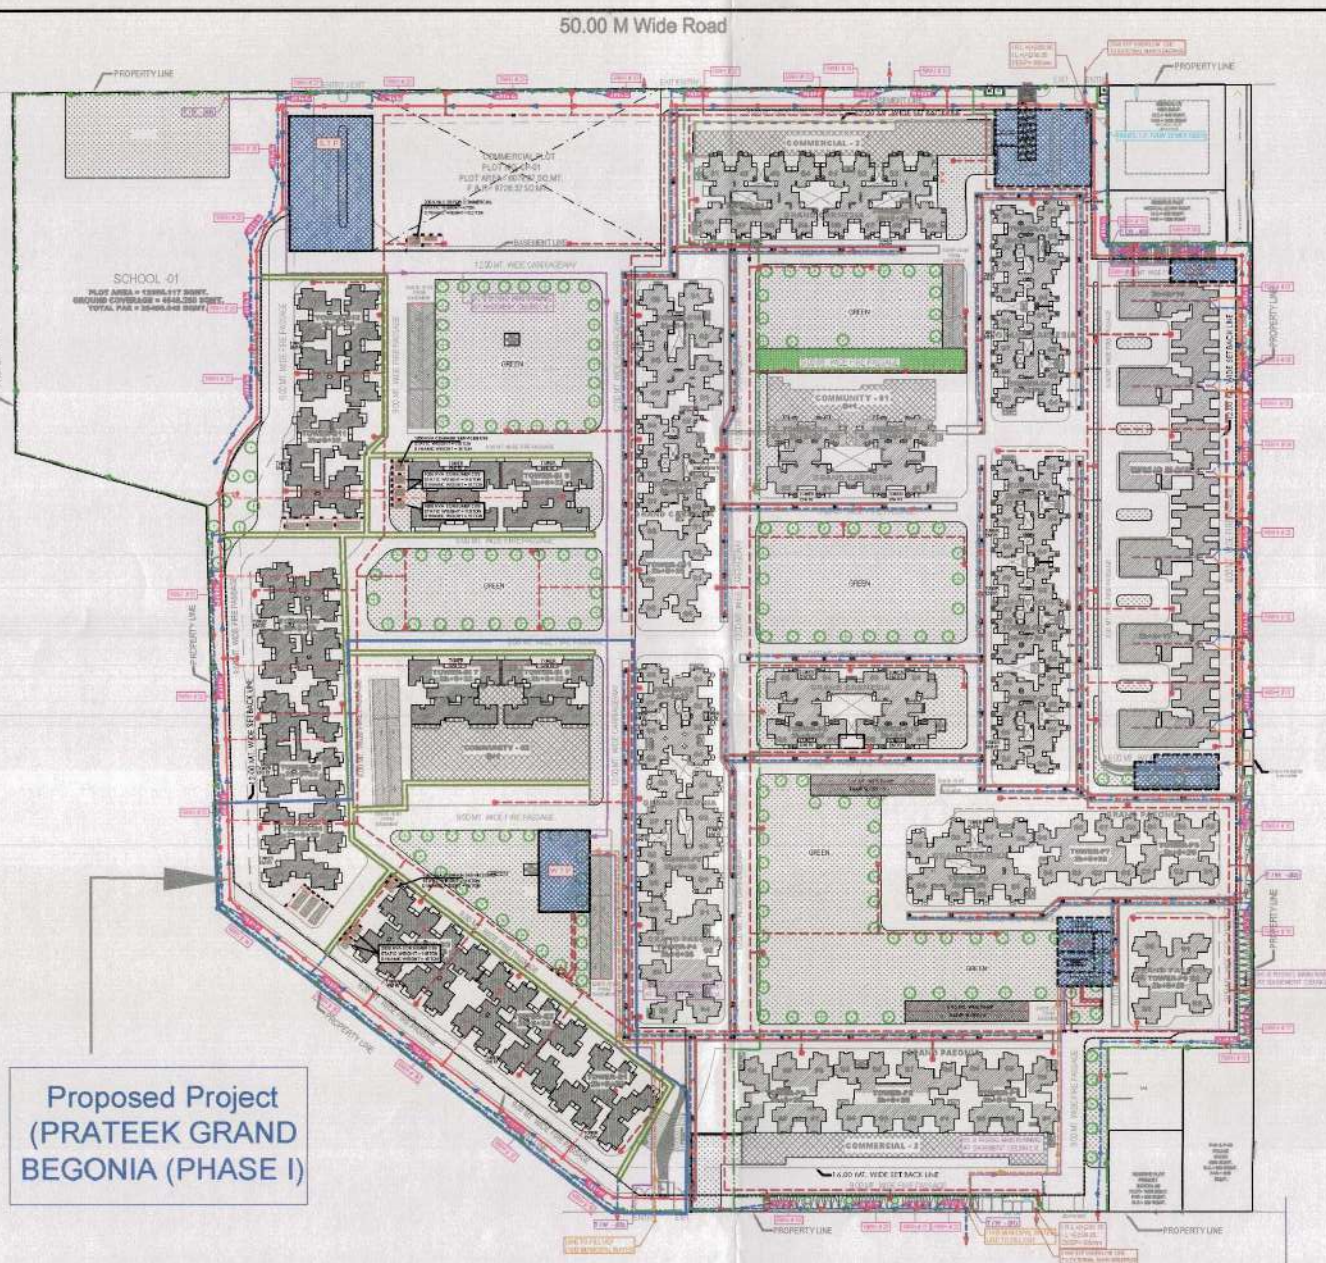

Proposed Project
(PRATEEK GRAND
BEGONIA (PHASE I))

LEGEND :

S. No.	SYMBOL	DESCRIPTION
1.	MH	MANHOLE
2.	WATER LINE	WATER LINE
3.	SEWER LINE (DW)	SEWER LINE (DW)
4.	C.P. / P.T.	CATCH PITS
5.	SPRINKLER CIRCULATING PIPE	SPRINKLER CIRCULATING PIPE
6.	RAIN WATER HARVESTING	RAIN WATER HARVESTING
7.	STORMWATER DRAIN	STORMWATER DRAIN
8.	RECYCLED WATER SUPPLY LINE FOR REUSE	RECYCLED WATER SUPPLY LINE FOR REUSE
9.	RECYCLED WATER SUPPLY LINE FOR REUSE	RECYCLED WATER SUPPLY LINE FOR REUSE
10.	PROPOSED FIREWELL	PROPOSED FIREWELL
11.	CH	CHAMBER
12.	MASQUITY CHAMBER FOR ISOLATION	MASQUITY CHAMBER FOR ISOLATION
13.	BASEMENT RETAINMENT WALL	BASEMENT RETAINMENT WALL

LEGEND - FIRE SYSTEM

S. No.	SYMBOL	DESCRIPTION
1.	FIRE LINE	FIRE LINE
2.	YH	YARD HYDRANT
3.	FIRE SUPPLY CONNECTION	FIRE SUPPLY CONNECTION
4.	BATTERY VALVE	BATTERY VALVE
5.	ISOLATION VALVE WITH CHECK VALVE	ISOLATION VALVE WITH CHECK VALVE
6.	ISOLATION VALVE WITH MASQUITY CHAMBER	ISOLATION VALVE WITH MASQUITY CHAMBER

ALL YARD HYDRANT SHALL BE CONNECTED FROM BASEMENT HYDRANT PIPE

For Prateek Realtors India Pvt. Ltd.

Authorised Signatory

Rev. No.	Date	Revision

Project: **PRATEEK GRAND CITY**
SIDHARTH VIHAR, GHAZIABAD

Title: **SITE PLAN**

Sub Title: **EXTERNAL COORDINATED LAYOUT**

Drawing released for:
☐ APPROVAL ☒ SUBMISSION
☐ ADVANCE COPY ☐ CONSTRUCTION

Fig. No. POC/SP/PL-04 Drawn by: S. Prasad

Scale: 1:500 @ A1 Designed by: Shakti Shakti

Date: 02.05.2022 Checked by: ANAND HAVELA

Architects: **Architect Hafeez Contractor**
28, South Street, Bombay 400 001, Tel: 415 22 2241/1000 Fax: 415 22 2241/1001
www.architecthafeezcontractor.com email: hafeez@architecthafeez.com

Services consultant: **Consummate Engineering Services (P) Ltd.**
B-10, Sector 10, Gurgaon, Haryana 122 002, Tel: 0124-2610000 (20 Lines)
Fax: 0124-2610001 (20 Lines)
E-mail: info@cesp.com, sales@cesp.com, web@cesp.com