
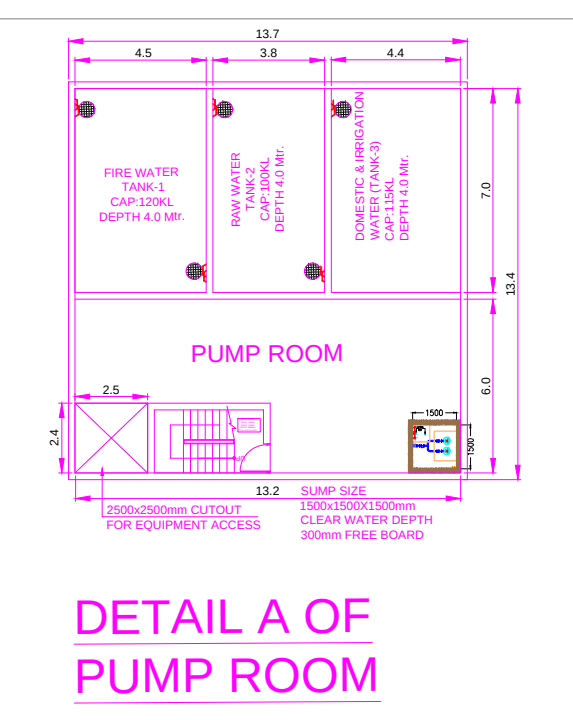


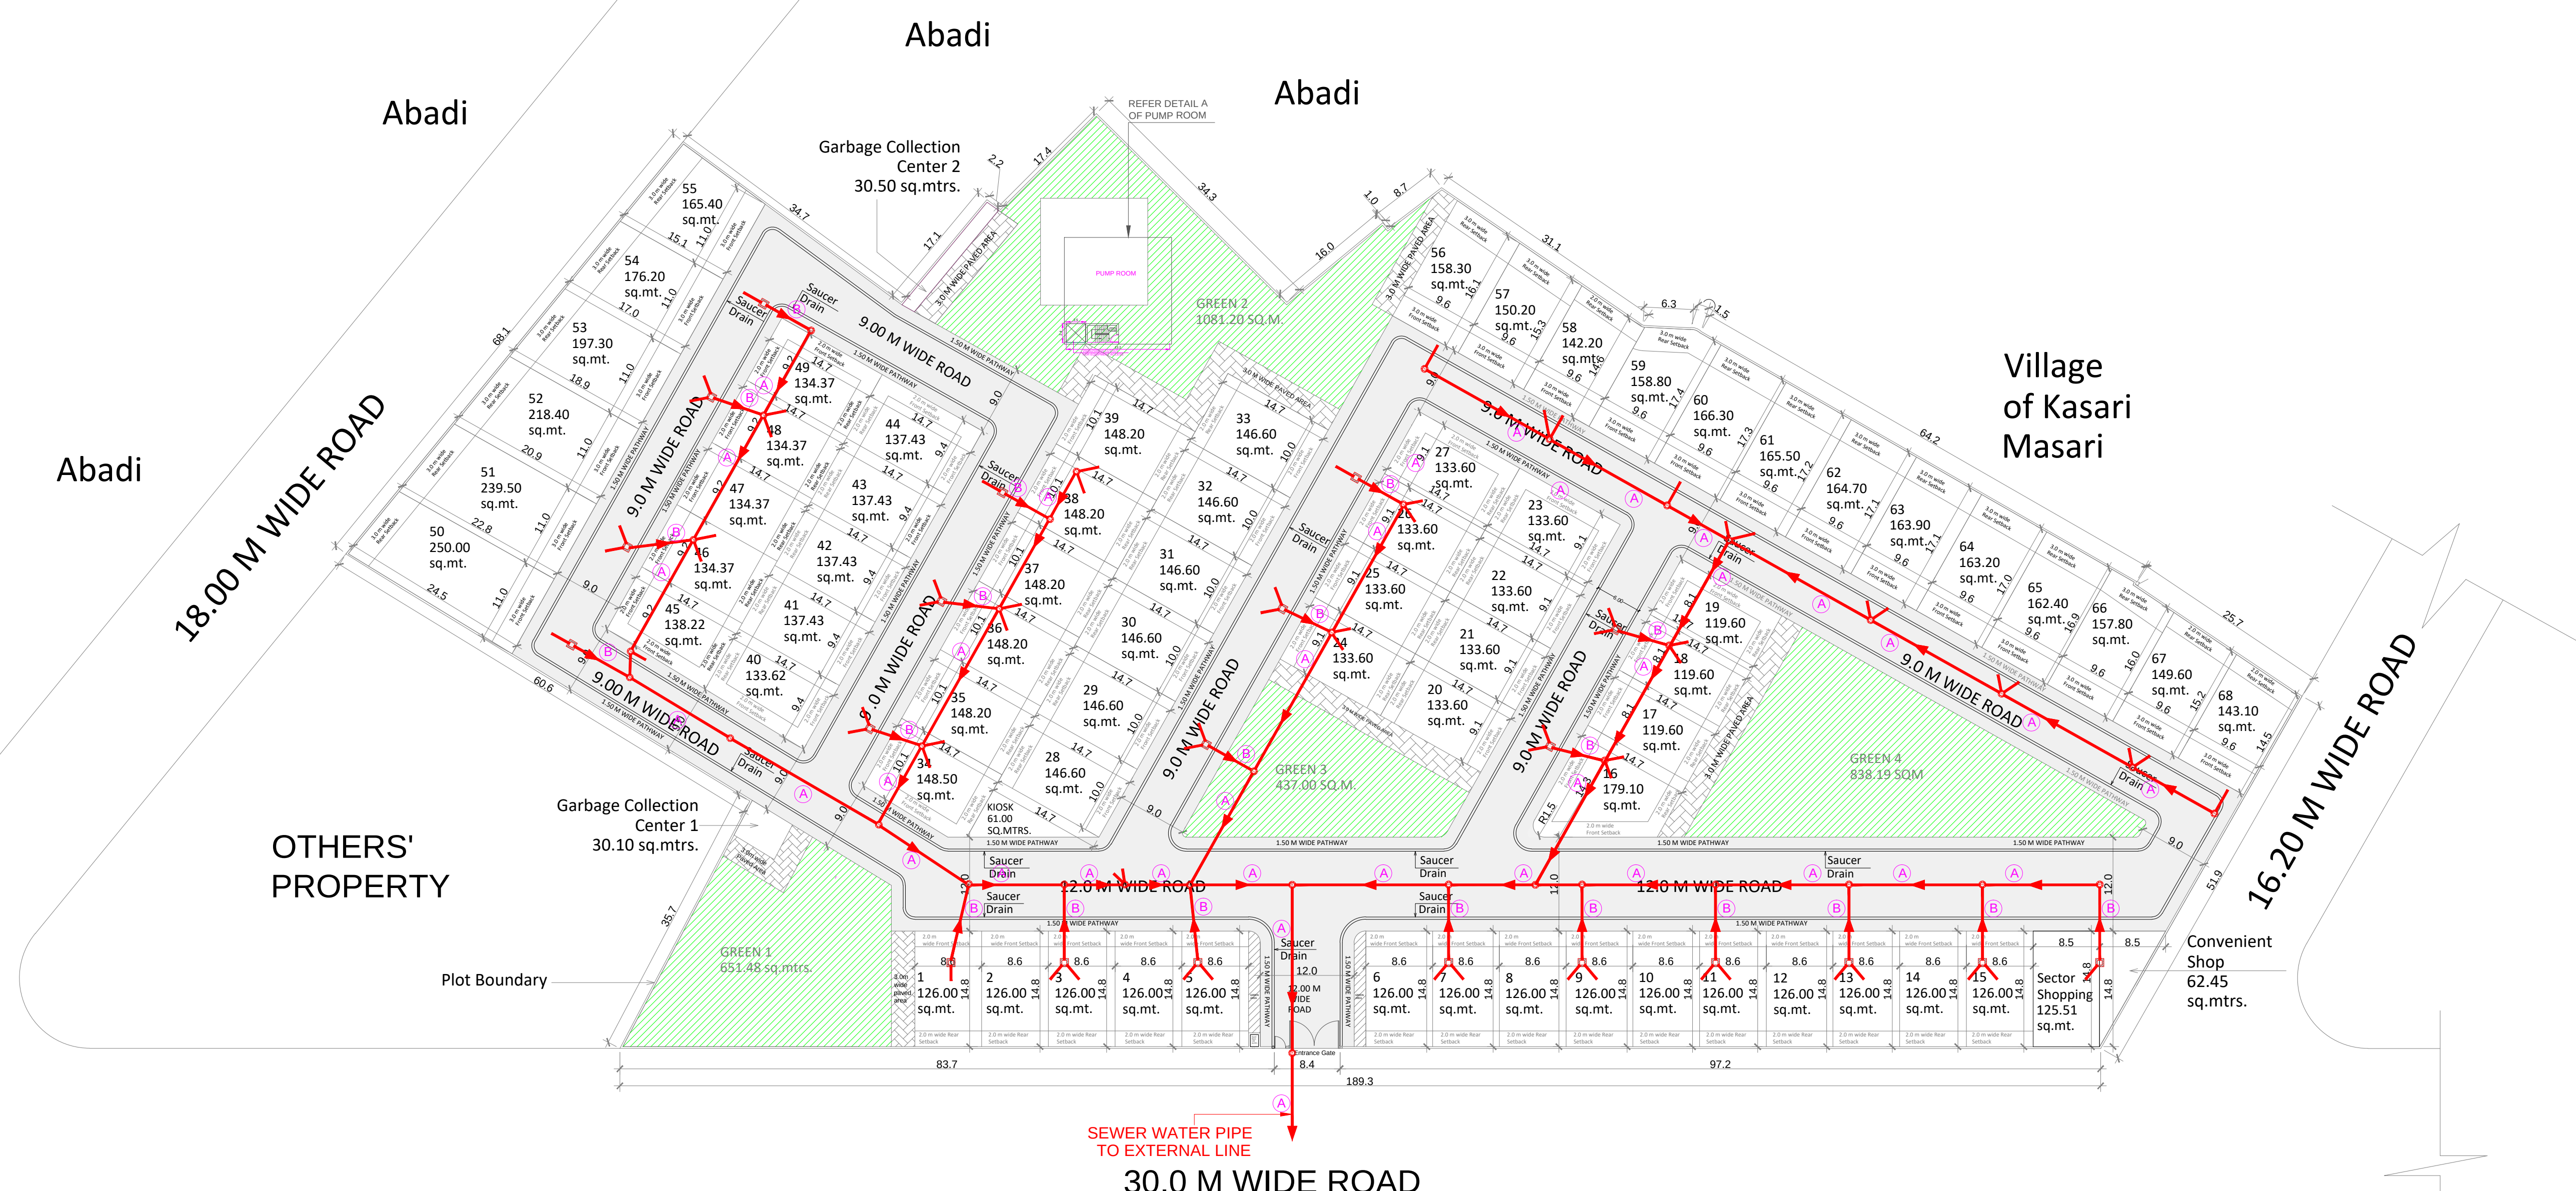

PLUMBING SEWER			
Ⓐ	200ϕ SEWER PIPE	1:150MM SLOPE	——
Ⓑ	150ϕ SEWER PIPE	1:100MM SLOPE	——
PLUMBING LEGENDS:-			
SEWER WATER LINE			→
SEWER MANHOLE			⊙

Project Title :

Plotted Development for Army Welfare Housing Organisation(A.W.H.O.),
at Sector IRW, Pocket -A Kalindipuram Awas Yojna, Kasari Masari, Prayagraj

JOB TITLE:

Plotting

DRG. TITLE:

SEWER LAYOUT

SCALE

DATE

DEALT BY

NORTH

-

03.02.2023

UPENDRA

DRG. NO.

AWHO/WD/PL/-02

ARCHITECT

AR. AJAI BEHL

CONSULTANT:

CIVIL CONSULTANTS

ARCHITECTS, PLANNERS & INTERIOR DESIGNERS

003, GAURI APARTMENTS ,57 HILTON LANE,
MEERABAI MARG, LUCKNOW-226001

Ph. No: 0522-2209859, 4230613 Fax: 0522-2209241

E-mail: civilconsultants@yahoo.co.in

Website: www.civilconsultants.co.in