


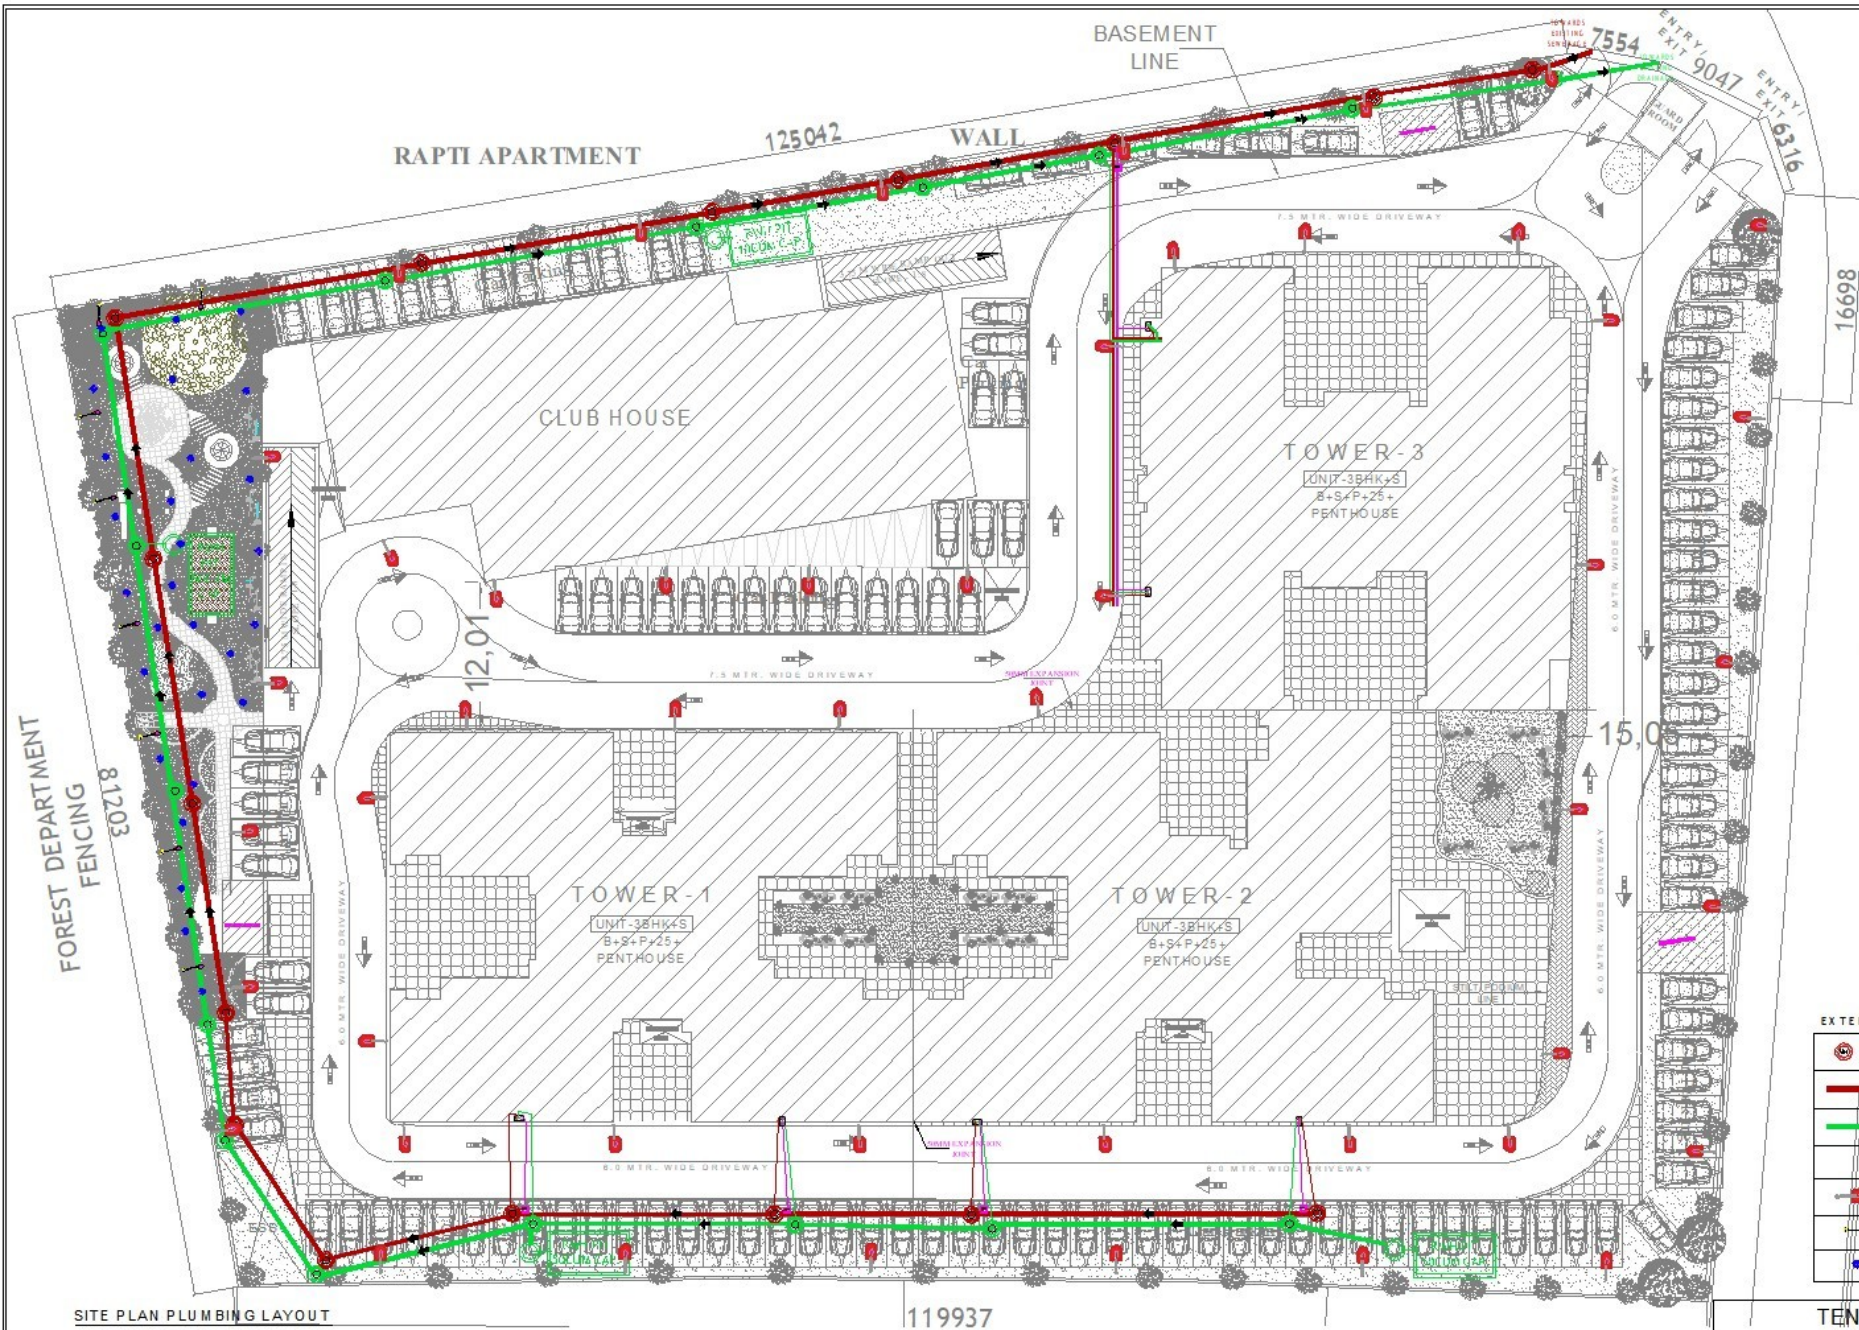

SITE PLAN PLUMBING LAYOUT

EXTERNAL LEGEND

	CIRCULAR MAN HOLE
	SEWERAGE PIPE - 3000
	RAIN WATER PIPE - 3000
LEGEND	
	STREET POLE LIGHT 3 MTR
	STREET POLE LIGHT 3 MTR
	BOLLARD LIGHT

TENDER DRAWING


ACT PLAN



25						25					
24						24					
23						23					
22						22					
21						21					
20	PRIYANKA	SR. AS/AN SINGH	Tender/Design			20					
19	DRAWN BY	DATE	APPROVED BY	DATE	STATUS	REMARK	19				
18							18				
17							17				
16							16				
15							15				
14							14				
13							13				
12							12				
11							11				
10							10				
9							9				
8							8				
7							7				
6							6				
5							5				
4							4				
3							3				
2							2				
1							1				

25						25					
24						24					
23						23					
22						22					
21						21					
20						20					
19						19					
18						18					
17						17					
16						16					
15						15					
14						14					
13						13					
12						12					
11						11					
10						10					
9						9					
8						8					
7						7					
6						6					
5						5					
4						4					
3						3					
2						2					
1						1					

25						25					
24						24					
23						23					
22						22					
21						21					
20						20					
19						19					
18						18					
17						17					
16						16					
15						15					
14						14					
13						13					
12						12					
11						11					
10						10					
9						9					
8						8					
7						7					
6						6					
5						5					
4						4					
3						3					
2						2					
1						1					

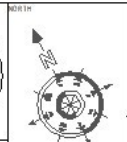

25						25					
24						24					
23						23					
22						22					
21						21					
20						20					
19						19					
18						18					
17						17					
16						16					
15						15					
14						14					
13						13					
12						12					
11						11					
10						10					
9						9					
8						8					
7						7					
6						6					
5						5					
4						4					
3						3					
2						2					
1						1					

25						25					
24						24					
23						23					
22						22					
21						21					
20						20					
19						19					
18						18					
17						17					
16						16					
15						15					
14						14					
13						13					
12						12					
11						11					
10						10					
9						9					
8						8					
7						7					
6						6					
5						5					
4						4					
3						3					
2						2					
1						1					

25						25					
24						24					
23						23					
22						22					
21						21					
20						20					
19						19					
18						18					
17						17					
16						16					
15						15					
14						14					
13						13					
12						12					
11						11					
10						10					
9						9					
8						8					
7						7					
6						6					
5						5					
4						4					
3						3					
2						2					
1						1					

25						25					
24						24					
23						23					
22						22					
21						21					
20						20					
19						19					
18						18					
17						17					
16						16					
15						15					
14						14					
13						13					
12						12					
11						11					
10						10					
9						9					
8						8					
7						7					
6						6					
5						5					
4						4					
3						3					
2						2					
1						1					

PROJ ACT TITLE : PROPOSED GROUP HOUSING, of Narmada Apartment at Sector-4, Gomti Nagar Extension, Lucknow.									
DRAWING TITLE: PLUMBING LAYOUT									
SITE SERVICES MARKING PLAN									
DRAWING NO. : 0825478-RG-01-TD(SRS)-00P01									
REV									
NOV21									
041									
01									