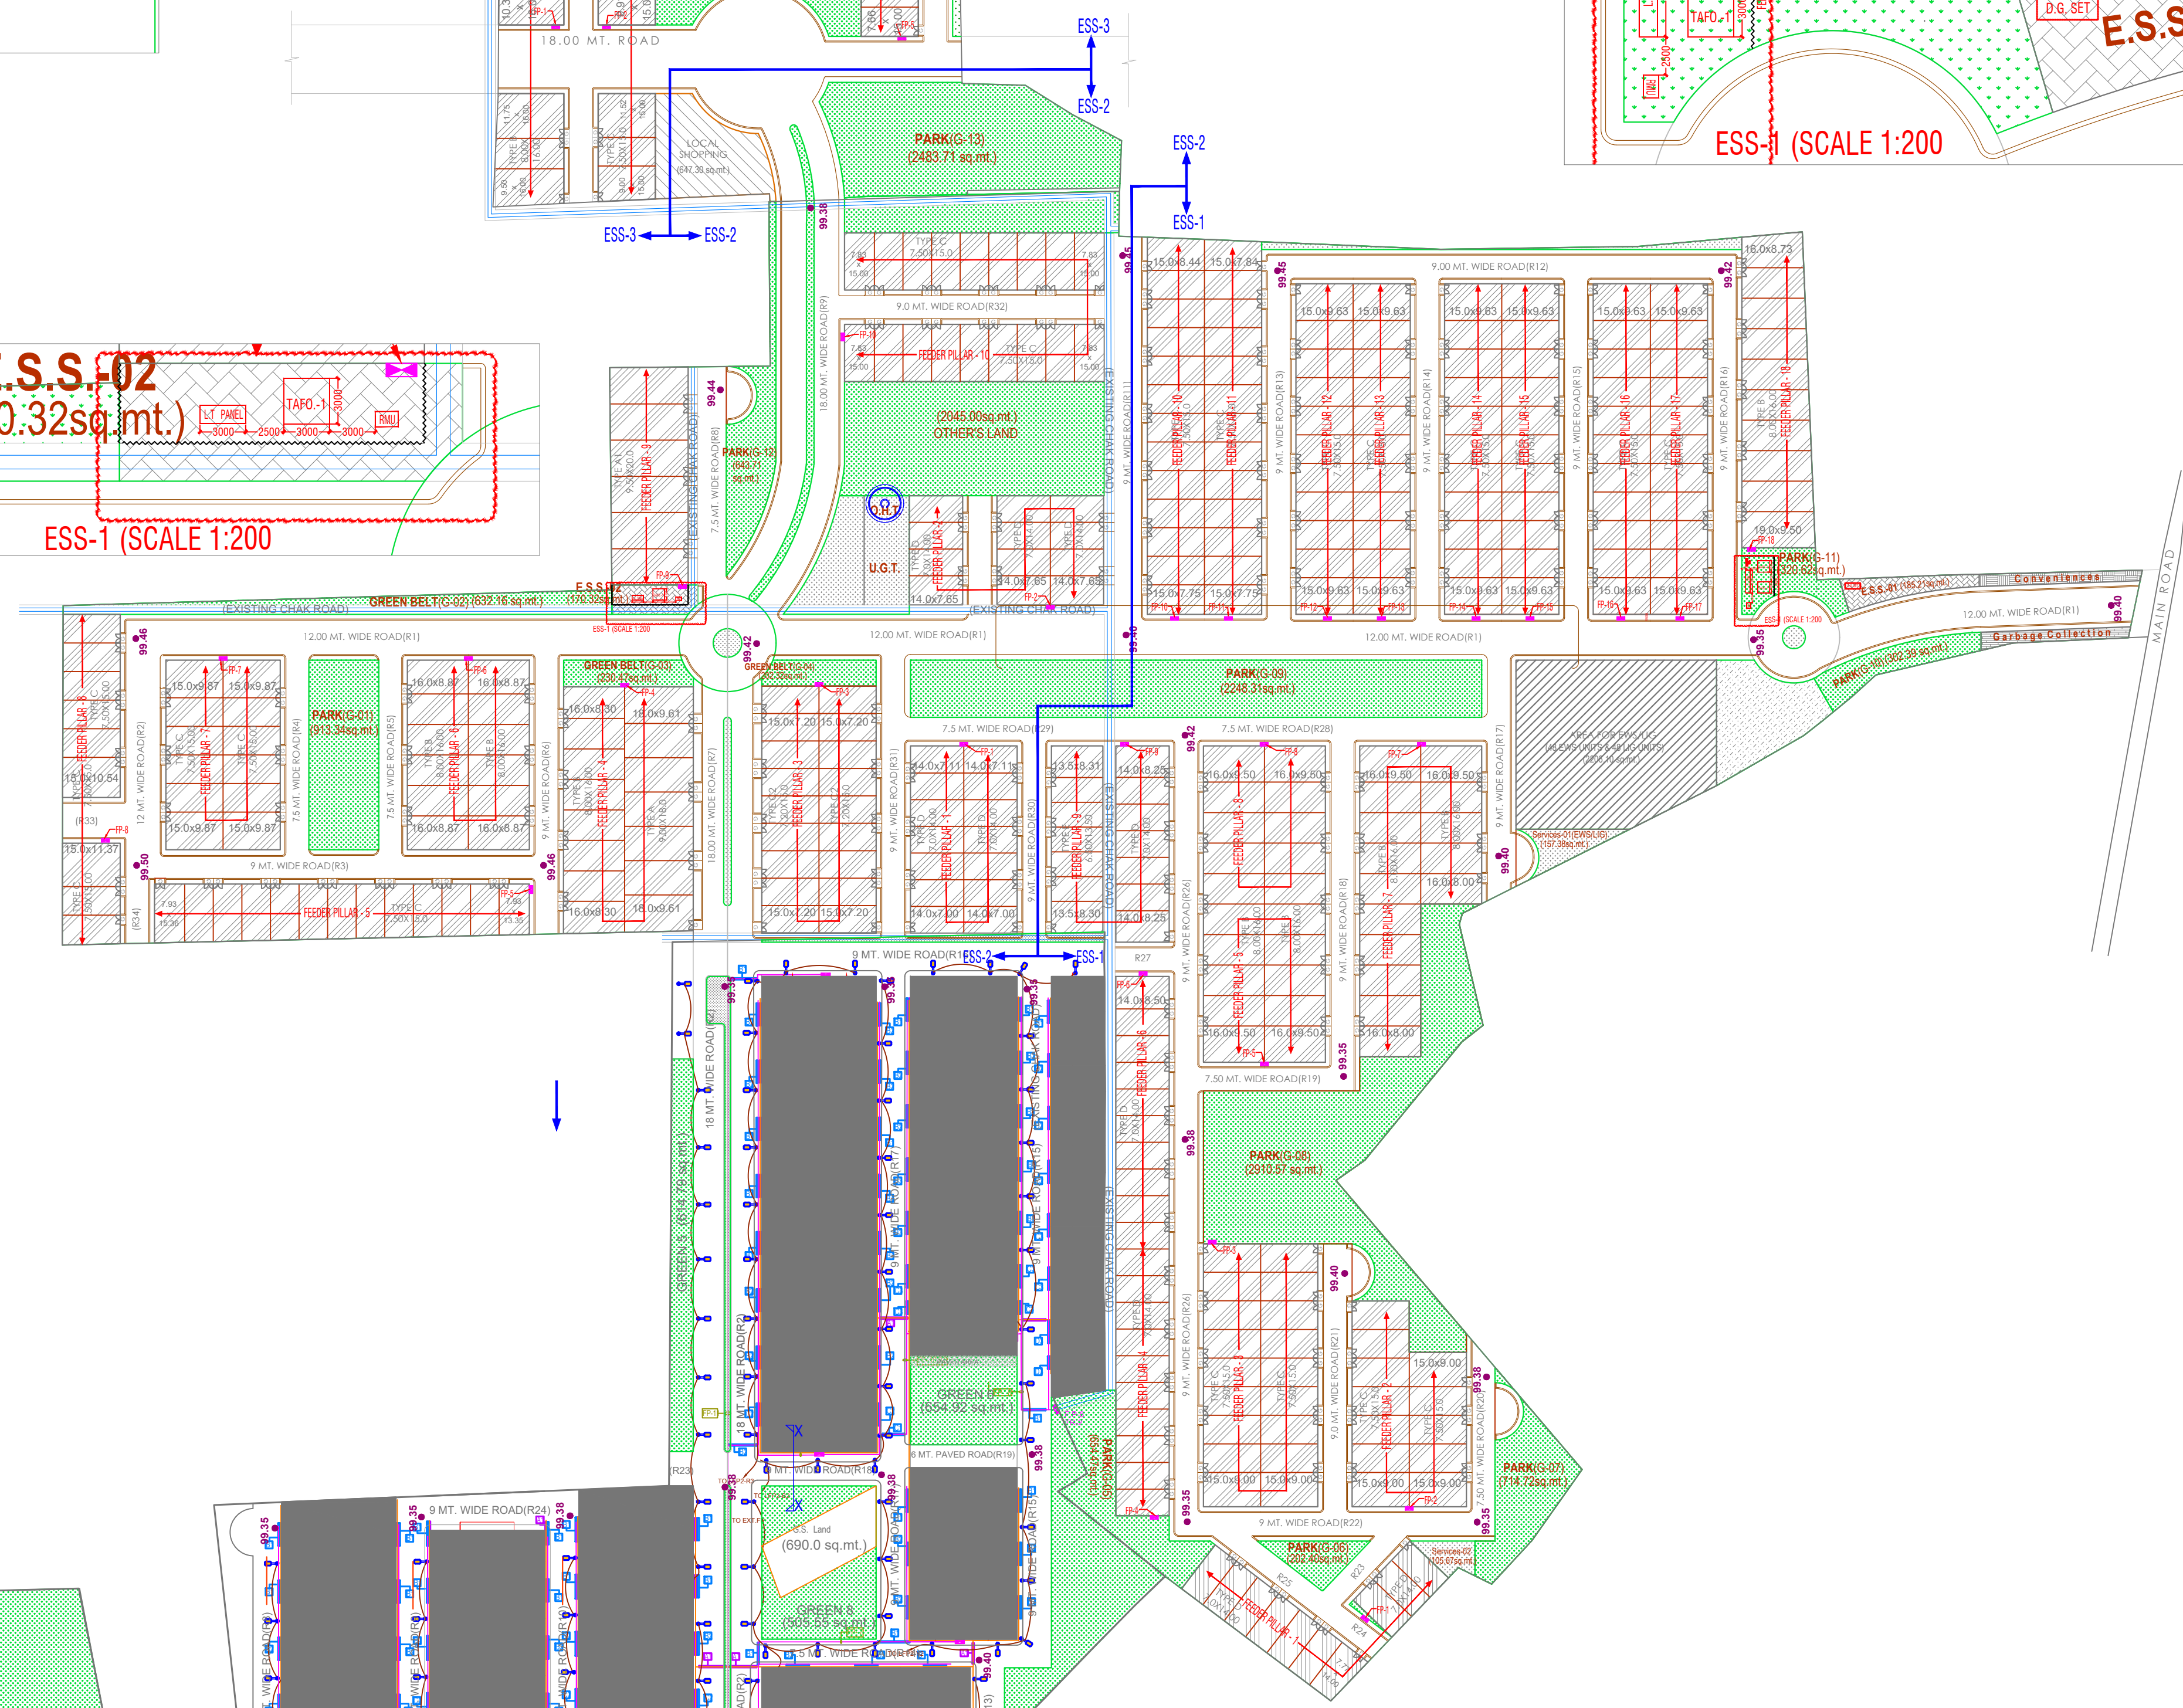
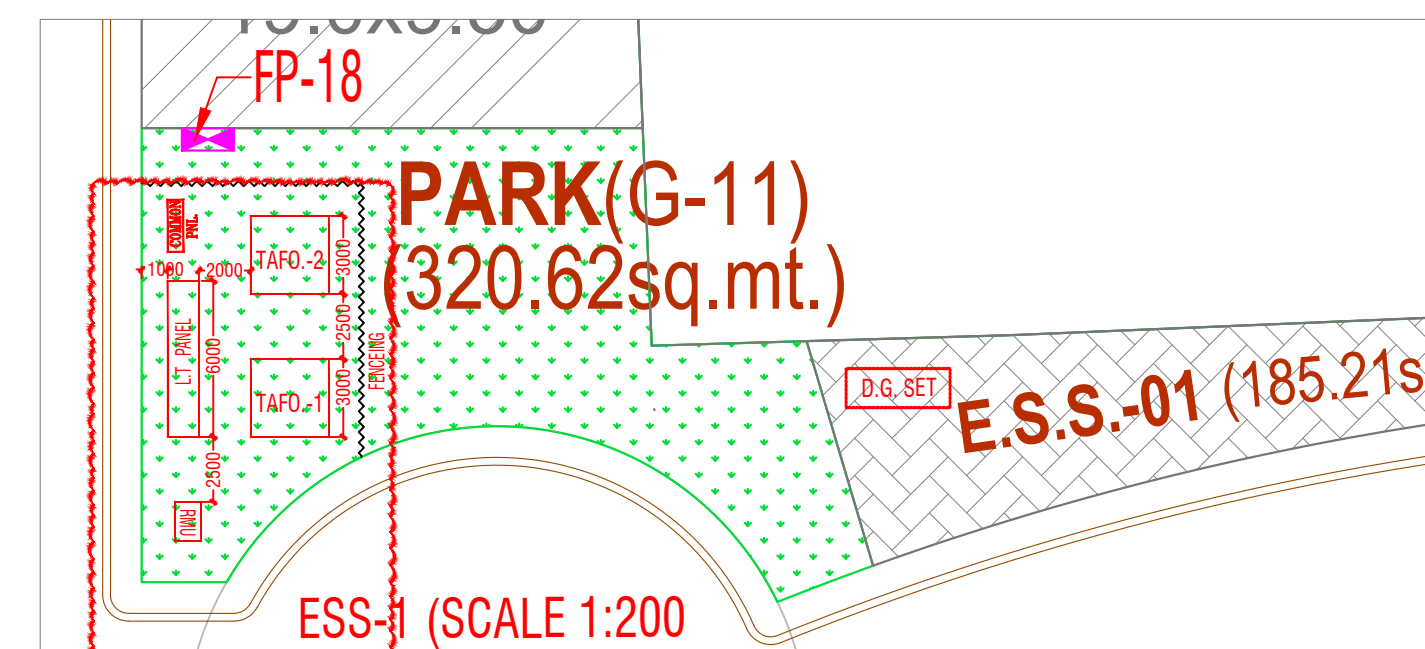
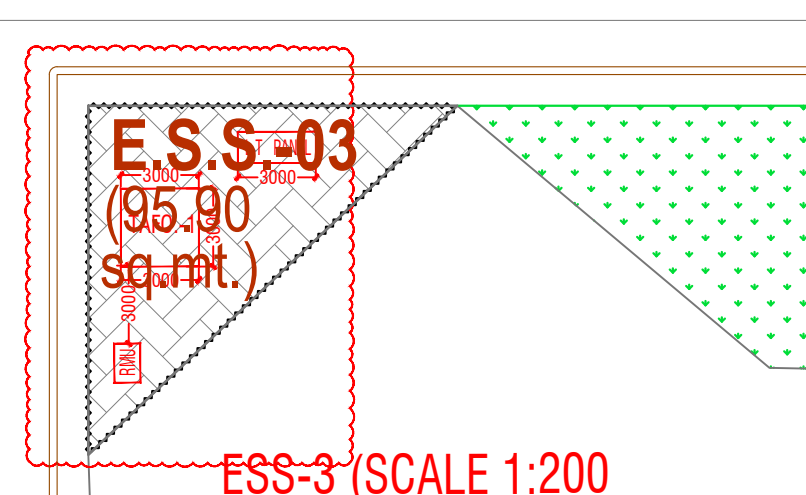
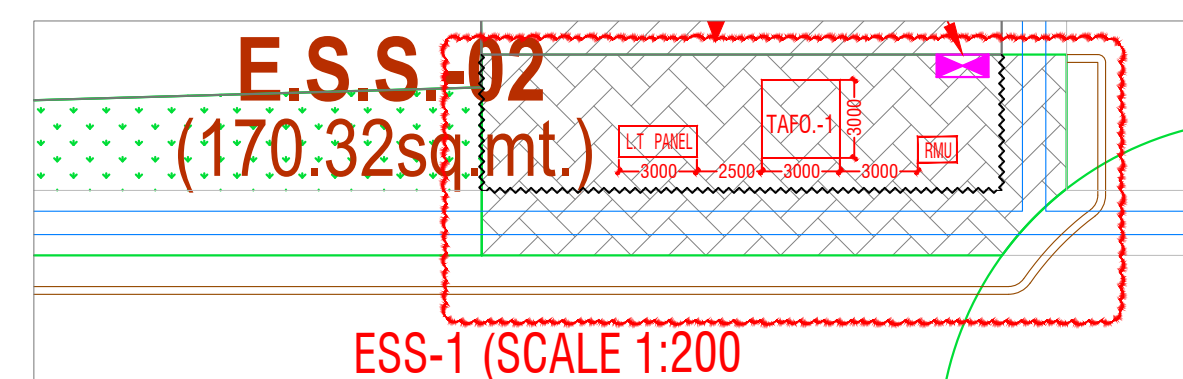
[illegible][illegible]

DRAWING STATUS:

WORKING DRAWING

PROJECT: RESIDENTIAL HOUSING SCHEME ELDECO IMPERIA A VILLAGE- JAITIKHERA, PARGANA-BIJNAUR, TEHSIL-SAROJINI NAGAR, LUCKNOW INDUSTRIAL DEVELOPMENT AUTHORITY, LUCKNOW

DEVELOPER:
ELDECO HOUSING & INDUSTRIES LTD.

ARCHITECT:



Ar. SANJAY KR. GUPTA
108, CORPORATE CHAMBER-I,
VIBHUTI KHAND, GOMTI NAGAR,
LUCKNOW
ph.no.- 0522-4065958, 09415114589

MEP CONSULTANTS:

PARADISE CONSULTANTS
Plot No. 129, Basement, Pocket 2
Near Sanjivani Hospital, Jasola Vihar
New Delhi - 110025
Landline : +91-11-46132800, 41030619
Web : www.paradiseconsultants.com

DRAWING TITLE :

MASTER PLAN ELECTRICAL LAYOUT

scale :	1:800 (A0)	drawn by :	RP
date :	12/09/2023	checked by :	AR
project no :	*****	approved by :	NAFEES
drawing no :			
EL-PC-IM Phase II-MEP-100			
REVISION			