
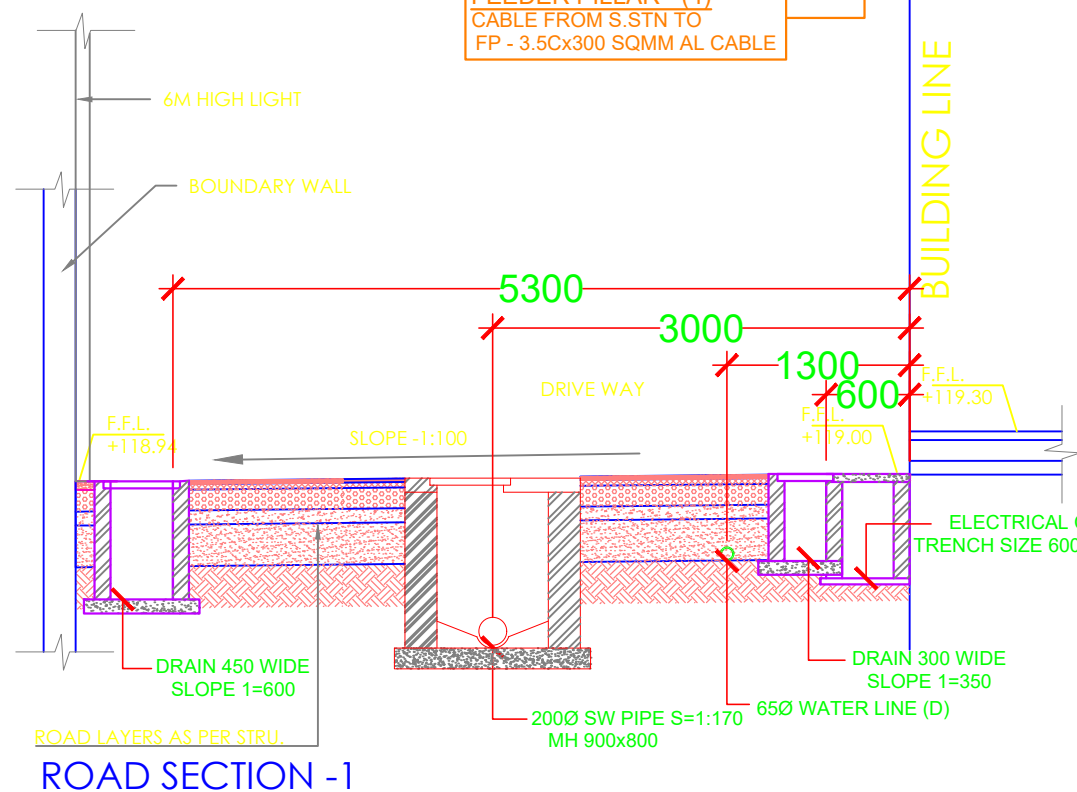
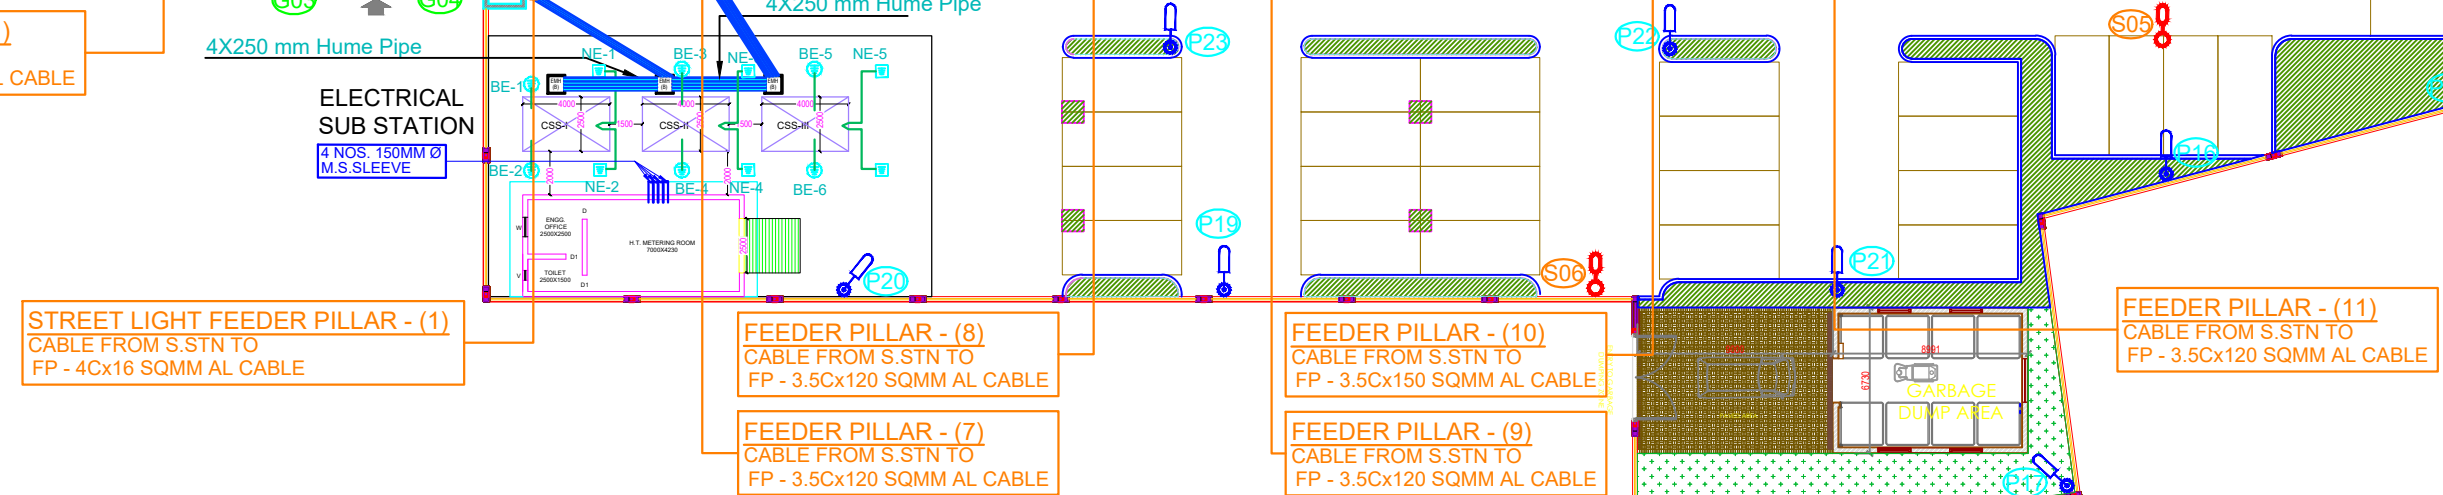
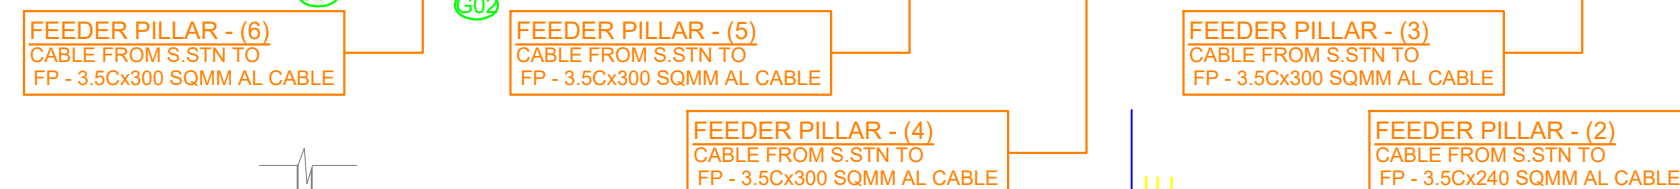



PROJECT:

PROPOSED
SUBMISSION DRG FOR M/S DLF
LIMITED OF LIG AND EWS HOUSING
AT GARDEN CITY,PURSENI,
LUCKNOW.


LEGEND:-			NOS. OF FIXTURES
1.		FEEDER PILLAR	
2.		6.0 METER HIGH GALVANIZED OCTAGONAL POLE SUITABLE FOR 1X70 W LED LAMP STREET LIGHT LUMINAIRES (FOR STREET LIGHTING) COLOR TEMPERATURE 3000K (YELLOW)	37
3.		6.0 METER HIGH SOLAR STREET LIGHT FIXTURE WITH 1X25 W LED SUITABLE FOR SOLAR MODULES SLOTTED ANGLE IRON FRAME STRUCTURE COLOR TEMPERATURE 3000K (YELLOW)	09
4.		1X70 W LED LIGHT FIXTURE ON WALL (FOR STREET LIGHTING) COLOR TEMPERATURE 3000K (YELLOW)	42
5.		GATE LIGHT SUITABLE FOR 1X70 W HPSV LAMP	04
6.		ELECTRICAL MAN HOLE (450MM x 450MM x 600MM DEEP)	65
7.		ELECTRICAL MAN HOLE (600MM x 600MM x 800MM DEEP)	03
8.		BODY EARTHING	
9.		NEUTRAL EARTHING	
10.		CABLE TRENCH A - 900mm x 900mm B - 600mm x 750mm	
11.		63MM Ø PVC PIPE (FOR TV / TEL. WIRES)	
12.		32MM Ø PVC PIPE (FOR TV / TEL. WIRES)	

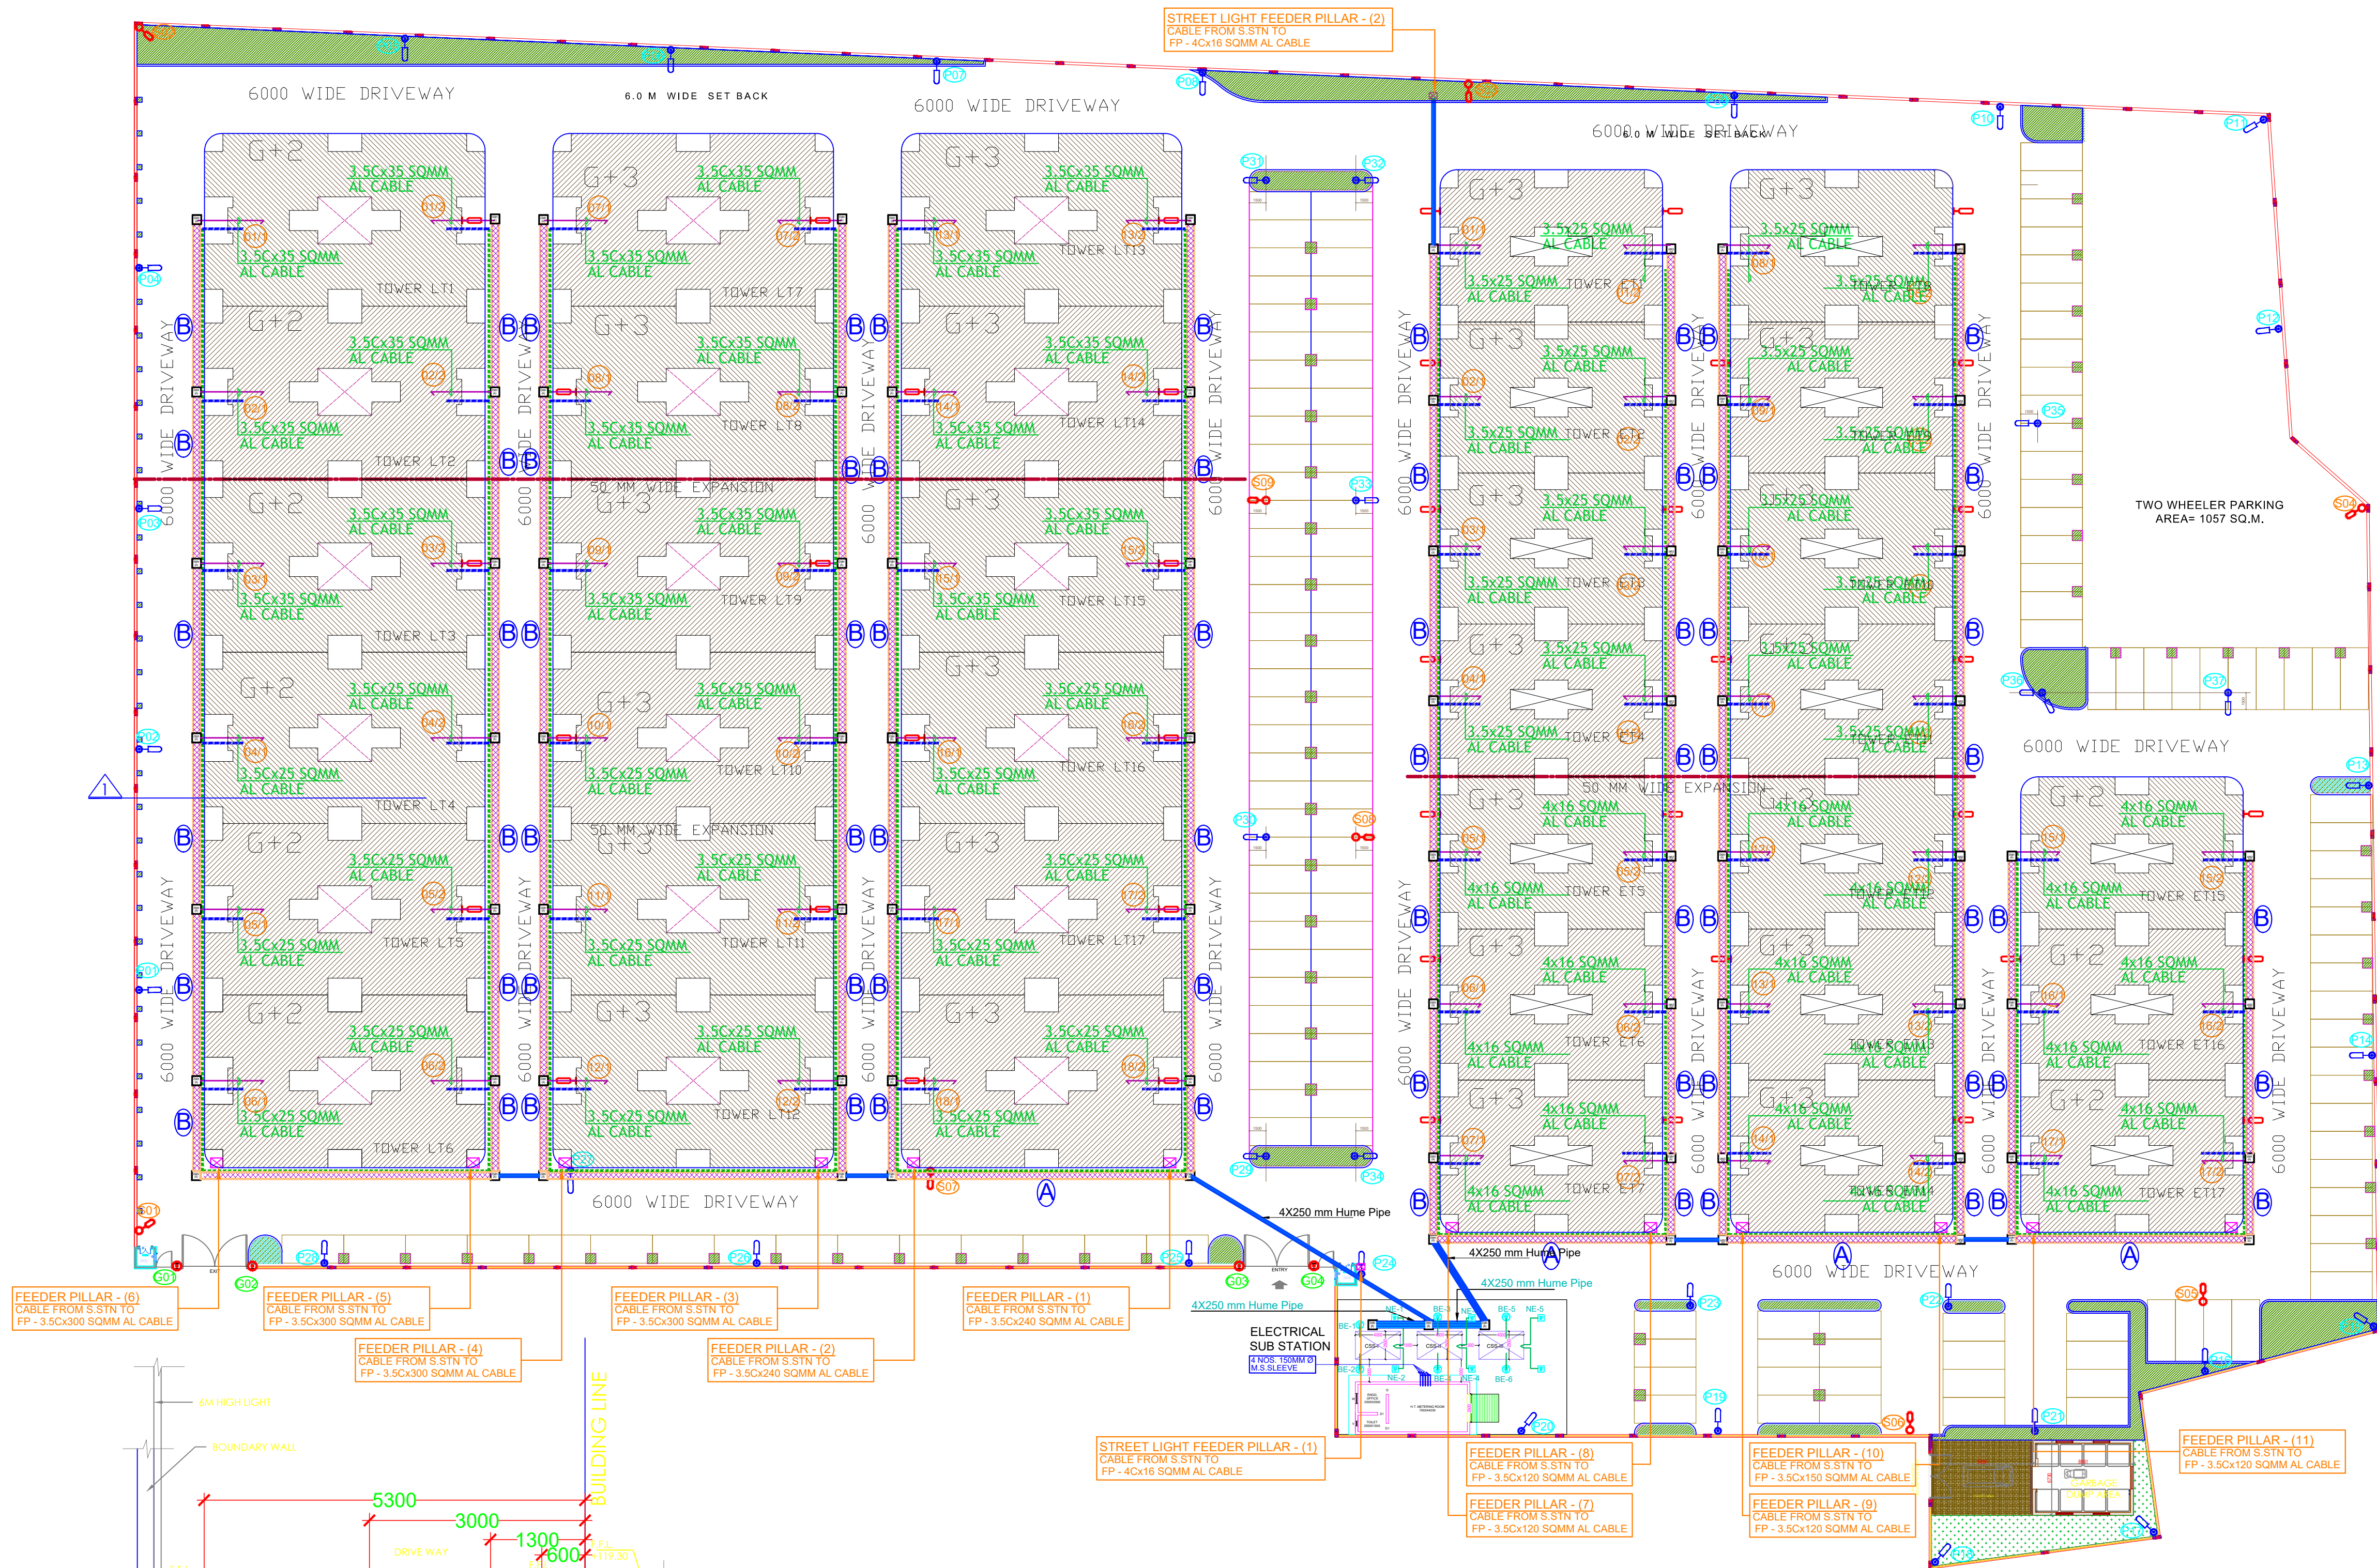


ROAD SECTION - I

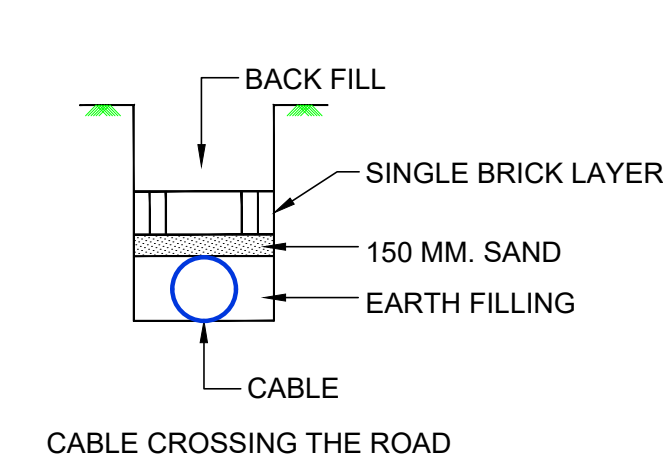


CABLE CROSSING THE ROAD

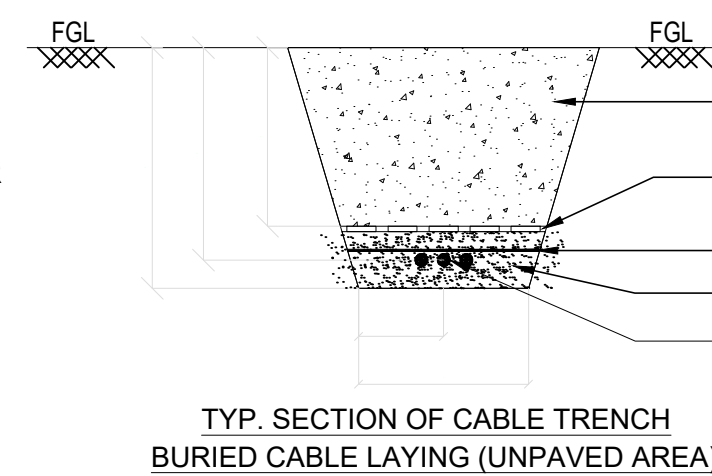


TYP. SECTION OF CABLE TRENCH
BURIED CABLE LAYING (UNPAVED AREA)

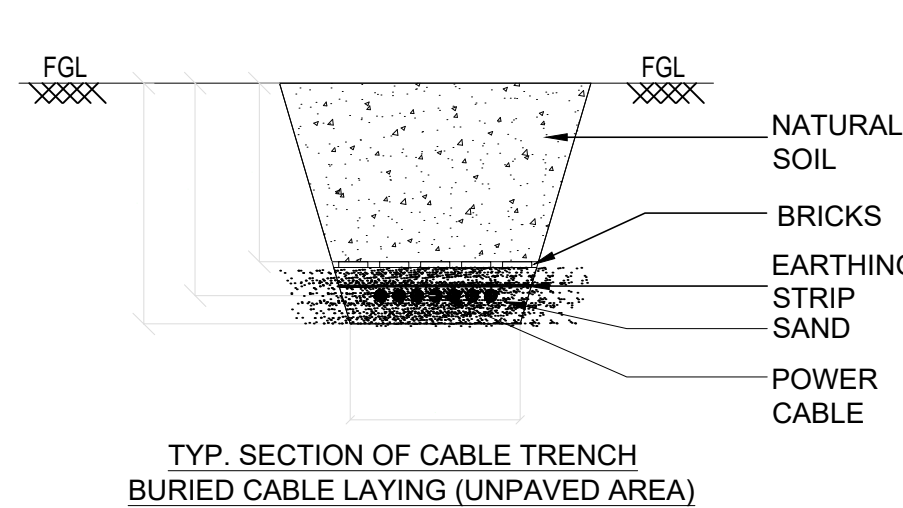


TYP. SECTION OF CABLE TRENCH
BURIED CABLE LAYING (UNPAVED AREA)

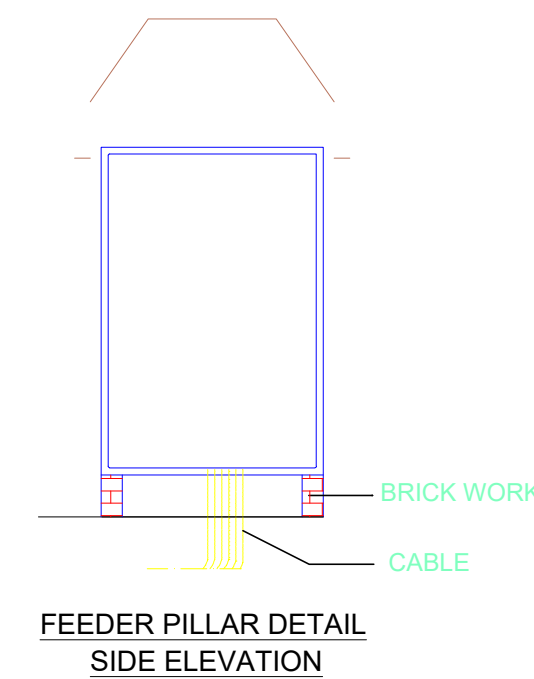

FEEDER PILLAR DETAIL
SIDE ELEVATION

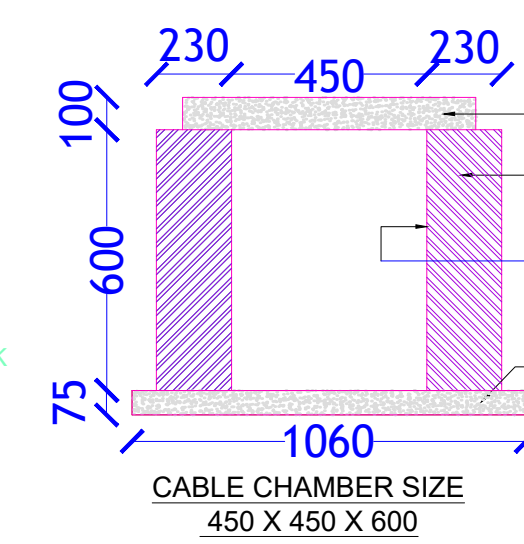

CABLE CHAMBER SIZE
450 X 450 X 600

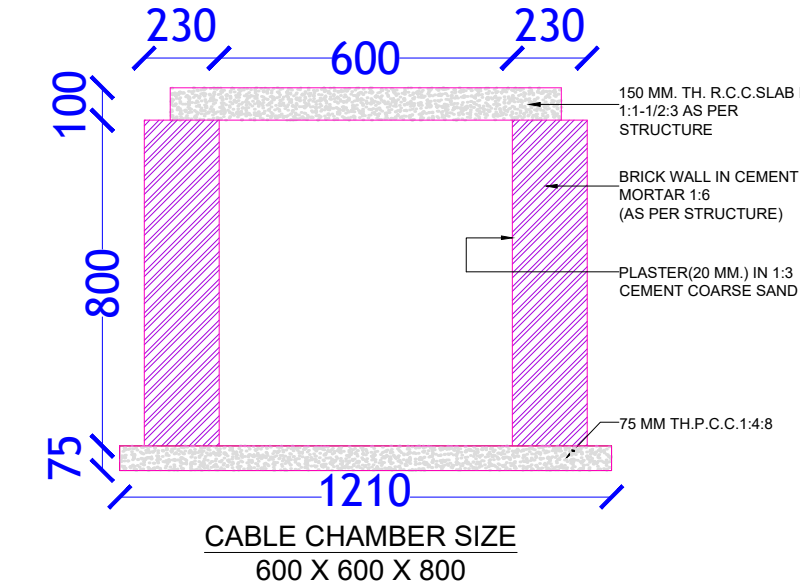

CABLE CHAMBER SIZE
600 X 600 X 800

SUB. TITLE:

LIG+EWS

DRG. TITLE:

SITE PLAN
(ELECTRICAL)

PROJECT MANAGER:

SCALE: 1:100 DRG. NO.: SITE PLAN /SEE-01

DRN BY: JITENDRA CHECKED BY:

DATE: MAR.-2018 O.P.SHAH

ARCHITECTURAL CONSULTANTS :-

Architect `s Avenue

D-2/122 Sambhav Tower Vibhuti Khand
Gomtinagar Lucknow,

Services Consultant :

SHAH & PANT
CONSULTING ENGINEERS (P) LTD.
AN ISO 9001-2008 COMPANY
(Building services Consultant, Soil & foundation Experts, Highway Engineering)
1, 4th Floor, HALWASIYA COURT, HAZRATGANJ, LUCKNOW (U.P.)
Tele. No. : 0522-2230625, Fax : 0522-2230625, Cell : 9839013280, 9415027719
Email : shah_pant@yahoo.co.in, Web : www.shahpantconsultingengineers.com

SITE PLAN