


Authorised Signatory

[Signature]

For Gulshan Homes And Infrastructure Pvt. Ltd.

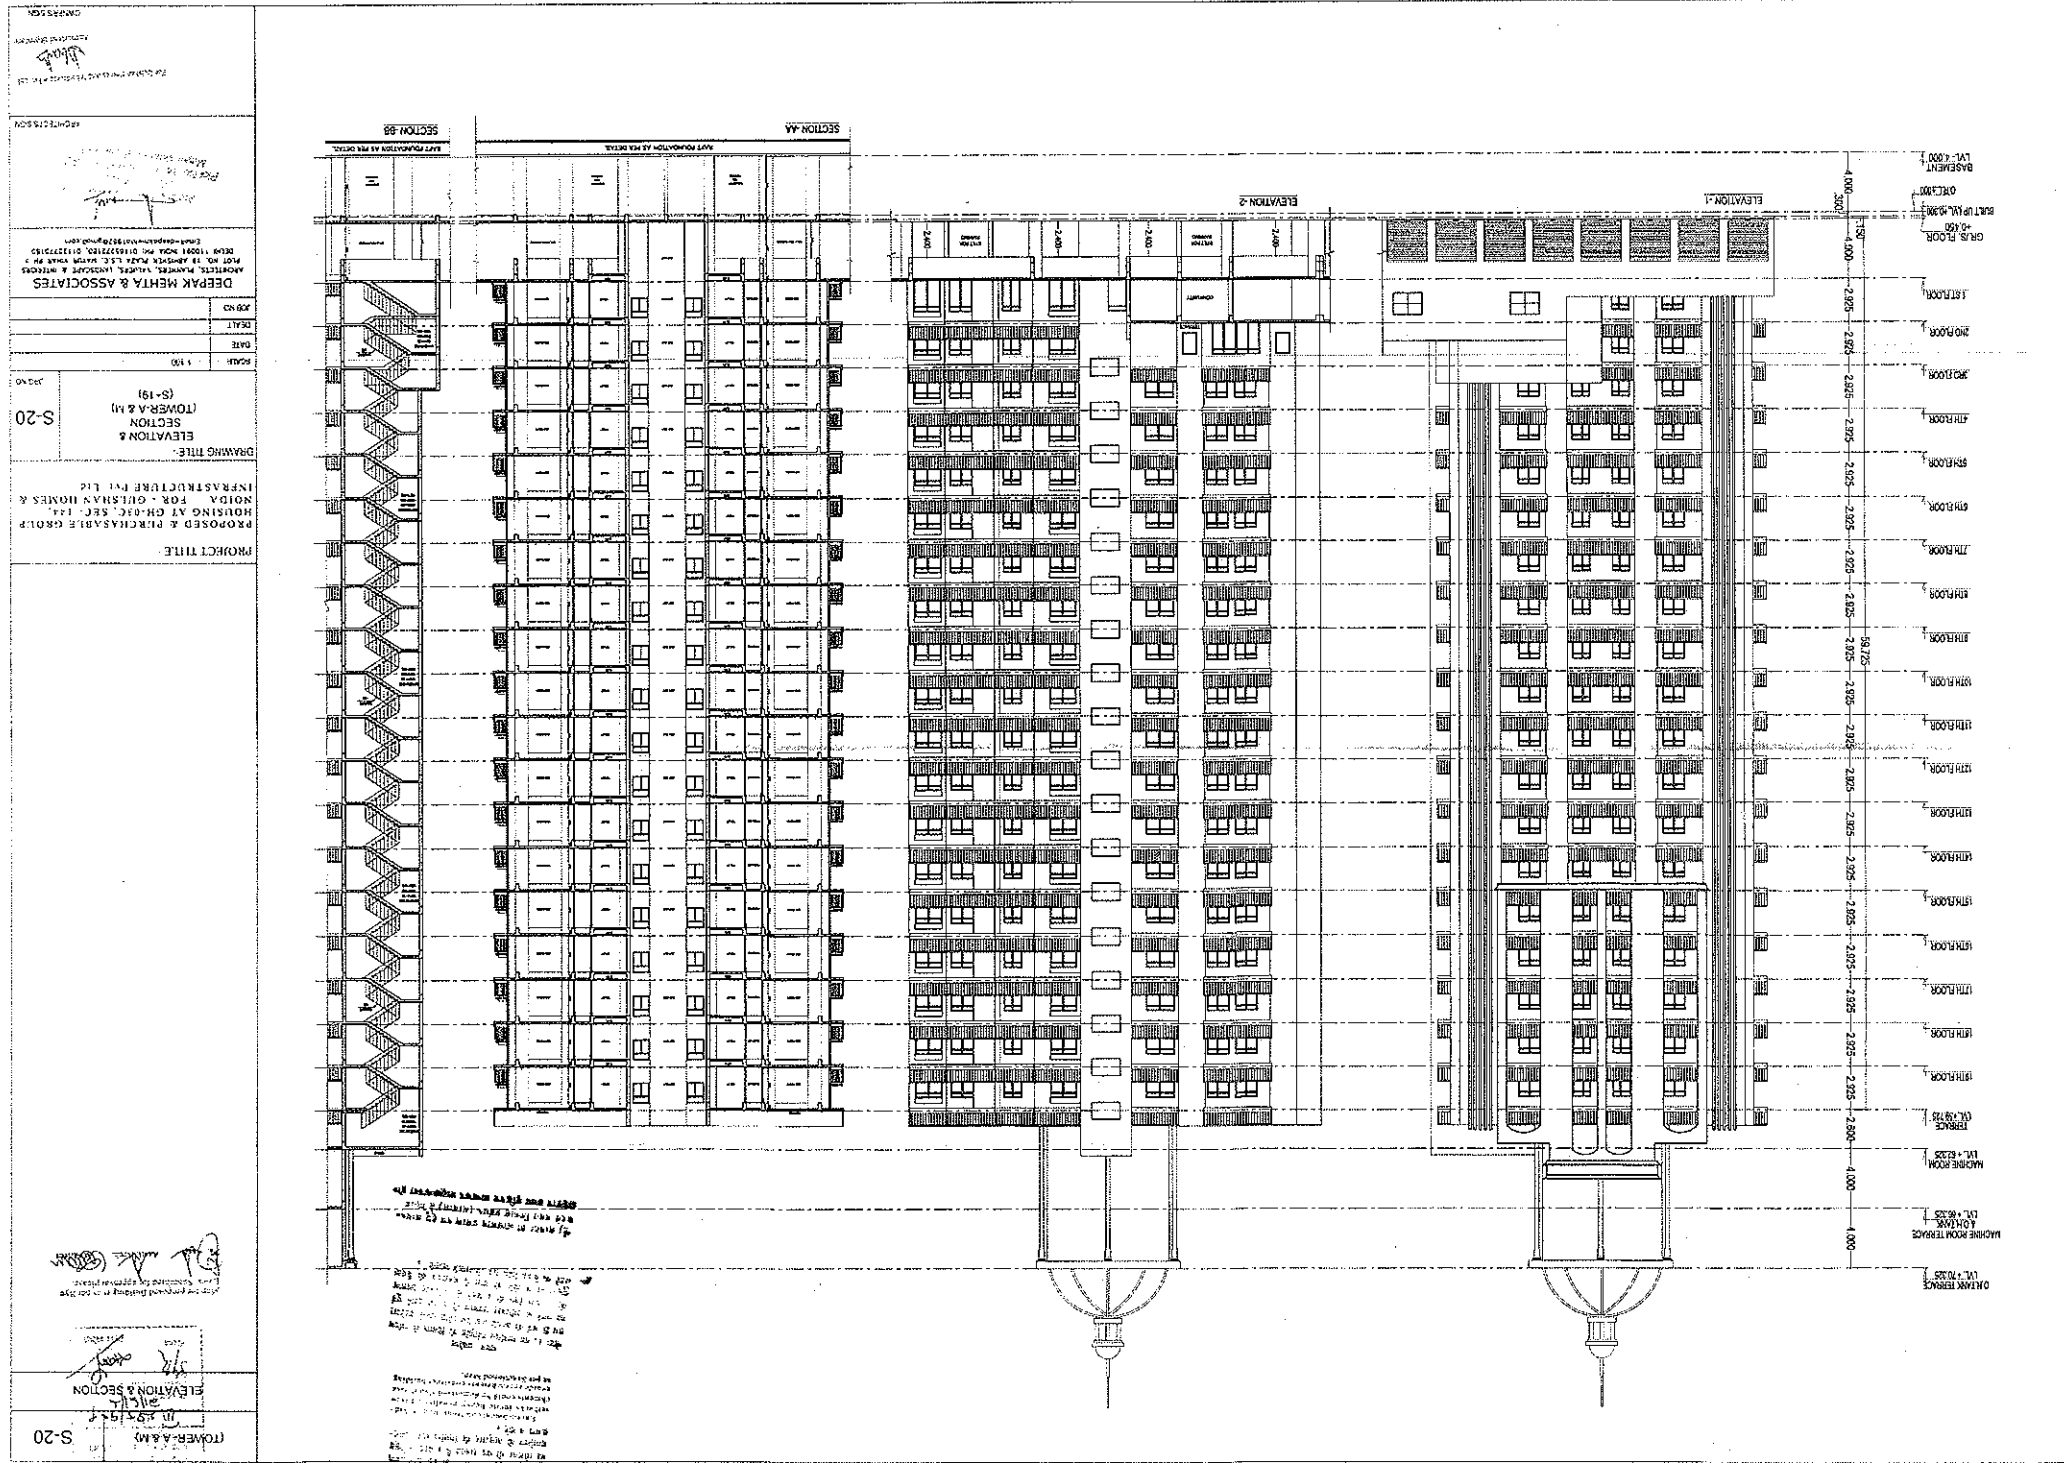

MACHINE ROOM
LEVEL: +5.500

TERACE
LEVEL: +5.500

16TH FLOOR

15TH FLOOR

14TH FLOOR

13TH FLOOR

12TH FLOOR

11TH FLOOR

10TH FLOOR

9TH FLOOR

8TH FLOOR

7TH FLOOR

6TH FLOOR

5TH FLOOR

4TH FLOOR

3RD FLOOR


2ND FLOOR

1ST FLOOR

GRS. FLOOR
LEVEL: +0.450

BUILT UP AREA: 40.000

BASEMENT
LEVEL: -4.000

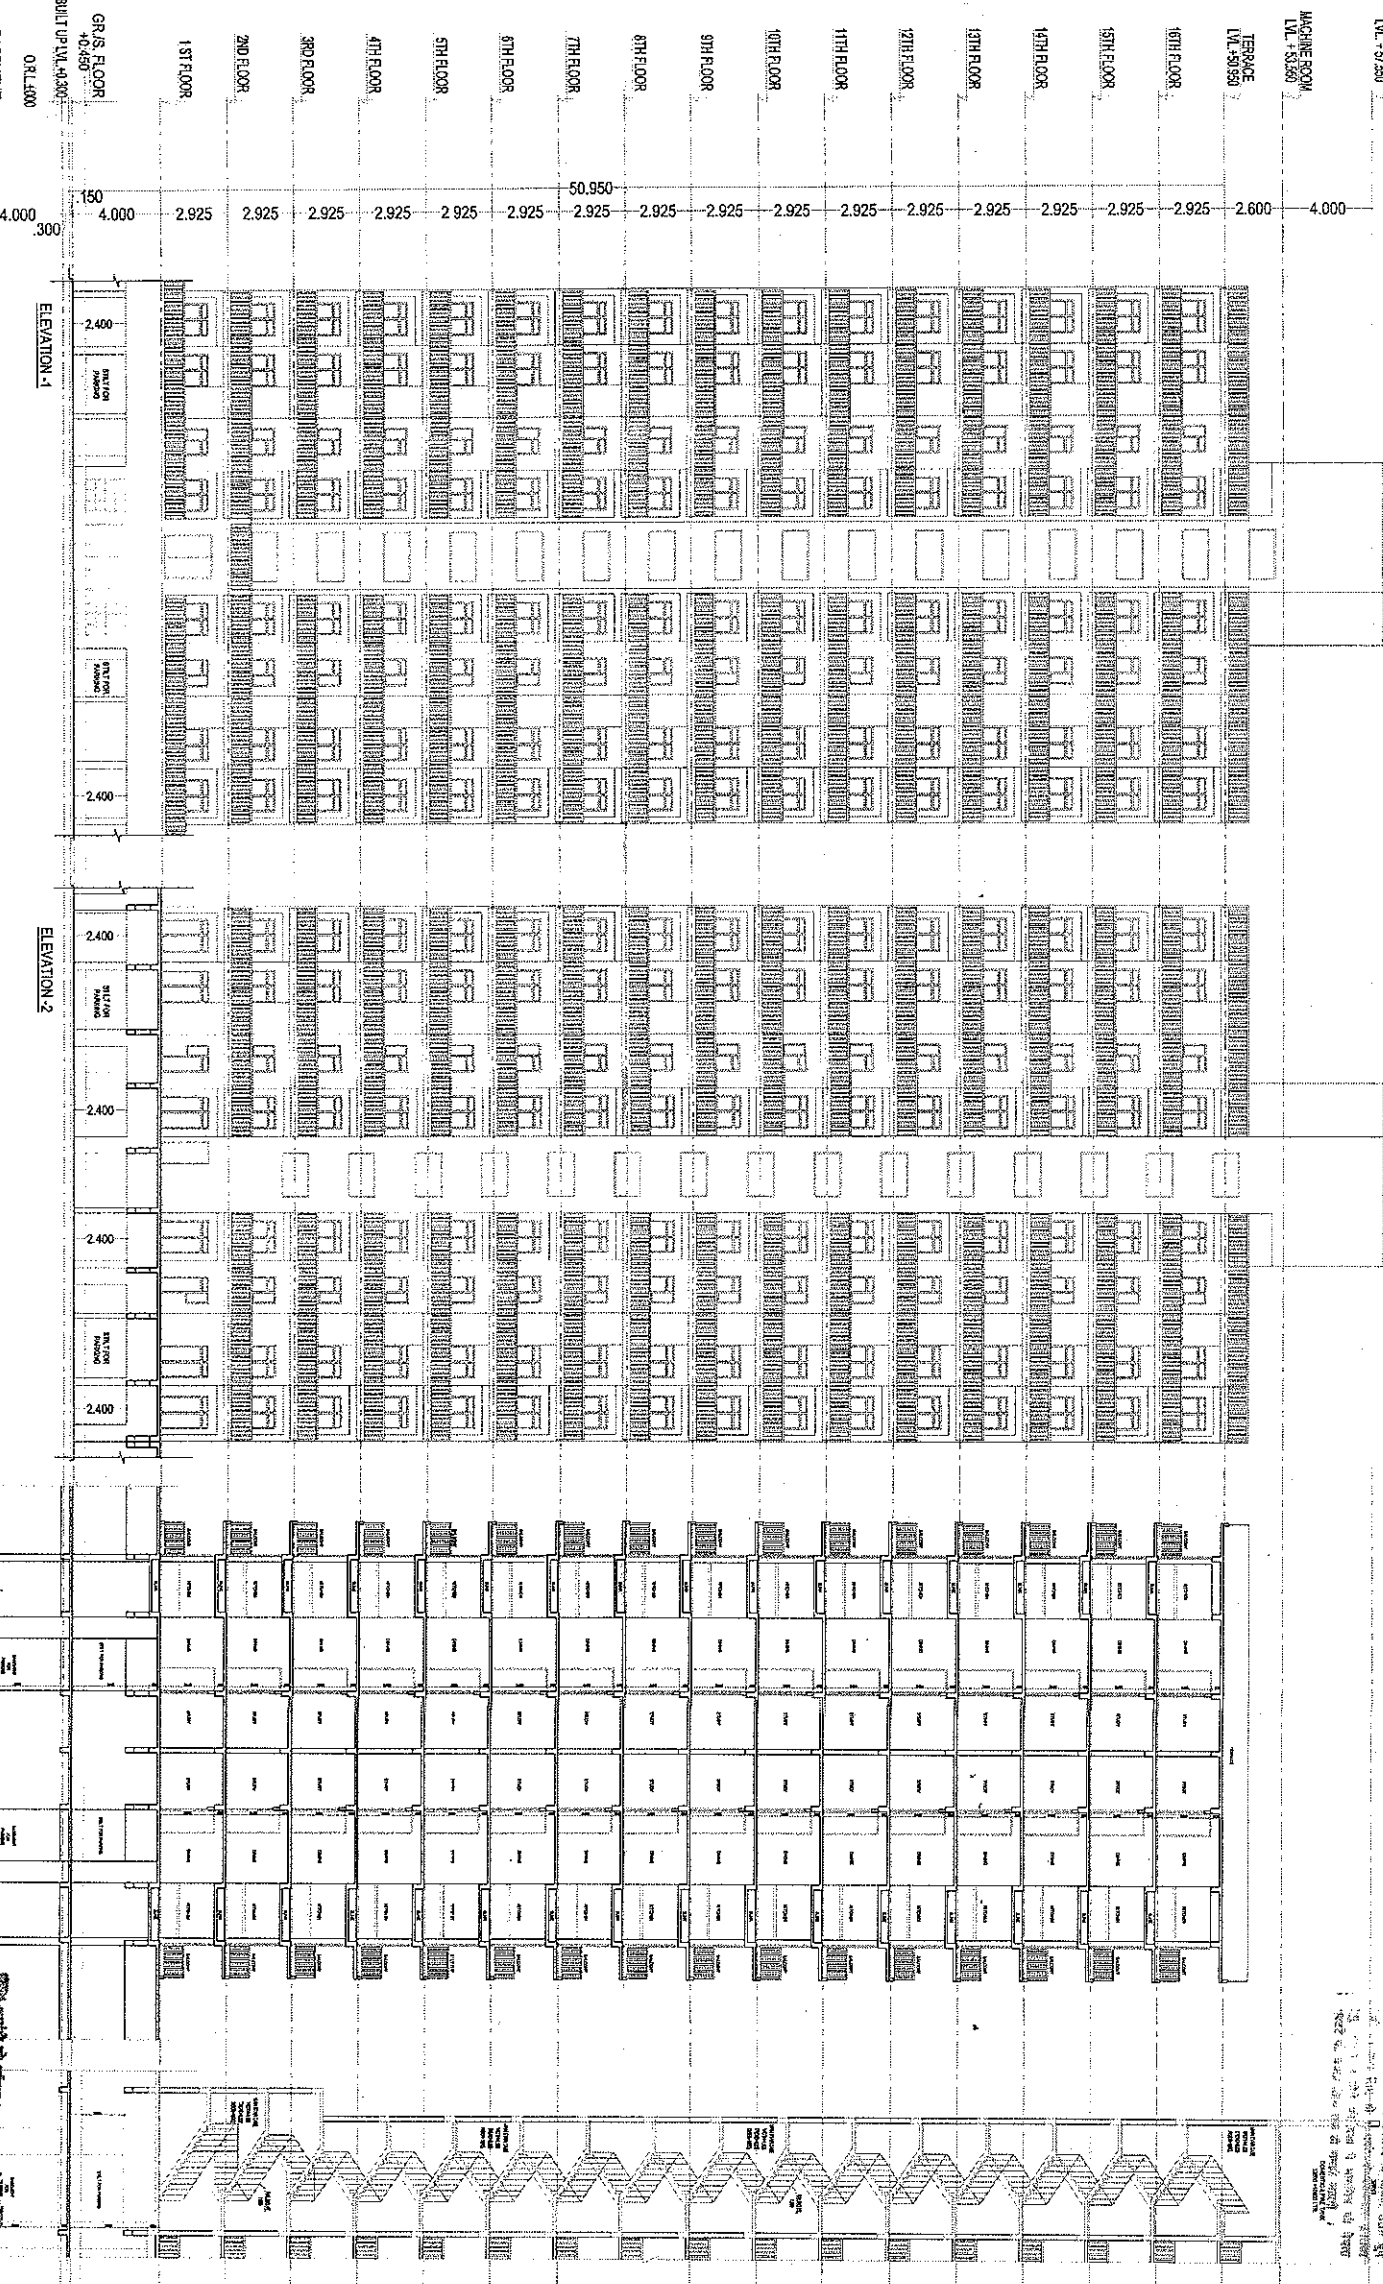

SECTION AA

DO NOT FOUNDATION AS PER DETAIL

SECTION BB

NOT TO SCALE
SECTION 1: ON THE RIGHT SIDE OF THE SECTION
SECTION 2: ON THE LEFT SIDE OF THE SECTION
SECTION 3: ON THE TOP OF THE SECTION
SECTION 4: ON THE BOTTOM OF THE SECTION
SECTION 5: ON THE FRONT OF THE SECTION
SECTION 6: ON THE BACK OF THE SECTION
SECTION 7: ON THE INSIDE OF THE SECTION
SECTION 8: ON THE OUTSIDE OF THE SECTION
SECTION 9: ON THE INTERIOR OF THE SECTION
SECTION 10: ON THE EXTERIOR OF THE SECTION
SECTION 11: ON THE ROOF OF THE SECTION
SECTION 12: ON THE BASEMENT OF THE SECTION
SECTION 13: ON THE ATTIC OF THE SECTION
SECTION 14: ON THE GARAGE OF THE SECTION
SECTION 15: ON THE PORCH OF THE SECTION
SECTION 16: ON THE TERRACE OF THE SECTION
SECTION 17: ON THE BALCONY OF THE SECTION
SECTION 18: ON THE STAIRCASE OF THE SECTION
SECTION 19: ON THE ELEVATOR SHAFT OF THE SECTION
SECTION 20: ON THE MECHANICAL ROOM OF THE SECTION
SECTION 21: ON THE ELECTRICAL ROOM OF THE SECTION
SECTION 22: ON THE WATER TANK OF THE SECTION
SECTION 23: ON THE SMOKE CHIMNEY OF THE SECTION
SECTION 24: ON THE VENTILATION SYSTEM OF THE SECTION
SECTION 25: ON THE HEATING SYSTEM OF THE SECTION
SECTION 26: ON THE COOLING SYSTEM OF THE SECTION
SECTION 27: ON THE PLUMBING SYSTEM OF THE SECTION
SECTION 28: ON THE ELECTRICAL WIRING OF THE SECTION
SECTION 29: ON THE TELEPHONE WIRING OF THE SECTION
SECTION 30: ON THE DATA CABLE WIRING OF THE SECTION
SECTION 31: ON THE FIRE ALARM SYSTEM OF THE SECTION
SECTION 32: ON THE SECURITY SYSTEM OF THE SECTION
SECTION 33: ON THE ACCESS CONTROL SYSTEM OF THE SECTION
SECTION 34: ON THE VIDEO SURVEILLANCE SYSTEM OF THE SECTION
SECTION 35: ON THE INTERCOM SYSTEM OF THE SECTION
SECTION 36: ON THE PA SYSTEM OF THE SECTION
SECTION 37: ON THE LIGHTING SYSTEM OF THE SECTION
SECTION 38: ON THE SOUND SYSTEM OF THE SECTION
SECTION 39: ON THE CLIMATE CONTROL SYSTEM OF THE SECTION
SECTION 40: ON THE AIR QUALITY CONTROL SYSTEM OF THE SECTION
SECTION 41: ON THE HUMIDITY CONTROL SYSTEM OF THE SECTION
SECTION 42: ON THE DUST CONTROL SYSTEM OF THE SECTION
SECTION 43: ON THE PEST CONTROL SYSTEM OF THE SECTION
SECTION 44: ON THE WASTE MANAGEMENT SYSTEM OF THE SECTION
SECTION 45: ON THE WATER MANAGEMENT SYSTEM OF THE SECTION
SECTION 46: ON THE SEWERAGE SYSTEM OF THE SECTION
SECTION 47: ON THE RAINWATER HARVESTING SYSTEM OF THE SECTION
SECTION 48: ON THE GREY WATER REUSE SYSTEM OF THE SECTION
SECTION 49: ON THE BLACK WATER REUSE SYSTEM OF THE SECTION
SECTION 50: ON THE ENERGY MANAGEMENT SYSTEM OF THE SECTION
SECTION 51: ON THE SMART BUILDING SYSTEM OF THE SECTION
SECTION 52: ON THE AUTOMATION SYSTEM OF THE SECTION
SECTION 53: ON THE INTEGRATION SYSTEM OF THE SECTION
SECTION 54: ON THE DATA CENTER SYSTEM OF THE SECTION
SECTION 55: ON THE SERVER ROOM SYSTEM OF THE SECTION
SECTION 56: ON THE NETWORK ROOM SYSTEM OF THE SECTION
SECTION 57: ON THE STORAGE ROOM SYSTEM OF THE SECTION
SECTION 58: ON THE BACKUP ROOM SYSTEM OF THE SECTION
SECTION 59: ON THE DISASTER RECOVERY SYSTEM OF THE SECTION
SECTION 60: ON THE BUSINESS CONTINUITY SYSTEM OF THE SECTION
SECTION 61: ON THE RISK MANAGEMENT SYSTEM OF THE SECTION
SECTION 62: ON THE COMPLIANCE SYSTEM OF THE SECTION
SECTION 63: ON THE AUDIT SYSTEM OF THE SECTION
SECTION 64: ON THE REPORTING SYSTEM OF THE SECTION
SECTION 65: ON THE DASHBOARD SYSTEM OF THE SECTION
SECTION 66: ON THE ALERTING SYSTEM OF THE SECTION
SECTION 67: ON THE NOTIFICATION SYSTEM OF THE SECTION
SECTION 68: ON THE COMMUNICATION SYSTEM OF THE SECTION
SECTION 69: ON THE COLLABORATION SYSTEM OF THE SECTION
SECTION 70: ON THE PRODUCTIVITY SYSTEM OF THE SECTION
SECTION 71: ON THE INNOVATION SYSTEM OF THE SECTION
SECTION 72: ON THE CREATIVITY SYSTEM OF THE SECTION
SECTION 73: ON THE IMAGINATION SYSTEM OF THE SECTION
SECTION 74: ON THE INSPIRATION SYSTEM OF THE SECTION
SECTION 75: ON THE MOTIVATION SYSTEM OF THE SECTION
SECTION 76: ON THE ENTHUSIASM SYSTEM OF THE SECTION
SECTION 77: ON THE PASSION SYSTEM OF THE SECTION
SECTION 78: ON THE COMMITMENT SYSTEM OF THE SECTION
SECTION 79: ON THE DEDICATION SYSTEM OF THE SECTION
SECTION 80: ON THE PERSEVERANCE SYSTEM OF THE SECTION
SECTION 81: ON THE RESILIENCE SYSTEM OF THE SECTION
SECTION 82: ON THE ADAPTABILITY SYSTEM OF THE SECTION
SECTION 83: ON THE FLEXIBILITY SYSTEM OF THE SECTION
SECTION 84: ON THE AGILITY SYSTEM OF THE SECTION
SECTION 85: ON THE VELOCITY SYSTEM OF THE SECTION
SECTION 86: ON THE ACCELERATION SYSTEM OF THE SECTION
SECTION 87: ON THE MOMENTUM SYSTEM OF THE SECTION
SECTION 88: ON THE IMPULSUS SYSTEM OF THE SECTION
SECTION 89: ON THE ELAN SYSTEM OF THE SECTION
SECTION 90: ON THE ZEST SYSTEM OF THE SECTION
SECTION 91: ON THE ENERGIY SYSTEM OF THE SECTION
SECTION 92: ON THE VIGOR SYSTEM OF THE SECTION
SECTION 93: ON THE ALACRITY SYSTEM OF THE SECTION
SECTION 94: ON THE LIVELINESS SYSTEM OF THE SECTION
SECTION 95: ON THE BUZZ SYSTEM OF THE SECTION
SECTION 96: ON THE HUM SYSTEM OF THE SECTION
SECTION 97: ON THE CHATTER SYSTEM OF THE SECTION
SECTION 98: ON THE NOISE SYSTEM OF THE SECTION
SECTION 99: ON THE SOUND SYSTEM OF THE SECTION
SECTION 100: ON THE SILENCE SYSTEM OF THE SECTION

For Gulshan Homes And Infrastructure Pvt. Ltd.

Authorised Signatory

Stamp for proposed Building is in per Dm
Date: 21/11/2024
Signature: [Signature]
Name: [Name]

PROJECT TITLE:
PROPOSED GROUP HOUSING AT
GH-03C, SEC-14A,
NOIDA, FOR - GULSHAN HOMES &
INFRASTRUCTURE PVT. LTD


DRAWING TITLE:
ELEVATION & SECTION
(TOWER B & C)
(S-21)

SCALE: 1:100
DATE: [Date]
DEPT: [Dept]
JOB NO: [Job No]

DEEPAK MENTA & ASSOCIATES
ARCHITECTS, PLANNERS, DESIGNERS & ENGINEERS
PLOT NO. 15, GATE NO. 150
MAYAPUR, NEW DELHI - 110016
Tel: 011-26101111, 011-26101112, 011-26101113

ARCHITECT'S SIGN
For Gulshan Homes And Infrastructure Pvt. Ltd.
Authorised Signatory
[Signature]
OWNER'S SIGN

Map for proposed building is as per Bye
Laws Submitted for approval please.

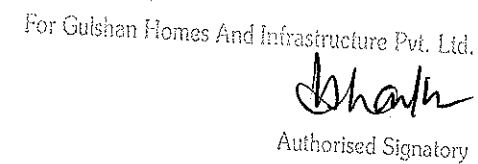

॥ श्रीगणेशाय नमः ॥ श्रीगणेशाय नमः ॥ श्रीगणेशाय नमः ॥

DRAWING TITLE:- ELEVATION & SECTION (TOWER-D.E.H & J) (S+14)	S-23 DRG NO.
--	----------------------------

SCALE	1:100
DATE	
DESIGN	
JOB NO.	

DEEPAK MEHTA & ASSOCIATES
ARCHITECTS, PLANNERS, VALUEERS, LANDSCAPE & INTERIORS
PLOT NO. 15 ADARSHK, PLAZA L.O.C. MAYUR VIHAR PH II
DELHI 110091 INDIA Ph: 01165272180, 01122770100
E-mail: deepak.mehta@16927@gmail.com

Architect's Sign

For Gulshan Homes And Infrastructure Pvt. Ltd.

Abhail

Authorized Signatory

GWNERS SXGN

ELEVATION & SECTION

DATE: 21/11/14
BY: S-24
SIGNED: [Signature]
[Stamp]

Notes for proposed Building 144 per floor
1. The building is proposed to be built on a plot of 144 sq. m.
2. The building is proposed to be built on a plot of 144 sq. m.
3. The building is proposed to be built on a plot of 144 sq. m.

PROJECT TITLE:

PROPOSED GROUP HOUSING AT
GH-03C, SEC-144,
NOIDA, FOR - GULSHAN HOMES &
INFRASTRUCTURE PVT. LTD.

DRAWING TITLE:

ELEVATION & SECTION
(TOWER-F & G)
(S+10)

S-24

DWGNO.

SCALE	1:100
DATE	
BY	
CHKD	
APPD	


DEEPAK MEHTA & ASSOCIATES
ARCHITECTS, PRACTICE, VASUKI, LIGAND & INTERIOR
PLOT NO. 16, JABBERPURA, LIGAND & INTERIOR
VILLAGE: 10001, ROAD NO. 10001, DISTRICT: 91
GATE NO. 10001, DISTRICT: 91

ARCHITECTS SIGN
PLOT NO. 16, JABBERPURA, LIGAND & INTERIOR
VILLAGE: 10001, ROAD NO. 10001, DISTRICT: 91
GATE NO. 10001, DISTRICT: 91

For Gulshan Homes And Infrastructure Pvt. Ltd.

Authorized Signatory

OWNERS SIGN

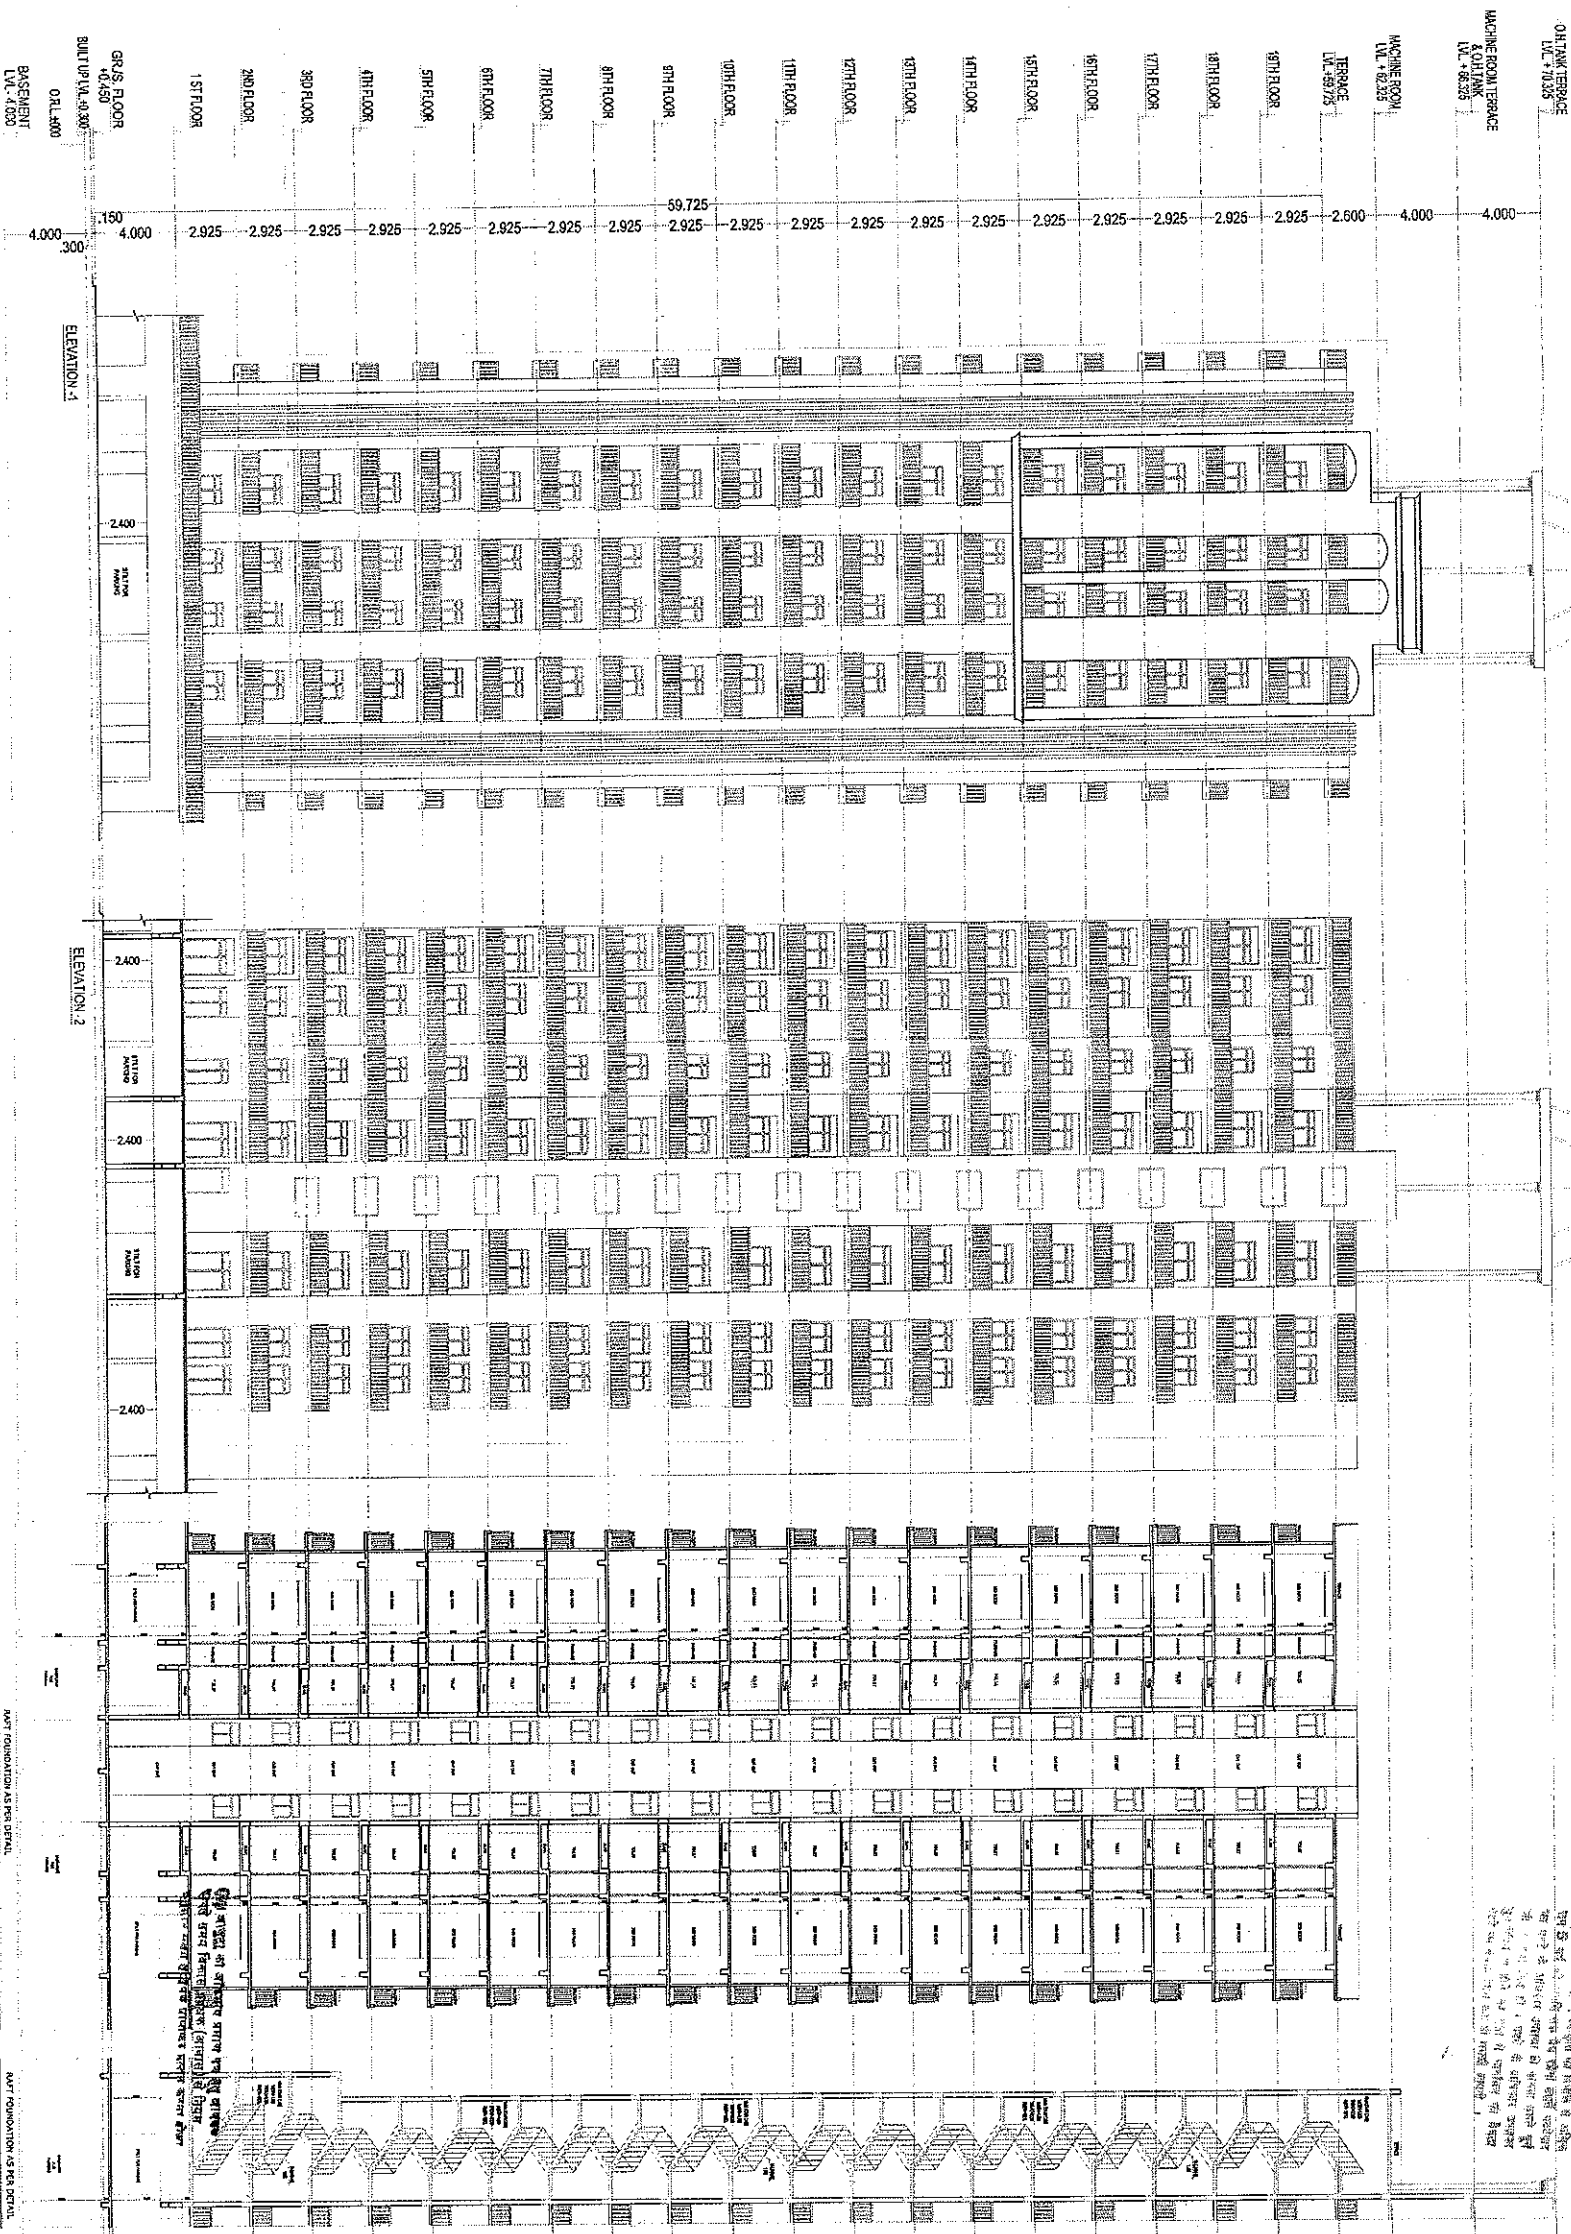

For Gulshan Homes And Infrastructure Pvt. Ltd.

Authorized Signatory

OWNERS SIGN