

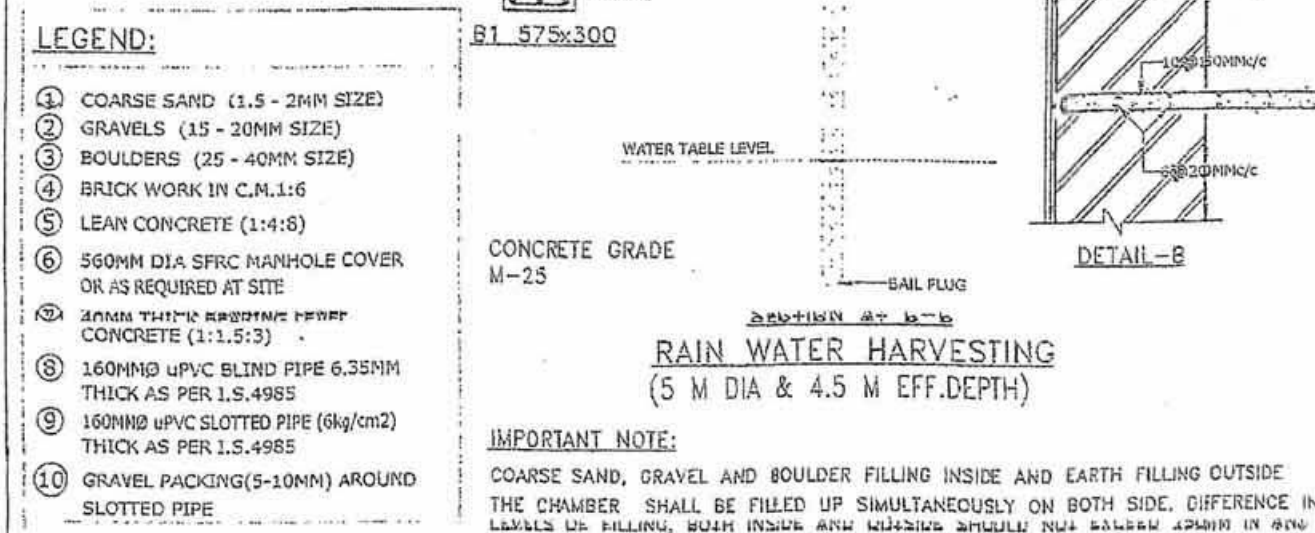
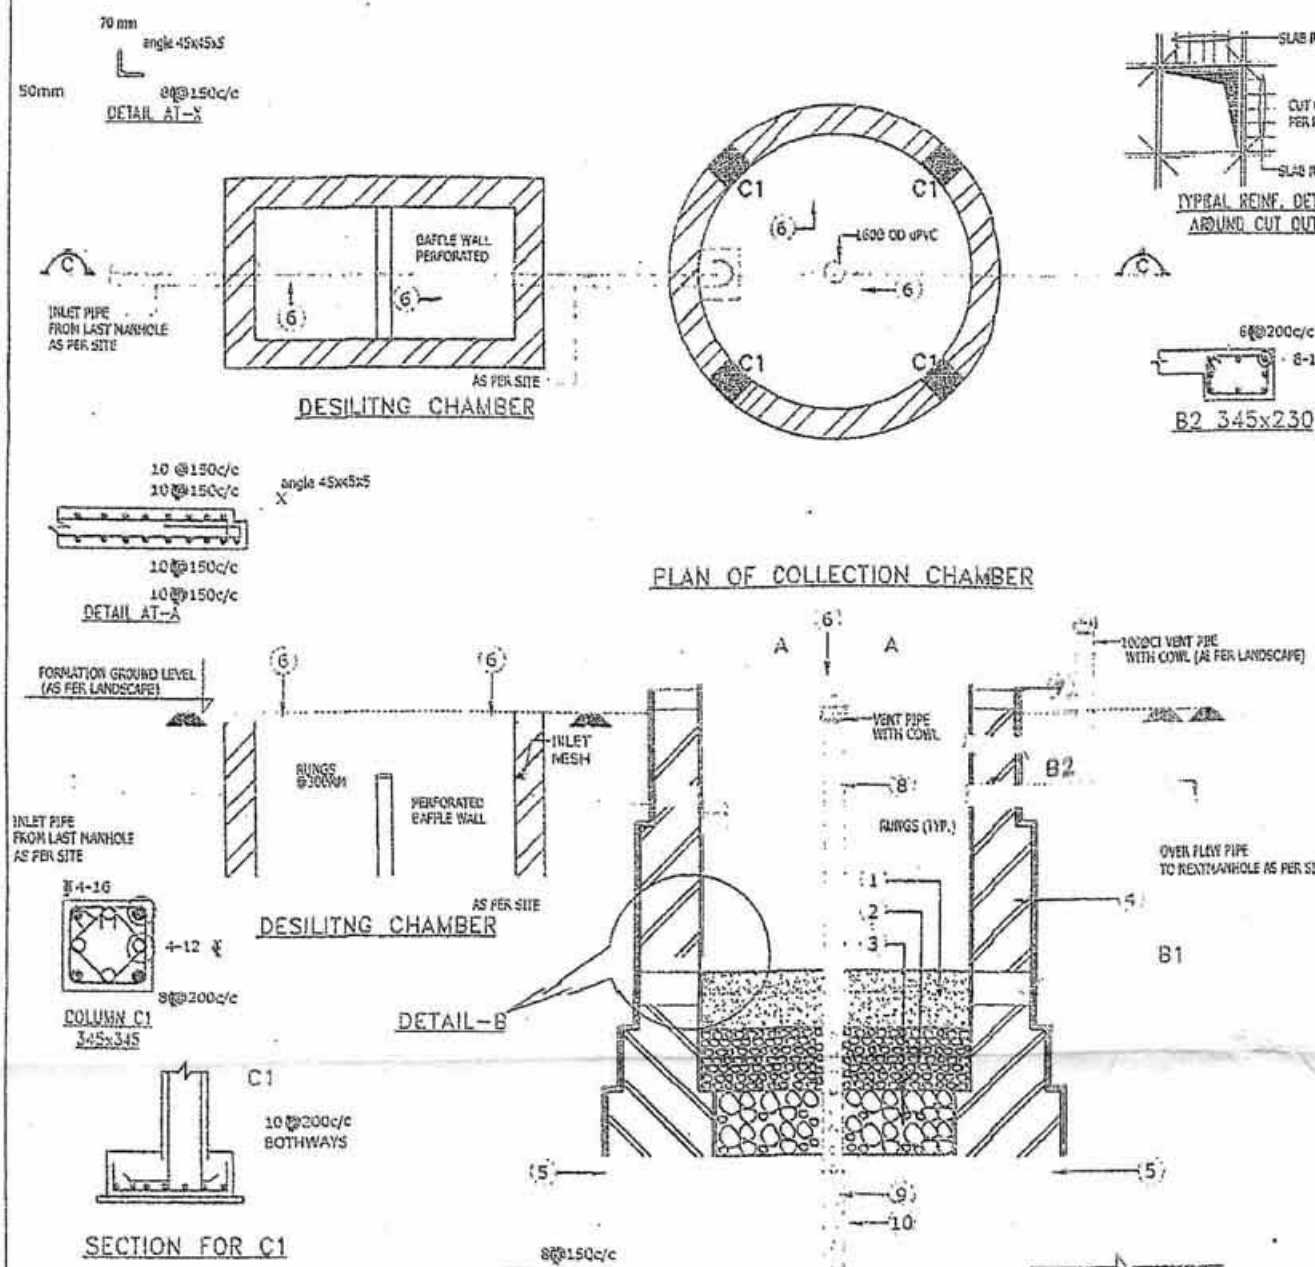
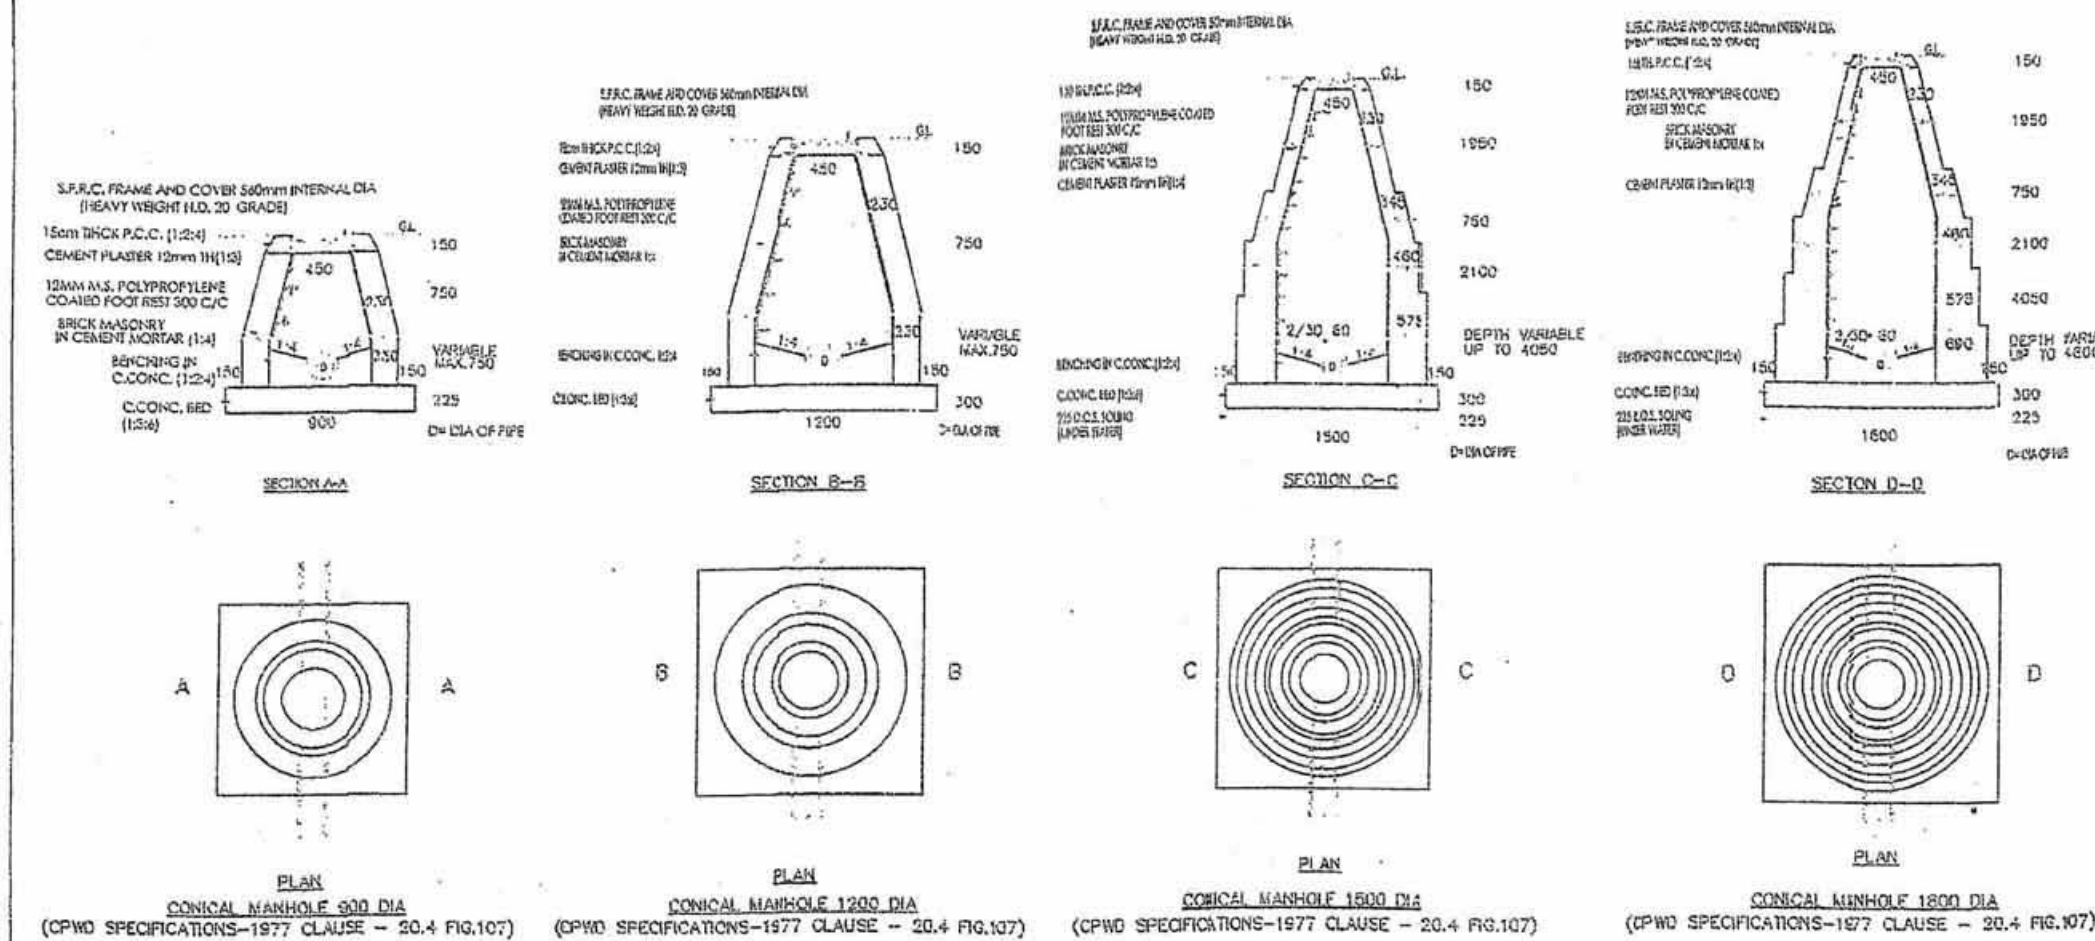
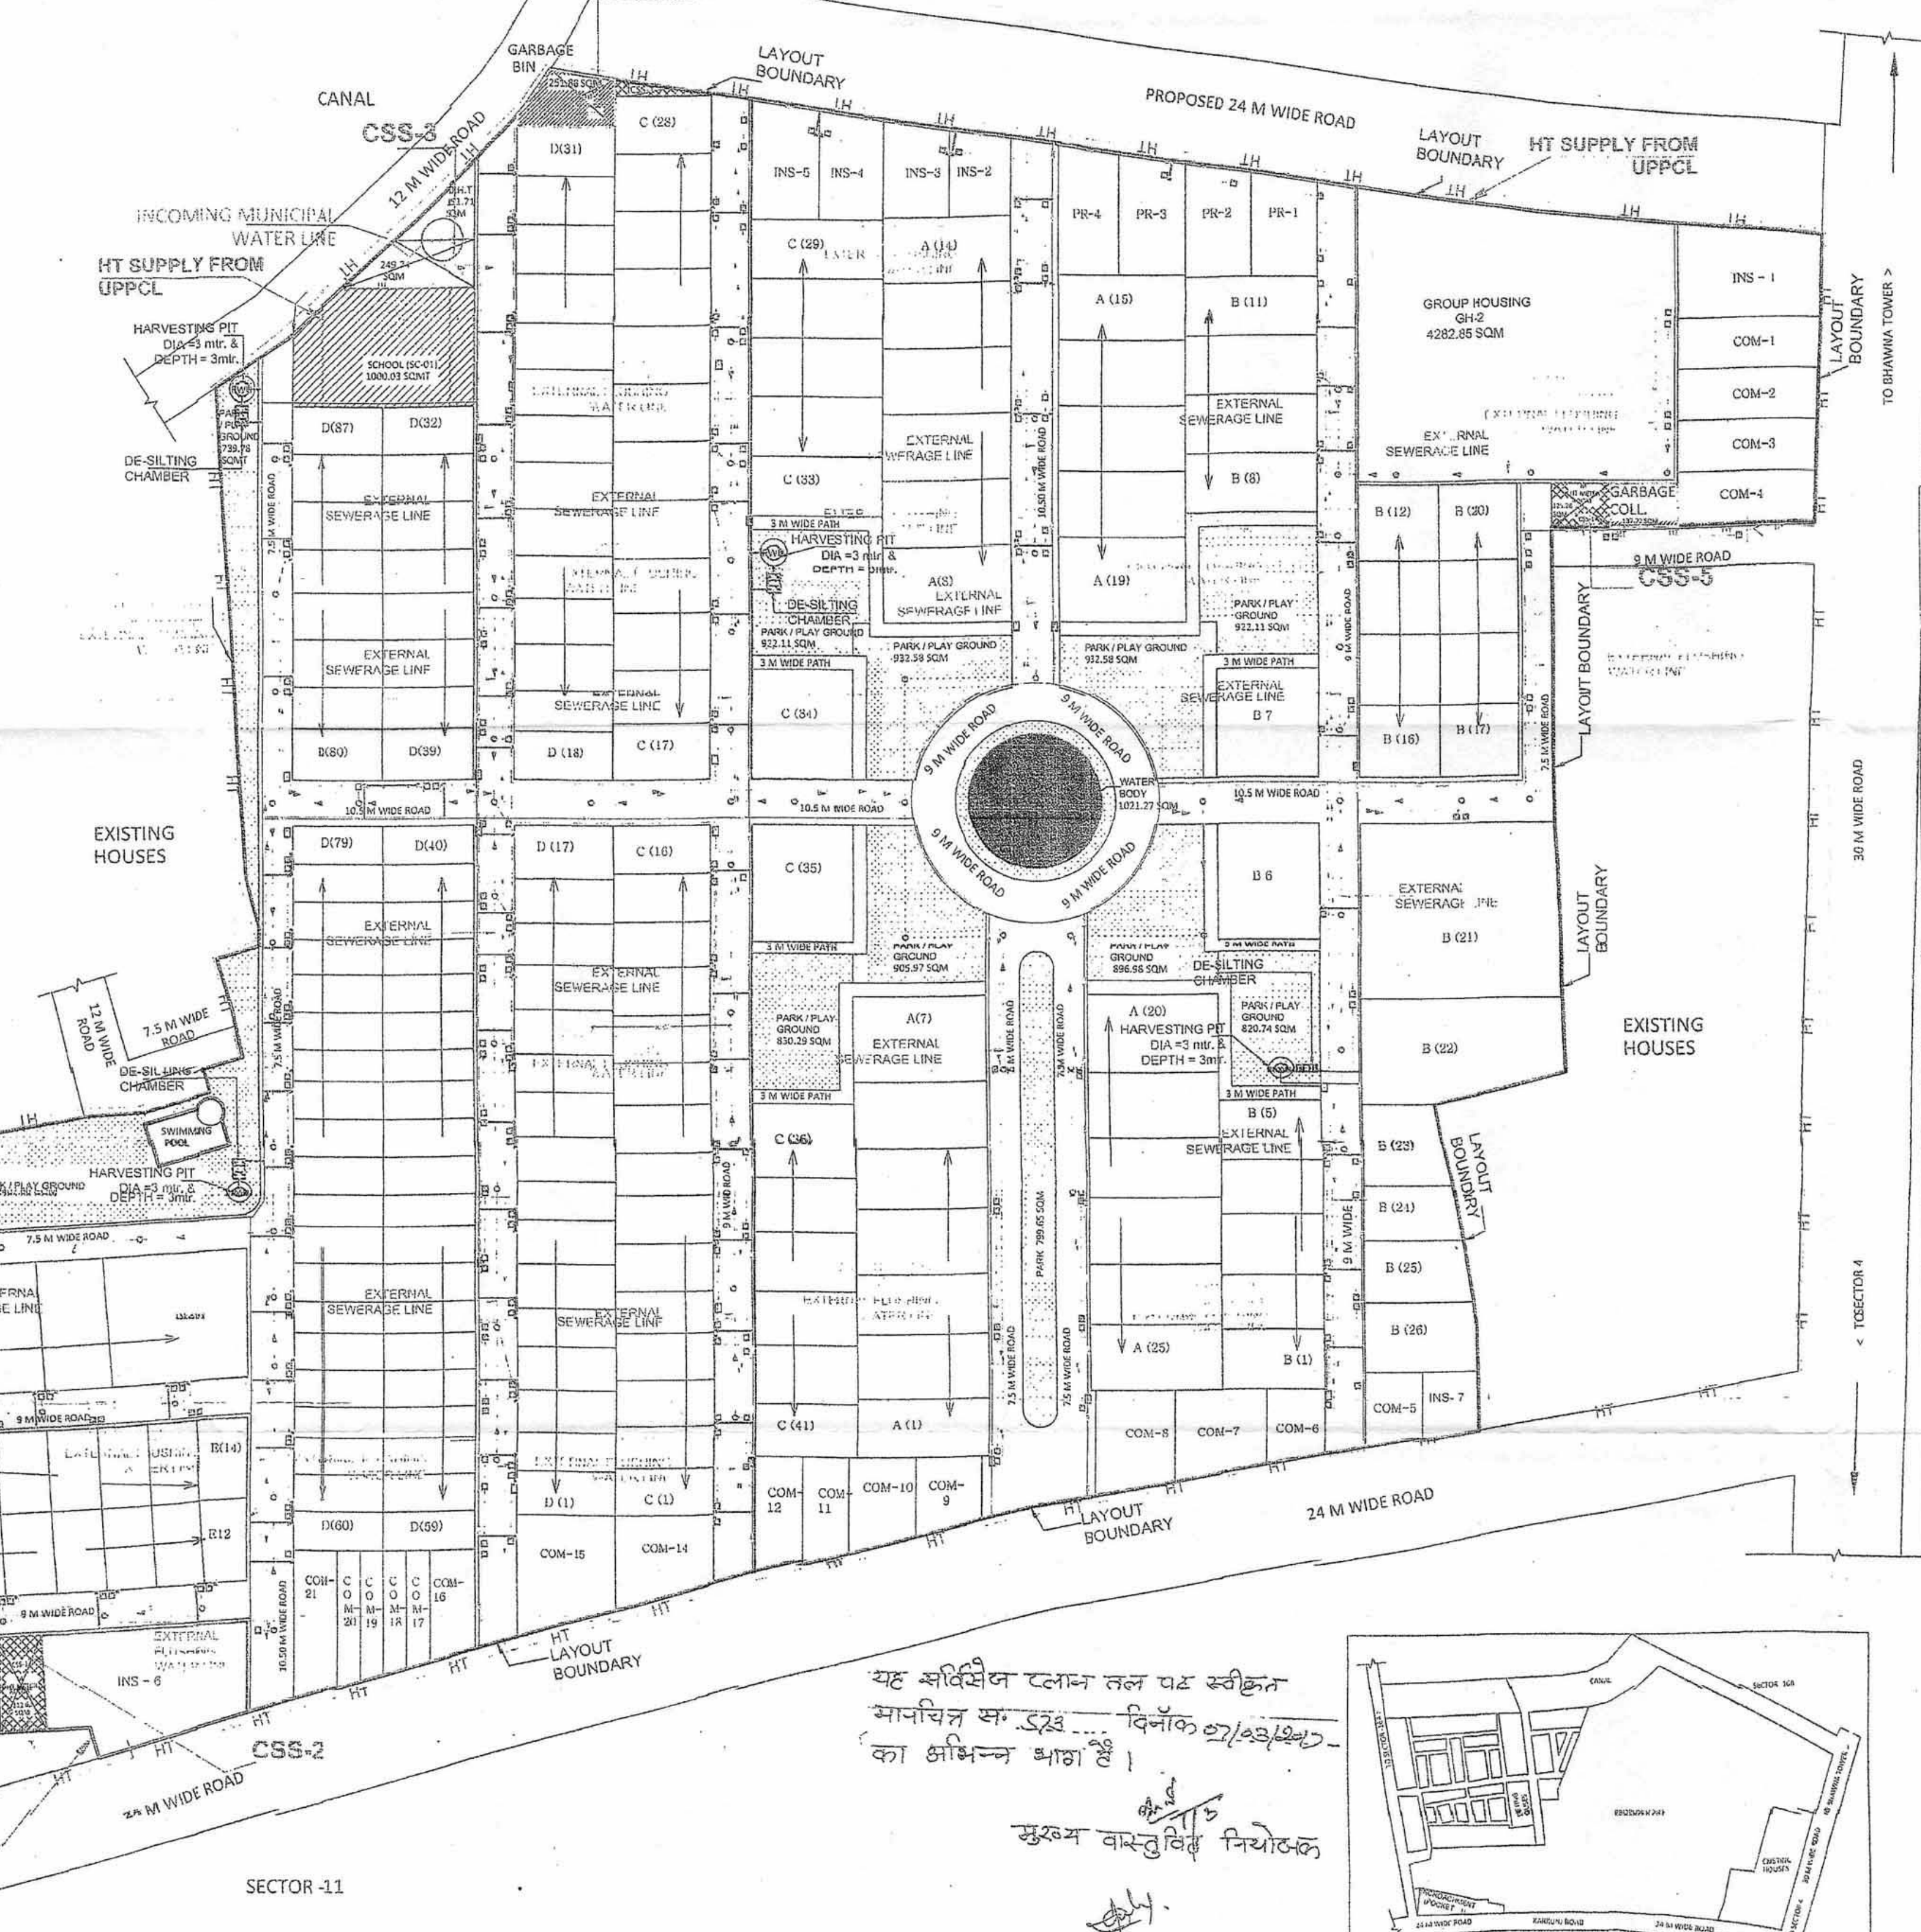
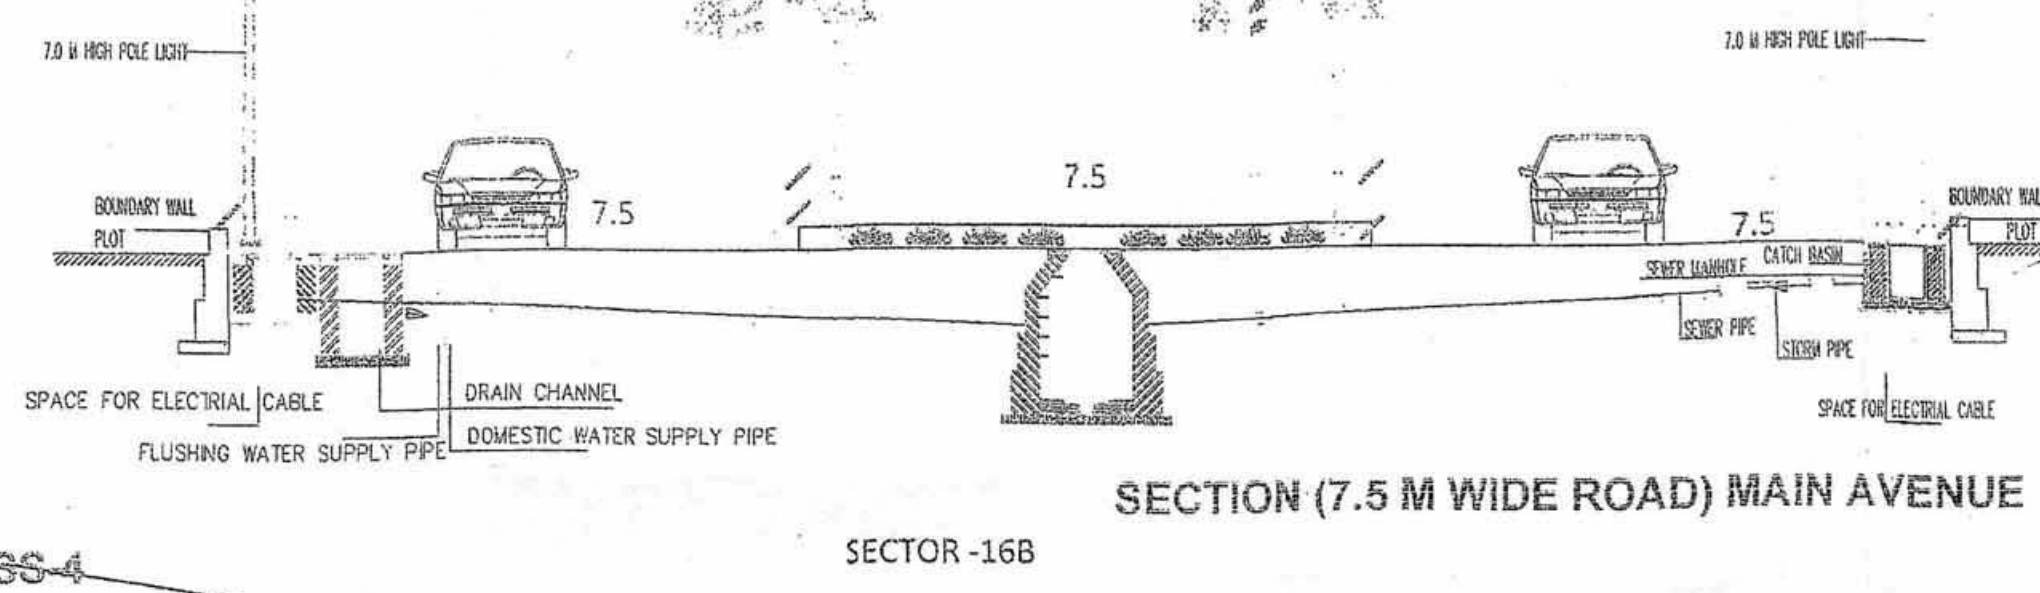


MANHOLE DETAIL

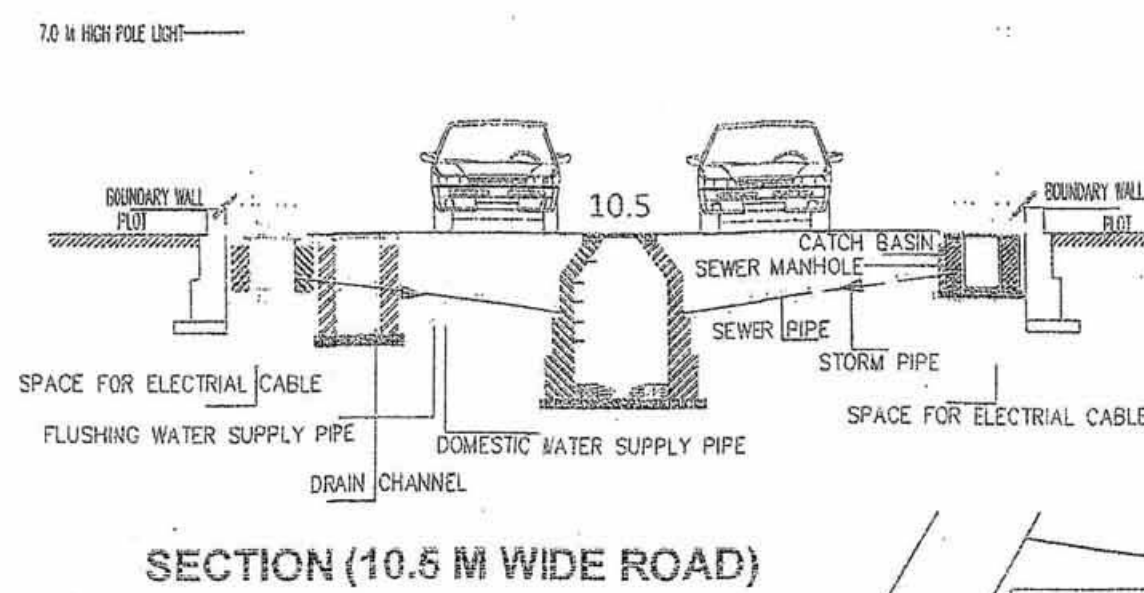

RWH DETAIL

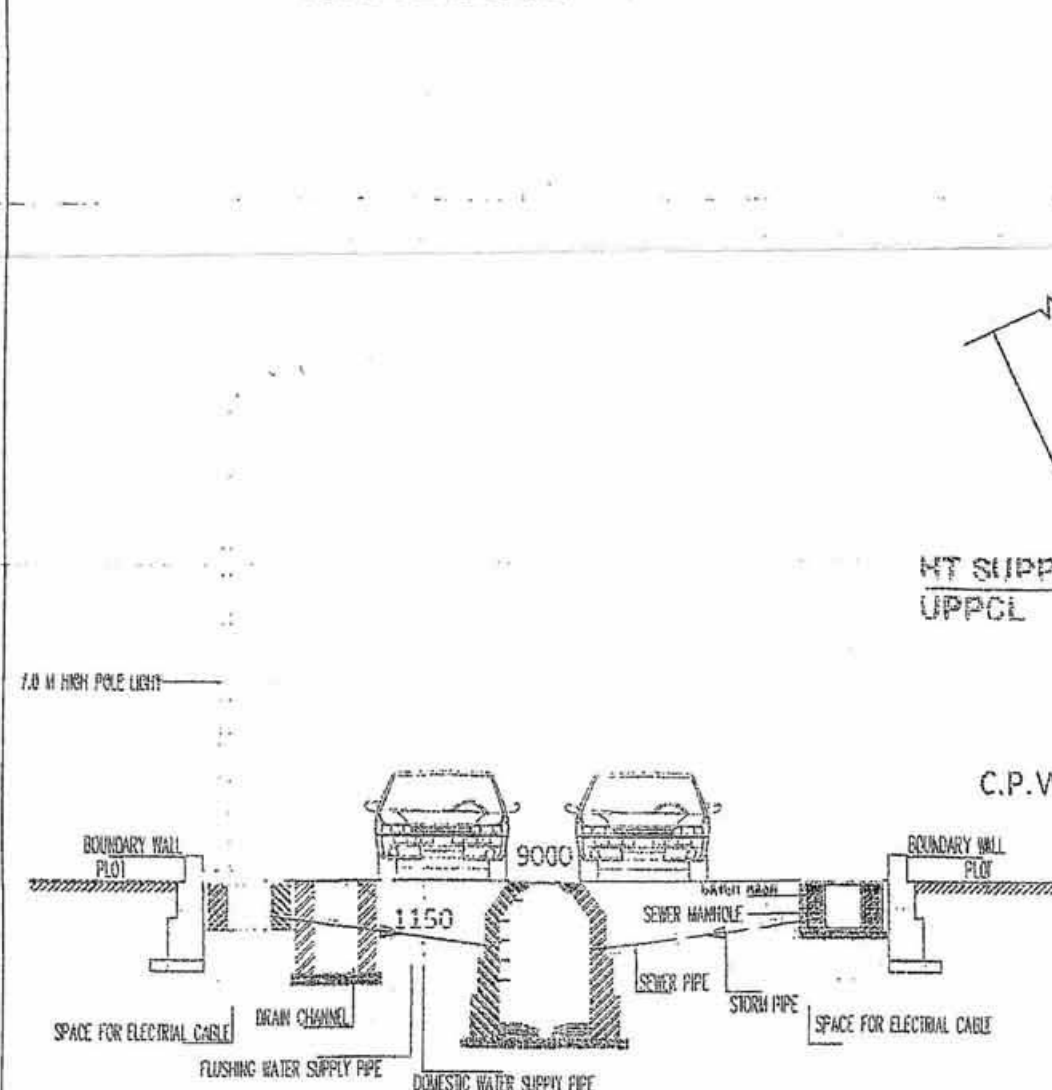

NOTES:

THIS ENTIRE DEVELOPMENT HAS BEEN CONCEIVED DESIGNED AND DRAFTED ON THE BASIS OF THE FOLLOWING PARAMETERS:
1. ALL DIMENSIONS ARE IN METERS.
2. DIMENSIONS NOT TO BE SCALED.
3. ALL DIMENSIONS TO BE READ NOT TO BE SCALED.
4. ALL PARAMETERS OF INDIVIDUAL PLOTS SHALL BE AS PER UPV/DH 2008 & AMENDMENTS 2016.

SUBMISSION DRAWING

SYMBOL	DESCRIPTION
	GULLY TRAP
	SEWERAGE MANHOLE
	STORM MANHOLE
	EXTERNAL GARDEN IRRIGATION LINE
	SEWERAGE LINE
	STORM LINE

SYMBOL	DESCRIPTION
	COMPACT SUB STATION
	EXTERNAL FEEDER PILLAR
	HT SUPPLY IN UNDER GROUND
	LT SUPPLY IN UNDER GROUND
	HT SUPPLY IN HOPE PIPE
	LT SUPPLY IN HOPE PIPE

SOLID WASTE MANAGEMENT

- DOOR TO DOOR COLLECTION OF SOLID WASTE WILL BE TAKEN UP BY ADMINISTRATION STAFF UNDER R.W.A.
- COLLECTION OF SOLID WASTE WILL BE DONE BY GARBAGE COLLECTOR IN A MANUAL RICKSHAW.
- SOLID WASTE WILL BE DISPOSED AT THE GARBAGE BIN, LOCATED AT THE CORNER OF THE PROPERTY OF THE PLOTTED DEVELOPMENT.
- LOCAL MUNICIPAL AUTHORITY SHALL COLLECT THE SOLID WASTE FROM THE GARBAGE BINS, AND SENT IT FOR RECYCLING /DUMPING AT WASTE COLLECTION LAND.

DRAWING TITLE: COORDINATE LAYOUT OF SITE PLAN AND DETAILS

PROJECT TITLE: PROPOSED LAYOUT PLAN OF ANTHEM, SEC-15 POCKET -A, SIKANDRA YOJNA, AGRA

CLIENT: BHARAT NAGAR HOUSING SHOBHIK GOYAL

DRAWN BY: R.K. CHECKED BY: R.R.

DATE: 27/02/2017 DRAWING NO. SD02

SCALE 1:1000 NORTH:

SHEET NO. 02

CLIENT:
ARCHITECT:

ARCHITECT: NEXUSPLUS CONSULTANTS PVT. LTD.
B-118 2ND FLOOR, SECTOR-50, NOIDA-201301
PHONE NO. 0120 4355781 / 4250663