


LEGEND:-

SOIL PIPE		
WASTE PIPE		
RAIN PIPE		
COLD WATER SUPPLY (CWS)		
HOT WATER SUPPLY (HWS) WITH INSULATION		
VENT PIPE		
EXTERNAL RAIN WATER PIPE		
SEWER LINE- EXTERNAL		
SEWERAGE MANHOLE		
STORM WATER MANHOLE		
KHURRA		
GALLY TRAP		
FLOOR TRAP (FT)		

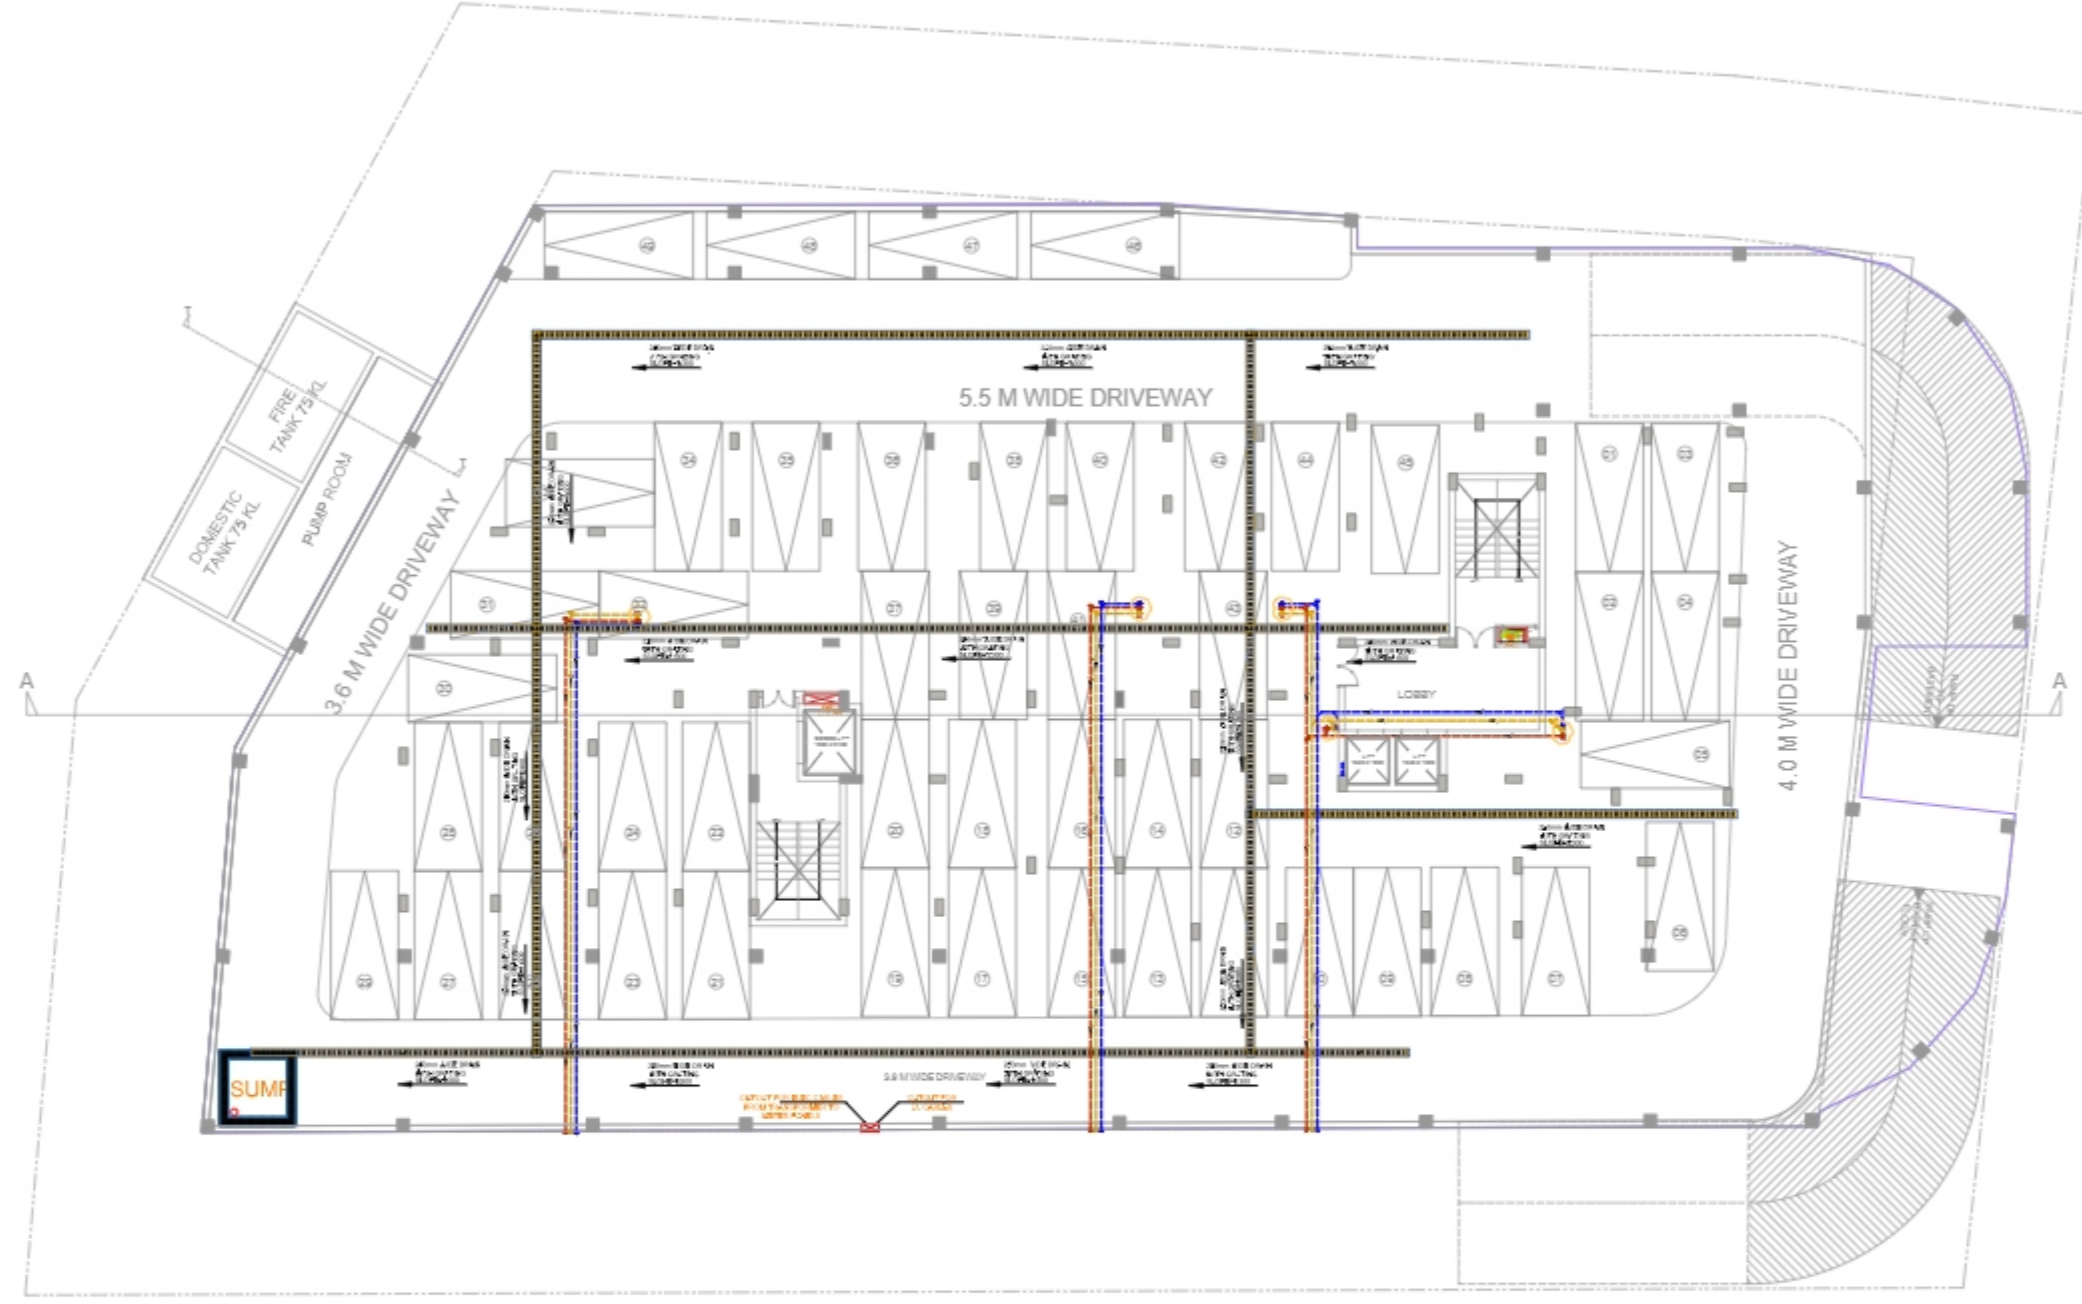

**BASEMENT FLOOR
PLUMBING LAYOUT**

NOTES

- * THIS DRAWING IS THE PROPERTY OF AVIGHNA ASSOCIATES AND IS NOT TO BE REPRODUCED, COPIED OR HANDLED OVER TO A THIRD PARTY OR USED FOR ANY OTHER PURPOSE OTHER THAN THAT FOR WHICH IT IS INTENDED.
- * DIMENSIONS ARE TO BE READ AND NOT MEASURED.
- * ASSUME ANY MISSING DIMENSION FROM SITE.
- * STRUCTURE & WALL ASBITE ACTUALS.
- * WALLS 1" THICK UNLESS NOTED OTHERWISE.
- * PLEASE BRING ANY DISCREPANCY IN DRAWING TO ARCHITECT BEFORE COMMENCING WORK AT SITE.
- * REFER SITE DRAWING FOR REINFORCEMENT.
- * REFER COLUMN SCHEDULE DRAWING.
- * THIS DRAWING IS STRICTLY FOR DEMARCATION OF COLUMNS & EXCAVATION.
- * SECTION PROVIDED FOR LEVELS.

LEGEND

SNO	SYMBOLS	DESCRIPTION

AVIGHNA CONSULTANT
 A-1, PATH NO. 4, JAMUNA NAGAR,
 SOULJA, JALPAIGURI DISTRICT,
 WEST BENGAL, INDIA.
 PH: NO. +91 941 2221000, 9214308430.

CLIENT:-

PROJECT:-
 HKD GANPATI
 BRAHMADEO APARTMENT

DWG. TITLE:-
 BASEMENT FLOOR
 PLUMBING LAYOUT PLAN

avighna associates
 ARCHITECTS, INTERIORS DESIGNERS & PLANNERS
 Studio: 2nd floor, 2nd & 3rd, 1st, 2nd, 3rd, 4th, 5th, 6th, 7th, 8th, 9th, 10th, 11th, 12th, 13th, 14th, 15th, 16th, 17th, 18th, 19th, 20th, 21st, 22nd, 23rd, 24th, 25th, 26th, 27th, 28th, 29th, 30th, 31st, 32nd, 33rd, 34th, 35th, 36th, 37th, 38th, 39th, 40th, 41st, 42nd, 43rd, 44th, 45th, 46th, 47th, 48th, 49th, 50th, 51st, 52nd, 53rd, 54th, 55th, 56th, 57th, 58th, 59th, 60th, 61st, 62nd, 63rd, 64th, 65th, 66th, 67th, 68th, 69th, 70th, 71st, 72nd, 73rd, 74th, 75th, 76th, 77th, 78th, 79th, 80th, 81st, 82nd, 83rd, 84th, 85th, 86th, 87th, 88th, 89th, 90th, 91st, 92nd, 93rd, 94th, 95th, 96th, 97th, 98th, 99th, 100th.

For HKDGANPATI INFRASHAPERS LLP


 Designated Partner



SCALE	N.T.S.	NORTH	REV.
DATE	04-03-2023		
DRG. STATUS	D.P.A.		
DEALT BY	PRANJANA		DRG. NO.
CHECKED BY	KUNAL		ΔΔ-0907-01

LEGEND:-

SOIL PIPE		
WASTE PIPE		
RAIN PIPE		
COLD WATER SUPPLY (CWS)		
HOT WATER SUPPLY (HWS) WITH INSULATION		
VENT PIPE		
EXTERNAL RAIN WATER PIPE		
SEWER LINE- EXTERNAL		
SEWERAGE MANHOLE		
STORM WATER MANHOLE		
KHURRA		
GALLY TRAP		
FLOOR TRAP (FT)		

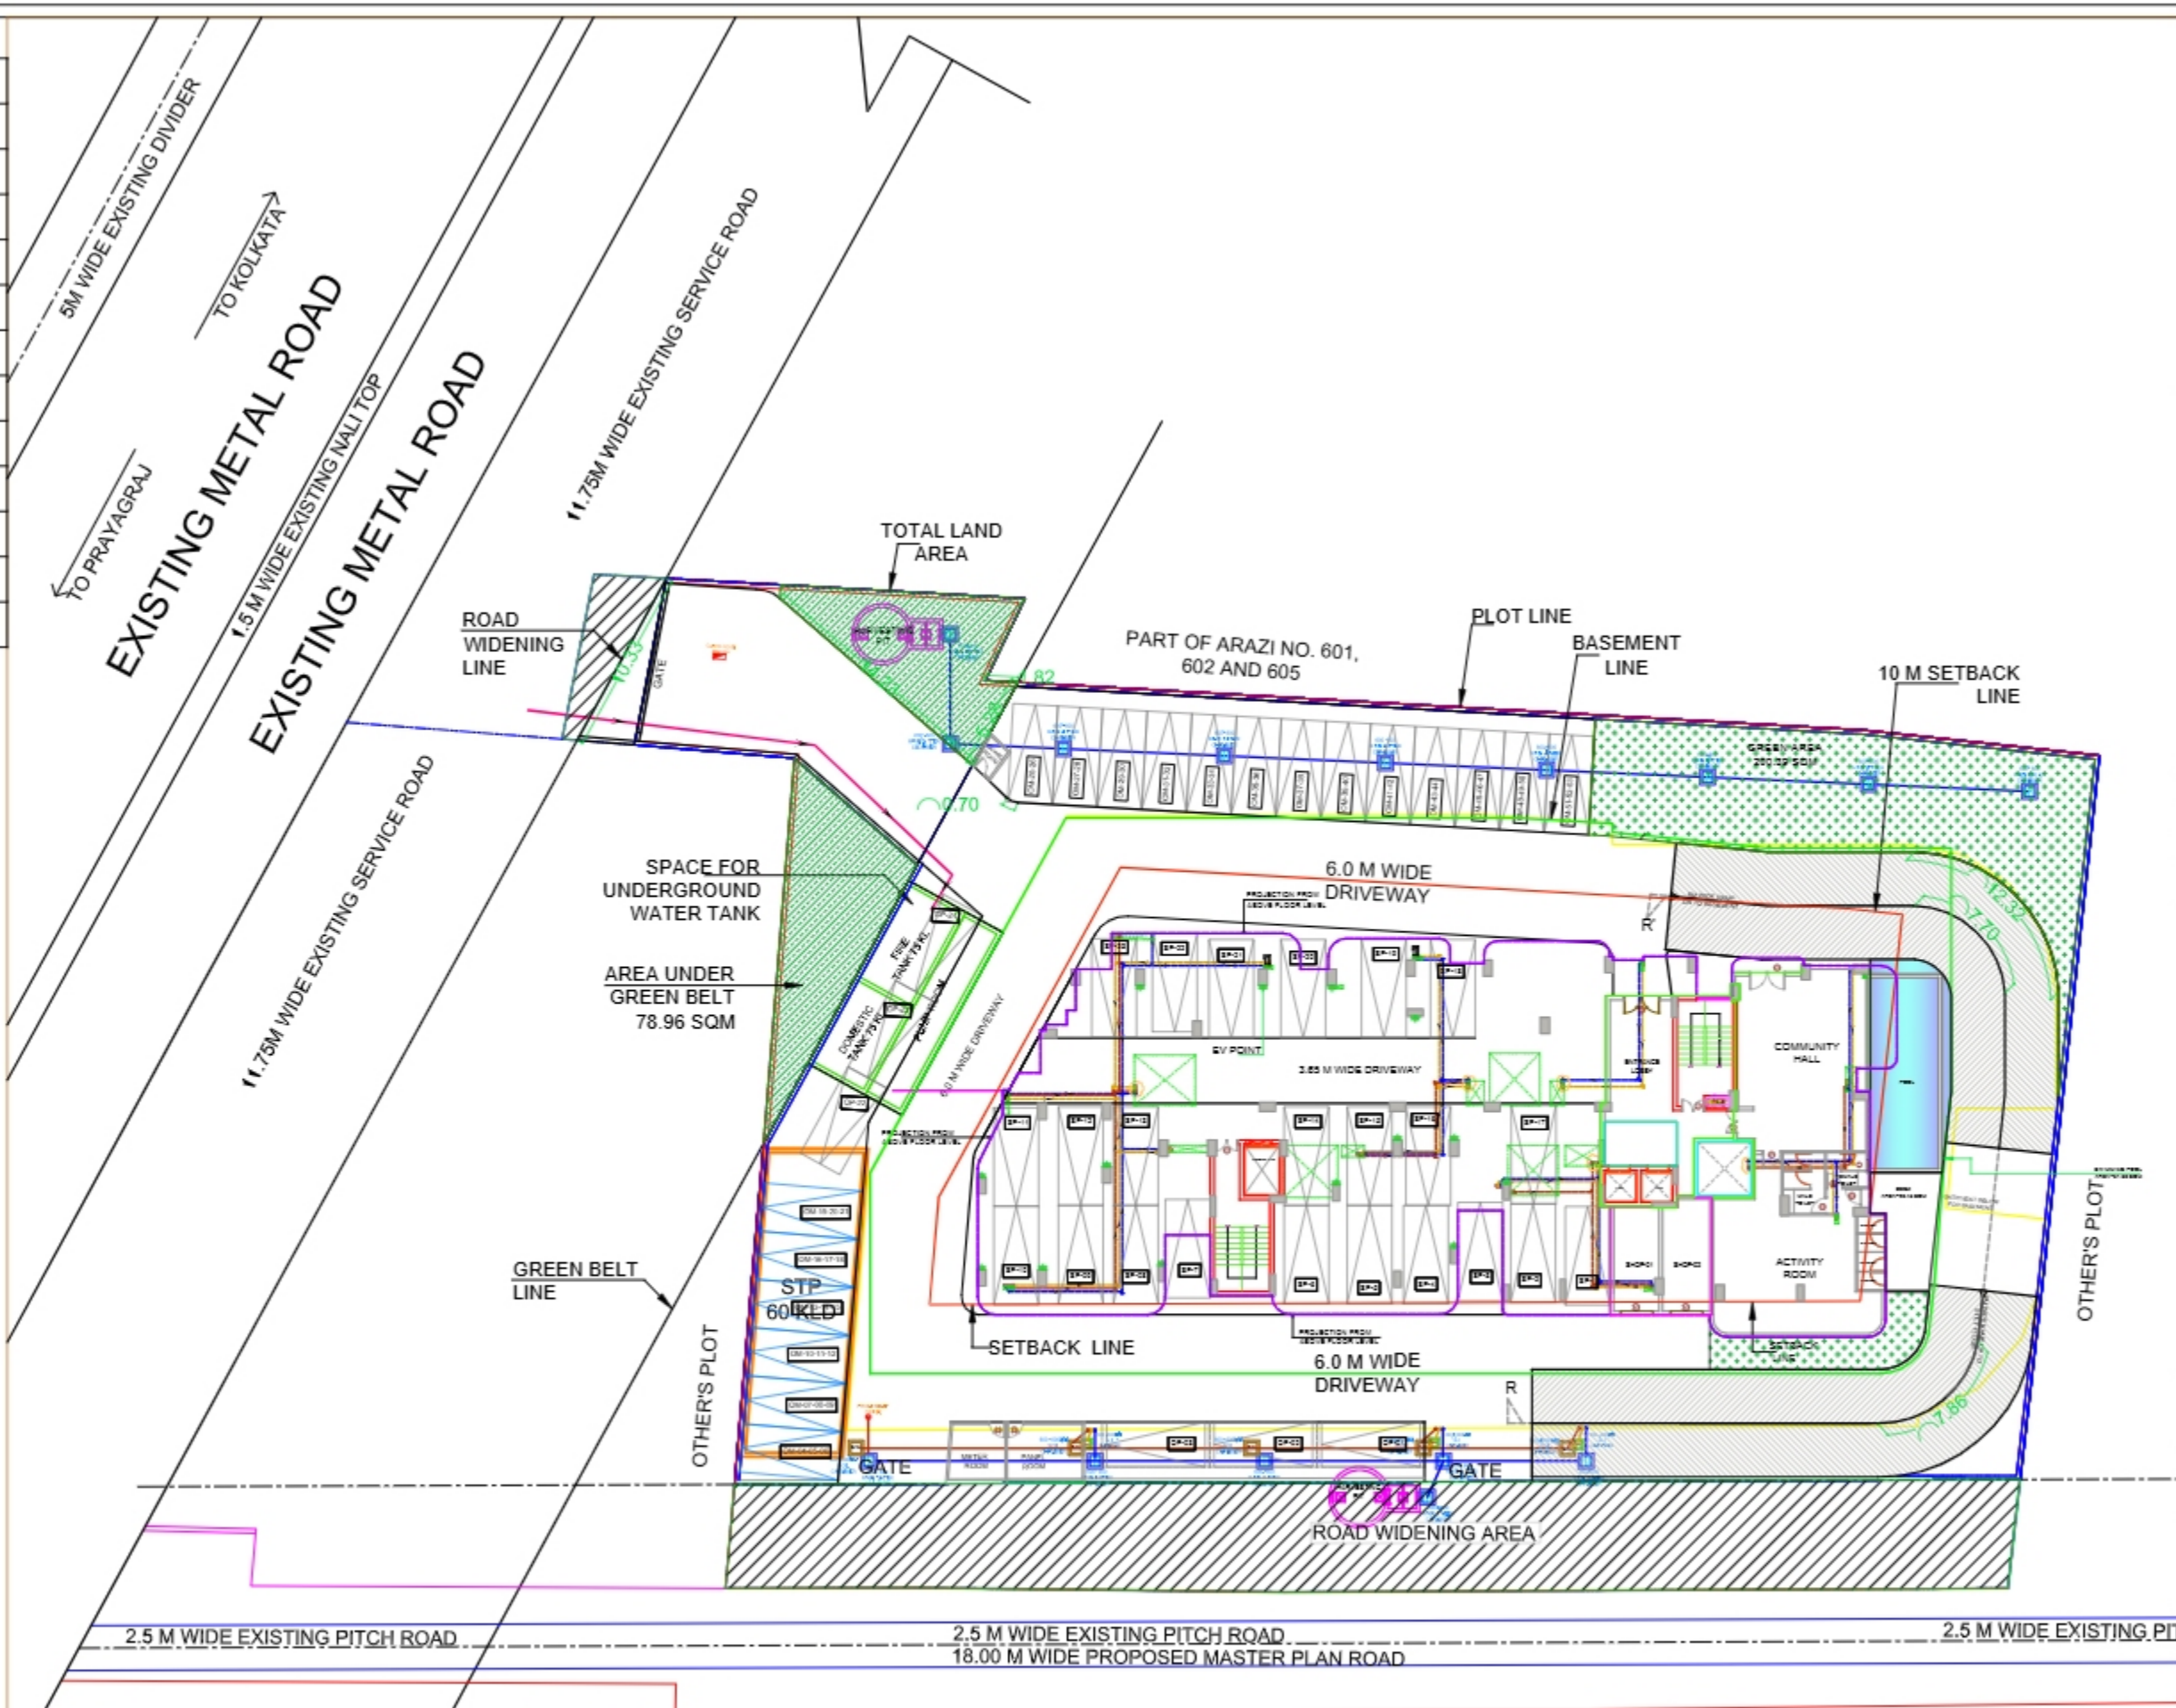

NOTES

- * THIS DRAWING IS THE PROPERTY OF AVIGHNA ASSOCIATES AND IS NOT TO BE REPRODUCED, COPIED OR HANDLED OVER TO A THIRD PARTY OR USED FOR ANY OTHER PURPOSE OTHER THAN THAT FOR WHICH IT IS INTENDED.
- * DIMENSIONS ARE TO BE READ AND NOT MEASURED.
- * ASSUME ANY MISSING DIMENSION FROM SITE.
- * STRUCTURES & WALL ARE AS BUILT.
- * WALLS 1" THICK UNLESS NOTED OTHERWISE.
- * PLEASE BRING ANY DISCREPANCY IN DRAWING TO ARCHITECT BEFORE COMMENCING WORK AT SITE.
- * REFER SITE DRAWING FOR REINFORCEMENT.
- * REFER COLUMN SCHEDULE DRAWING FOR DEMARCATION OF COLUMNS & EXCAVATION.
- * SECTION PROVIDED FOR LEVELS.

LEGEND

SNO	SYMBOLS	DESCRIPTION

CLIENT:-

avighna consultant
 A. PATHI & JAYAN NAIK,
 SOHRA, JALPAIGURI
 DISTRICT - Cooch Behar
 PIN NO. 713 141 222105, 713135430

PROJECT:-

HKD GANPATI
 BRAHMADEO APARTMENT

DWG. TITLE:-

SITE PLAN PLUMBING
 LAYOUT PLAN

avighna associates
 ARCHITECTS, INTERIORS DESIGNERS & PLANNERS
 10/10, 2nd Floor, Block B, Office No. 103, West
 Bengal, Kolkata, West Bengal - 700015, India
 Email: avighnaassociates@gmail.com

**GROUND FLOOR
 PLUMBING LAYOUT**

For HKDGANPATI INFRA SHAPERS LLP

 Designated Partner



SCALE	N.T.S	NORTH	REV.
DATE	04-03-2023		
DRG. STATUS	D.P.A.		
DEALT BY	PRANJAN	DRG. NO.	
CHECKED BY	KUNAL	AS-DRG-01	

LEGEND:-		
SOIL PIPE		
WASTE PIPE		
RAIN PIPE		
COLD WATER SUPPLY (CWS)		
HOT WATER SUPPLY (HWS) WITH INSULATION		
VENT PIPE		
EXTERNAL RAIN WATER PIPE		
SEWER LINE- EXTERNAL		
SEWERAGE MANHOLE		
STORM WATER MANHOLE		
KHURRA		
GALLY TRAP		
FLOOR TRAP (FT)		



FIRST FLOOR PLUMBING LAYOUT

- NOTES**
- * THIS DRAWING IS THE PROPERTY OF AVIGHNA ASSOCIATES AND IS NOT TO BE REPRODUCED, COPIED OR HANDLED OVER TO A THIRD PARTY OR USED FOR ANY OTHER PURPOSE OTHER THAN THAT FOR WHICH IT IS INTENDED.
 - * DIMENSIONS ARE TO BE READ AND NOT MEASURED.
 - * ASSUME ANY MISSING DIMENSION FROM SITE.
 - * STRUCTURE & WALL ASBTS ACTUALS.
 - * WALLS 1" THICK UNLESS NOTED OTHERWISE.
 - * PLEASE BRING ANY DISCREPANCY IN DRAWING TO ARCHITECT BEFORE COMMENCING WORK AT SITE.
 - * REFER SITE DRAWING FOR REINFORCEMENT.
 - * REFER COLUMN SCHEDULE DRAWING.
 - * THIS DRAWING IS STRICTLY FOR DEMARCATION OF COLUMNS & EXCAVATION.
 - * SECTION PROVIDED FOR LEVELS.

LEGEND		
S.NO	SYMBOLS	DESCRIPTION

CLIENT:-
 HKD GANPATI
 BRAHMADEO APARTMENT

PROJECT:-
 HKD GANPATI
 BRAHMADEO APARTMENT

DWG. TITLE:-
 FIRST FLOOR
 PLUMBING LAYOUT PLAN

avighna associates
 ARCHITECTS, INTERIORS DESIGNERS & PLANNERS
 1001, 2nd floor, 2nd & 3rd, 4th, 5th, 6th, 7th, 8th, 9th, 10th, 11th, 12th, 13th, 14th, 15th, 16th, 17th, 18th, 19th, 20th, 21st, 22nd, 23rd, 24th, 25th, 26th, 27th, 28th, 29th, 30th, 31st, 32nd, 33rd, 34th, 35th, 36th, 37th, 38th, 39th, 40th, 41st, 42nd, 43rd, 44th, 45th, 46th, 47th, 48th, 49th, 50th, 51st, 52nd, 53rd, 54th, 55th, 56th, 57th, 58th, 59th, 60th, 61st, 62nd, 63rd, 64th, 65th, 66th, 67th, 68th, 69th, 70th, 71st, 72nd, 73rd, 74th, 75th, 76th, 77th, 78th, 79th, 80th, 81st, 82nd, 83rd, 84th, 85th, 86th, 87th, 88th, 89th, 90th, 91st, 92nd, 93rd, 94th, 95th, 96th, 97th, 98th, 99th, 100th

For HKDGANPATI INFRASHAPERS LLP

 Designated Partner

SCALE	N.T.S	NORTH	REV.
DATE	20-02-2023		
DRG. STATUS	DT.A		
DEALT BY	PRANJAL	DRG. NO.	
CHECKED BY	KUNAL	AS-DWG-01	

LEGEND:-		
SOIL PIPE		
WASTE PIPE		
RAIN PIPE		
COLD WATER SUPPLY (CWS)		
HOT WATER SUPPLY (HWS) WITH INSULATION		
VENT PIPE		
EXTERNAL RAIN WATER PIPE		
SEWER LINE- EXTERNAL		
SEWERAGE MANHOLE		
STORM WATER MANHOLE		
KHURRA		
GALLY TRAP		
FLOOR TRAP (FT)		



TYPICAL FLOOR PLUMBING LAYOUT

For HKDGANPATI INFRASTRUCTURE LLP
Jugal Kataria
 Designated Partner



- NOTES**
- * THIS DRAWING IS THE PROPERTY OF AVIGHNA ASSOCIATES AND IS NOT TO BE REPRODUCED, COPIED OR HANDLED OVER TO A THIRD PARTY OR USED FOR ANY OTHER PURPOSE OTHER THAN THAT FOR WHICH IT IS INTENDED.
 - * DIMENSIONS ARE TO BE READ AND NOT MEASURED.
 - * ASSUME ANY MISSING DIMENSION FROM SITE.
 - * STRUCTURE & WALL ASBITE ACTUALS.
 - * WALLS 1" THICK UNLESS NOTED OTHERWISE.
 - * PLEASE BRING ANY DISCREPANCY IN DRAWING TO ARCHITECT BEFORE COMMENCING WORK AT SITE.
 - * REFER SITE DRAWING FOR REINFORCEMENT.
 - * REFER COLUMN SCHEDULE DRAWING.
 - * THIS DRAWING IS STRICTLY FOR DEMARCATION OF COLUMNS & EXCAVATION.
 - * SECTION PROVIDED FOR LEVELS.

LEGEND		
S.NO	SYMBOLS	DESCRIPTION

AP/20/19/07
cubo consultant
 A-1, BATH NO. 4, JAMUNA NAGAR,
 SOONLA, JALPAIGURI
 EMAIL: cuboconsultant@gmail.com
 PH: NO. 901 941 2221000, 9214300430.

CLIENT:-


PROJECT:-
 HKD GANPATI
 BRAHMADEO APARTMENT

DWG. TITLE:-
 TYPICAL FLOOR PLUMBING
 LAYOUT PLAN

avighna associates
 ARCHITECTS, INTERIORS DESIGNERS & PLANNERS
 Studio: 2nd floor, Block 3, Office no. 303, Market
 Street, Malabar Hill, Mumbai - 400034, India
 Phone: 9822000000
 Email: avighnaassociates.com

SCALE	1:10	NORTH	REV.
DATE	04-03-2023		
DRG. STATUS	07.A		
DEALT BY	PRANJAN	DRG. NO.	
CHECKED BY	KUNAL	AS-DWG-01	

LEGEND:-		
SOIL PIPE		
WASTE PIPE		
RAIN PIPE		
COLD WATER SUPPLY (CWS)		
HOT WATER SUPPLY (HWS) WITH INSULATION		
VENT PIPE		
EXTERNAL RAIN WATER PIPE		
SEWER LINE- EXTERNAL		
SEWERAGE MANHOLE		
STORM WATER MANHOLE		
KHURRA		
GALLY TRAP		
FLOOR TRAP (FT)		

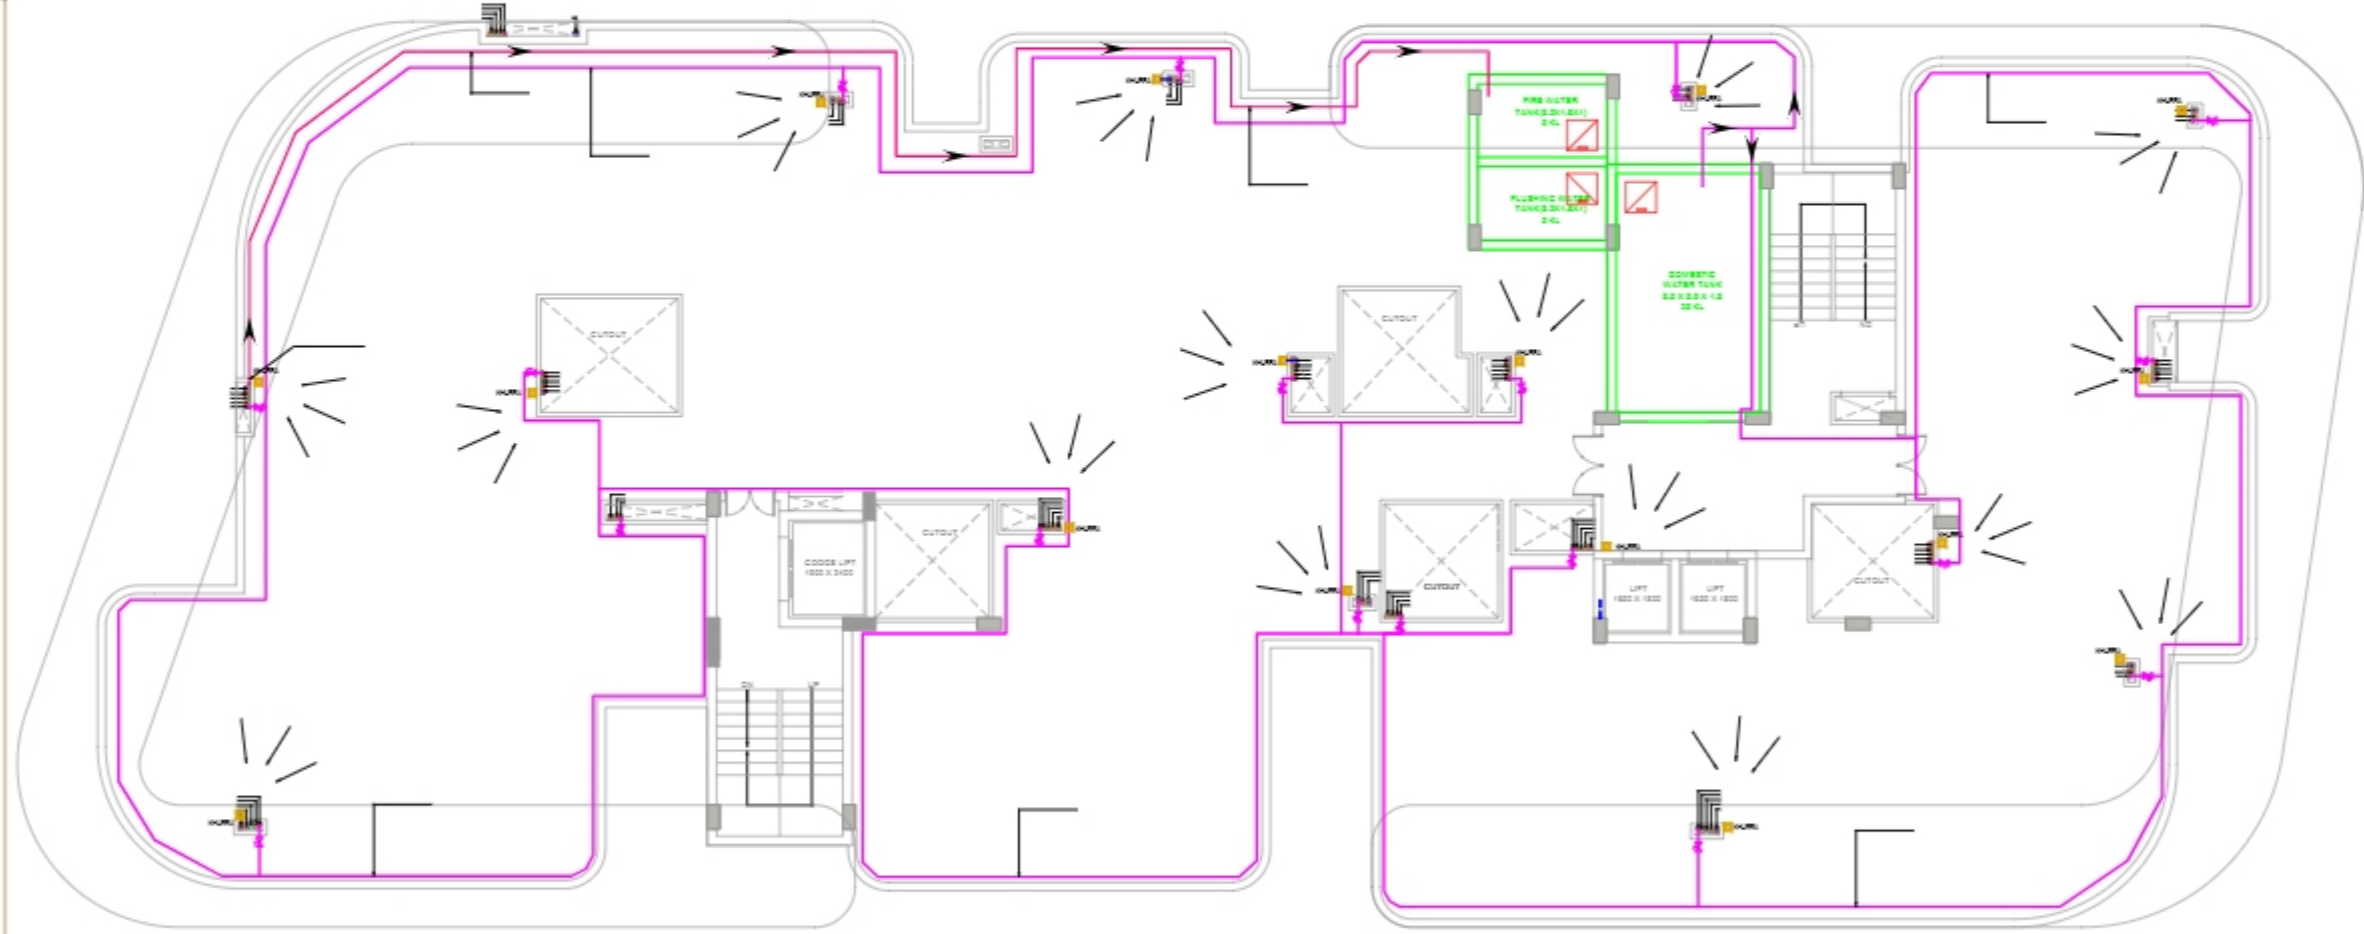

TERRACE FLOOR PLUMBING LAYOUT

- NOTES**
- * THIS DRAWING IS THE PROPERTY OF AVIGHNA ASSOCIATES AND IS NOT TO BE REPRODUCED, COPIED OR HANDLED OVER TO A THIRD PARTY OR USED FOR ANY OTHER PURPOSE OTHER THAN THAT FOR WHICH IT IS INTENDED.
 - * DIMENSIONS ARE TO BE READ AND NOT MEASURED.
 - * ASSUME ANY MISSING DIMENSION FROM SITE.
 - * STRUCTURE & WALL ARE AS ACTUAL.
 - * WALLS 1" THICK UNLESS NOTED OTHERWISE.
 - * PLEASE BRING ANY DISCREPANCY IN DRAWING TO ARCHITECT BEFORE COMMENCING WORK AT SITE.
 - * REFER SITE DRAWING FOR REINFORCEMENT.
 - * REFER COLUMN SCHEDULE DRAWING.
 - * THIS DRAWING IS STRICTLY FOR DEMARCATION OF COLUMNS & EXCAVATION.
 - * SECTION PROVIDED FOR LEVELS.

LEGEND		
S.NO	SYMBOLS	DESCRIPTION

AVIGNA CONSULTANT
 A-1, BATH NO. 4, JAMUNA NAGAR,
 SOHLA, JALPAIGANJ
 EMAIL: avignacivil@gmail.com
 PH. NO. +91 941 2221000, 9214300430.

CLIENT:-

PROJECT:-
 HKD GANPATI
 BRAHMADEO APARTMENT

DWG. TITLE:-
 TERRACE FLOOR PLUMBING
 LAYOUT PLAN

avighna associates
 ARCHITECTS, INTERIORS DESIGNERS & PLUMBERS
 Studio: 2nd floor, Block 3, Office no. 103, Market
 Street, Gurgaon, Gurgaon - 122001, Haryana
 India. WhatsApp: 919910000000
 Email: avignacivil@gmail.com

For HKDGANPATI INFRASHAPERS LLP

 Designated Partner



SCALE	N.T.S.	NORTH	REV.
DATE	09-09-2023		
DRG. STATUS	D.P.A.		
DEALT BY	PRANJAL	DRG. NO.	
CHECKED BY	KUNAL	AS-DWG-01	