
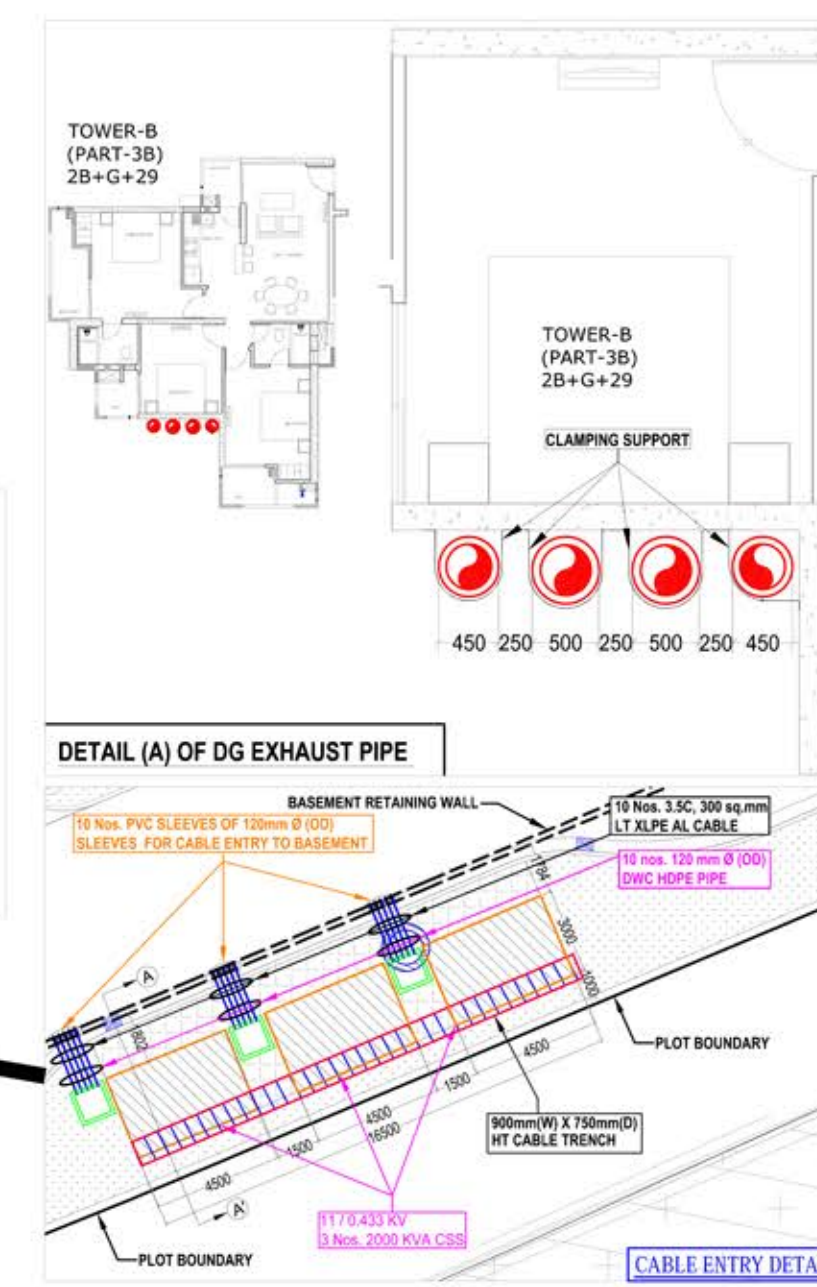
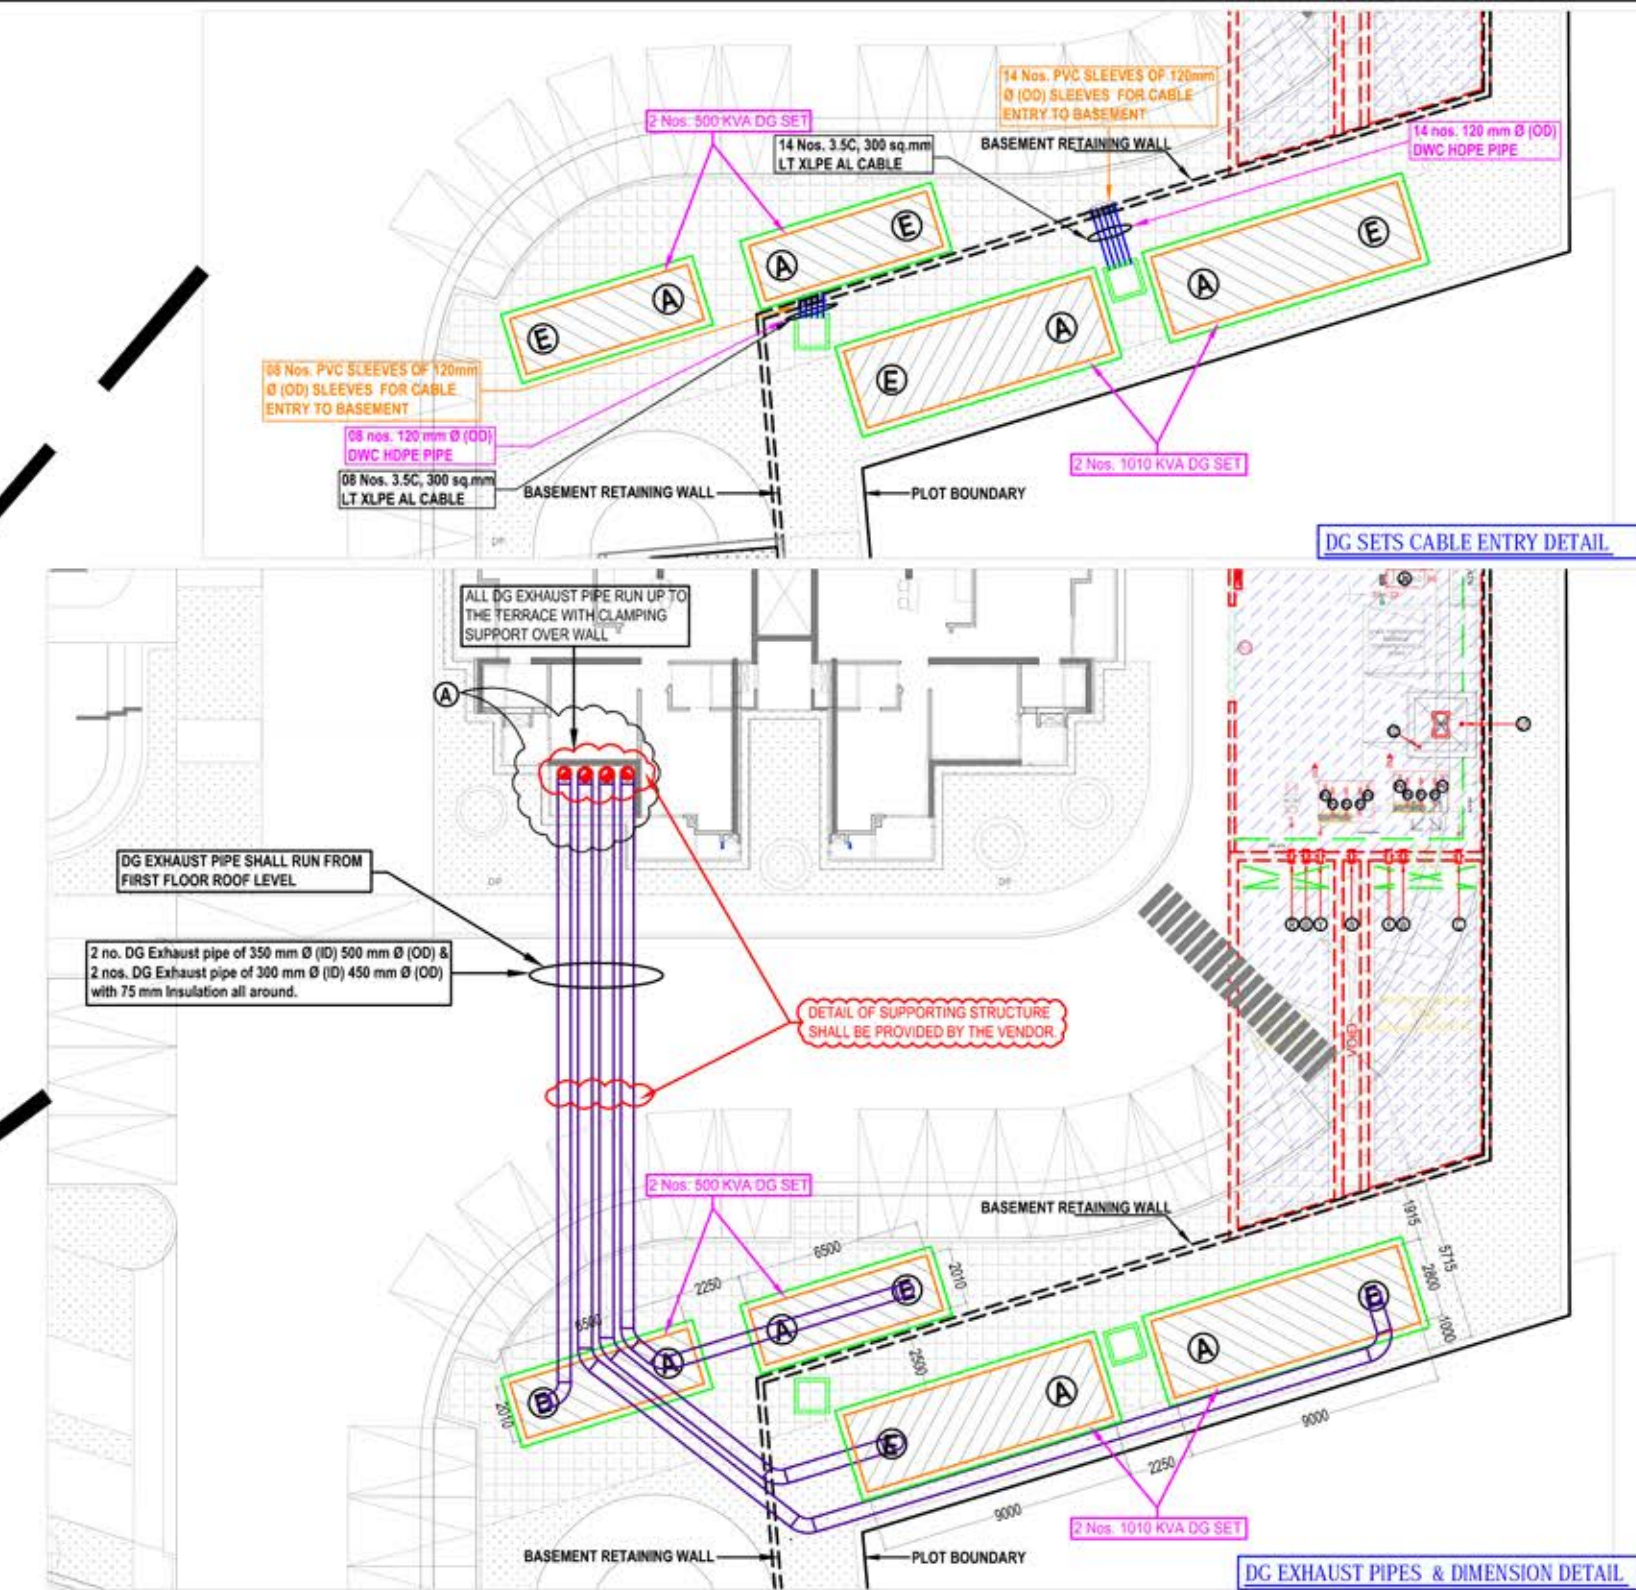


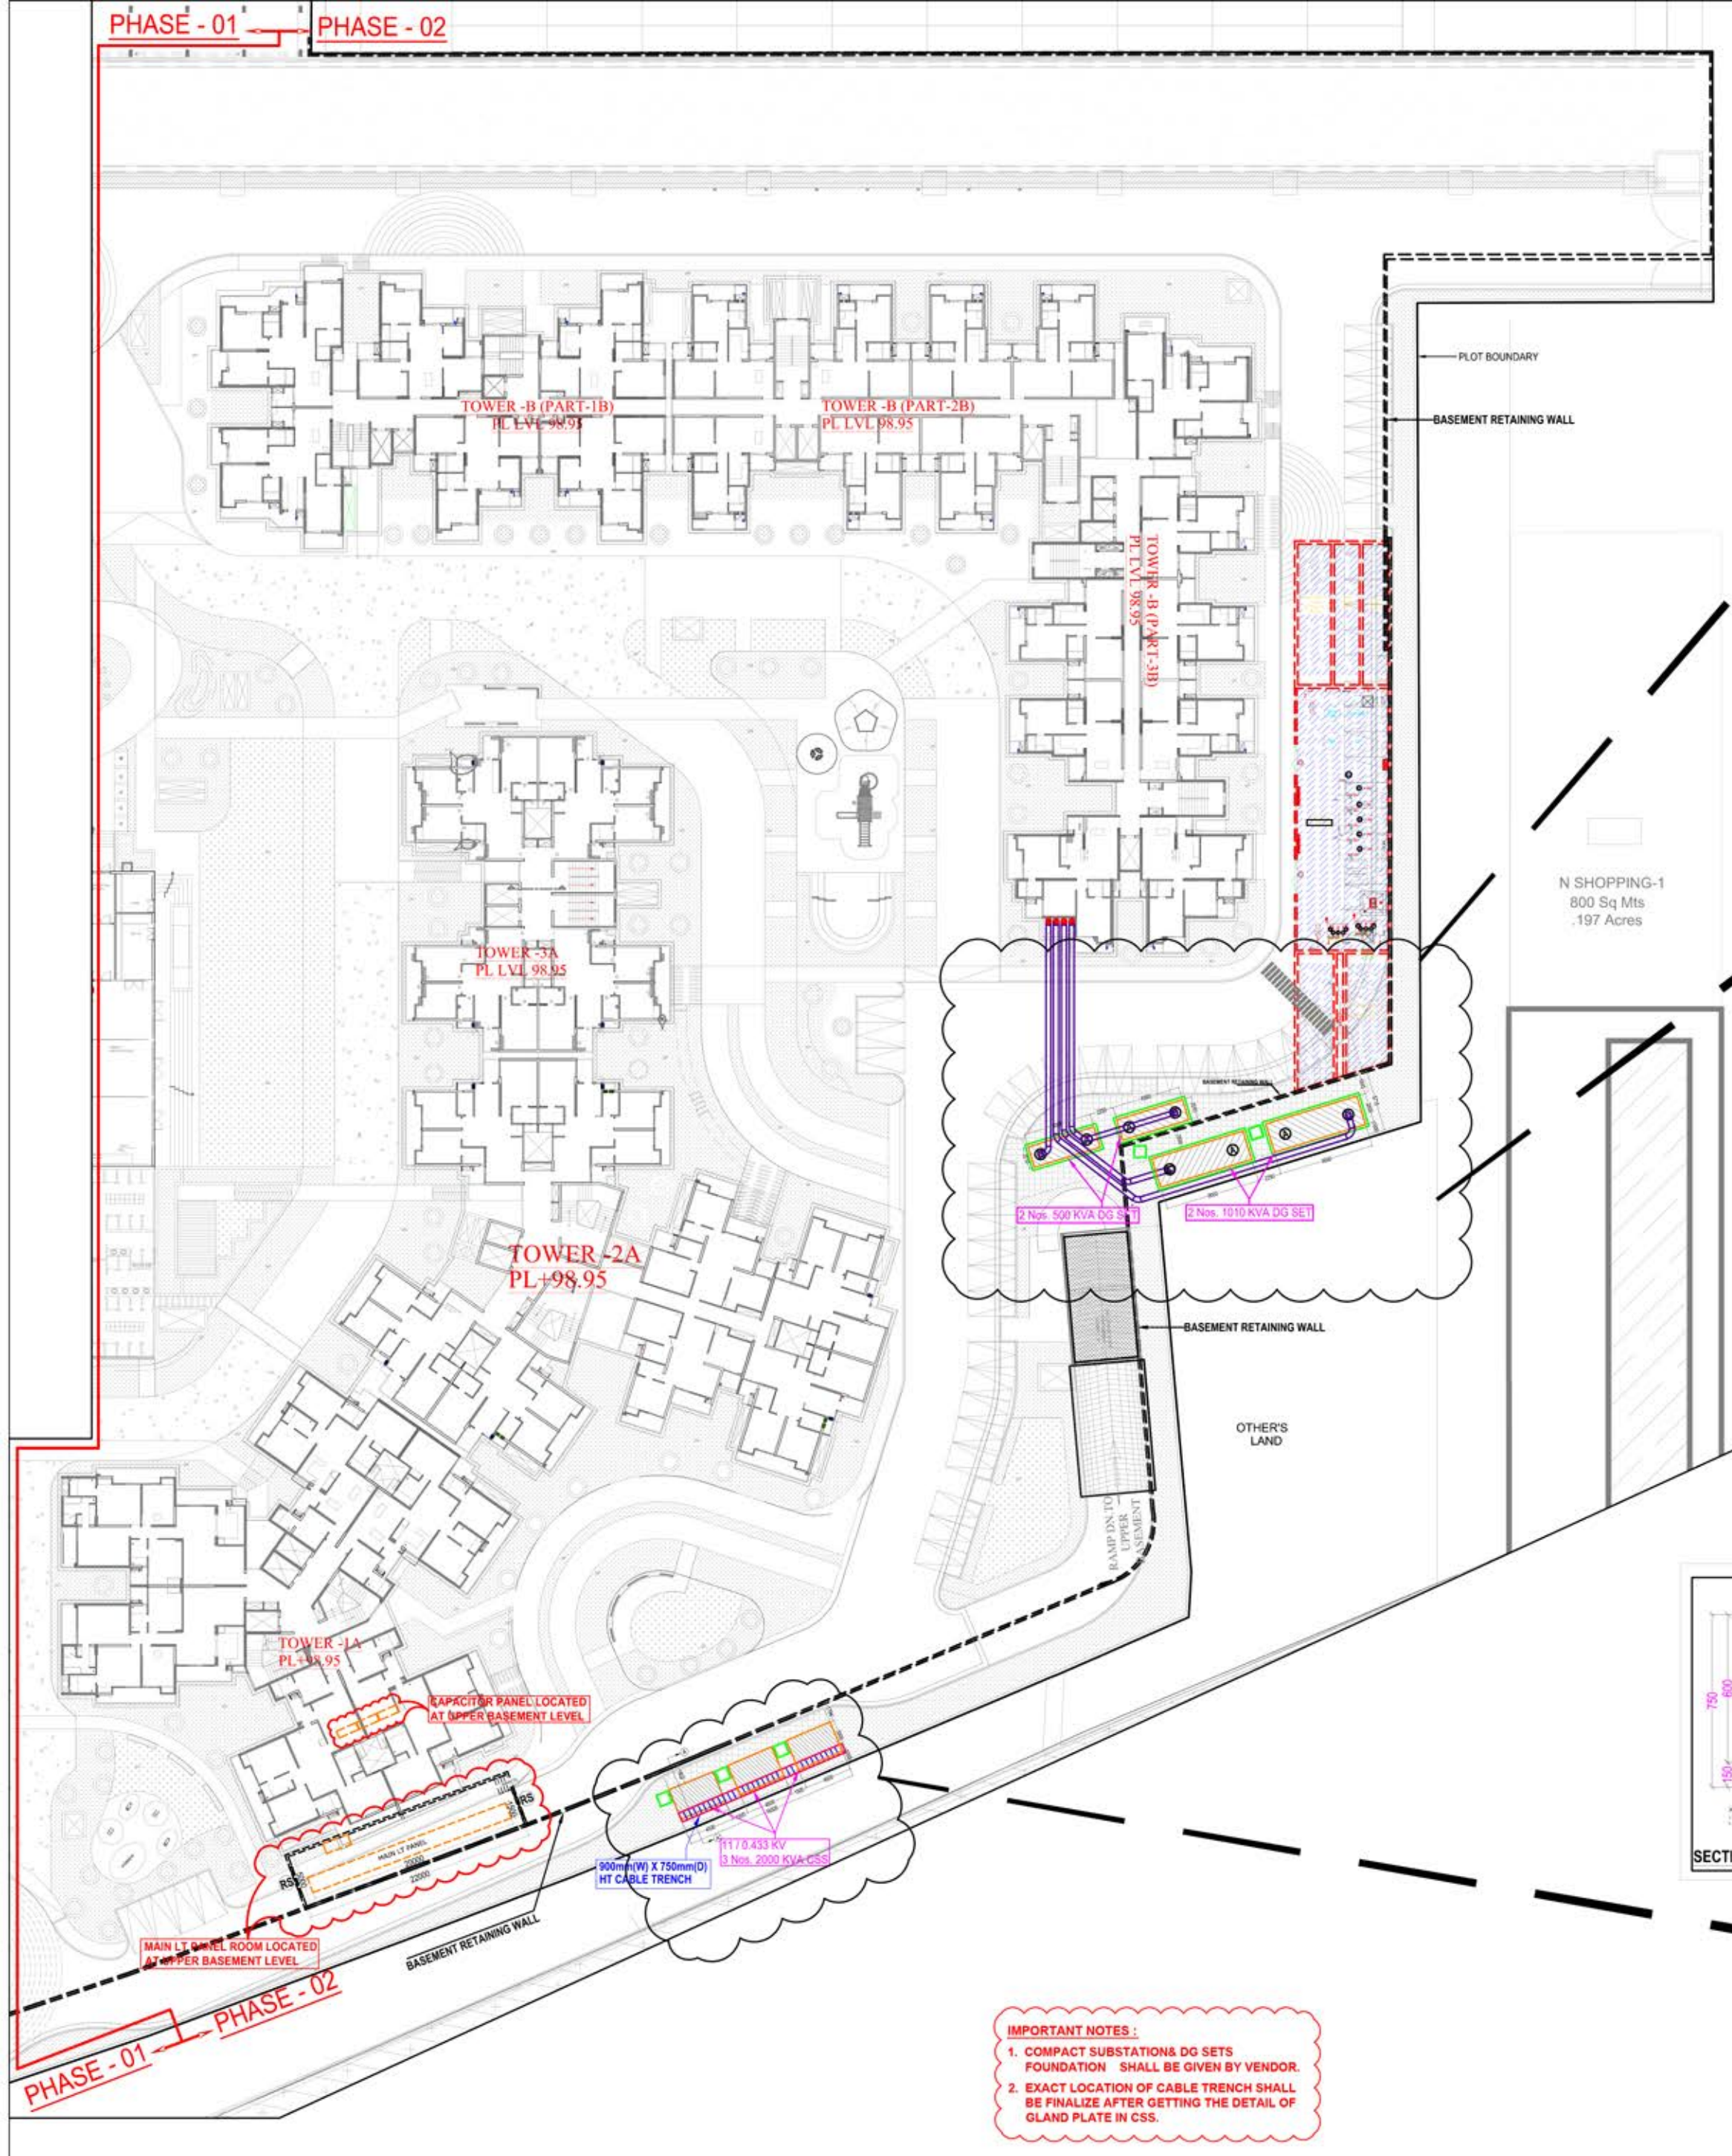

R0	15.09.2015	GFC ISSUED.
rev. no.	date	revision
project "LANDCRAFT GOLF LINKS" VILLAGE MEHRAULI, DISST. GHAZIABAD,U.P		
title ELECTRICAL DRAWING (PHASE-02)		
subtitle ELECTRICAL SETTING-OUT LAYOUT (AT SITE PLAN)		
drawing released for ☐ APPROVAL ☐ SUBMISSION ☐ ADVANCE COPY ☒ CONSTRUCTION		
drg. no. GI/ ELEC / EXT. -01	drawn by Surjeet	
scale 1 : 375 @ A1	designed by Ateeq Ur Rehman	
date Sep. 2015	checked by Anand Havella	
architects  Space Designers architects & engineers Space Designers International Architects Pvt. Ltd. B-34, Sector-67, Noida -201301 (U.P.) PH : 0120-2484445, 4446 Mob: 9811336231 e-mail : spacesdi@gmail.com, www.spacedi.com		
services consultant Consummate Engineering Services (P) Ltd. Noida Office : B -67, Sector-67, Noida - 201 301 Tel. : (0120) 2935500 (30 Lines) Lko Office : B-006, Rohitas Phamaria, Condit Nagar, Lucknow Tel. : (0522) 6515455 e mail : mail@cespl.in, website : www.cespl.in		