


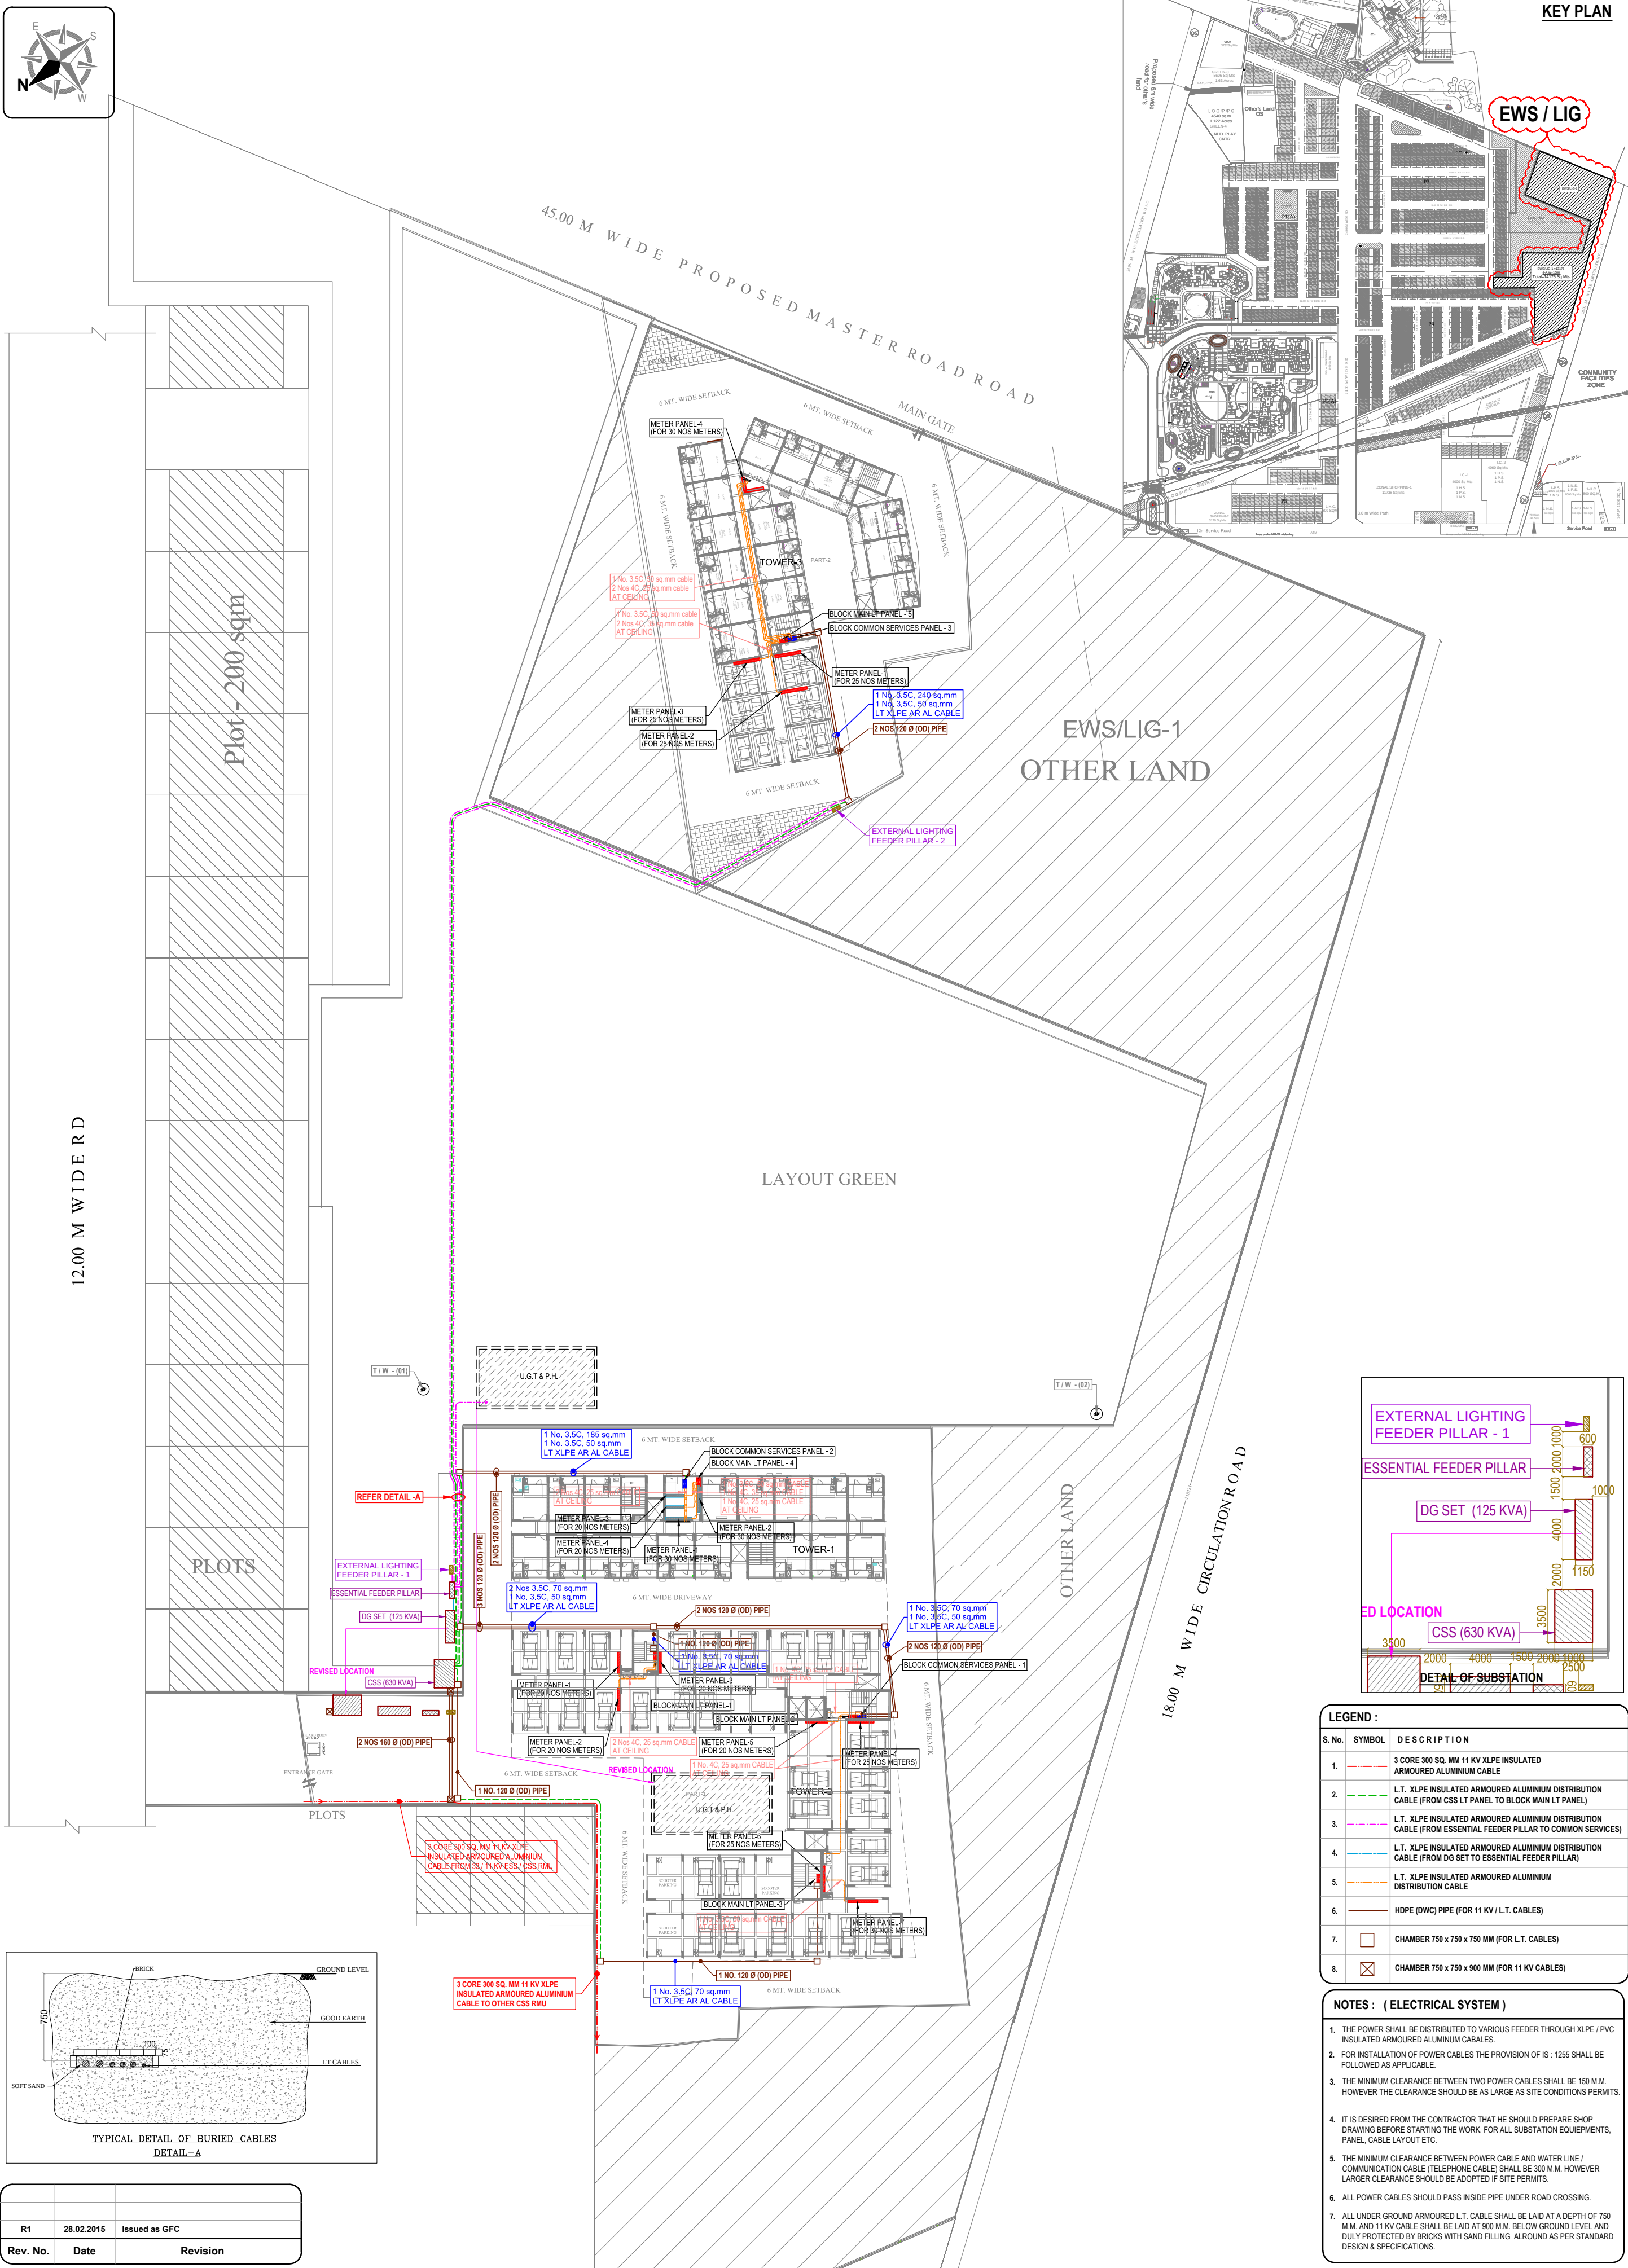

Title :
SITE PLAN

Subtitle :
EXTERNAL ELECTRICAL SYSTEM

Drg. No :
GL-LC-EWS-LIG-EE-01

Drawn By :
Mandeep

Date :
Feb. 2015

Architects :
SHILP KRITI ARCHITECTS
AR.SHILPA AGRAWAL CA97217284 (I.LT.ROORKEE)
GC-34,THIRD FLOOR , ADITYA GOLD CREST MALL
VAIBHAV KHAND, INDIRAPURAM, GHAZIABAD. PH: 9818443042

Services Consultant :
Consummate Engineering Services (P) Ltd.

cespi
Creating & Inspiring People To Grow & Succeed

Noida Office : B - 67, Sector - 67, Noida - 201 301
Tel : (0120) 2593500 (30 Lines)
Lko. Office : R 006, Rohtas Plumeria, Gomti Nagar, Lucknow
Tel : (0522) 6515455
e mail : mail@cespi.in, website : www.cespi.in