

[illegible]


01		02	03	04 = 02 + 03		05	06		07 = 04 + 05
PARTICULARS		PART - A	PART - B	TOTAL (PART A + PART B)	PERCENTAGE PART - A	PERCENT - B	TOTAL PERCENT	GRAND TOTAL	
01	GROUND COVER AREA	14.5042	11.5144	27.0186	NIL	NIL	NIL	27.0186	
02	TOTAL P.A. AREA								
03	A. RESIDENTIAL P.A. AREA	24.5513	24.5513						
04	COMMERCIAL P.A. AREA	286.871	286.871						
05	C. PARKING P.A. AREA	100.00		426.7034	12.5831	574.1133	24.0044	626.6044	
06	D. OTHERS P.A. AREA	14.602	77.93						
07	TOTAL P.A. AREA	24.6493	30.3381						
08	04 + 05	69.4242	10.5831	80.0073	NIL	NIL	NIL	80.0073	
09	06 + 07	14.1414	10.7616	24.9030	89.52	114.03	10.5242	17.4267	
10	TOTAL P.A. AREA	20.1747	17.9016	38.0763	NIL	NIL	NIL	38.0763	
11	08 + 09	83.5656	12.3446	95.9102	NIL	NIL	NIL	124.9195	
12	TOTAL P.A. AREA	66.6667	66.6667	133.3334	NIL	NIL	NIL	133.3334	
13	TOTAL P.A. AREA	200.0000	180.0000	380.0000	NIL	NIL	NIL	380.0000	
14	TOTAL P.A. AREA	NIL	NIL	NIL	NIL	NIL	NIL	3.275515	3.275515

[illegible]


KEY PLAN OF SECTOR - 118 (PLOT NO. - GH-01)



150# DOMESTIC WATER RINGMAN	00 00 00 00 00
150# FLUSHING WATER RINGMAN	00 00 00 00 00
90 OD IRRIGATION RINGMAN	00 00 00 00 00
GARDEN HYDRANT	00 00 00 00 00

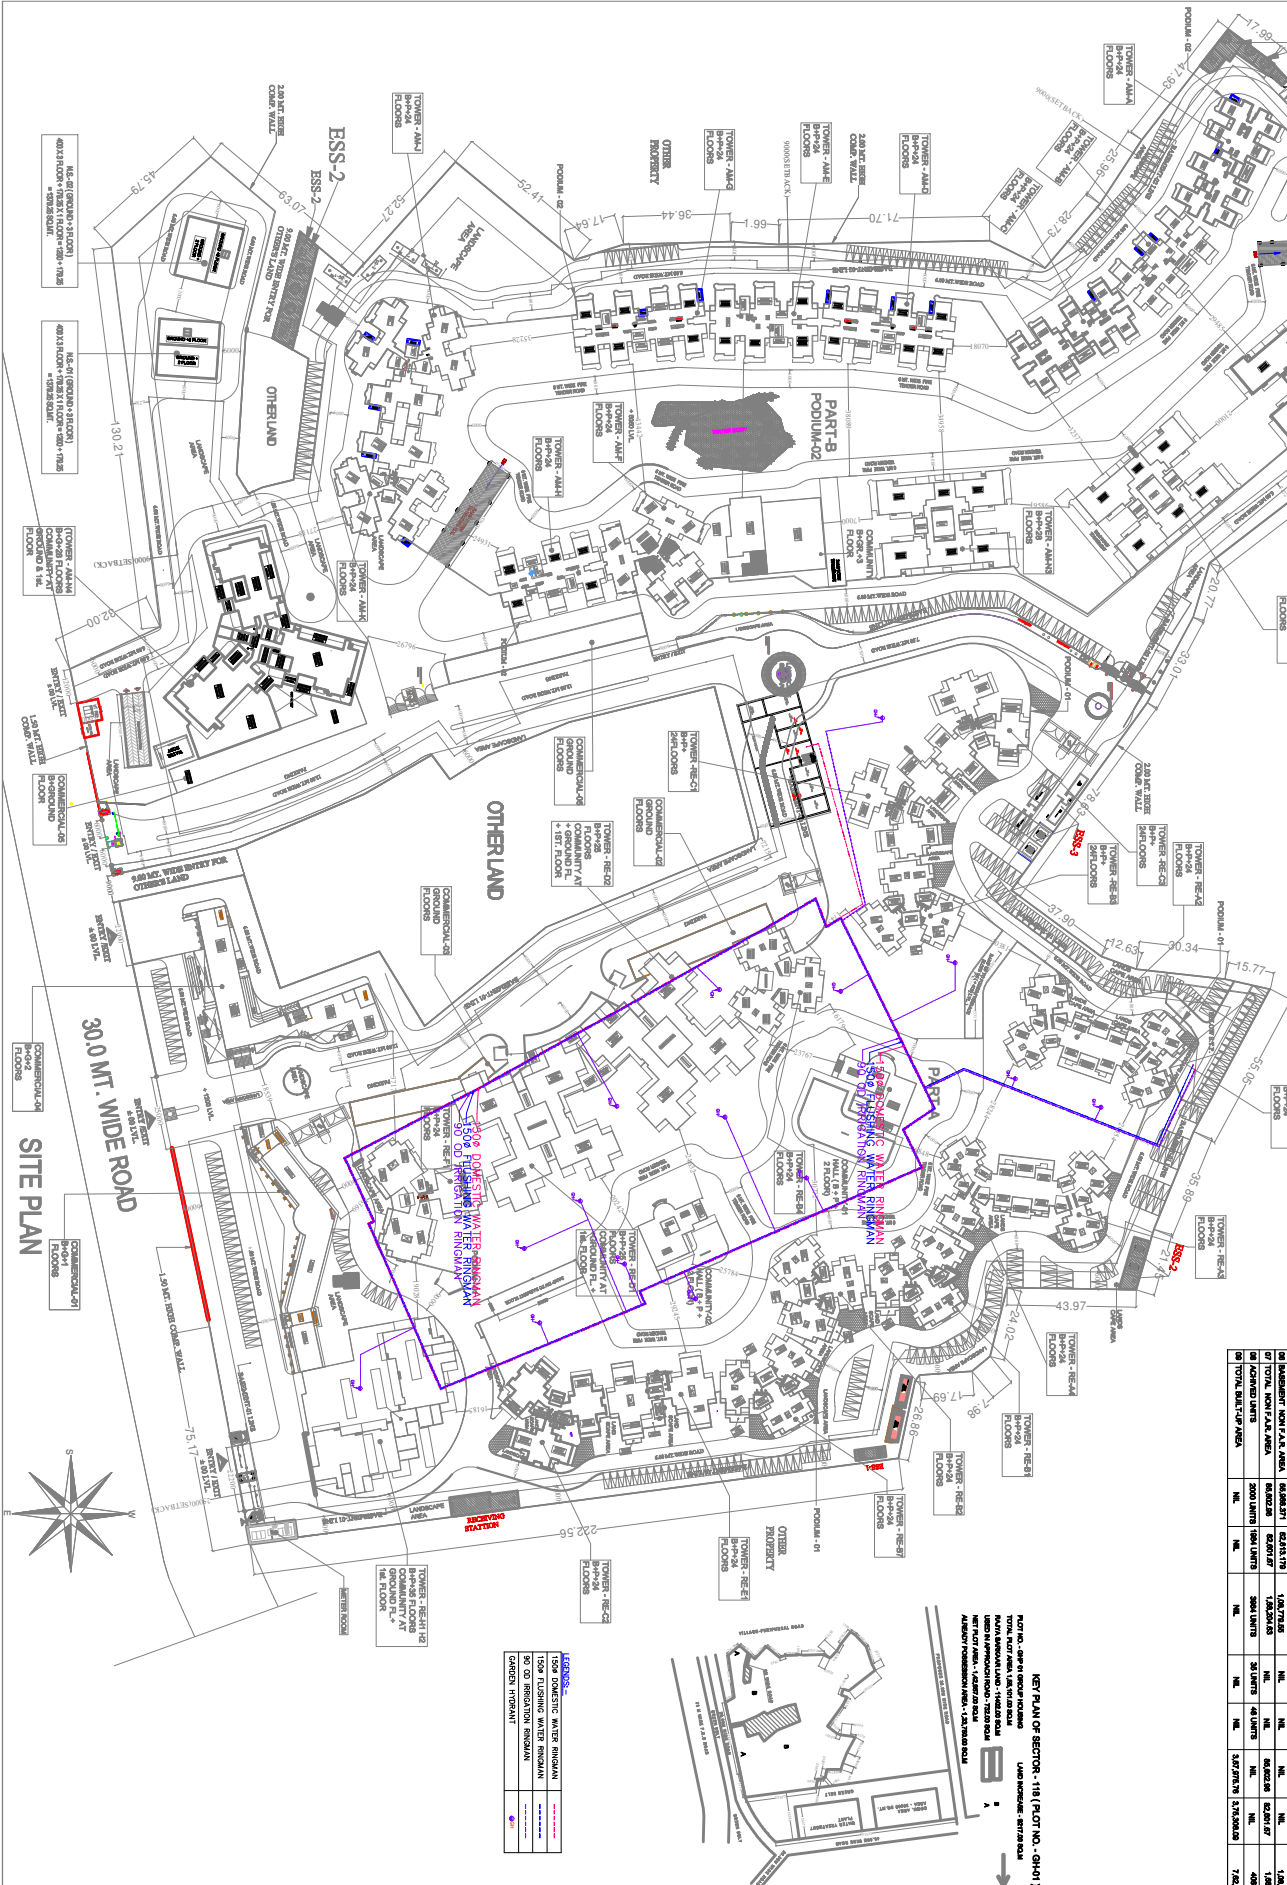

SITE PLAN

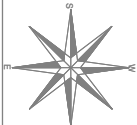

PROJECT :-		PROPOSED GROUP HOUSING AT SECTOR 118, NOIDA	
BUILDERS & PROMOTER :-		M/s M/R PRIME DEVELOPERS (PVT.) LTD.	
ADDRESS :-		1114, HERICANT CHAMBERS, 89, NERUL PLACE, NEW DELHI-110019	
DRAWING TITLE :-		WATER SUPPLY SITE PLAN	
 ARCHITECTS: Space Designers International 101, 102, 103, 104, 105, 106, 107, 108, 109, 110, 111, 112, 113, 114, 115, 116, 117, 118, 119, 120 Plot - 10, Sector - 10, Noida - 201301 Mobile: 9911070009, 9911070010 Email: space@sdinoida.com, www.sdinoida.com			
CONSULTANTS:		 PLANNING & FIRE FIGHTING CONSULTANTS :- 815-5, EAST OF LANE ROAD, SEWALDA, Noida-201309 Mobile: 9911070009 EMAIL: planning.firefighting@spaceindia.com	
DRAWN BY :- CHECKED BY :- SCALE		DATE :-	
DESIKH		DINESH	
1 : 800		30-05-19	
OWNER'S SIGN		ARCHITECT'S SIGN.	
DRG. NO. - 02			