


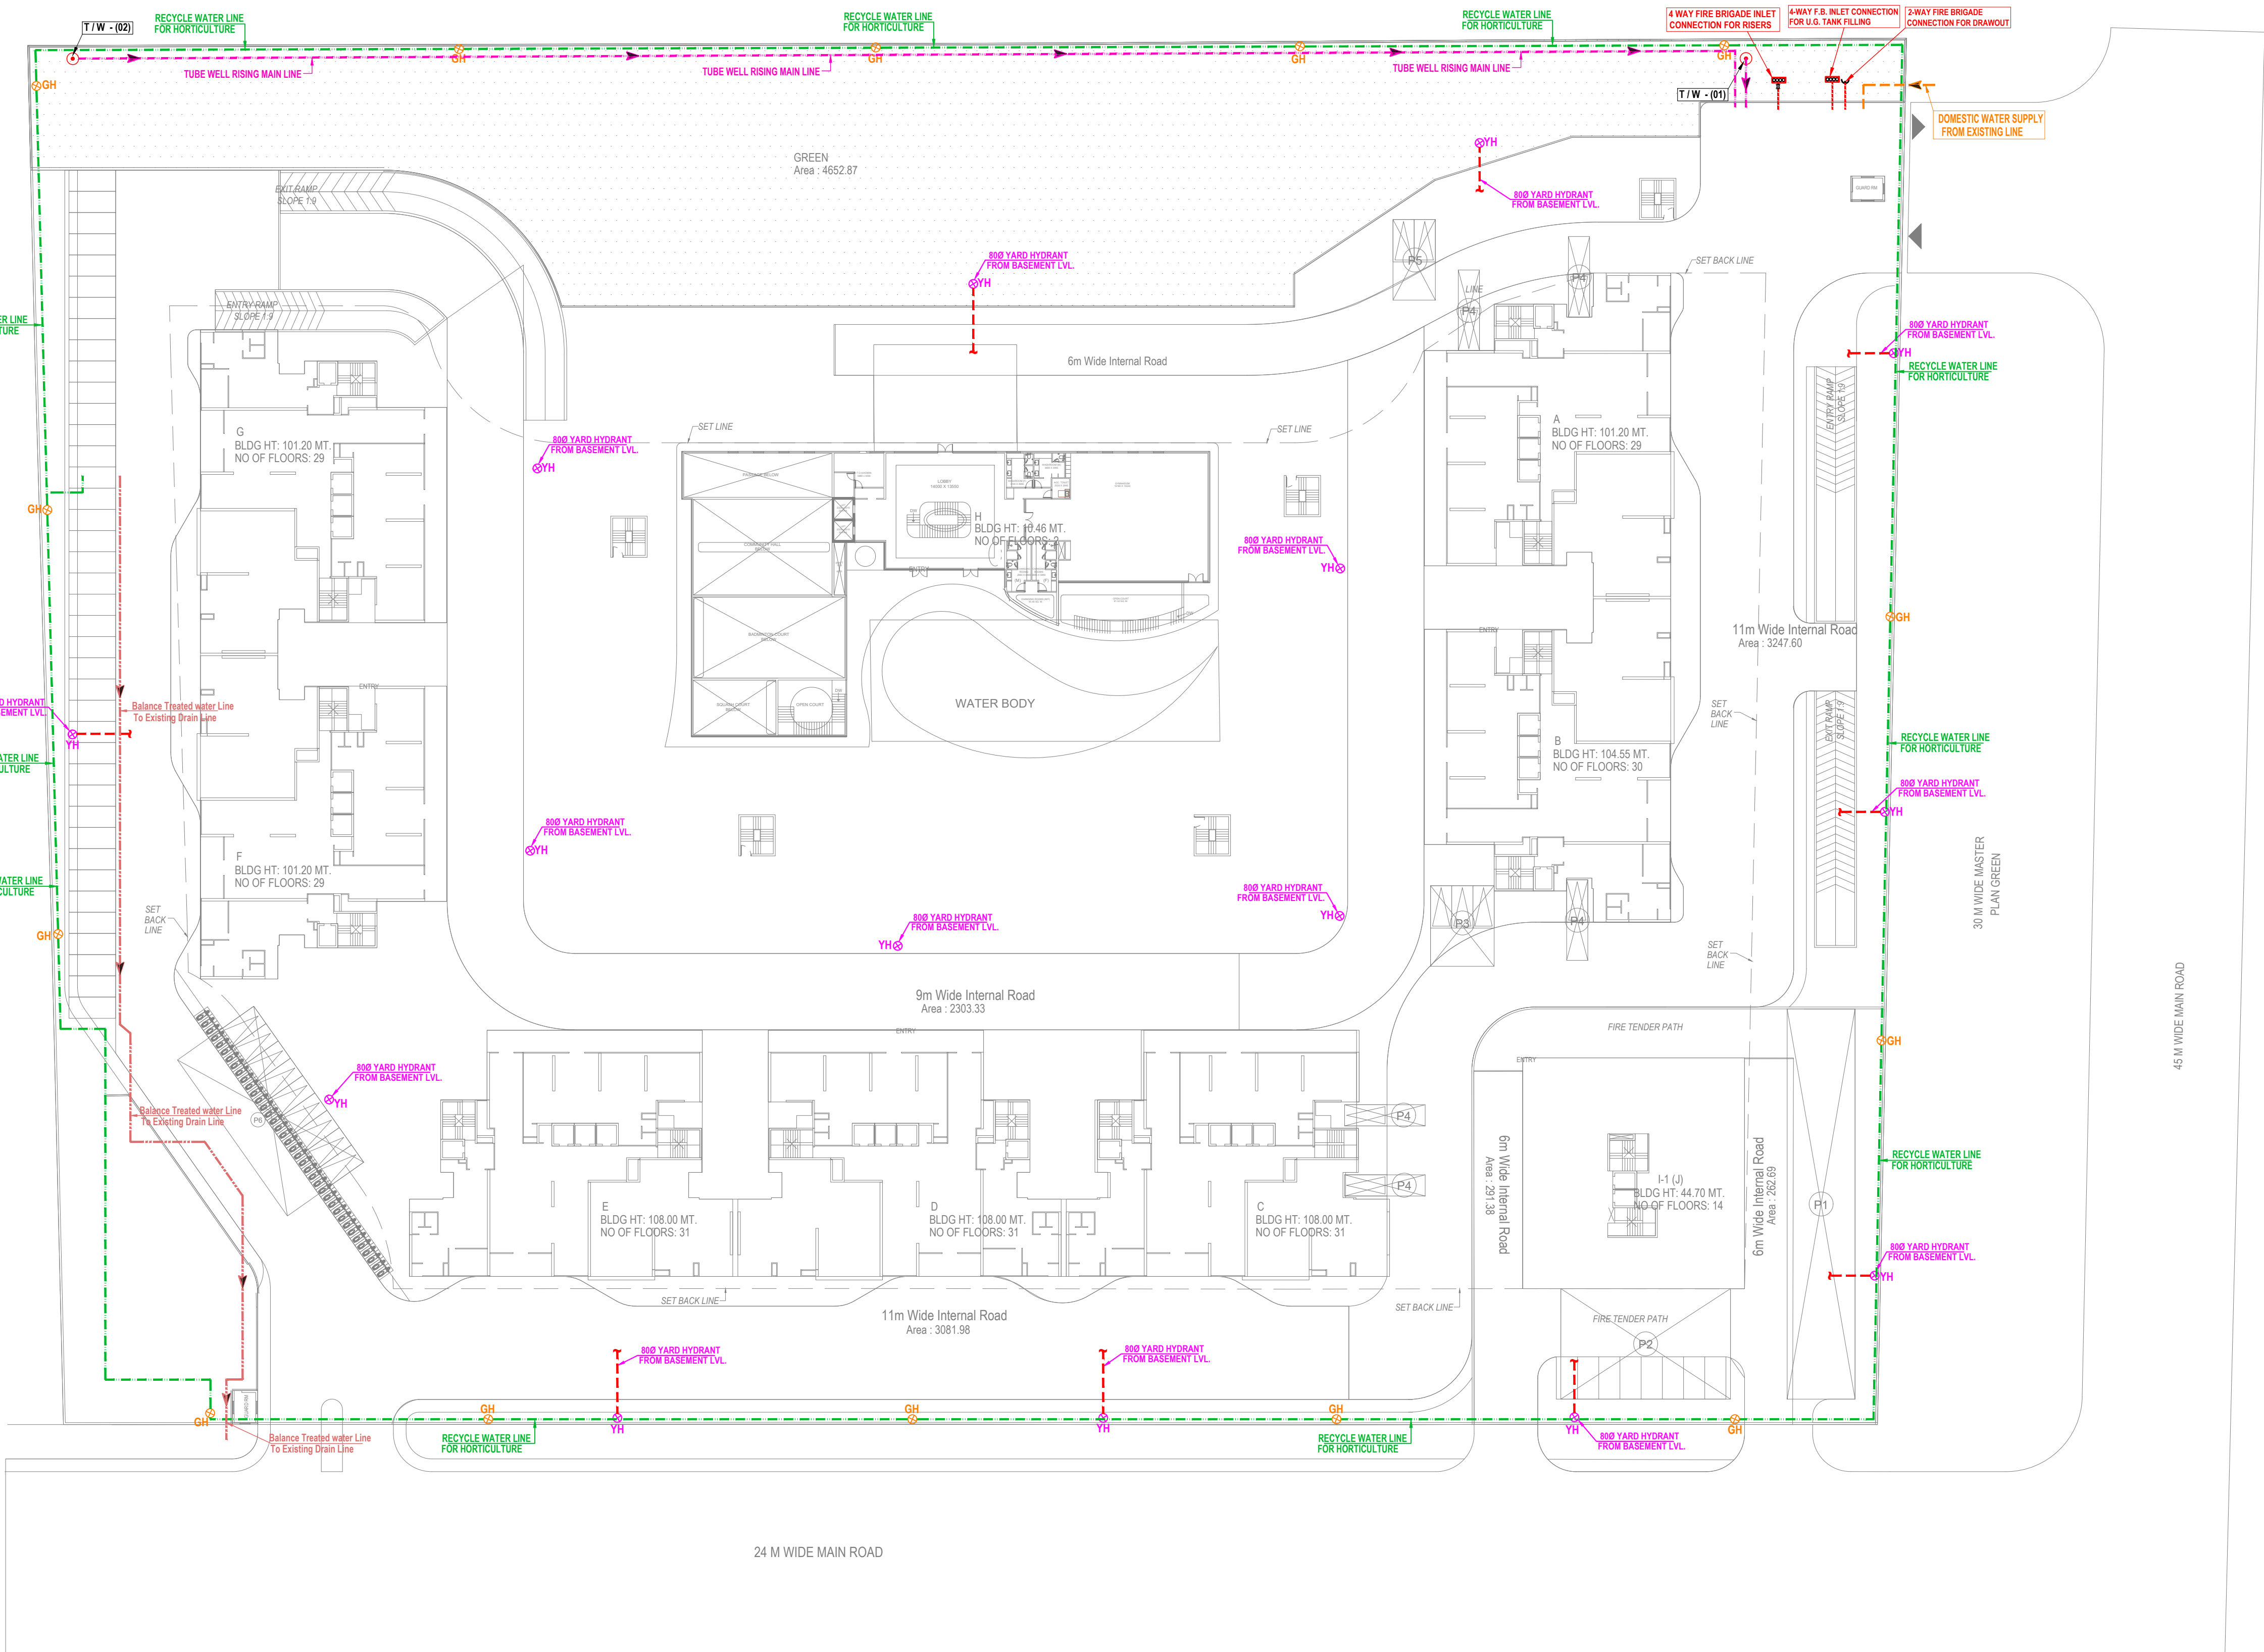

LEGEND :		
S.No.	SYMBOL	DESCRIPTION
1.		RECYCLED WATER SUPPLY PIPE LINE.
2.		RISING MAIN WATER PIPE LINE.
3.		DOMESTIC WATER SUPPLY PIPE LINE.
4.		PROPOSED TUBE WELL.
5.		GARDEN HYDRANT
6.		YARD HYDRANT

Rev. no.	Date	Revision
Project THE SUNFLOWER GROUP HOUSING AT PLOT NO.-: GH-7 ADITYA WORLD CITY, NH24, GHAZIABAD, (UP).		
Title SITE PLAN.		
Subtitle EXTERNAL WATER SUPPLY SERVICES		
Drawing released for ☐ APPROVAL ☒ SUBMISSION ☐ ADVANCE COPY ☐ CONSTRUCTION		
Drg. no.	S.F / EX / S-03	Drawn by Kulwant
Scale	1 : 450	Designed by R.K.
Date	Feb. 2024	Checked by Anand Havella
Architects N + U DESIGN STUDIO Architecture • Project Management Urban Planning • Product Design B-204, OKHA PHASE-I, NEW DELHI - 110059, INDIA Telephone : +91-11-46818113 E-Mail : info@nplusu.in Website : www.nplusu.in		
Services Consultant Consummate Engineering Services (P) Ltd. Noida Office : B - 67, Sector - 67, Noida - 201 301 Tel : (0120)6943500 (23 Lines) Lko. Office : R 006, Rohtas Plumeria, Gomti Nagar, Lucknow e mail : mail@cespl.in, website : www.cespl.in		