




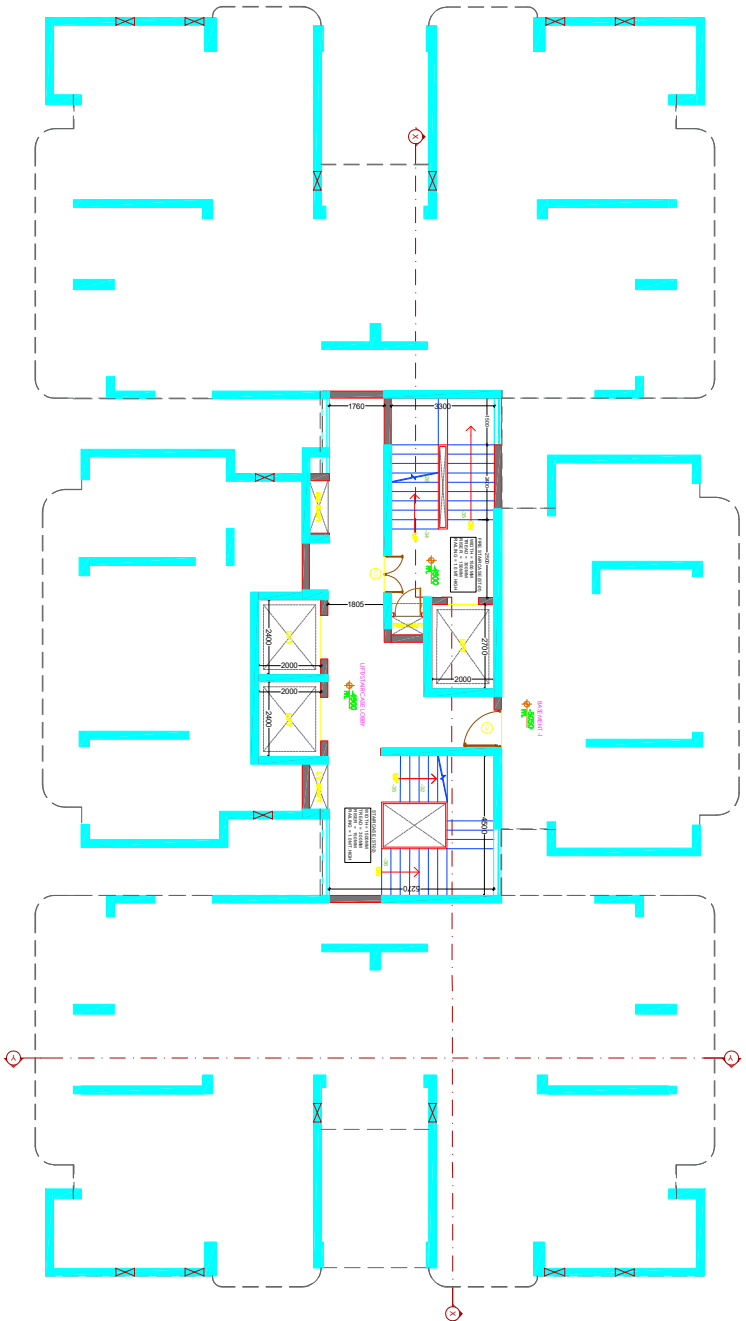


BASEMENT LEVEL -1 FLOOR PLAN
TOWER-A

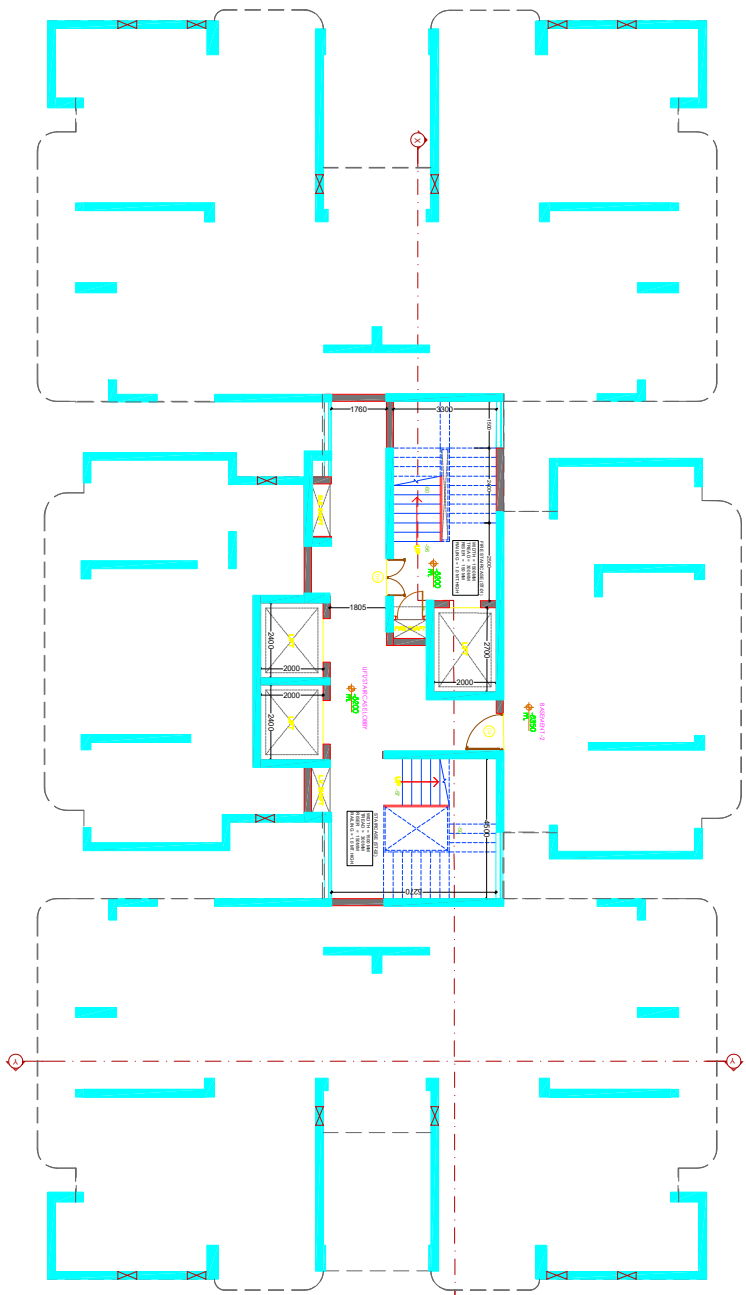

BASEMENT LEVEL -2 FLOOR PLAN
TOWER-A

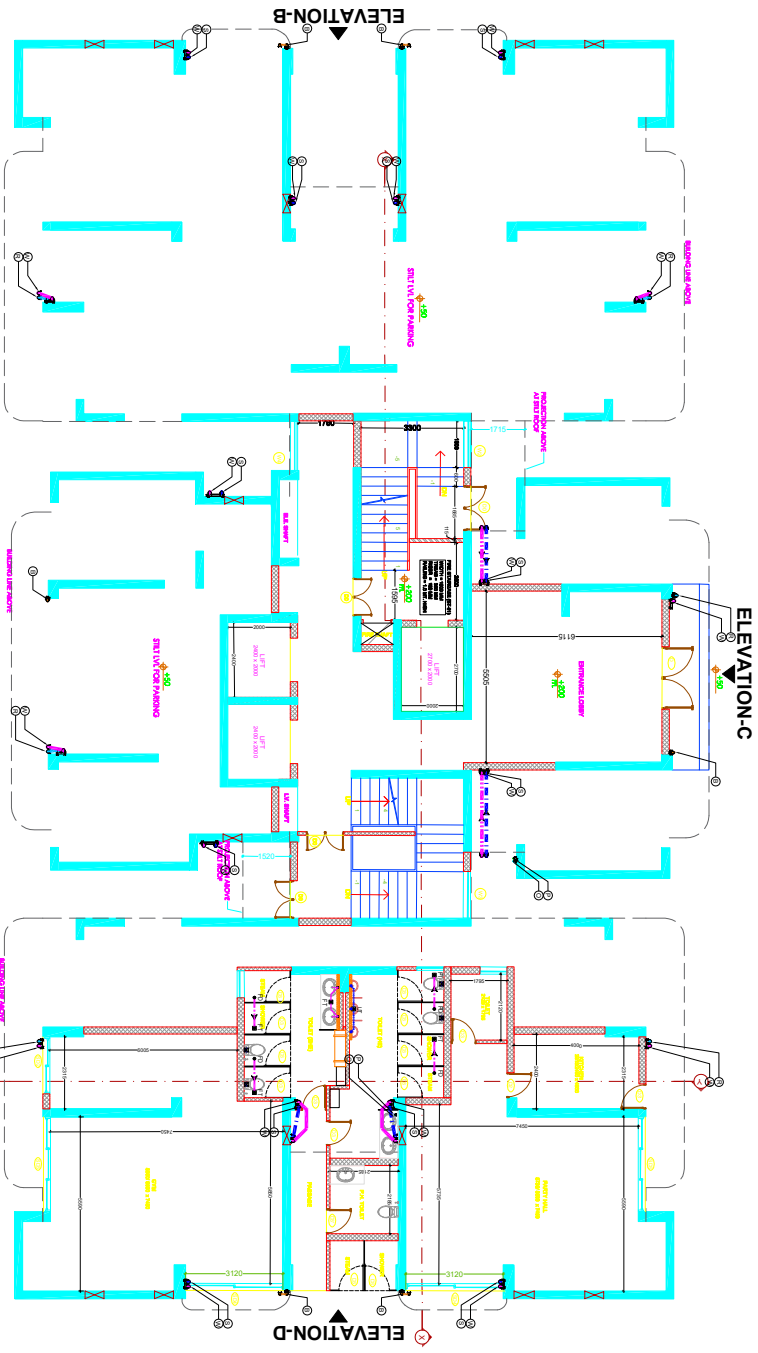

STILT LEVEL FLOOR PLAN
TOWER-A

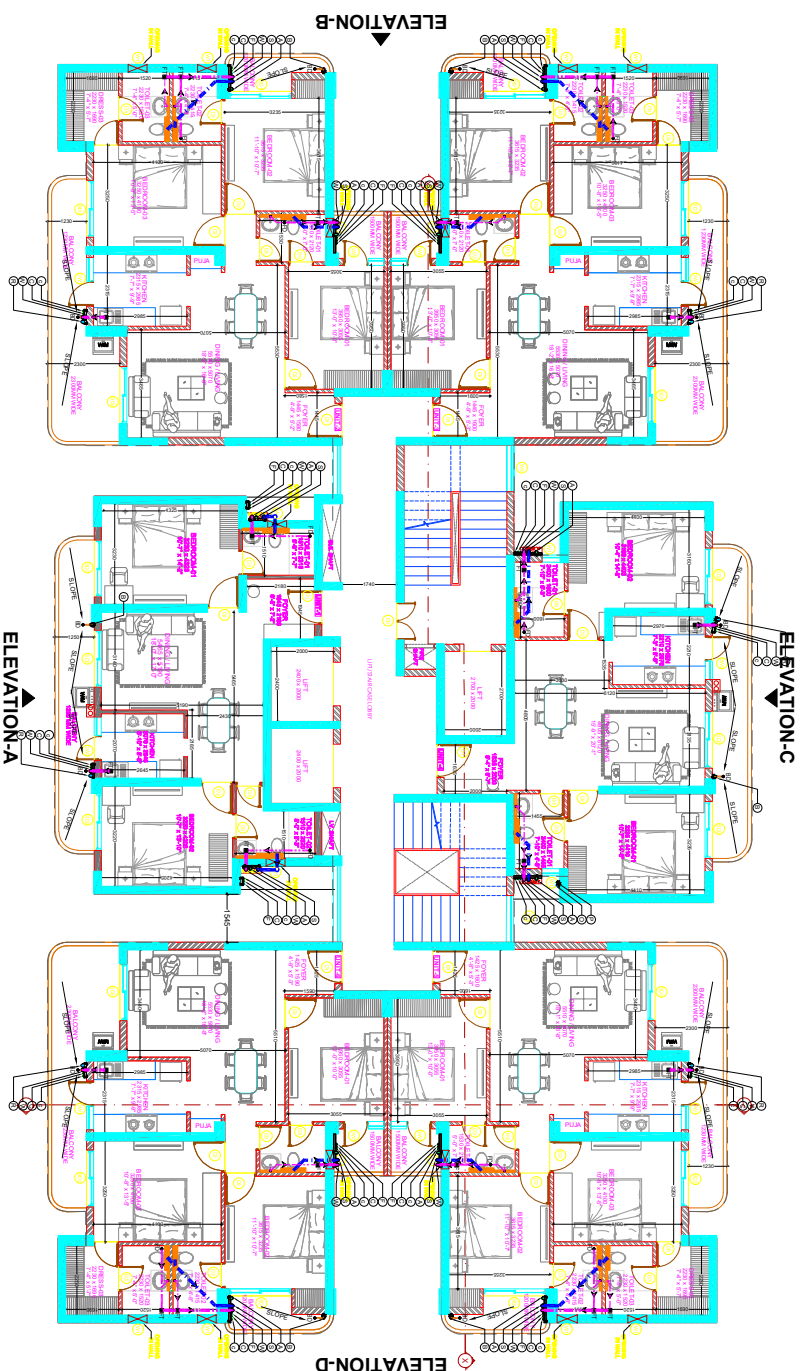

TYPICAL FLOOR PLAN (1ST TO 17TH, 19TH TO 26TH)
TOWER-A

PLUMBING LEGEND:-	
S. No.	SYMBOL
1.	110 mm OD UPVC SOIL AND VENT PIPE
2.	110mm OD UPVC WASTE AND VENT PIPE
3.	110mm OD UPVC KITCHEN WASTE AND VENT PIPE
4.	DOMESTIC WATER SUPPLY PIPE (UPPER 3 FLOOR)
5.	DOMESTIC WATER SUPPLY PIPE
6.	FLUSHING WATER SUPPLY PIPE
7.	650 DOMESTIC WATER RISER SUPPLY
8.	500 FLUSHING WATER RISER SUPPLY
9.	63mm OD UPVC VENT PIPE
10.	110mm OD UPVC RAINWATER PIPE
11.	63mm OD UPVC BALCONY DRAIN PIPE
12.	FLOOR DRAIN WITH GRATINGS
13.	F.T./U.T
14.	DWS
15.	RWS
16.	HWS
17.	FCO
18.	COP

DRAINAGE PIPE CONNECTION DETAIL:-

- FROM WC TO STACK W/ 1100 PIPE
- FROM SINK TO STACK W/ 1100 PIPE
- FROM SINK TO SINK W/ 1100 PIPE
- FROM SINK TO FT W/ 1100 PIPE
- FROM SINK TO FT W/ 1100 PIPE
- FLOOR DRAIN 110 X 63 / 110 X 50.....FD
- FLOOR CLEANOUT 110 X 110.....COP

PLUMBING SUBMISSION

PROJECT:
PROPOSED GROUP HOUSING

CLIENT:
ON KASBA NO. 44TH, 7TH & 12TH FLOOR
VALLEY SUBDIVISION, TOWER, SECTOR 10/11, KASBA

STRUCTURAL CONSULTANT:

M.E.P CONSULTANT:

ARCHITECT:
K DESIGN
405, ANAND APARTMENT
NEW MANGLAPUR, NEW DELHI - 110005
Email : architectkdesign@gmail.com, kdesign@gmail.com

SCALE: N.T.S (A1)



DRAWING BLOCK:
TOWER - A

DIRECTION:


SHEET TITLE:
FLOOR PLANS

SHEET NO.
SUB_A01

THIS DRAWING IS COPYRIGHT. IT IS THE PROPERTY OF THE CONSULTANT AND IS NOT TO BE REPRODUCED, COPIED, HANDED OVER TO A THIRD PARTY OR USED FOR ANY PURPOSE OTHER THAN FOR WHICH IT HAS BEEN LOANED.

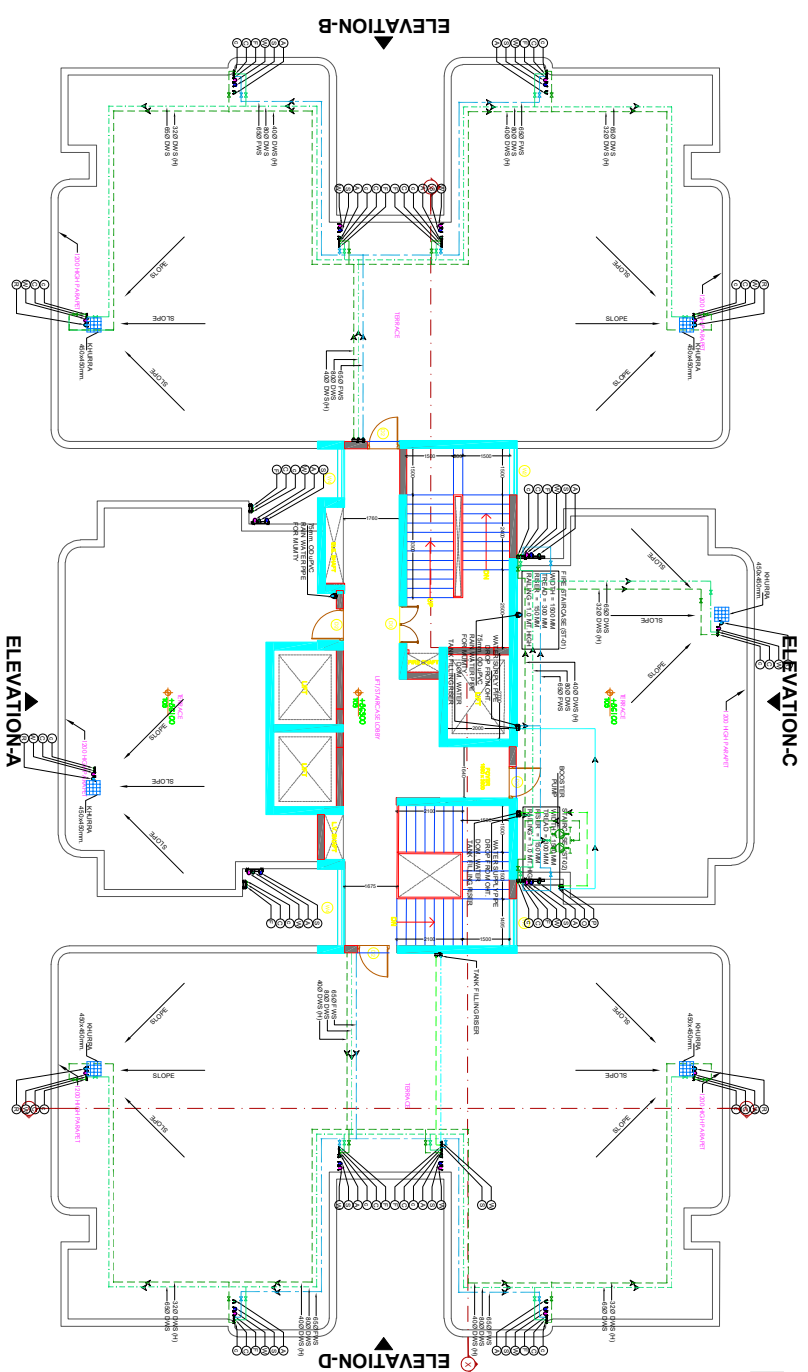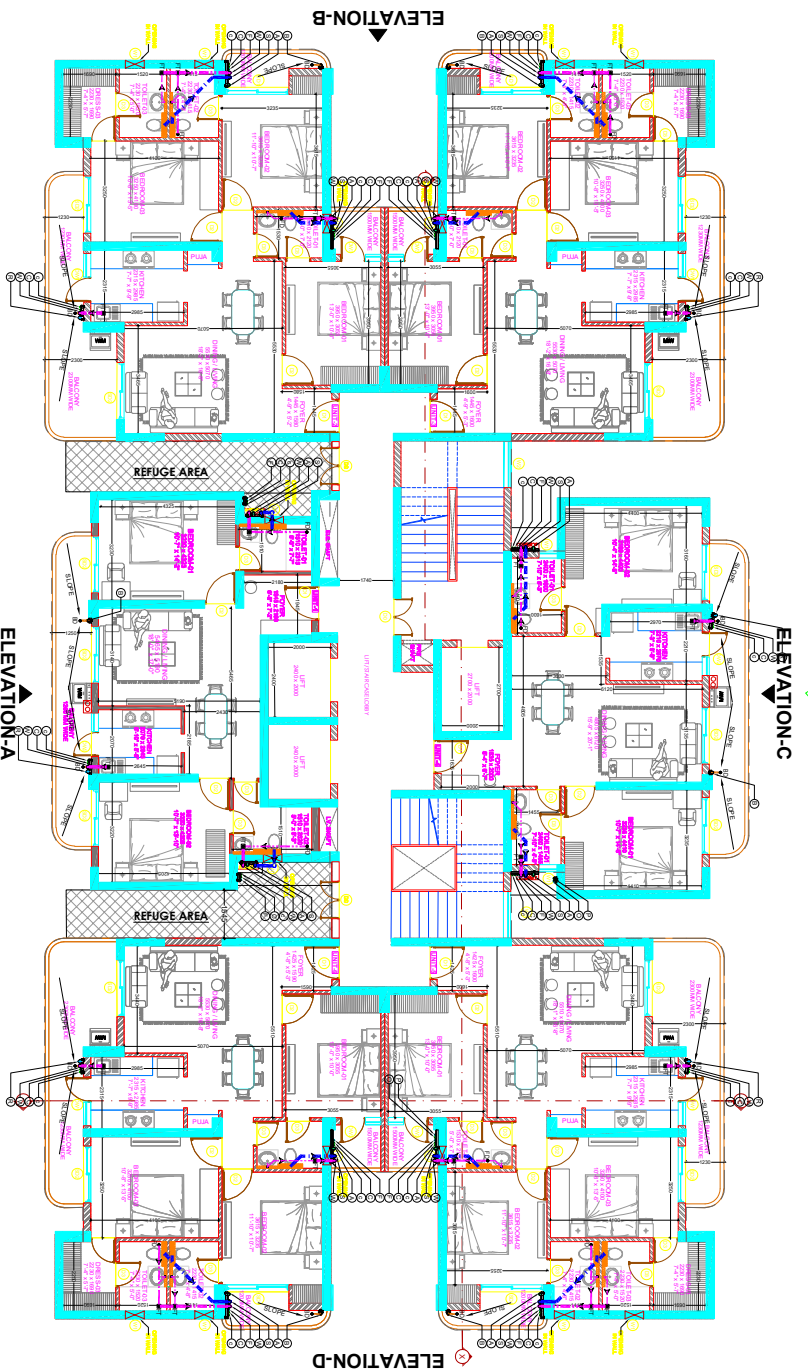

DATE: 29-07-2024

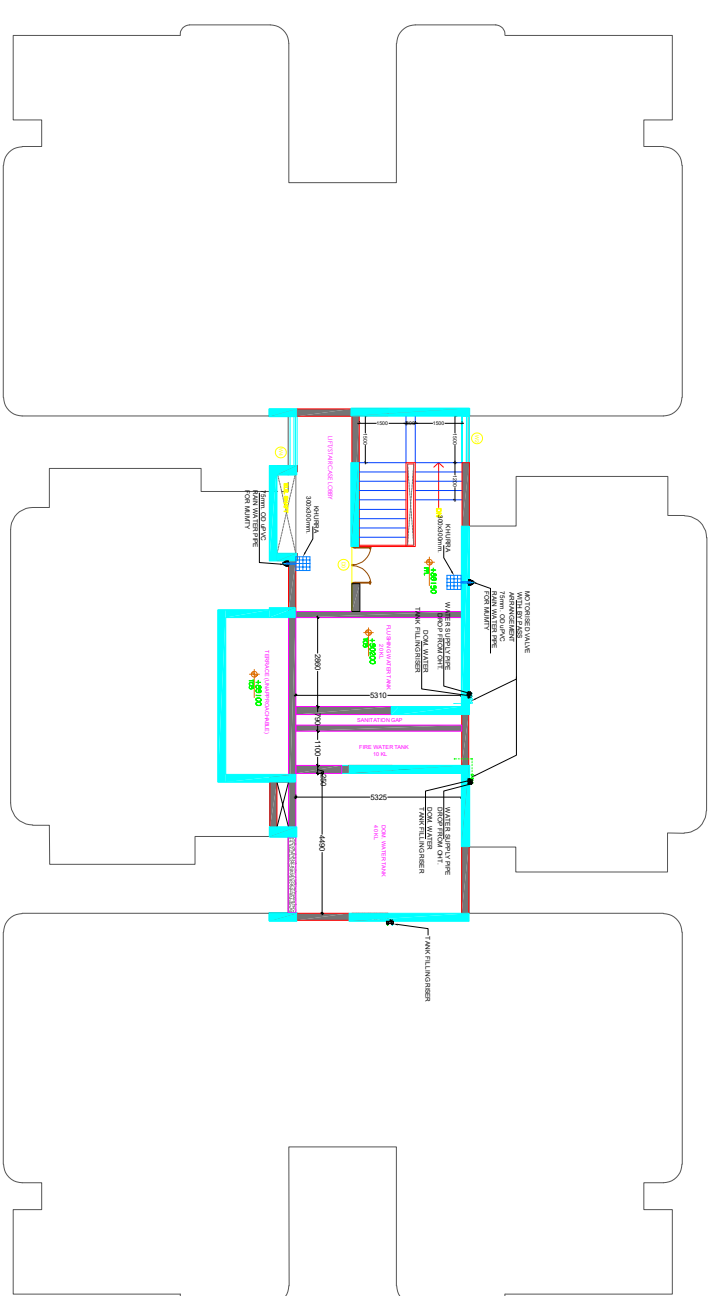18TH FLOOR PLAN
TOWER-BOHT LEVEL FLOOR PLAN
TOWER-B

PLUMBING LEGEND:-		
S. No.	SYMBOL	DESCRIPTION
1.		110 mm OD D/PVC SOIL AND VENT PIPE
2.		110mm OD D/PVC WASTE AND VENT PIPE
3.		110mm OD D/PVC KITCHEN WASTE AND VENT PIPE
4.		DOMESTIC WATER SUPPLY PIPE (UPPER 3 FLOOR)
5.		DOMESTIC WATER SUPPLY PIPE
6.		FLUSHING WATER SUPPLY PIPE
7.		600 DOMESTIC WATER RISER SUPPLY
8.		500 FLUSHING WATER RISER SUPPLY
9.		83mm OD D/PVC RENT PIPE
10.		110mm OD D/PVC RAIN WATER PIPE
11.		83mm OD D/PVC BALCONY DRAIN PIPE
12.		FLOOR DRAIN WITH GRATING
13.		F.T. & I.T.
14.		FLOOR TRAP / URINAL, TRAP WITH GRATING
15.		DOMESTIC WATER SUPPLY PIPE
16.		FLUSHING WATER SUPPLY PIPE
17.		HOT WATER SUPPLY PIPE
18.		FLUOR CLEANOUT
19.		CLEANOUT PLUG
20.		COP

DRAINAGE PIPE CONNECTION DETAIL:-

- FROM FT TO STACK \ GT 110D PIPE
FROM WB TO FD \ FT 32D PIPE
FROM SINK TO FT 32D PIPE
FLOOR TRAP 110D X 110D FT
FLOOR DRAIN 110 X 63 \ 110 X 50 FD
FLOOR CLEANOUT 110 X 110 COP

TERRACE FLOOR PLAN
TOWER-B

PROJECT:	
PROPOSED GROUP HOUSING	
ON KALANJA NO. 44TH, 1200TH, 30TH & 102 STREET, VILLAGE SHIMSHAN, THERU, SAKOLLA WARD, LUDHIANA	
CLIENT:	
STRUCTURAL CONSULTANT:	
M.E.P CONSULTANT:	
ARCHITECT:	
K DESIGN	
402, AMALCA APARTMENT NEW MANGLAPATRI, NEW DELHI - 110020 E mail : architectkdesign@gmail.com, kdesign@gmail.com	
SCALE: N.T.S (A1)	DIRECTION:
DRAWING BLOCK:	
TOWER -B	
SHEET TITLE:	
FLOOR PLANS	
SHEET NO.	
SUB_B02	



PLUMBING SUBMISSION
(WATER SUPPLY NETWORK)

PROJECT: PROPOSED GROUP HOUSING ON KHASRA NO. 84(P), 780(P), 791(P) & 782 Khaf, VILLAGE SARASWAN, TEHSIL- SARGUNI NAGAR, LUCKNOW.	
CLIENT:	
STRUCTURAL CONSULTANT:	
M.E.P CONSULTANT:	
ARCHITECT: K DESIGN 405, AVALON APARTMENT NEW MANGALAPURI, NEW DELHI- 110030 E mail - architectrakeshsharma@gmail.com, royak07@gmail.com	
SCALE: N.T.S (A1)	DIRECTION:
DRAWING BLOCK: SITE PLAN	
SHEET TITLE: SITE LAYOUT	
SHEET NO. SUB_S01	