


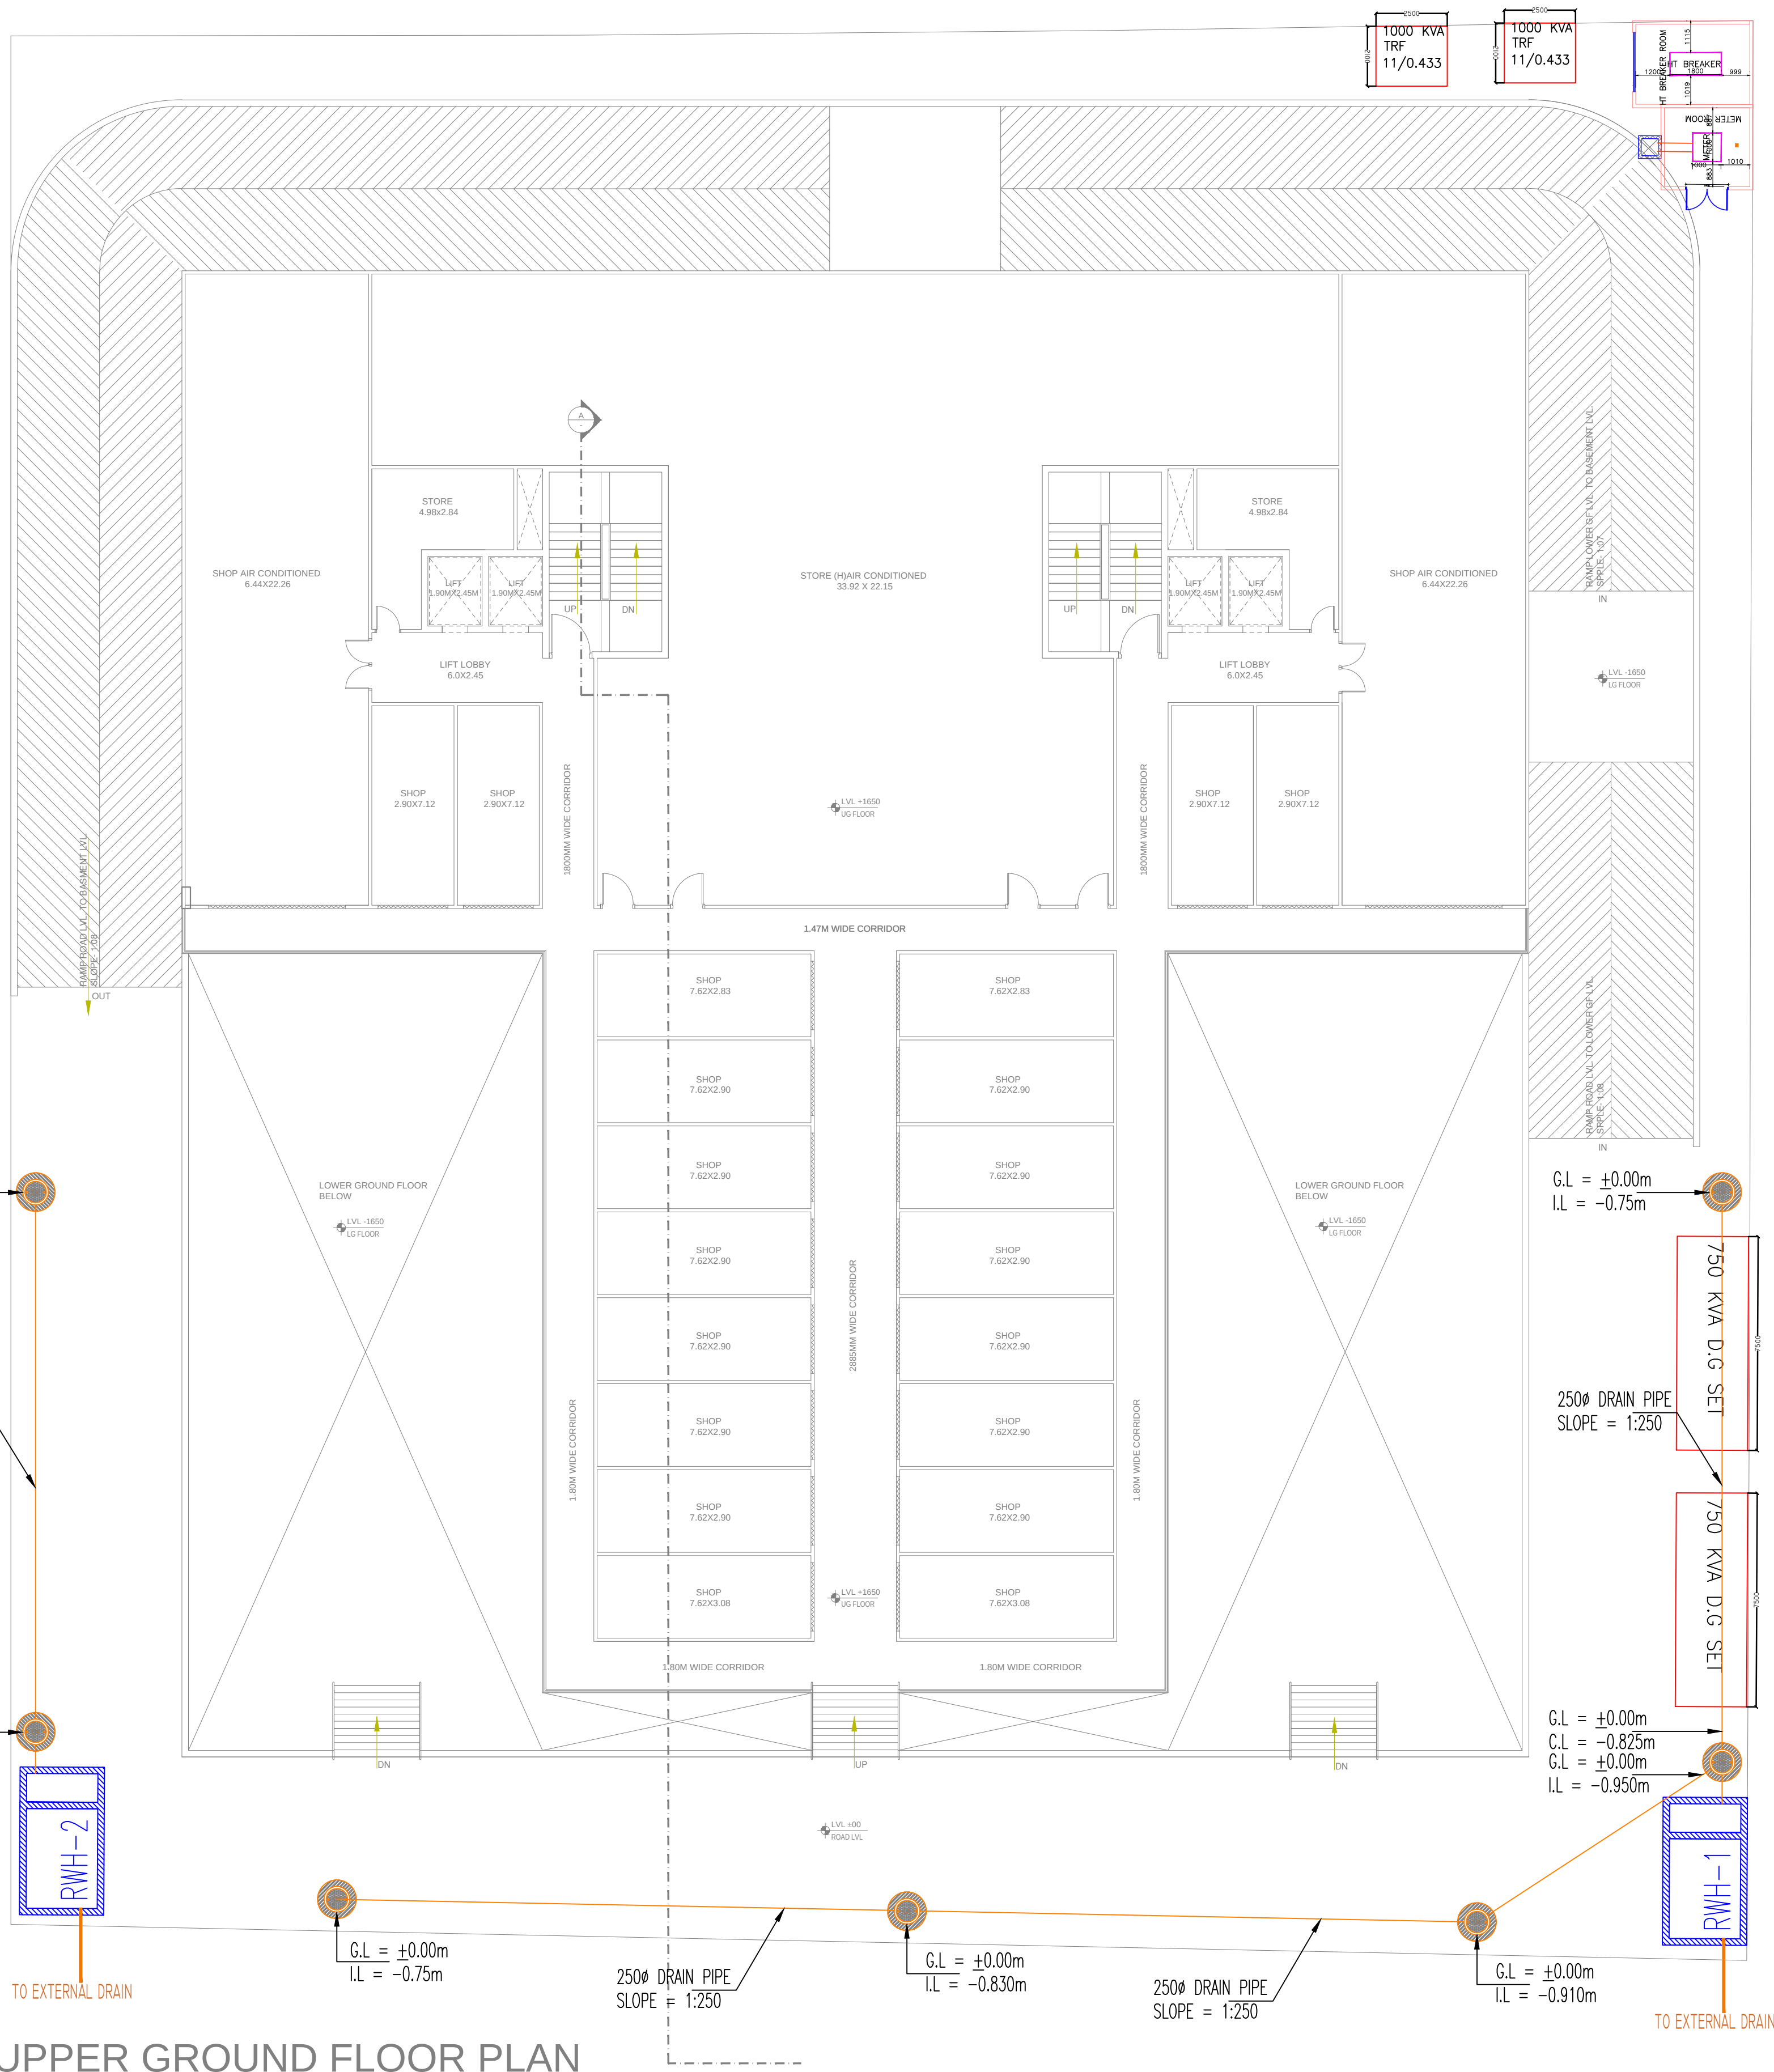

UPPER GROUND FLOOR PLAN

LEGENDS FOR DRAINAGE SYSTEM:-	
	DOMESTIC WATER SUPPLY PIPE
	DOMESTIC WATER SUPPLY PIPE
	DRAINAGE MANHOLE
	RAIN WATER HARVESTING PIT

GROUND FLOOR PLAN

PROJECT -

PROPOSED HOTEL AT
VILLAGE - NOORNAGAR
GHAZIABAD (U.P)

OWNER -

DRAWING TITLE :-

EXTERNAL SERVICES LAYOUT PLAN

OWNER SIGN

ARCHITECT SIGN

ARCHITECTS & PLANNERS :

SINGLA ARCHITECTS & ASSOCIATES

EROS MARKET PLACE, PLOT NO- 02, SHOP - 87, 1ST. FLOOR

SHAKTI KHAND - 2, INDIRAPURAM, GHAZIABAD (U.P.)

Mob: 9971998445

e-mail : gsingla32@gmail.com,

MEP Consultant:

 **WeDESIGN Associates**
"Engineered to perfection"
Email - weesignassociates@gmail.com
Mob: - 9999288416, 9999288407, 9882244495

DEALT BY:- DK CHECKED BY:- NTS. SCALE:- DATE:- 07.04.2025 DRG. No:- PL-EXT-01