


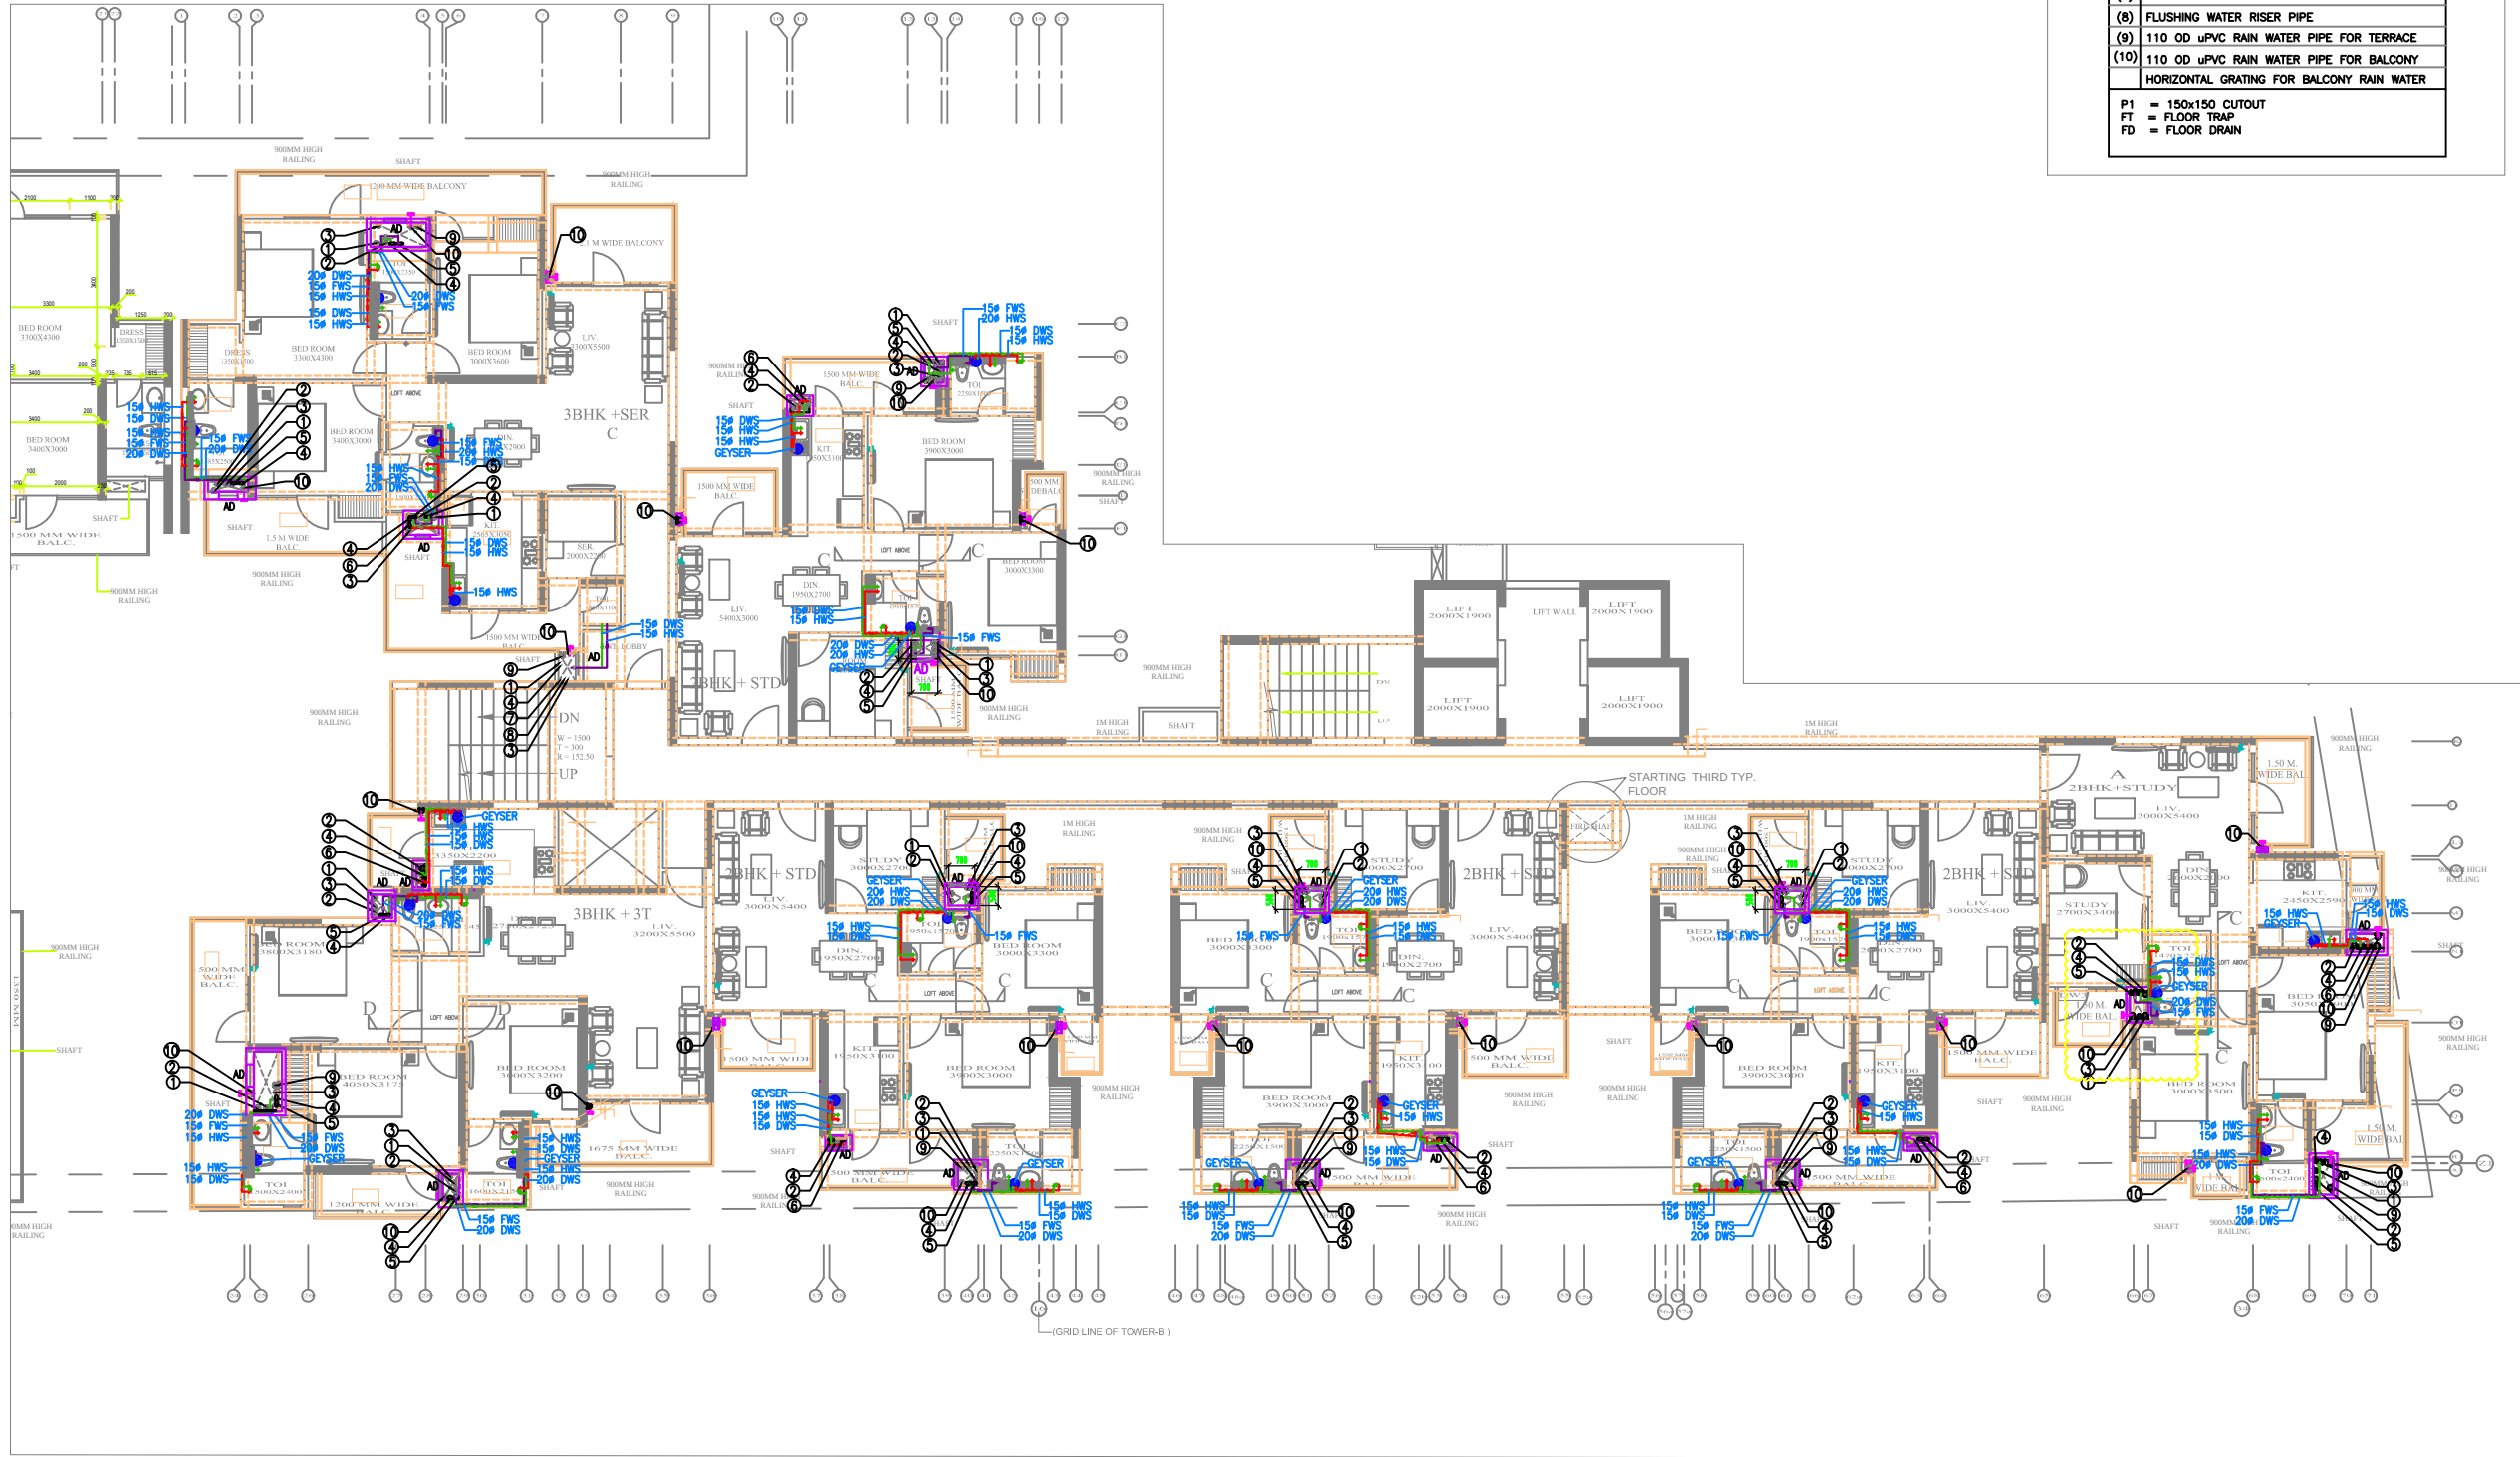

NOTE. TOILET SUNK
ALL TOILET SHALL BEE 350mm SUNK + FLOOR FINISH

PLUMBING LEGEND:-	
(1)	110 OD uPVC SOIL & VENT PIPE
(2)	110 OD uPVC WASTE & VENT PIPE
(3)	75 OD uPVC ANTISYPHONAGE PIPE
(4)	DOMESTIC WATER DN TAKE PIPE
(5)	FLUSHING WATER DN TAKE PIPE
(6)	HOT WATER DN TAKE PIPE FROM SOLAR
(7)	DOMESTIC WATER RISER PIPE
(8)	FLUSHING WATER RISER PIPE
(9)	110 OD uPVC RAIN WATER PIPE FOR TERRACE
(10)	110 OD uPVC RAIN WATER PIPE FOR BALCONY
HORIZONTAL GRATING FOR BALCONY RAIN WATER	

P1 = 150x150 CUTOUT
FT = FLOOR TRAP
FD = FLOOR DRAIN

NOTE. TOILET SUNK
ALL TOILET SHALL BEE 350mm SUNK + FLOOR FINISH

REVISIONS	DATE

CLIENT :
REAL ANCHOR PVT.LTD.


PROJECT :
PROPOSED APARTMENT FOR
M/S WORLD RESIDENCY
AT INDIRAPURAM

Building Services (MEP) Consultants
SNC
MEP Consulting Engineers
Sunil Nayyar Consultants Pvt. Ltd.
Head Office : 206- 206A & 305A-305B, 2nd & 3rd Floor,
Time Centre, DLF Golf Course Road,
Sector-54, Gurgaon-122002, Haryana (India)
Tele : +91-124-4803800 (30 Lines)
Fax : +91-124-4803817
E-mail : sncgurgaon@snc.co.in
URL : www.snc.co.in
□ Delhi ■ Gurgaon

SCALE	1:100
DATE	12.11.13
CHK	JOSHI
DRN	SURENDRA

DRG. TITLE : TOWER -B TYPICAL FLOOR PLAN WATER SUPPLY LAYOUT	 DRG. NO. SNC/WR/TB/WS/PL-03
---	---

ARCHITECTS: DIMENSIONS & DESIGNS architects,engineers&interior designers D-669, Chitrtranjan Park NEW DELHI-110019 (INDIA) PH: 011-26274473, 011-26274474	D&D
--	----------------

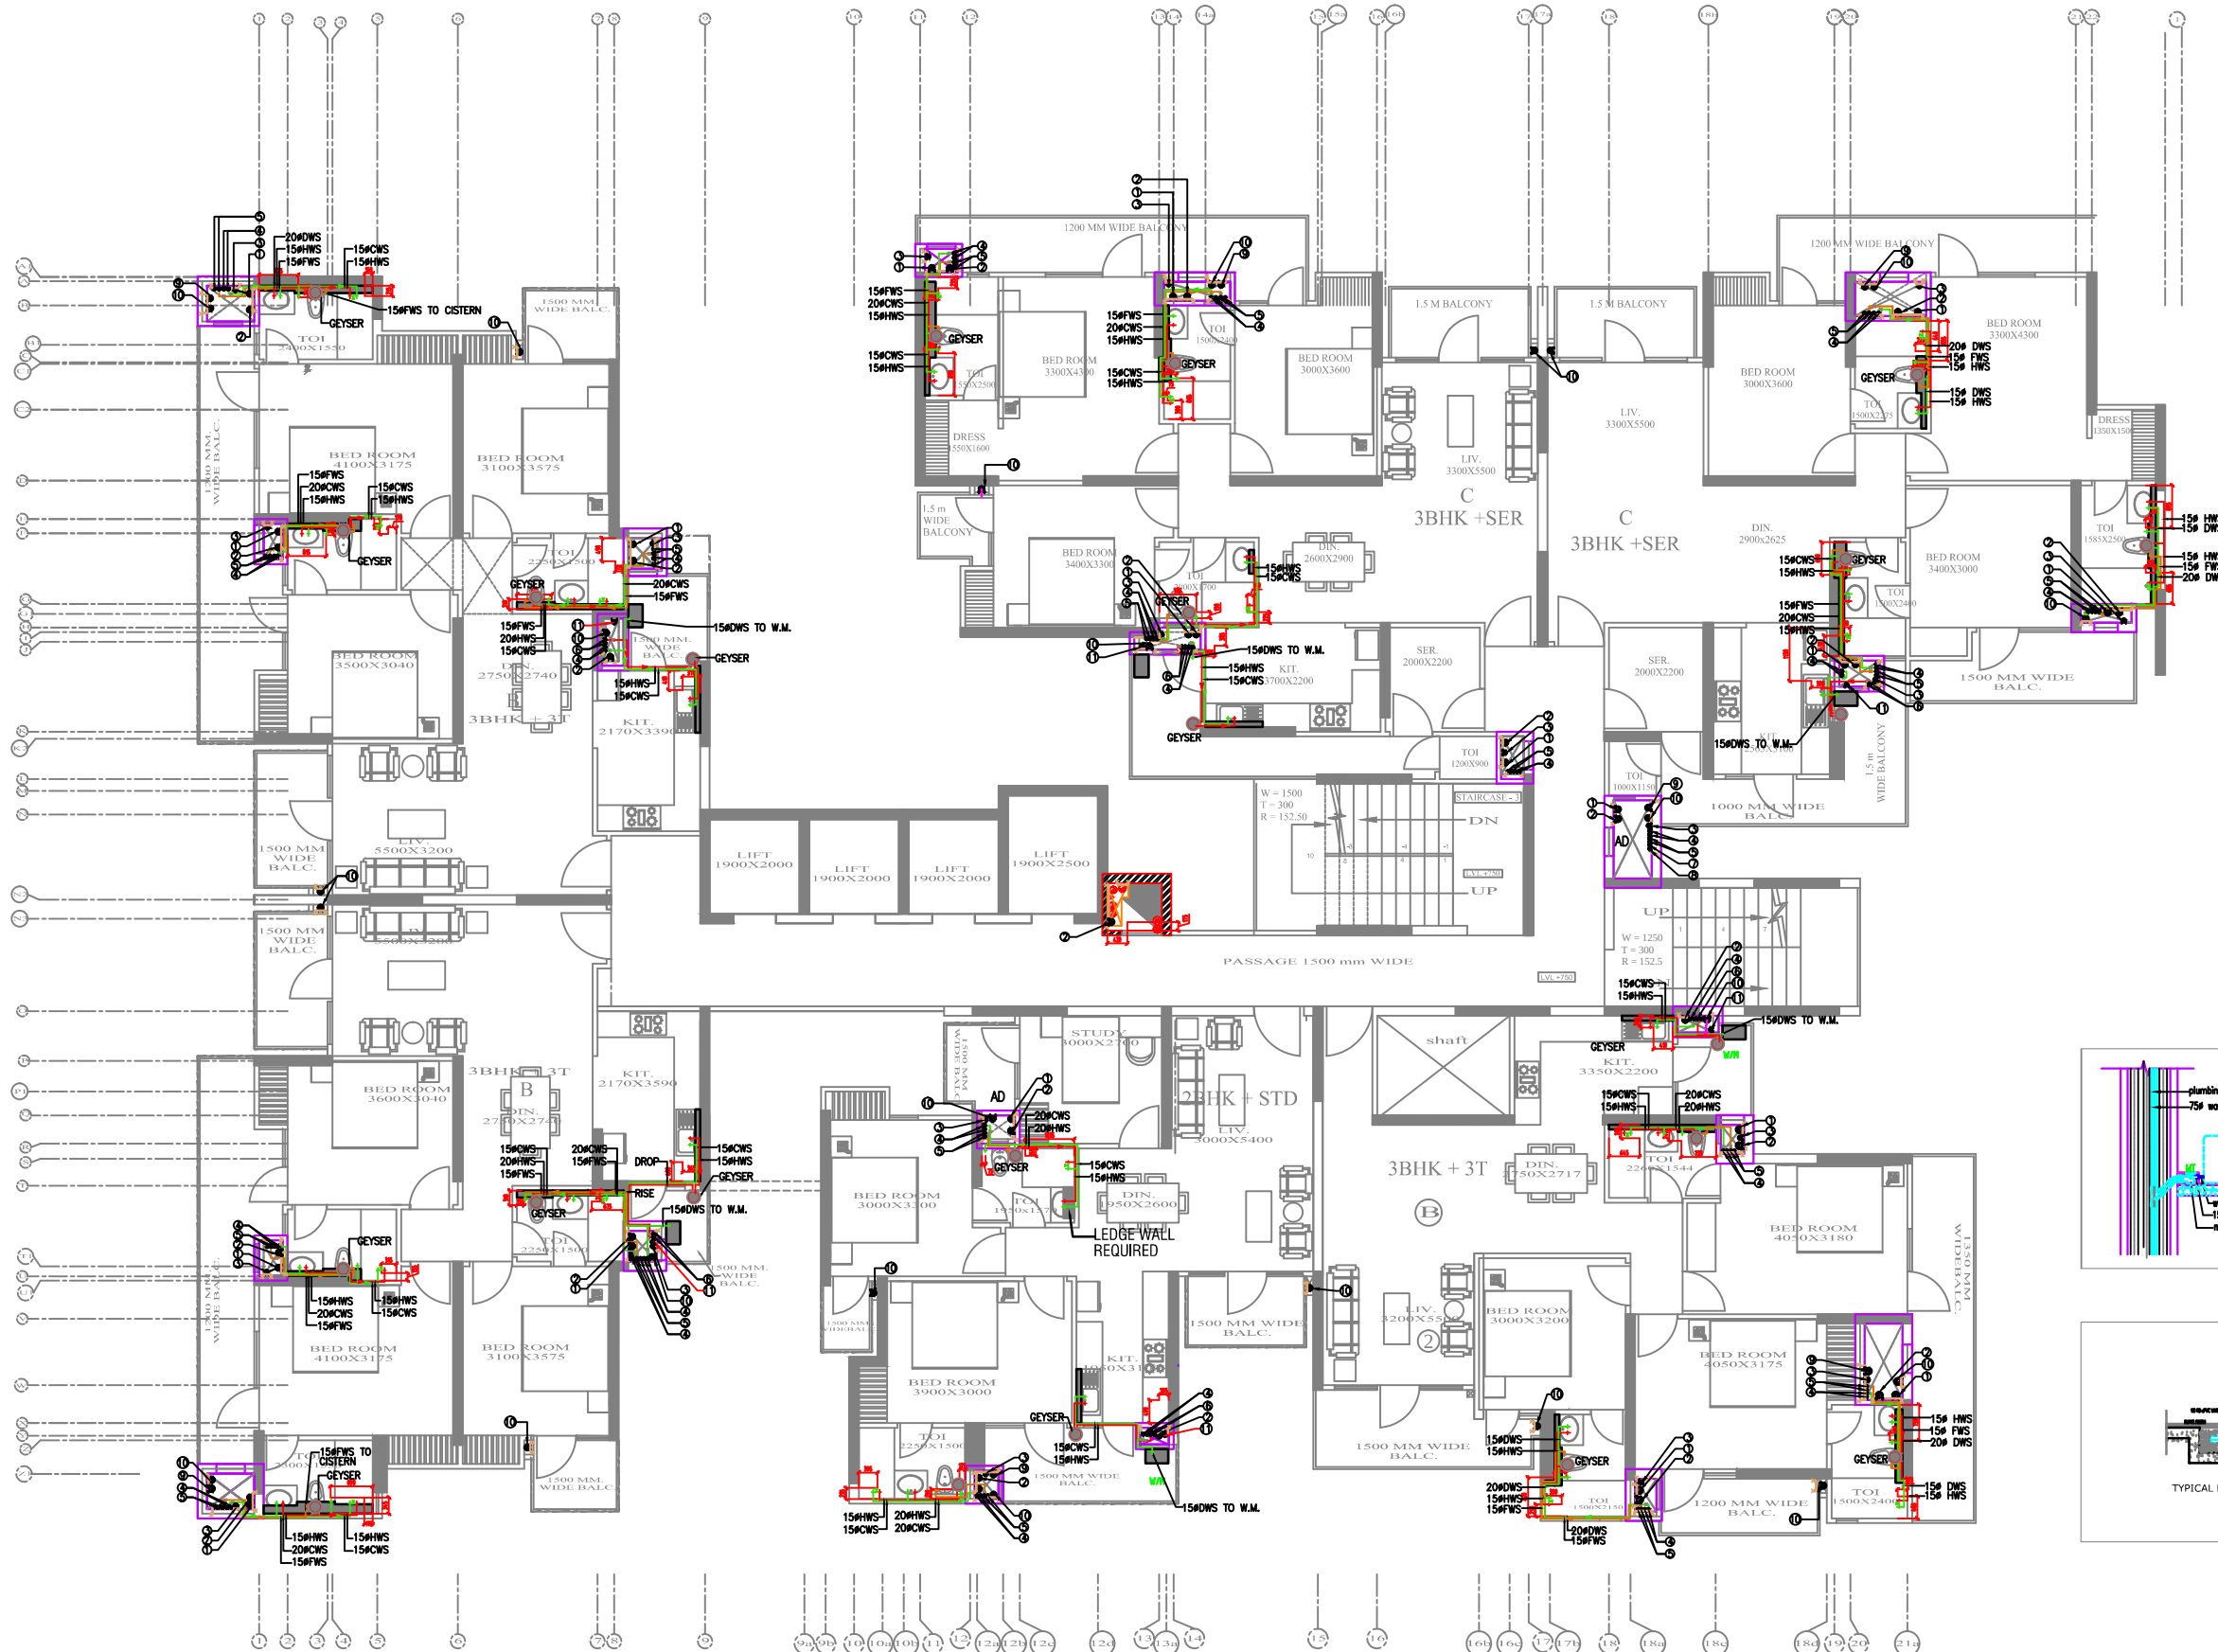

LEGEND FOR VERTICAL PIPES:	
(1)	110 OD uPVC SOIL & VENT PIPE
(2)	110 OD uPVC WASTE & VENT PIPE
(3)	75 OD uPVC ANTISIPHONAGE PIPE
(4)	DOMESTIC WATER DN TAKE PIPE
(5)	FLUSHING WATER DN TAKE PIPE
(6)	HOT WATER DN TAKE PIPE FROM SOLAR
(7)	DOMESTIC WATER RISER PIPE
(8)	FLUSHING WATER RISER PIPE
(9)	110 OD uPVC RAIN WATER PIPE FOR TERRACE
(10)	110 OD uPVC RAIN WATER PIPE FOR BALCONY
(11)	75# WASTE PIPE FOR WASHING MACHINE DRAIN.

PIPE DIA	DESCRIPTION
110 OD	SOIL PIPE FROM WATER CLOSET TO HORIZONTAL / VERTICAL STACK
110 OD	WASTE PIPE FROM FLOOR TRAP TO VERTICAL STACK
40 OD	WASTE PIPE FROM WASH BASIN TO FLOOR TRAP
50 OD	WASTE PIPE FROM SINK TO FLOOR TRAP
63 OD	WASTE PIPE FROM FLOOR DRAIN TO FLOOR TRAP

LEGEND FOR HORIZONTAL PIPES:	
—	SOIL LINE
—	WASTE LINE
—	DOM. WATER SUPPLY LINE
—	HOT WATER SUPPLY LINE
—	FLUSHING WATER SUPPLY LINE
—	VALVE/GATE VALVE

PLUMBING LEGEND:-	
⊙	FT FLOOR TRAP / URINAL TRAP
⊙	FD FLOOR DRAIN
⊙	BD HORIZONTAL GRATING FOR BALCONY DRAIN
⊙	WT MULTI TRAP FOR WASHING MACHINE
⊙	⊙ P1 150/150 CUTOFF FOR F.T., F.D. AND W.C. BALCONY TAP FOR WASHING MACHINE HT 750 MM

REV NO.	DATE	DESCRIPTION
R-01	31.03.17	AS PER ARCHITECT/ SITE COMMENTS

REVISIONS	
CLIENT :	REAL ANCHOR PVT.LTD.

PROJECT :	PROPOSED APARTMENT FOR M/S WORLD RESIDENCY AT INDIRAPURAM
-----------	---

MEP CONSULTANTS :-	KKSC KISHOR KUMAR SERVICES CONSULTANTS 007-PINNACLE TOWER, GH-7 AHINSA KHAND-2, INDIRAPURAM GHAZIABAD, UP-201014 PHONE: +91 120 4132558 MOBILE: +91 9910487835 kkscoi01@gmail.com
--------------------	---

ARCHITECTS:	DIMENSIONS & DESIGNS architects,engineers&interior designers D-669, Chitranganj Park NEW DELHI-110019 (INDIA) PH: 011-26274473, 011-26274474
-------------	---

CONTRACTOR:-	JAPSIN JACOB WIRE DRAWING PVT.LTD. (FIRE FIGHTING & CONSULTING DIVISION) F-15/G-1 DILSAD COLONY DELHI-110095 mobile-9810619902
--------------	---

DRG. TITLE:-	TOWER -A TYPICAL FLOOR PLAN (WATER SUPPLY LAYOUT)
--------------	---

DRAWN	SCALE	REVISION NO.
UMESH	1:75	R-01
DRG. TITLE:-	DRG. NO.	
RAM KUMAR	SH-PL-TR-A-WS-02	

SHOP DRAWING

