



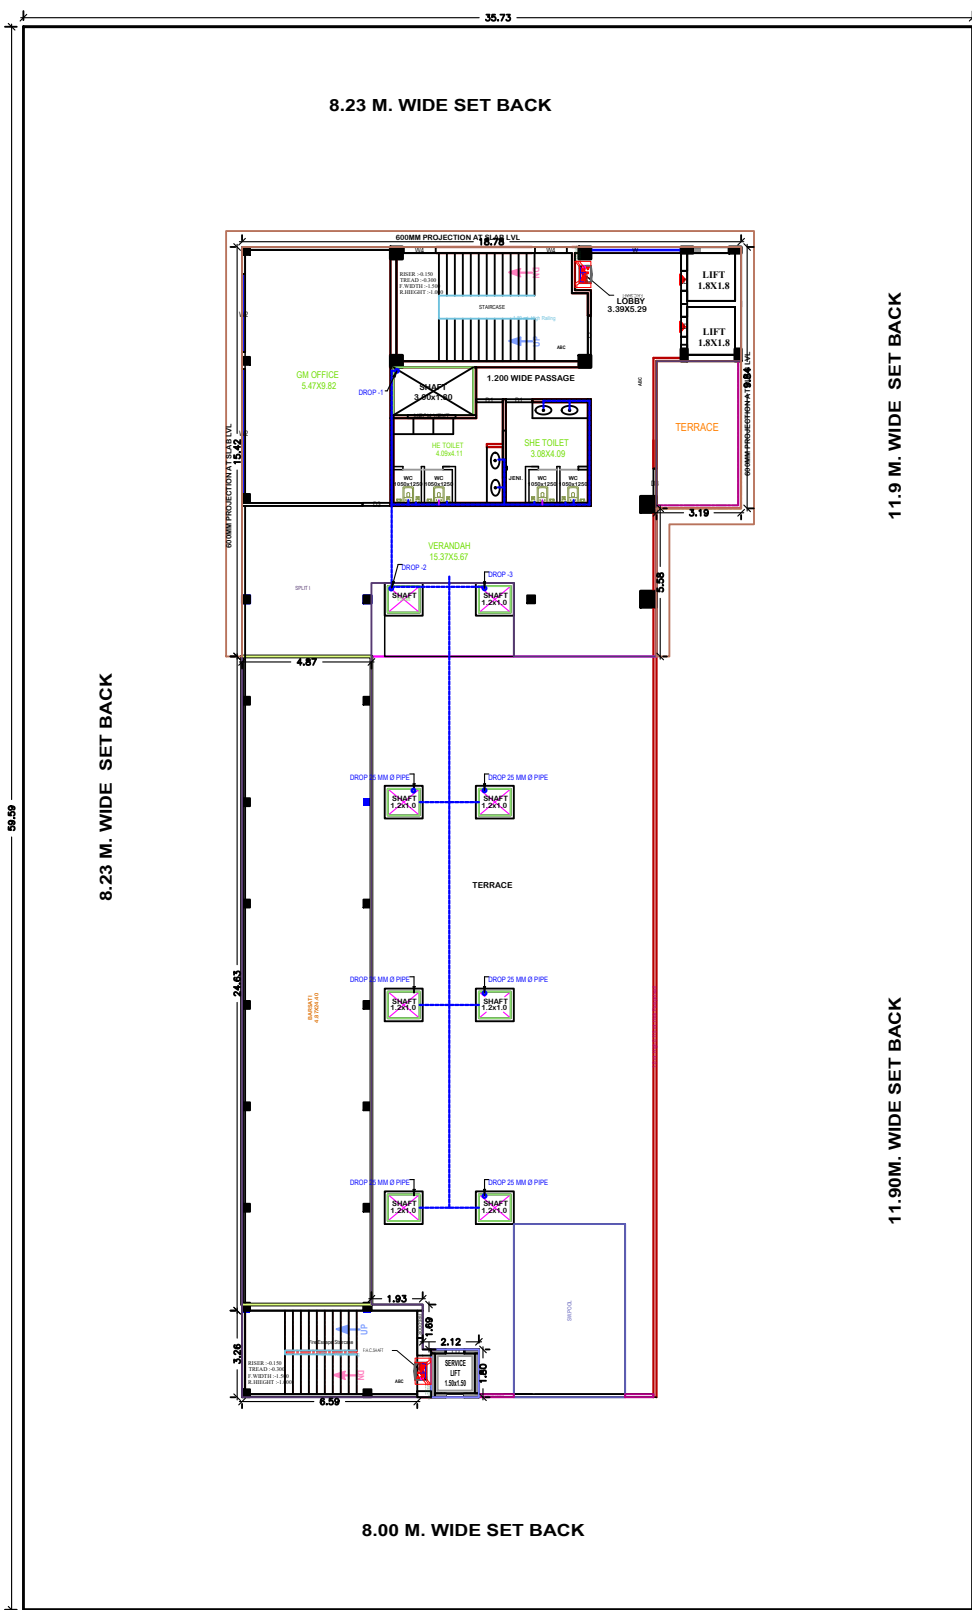


SIXTH FLOOR PLAN
SCALE 1:100

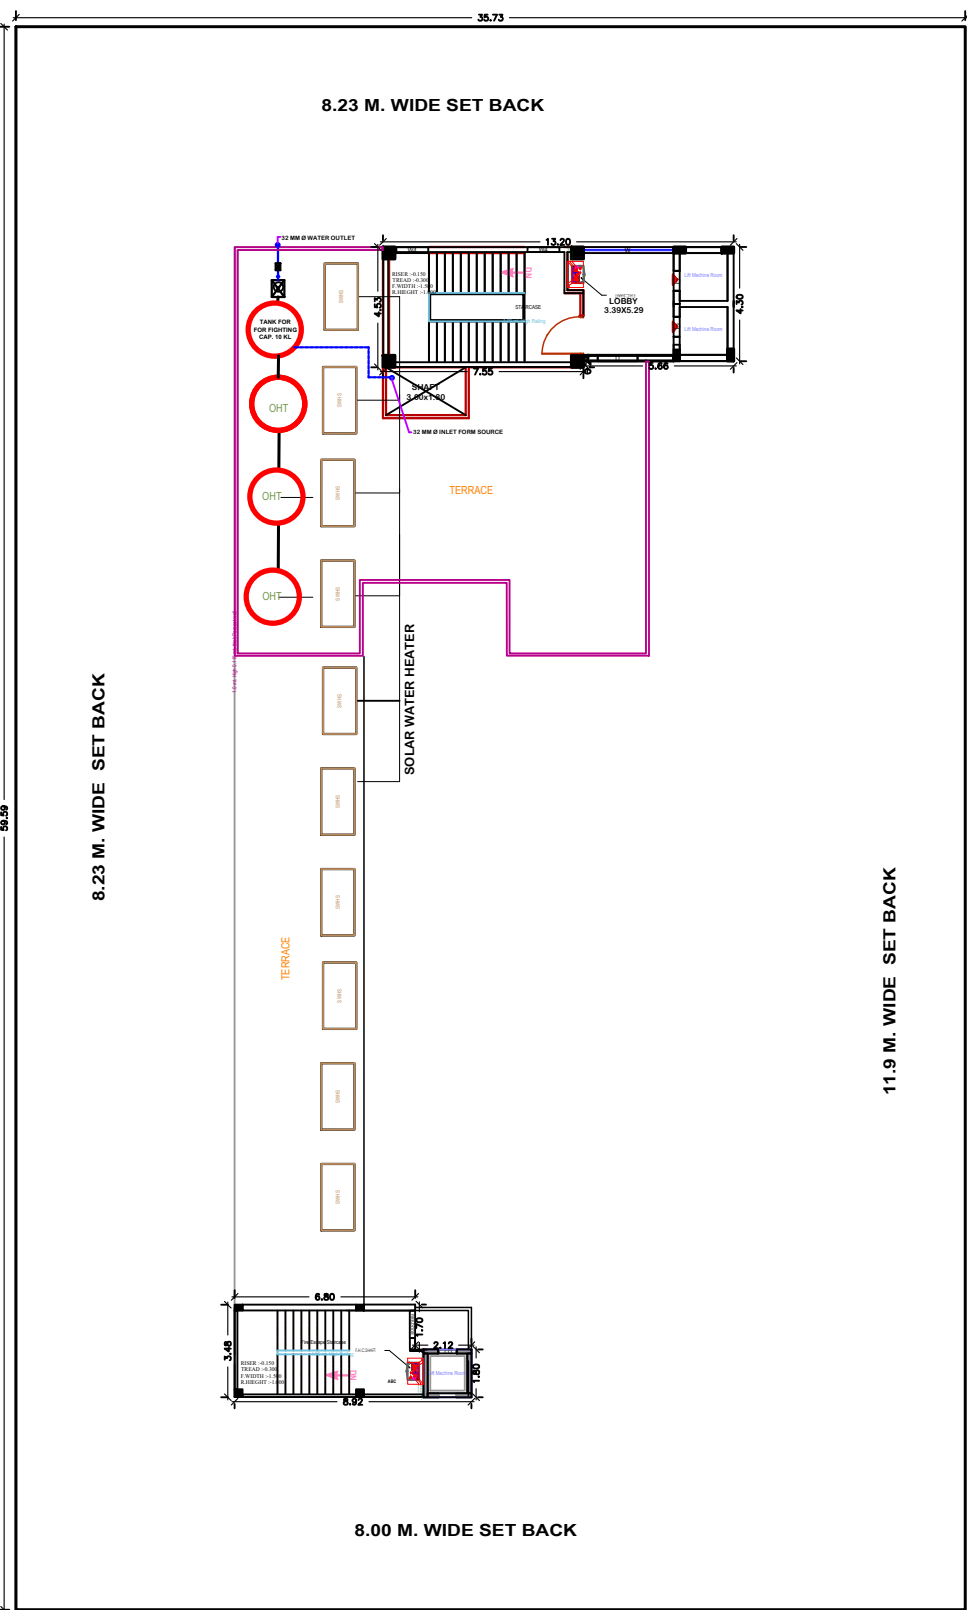


TERRACE FLOOR PLAN
SCALE 1:100




SITE PLAN

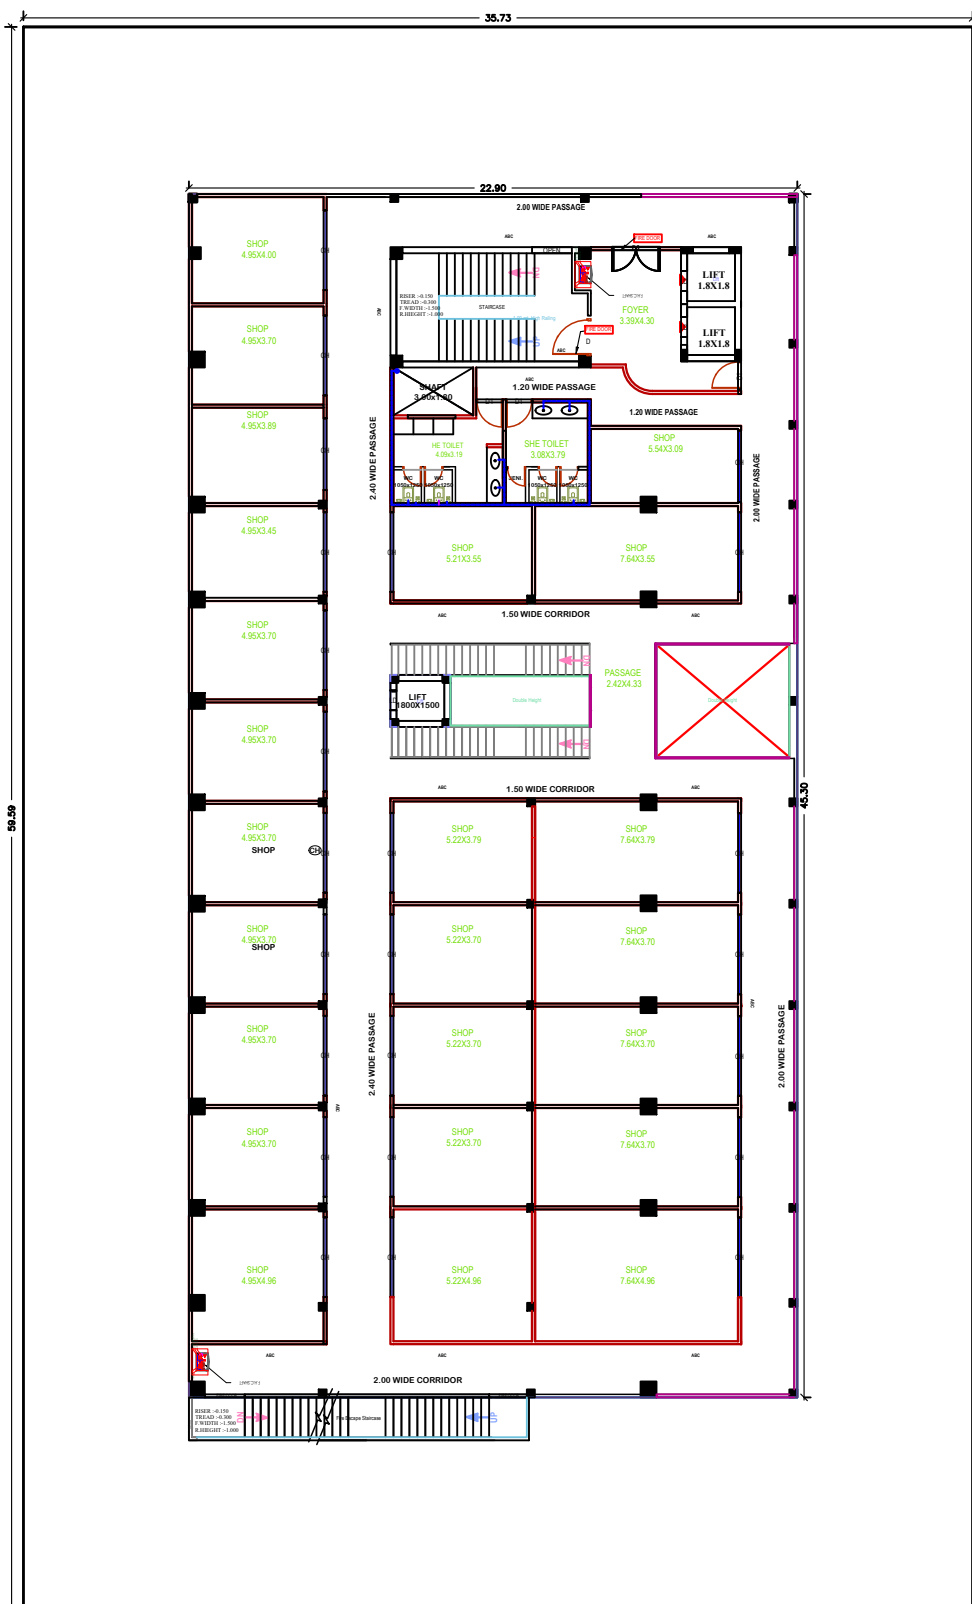


SECOND FLOOR PLAN
SCALE 1:100

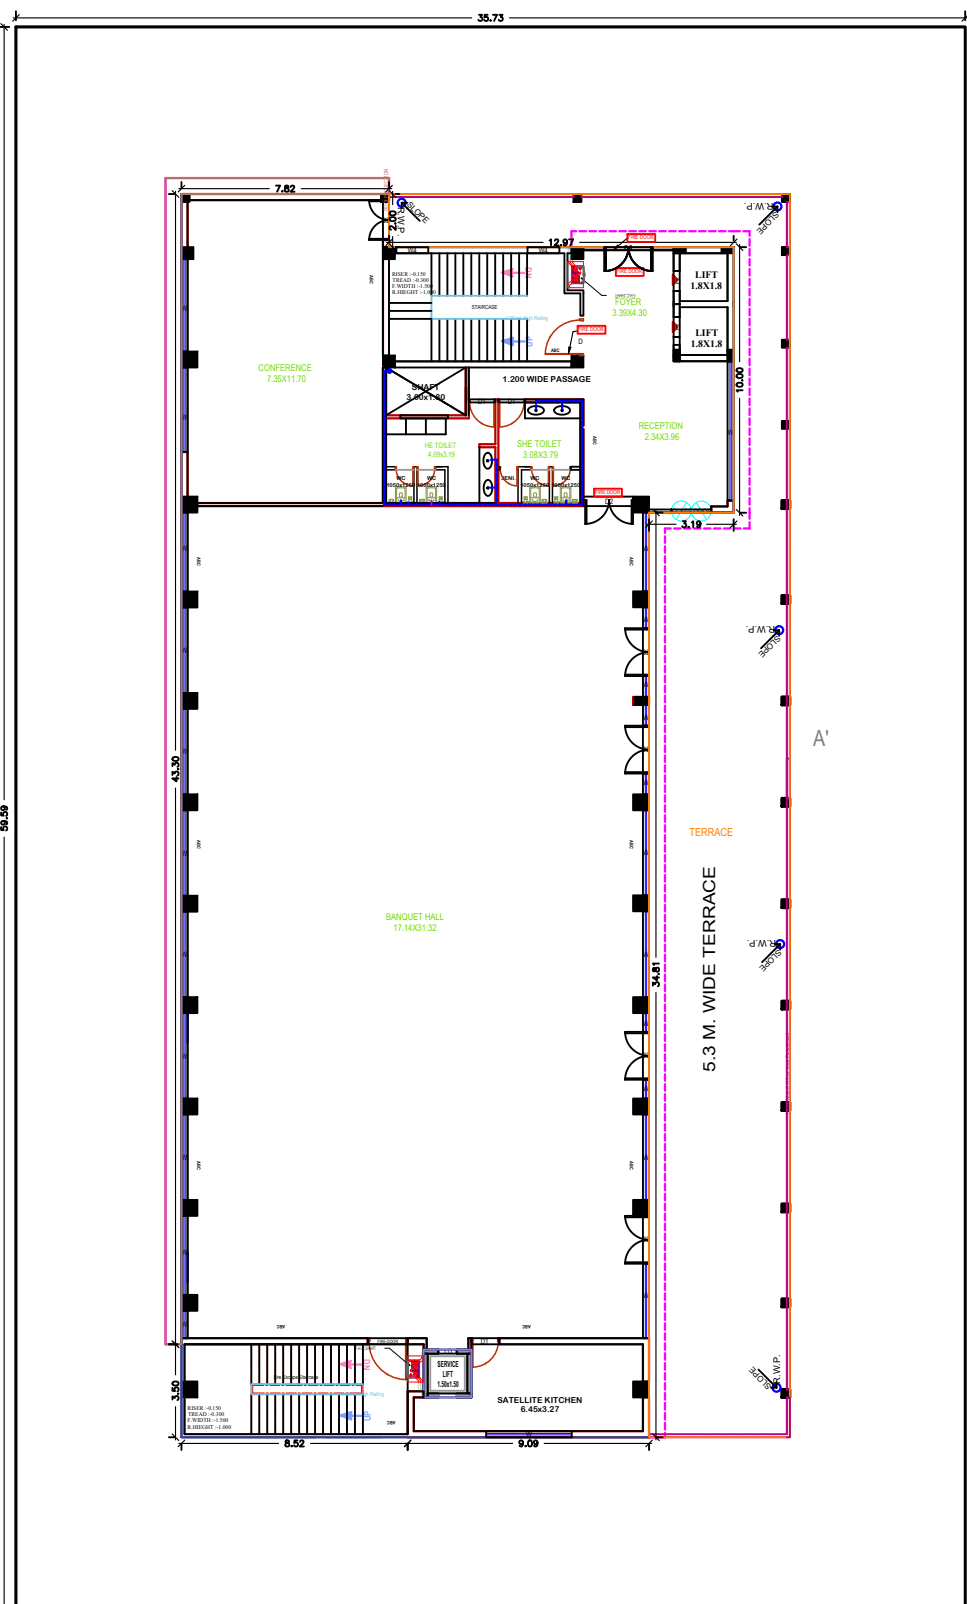


THIRD FLOOR PLAN
SCALE 1:100

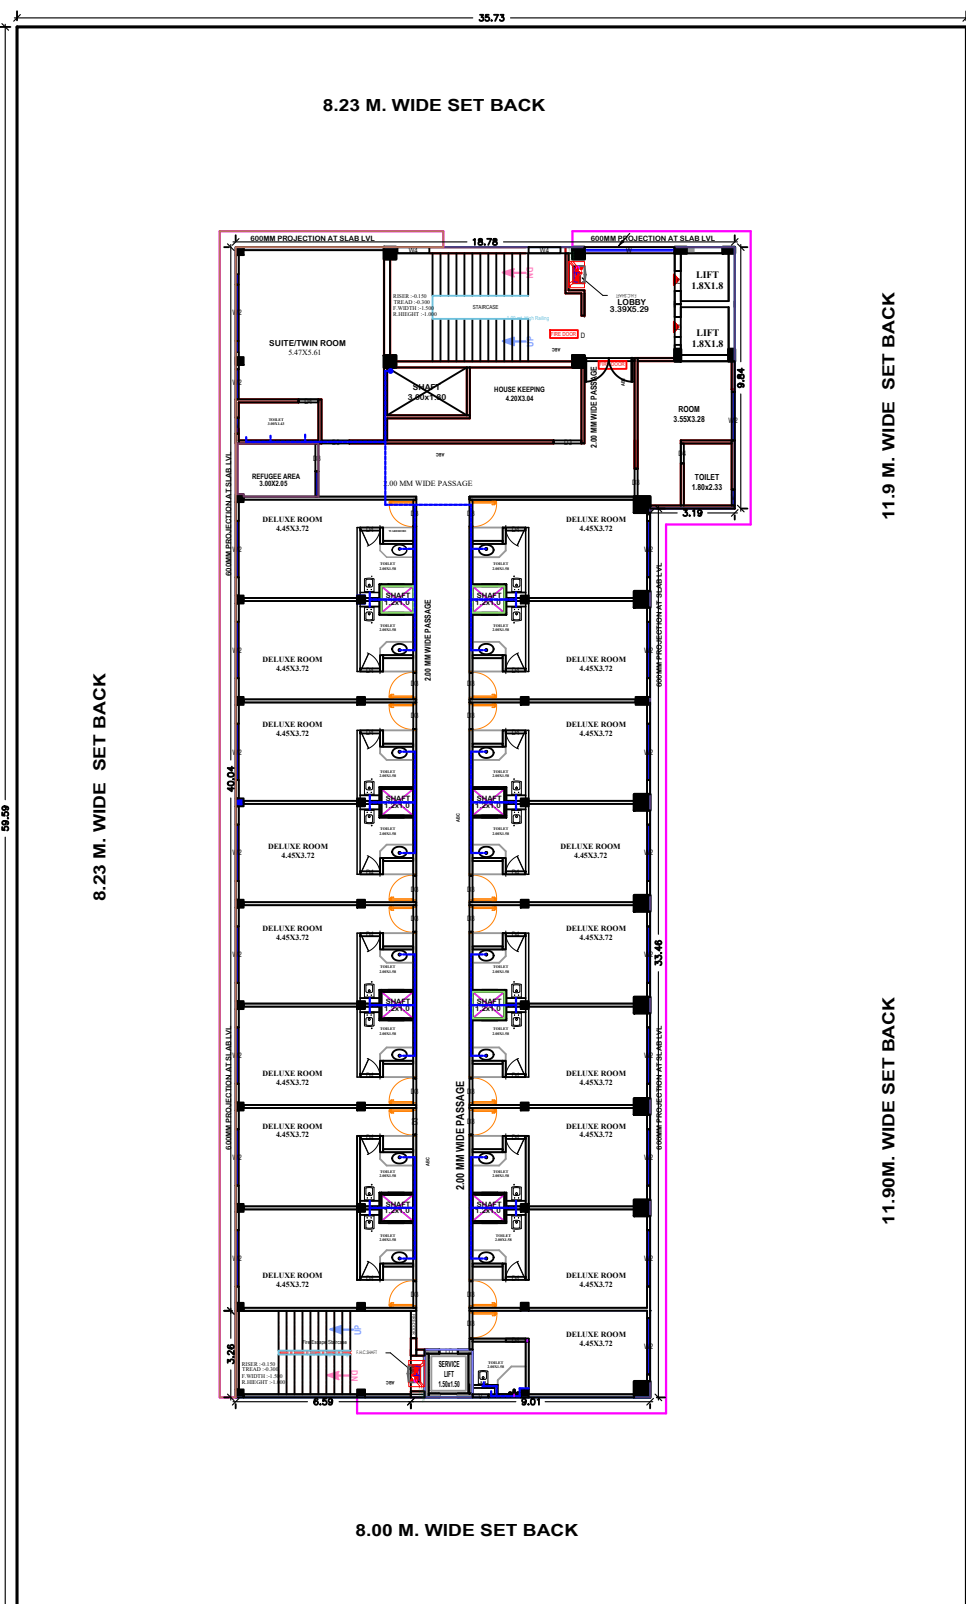


FOURTH FLOOR PLAN
SCALE 1:100

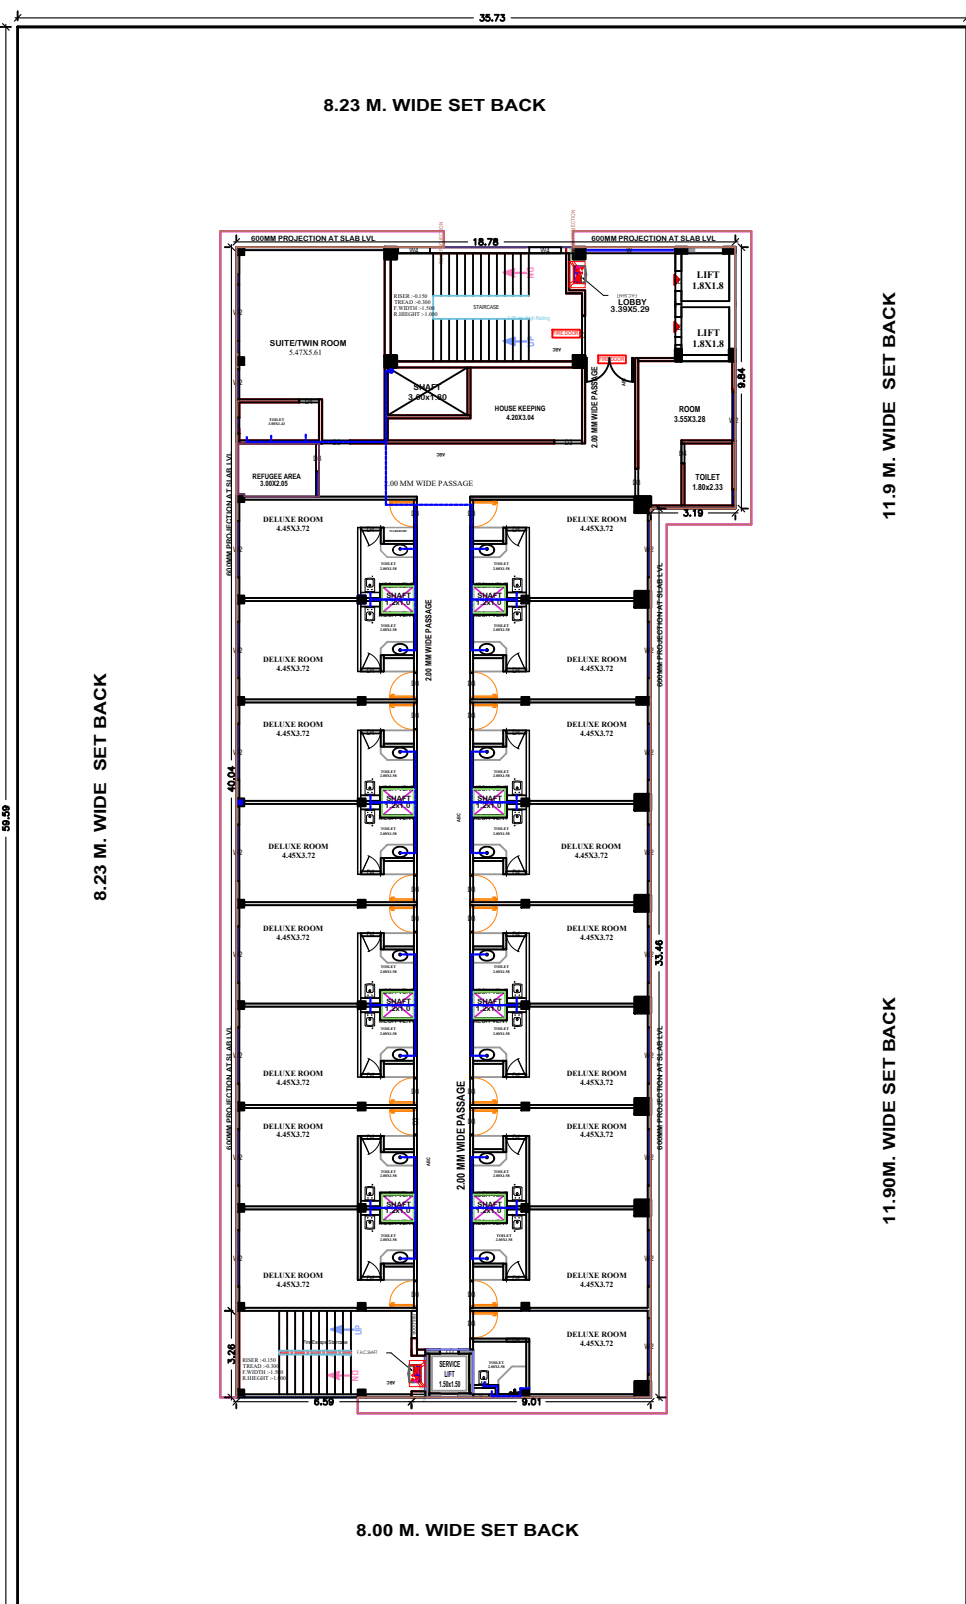


FIFTH FLOOR PLAN
SCALE 1:100

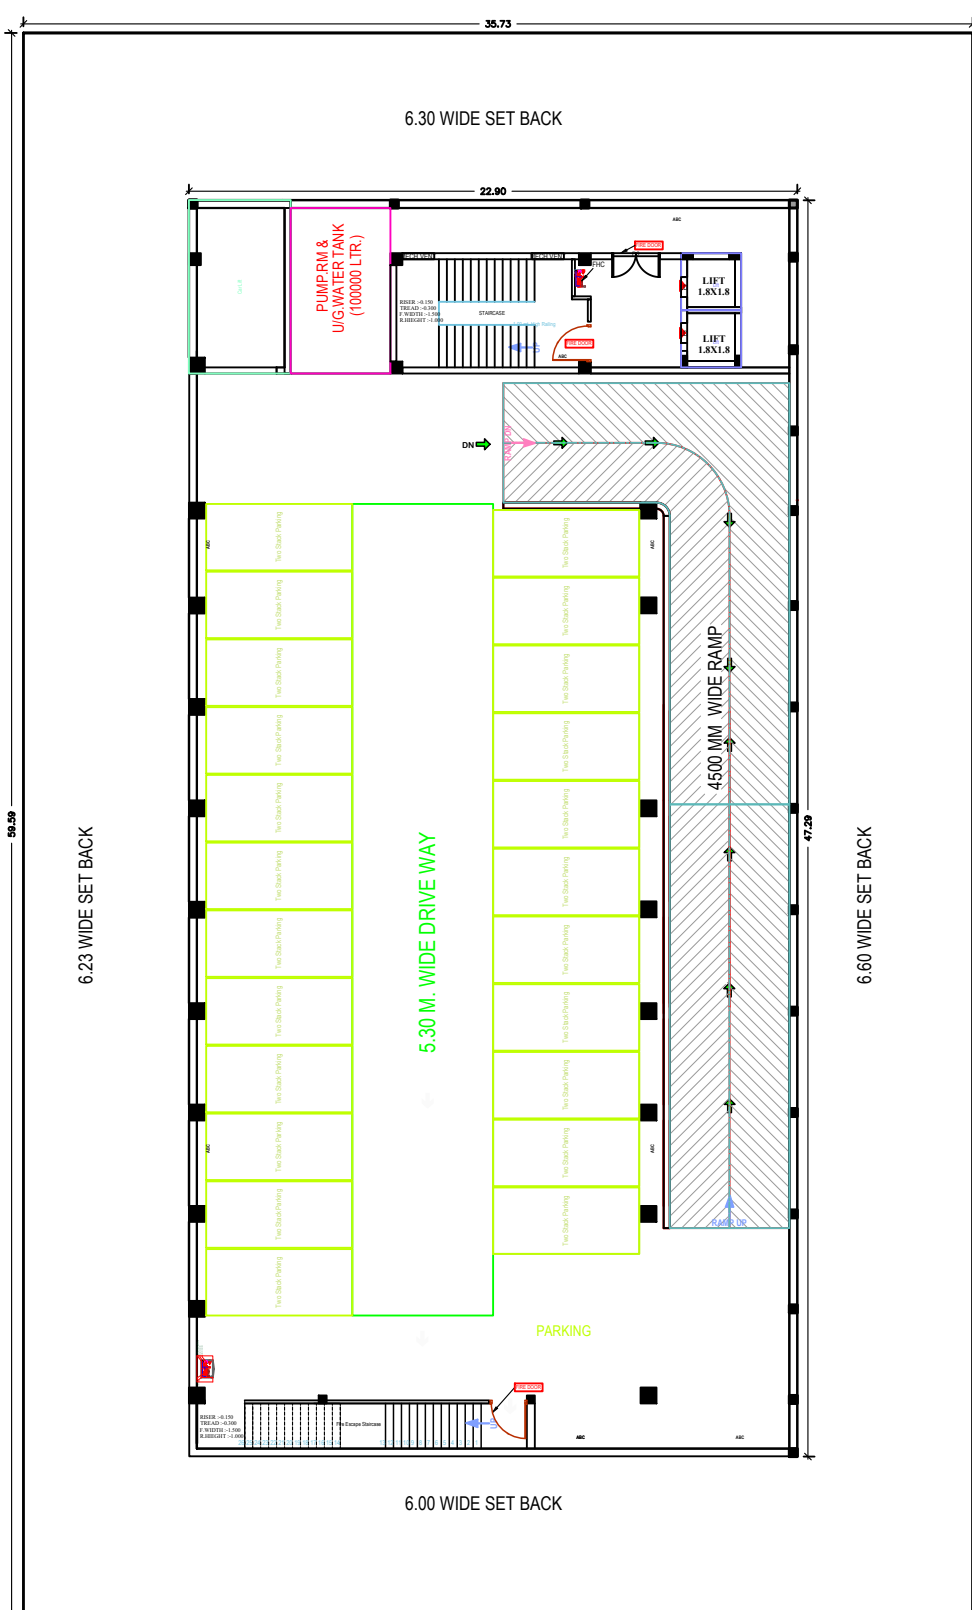


LOWER BASEMENT FLOOR PLAN
SCALE 1:100

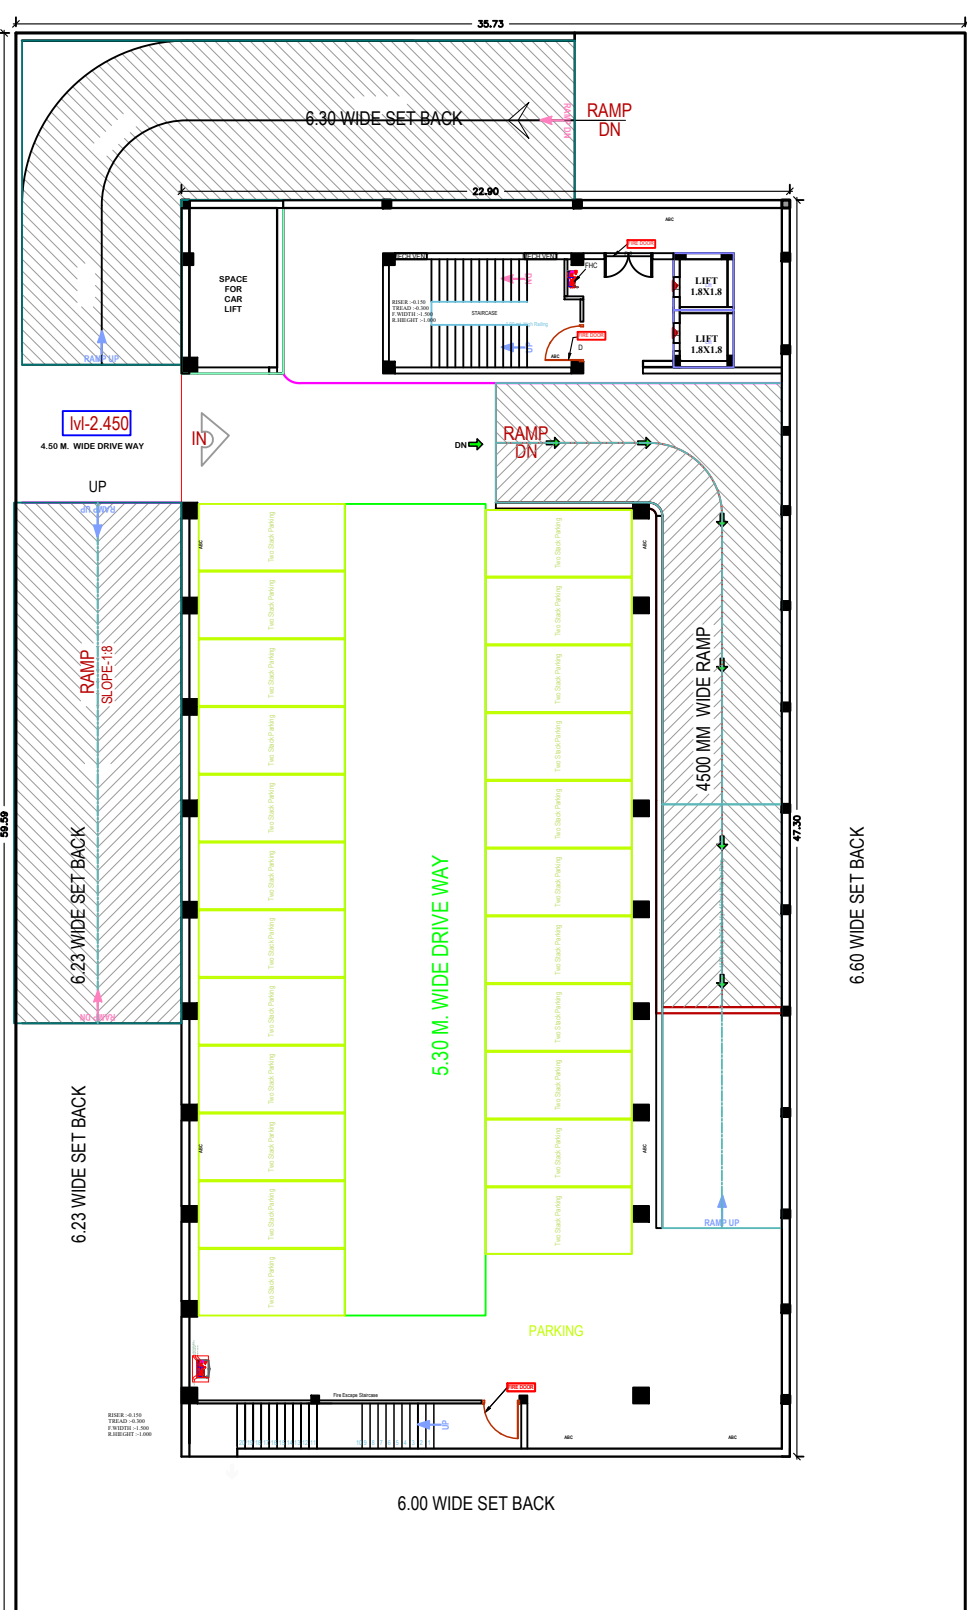

UPPER BASEMENT FLOOR PLAN
SCALE 1:100

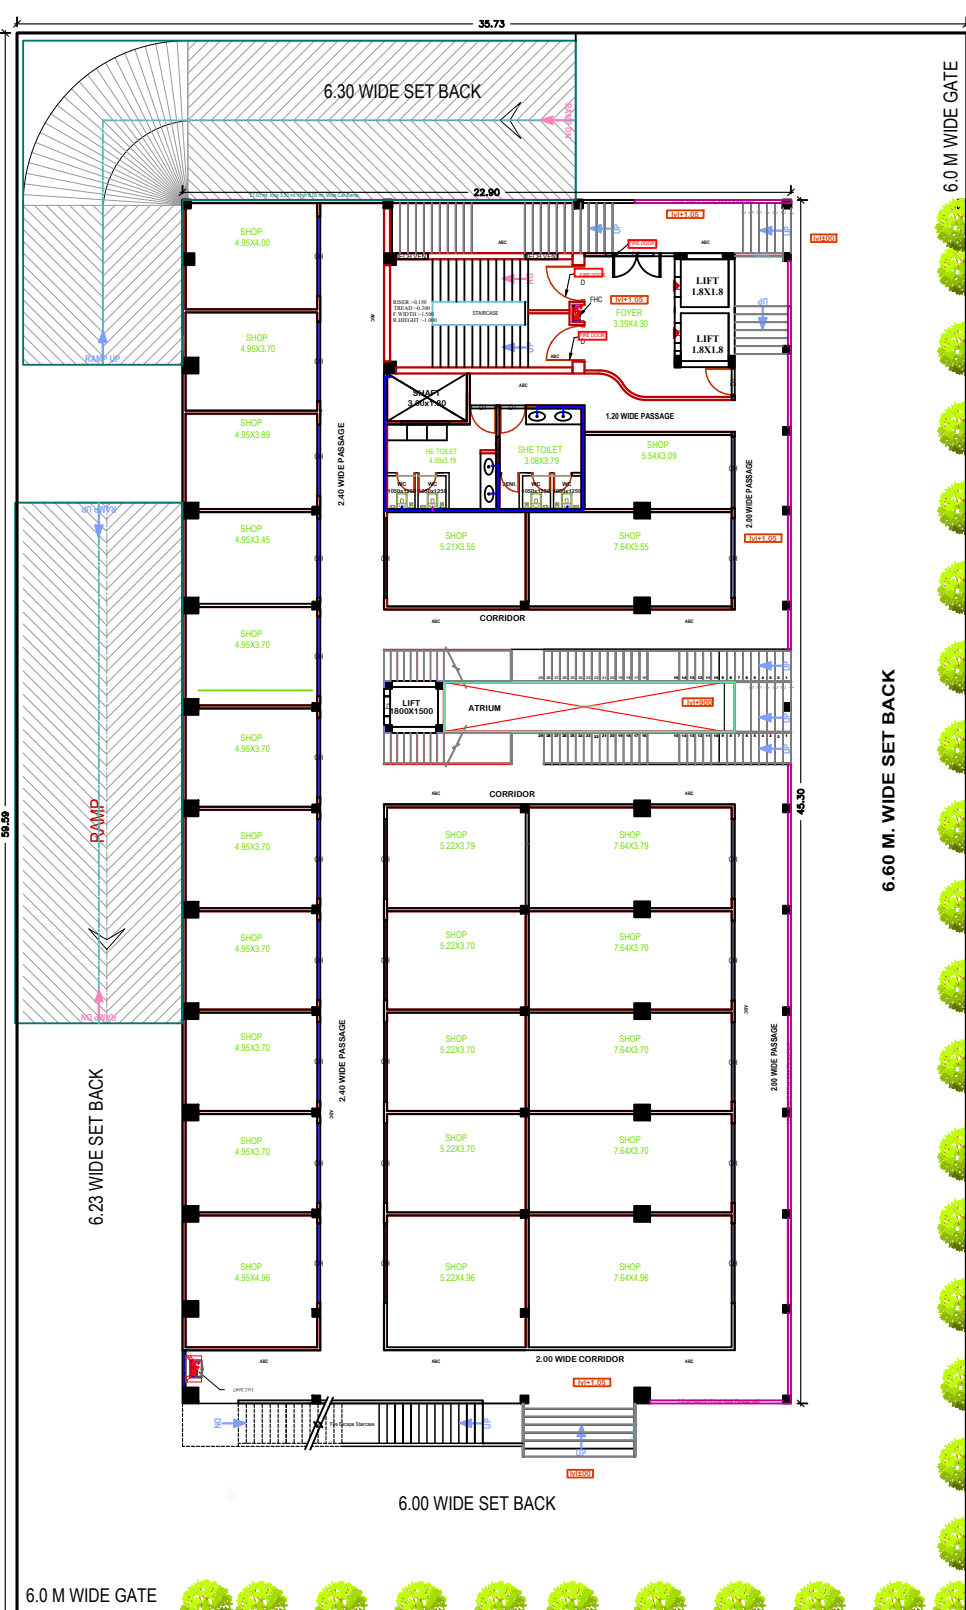

GROUND FLOOR PLAN
SCALE 1:100

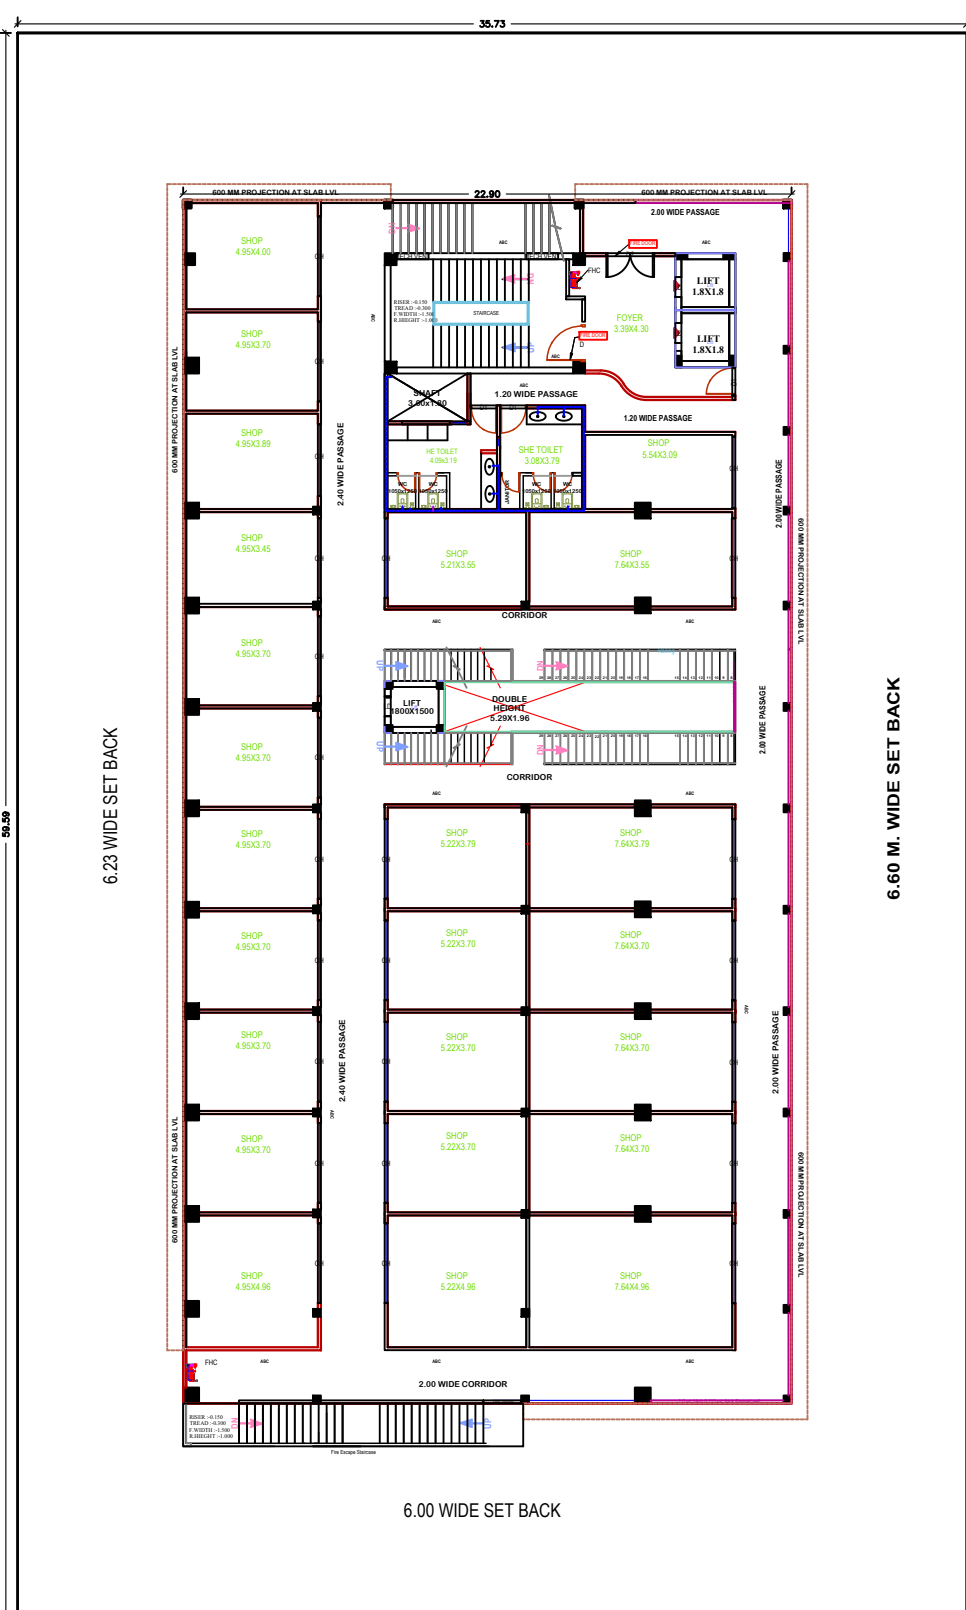

FIRST FLOOR PLAN
SCALE 1:100

Project Title :PROPOSED FIRE FIGHTING
COMMERCIAL BUILDING PLAN
OF PRISTINE ENTERPRISES
PLOT FOR SECTOR SHOPPING-2
(COMMERCIAL) SITUATED AT
OMAXE INTEGRATED TOWNSHIP,
SARSAWAN, LUCKNOW

AREA DETAIL

1	TOTAL PLOT AREA-	2129.09 SQM.
2	LOWER BASEMENT FLOOR COVD. AREA-	1083.17 SQM.
3	UPPER BASEMENT FLOOR COVD. AREA-	1083.17 SQM.
4	GROUND FLOOR COVD. AREA-	1018.82 SQM.
5	FIRST FLOOR COVD.AREA-	1001.88 SQM.
6	SECOND FLOOR COVD. AREA-	991.26 SQM.
7	THIRD FLOOR COVD.AREA-	793.06 SQM.
8	FOURTH FLOOR COVD. AREA-	656.34 SQM.
9	FIFTH FLOOR COVD.AREA-	656.34 SQM.
10	SIXTH FLOOR COVD AREA-	232.01 SQM.
11	MUMTY AREA-	81.90 SQM.
12	TOTAL COVD AREA-	7597.95 SQM.
13	GROUND FLOOR COVERAGE	47.852 %
14	F.A.R. ACHIEVED-	2.512

DOOR / WINDOW DETAIL

S.No.	TYPE	SIZE	SILL
1	CH	3600X3000	0
2	CH-1	2400X2400	0
3	D1	1500X2100	0
4	D2	1000X2100	0
5	D3	750X2100	0
6	W	1800X1350	750
7	W1	1500X1350	750
8	V	900X450	1650


REF-	SEWER LINE SHOWN THUS	— — — — —
1	RAIN WATER LINE SHOWN THUS	— — — — —
2	RAIN WATER PIPE	100 MM (P.V.C.P)
3	RAIN WATER HARVESTING	100 MM (P.V.C.P)
4	TREE	100 MM (P.V.C.P)
5	SWHS	SOLAR WATER HEAT SYSTEM

LEGEND:- WATER SUPPLY AND SEWERAGE

SL	SYMBOL	DESCRIPTION	SL	SYMBOL	LEGEND	DESCRIPTION
1.	[Symbol]	SEWER LINE MAN HOLE 900X800	14	[Symbol]	[Symbol]	150 Ø SOIL WASTE WATER PIPE
2.	[Symbol]	G.T. (450X450)	15	[Symbol]	[Symbol]	50 Ø DOMESTIC WATER PIPE
3.	[Symbol]	150 Ø S.W.P. S=1 IN 100	16	[Symbol]	[Symbol]	100 Ø WASTE WATER PIPE
4.	[Symbol]	WATER SUPPLY LINE (CPVC)	17	[Symbol]	[Symbol]	100 Ø RAIN WATER PIPE
5.	[Symbol]	WEST WATER PIPE (UPVC)				
6.	[Symbol]	RAIN WATER PIPE (PVC)				
7.	[Symbol]	DIRECTION OF FLOW				
8.	[Symbol]	WASH BASIN				
9.	[Symbol]	EUROPEAN W.C.				
10.	[Symbol]	FLOOR TRAP/ FLOOR DRAIN				
11.	[Symbol]	URINAL				
12.	[Symbol]	INDIAN URINAL				
13.	[Symbol]	ABLUTION TRAP				
	[Symbol]	GATE VALVE				

OWNER SIGN

NORTH

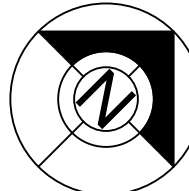

ARCHITECT/ENGINEER SIGN