


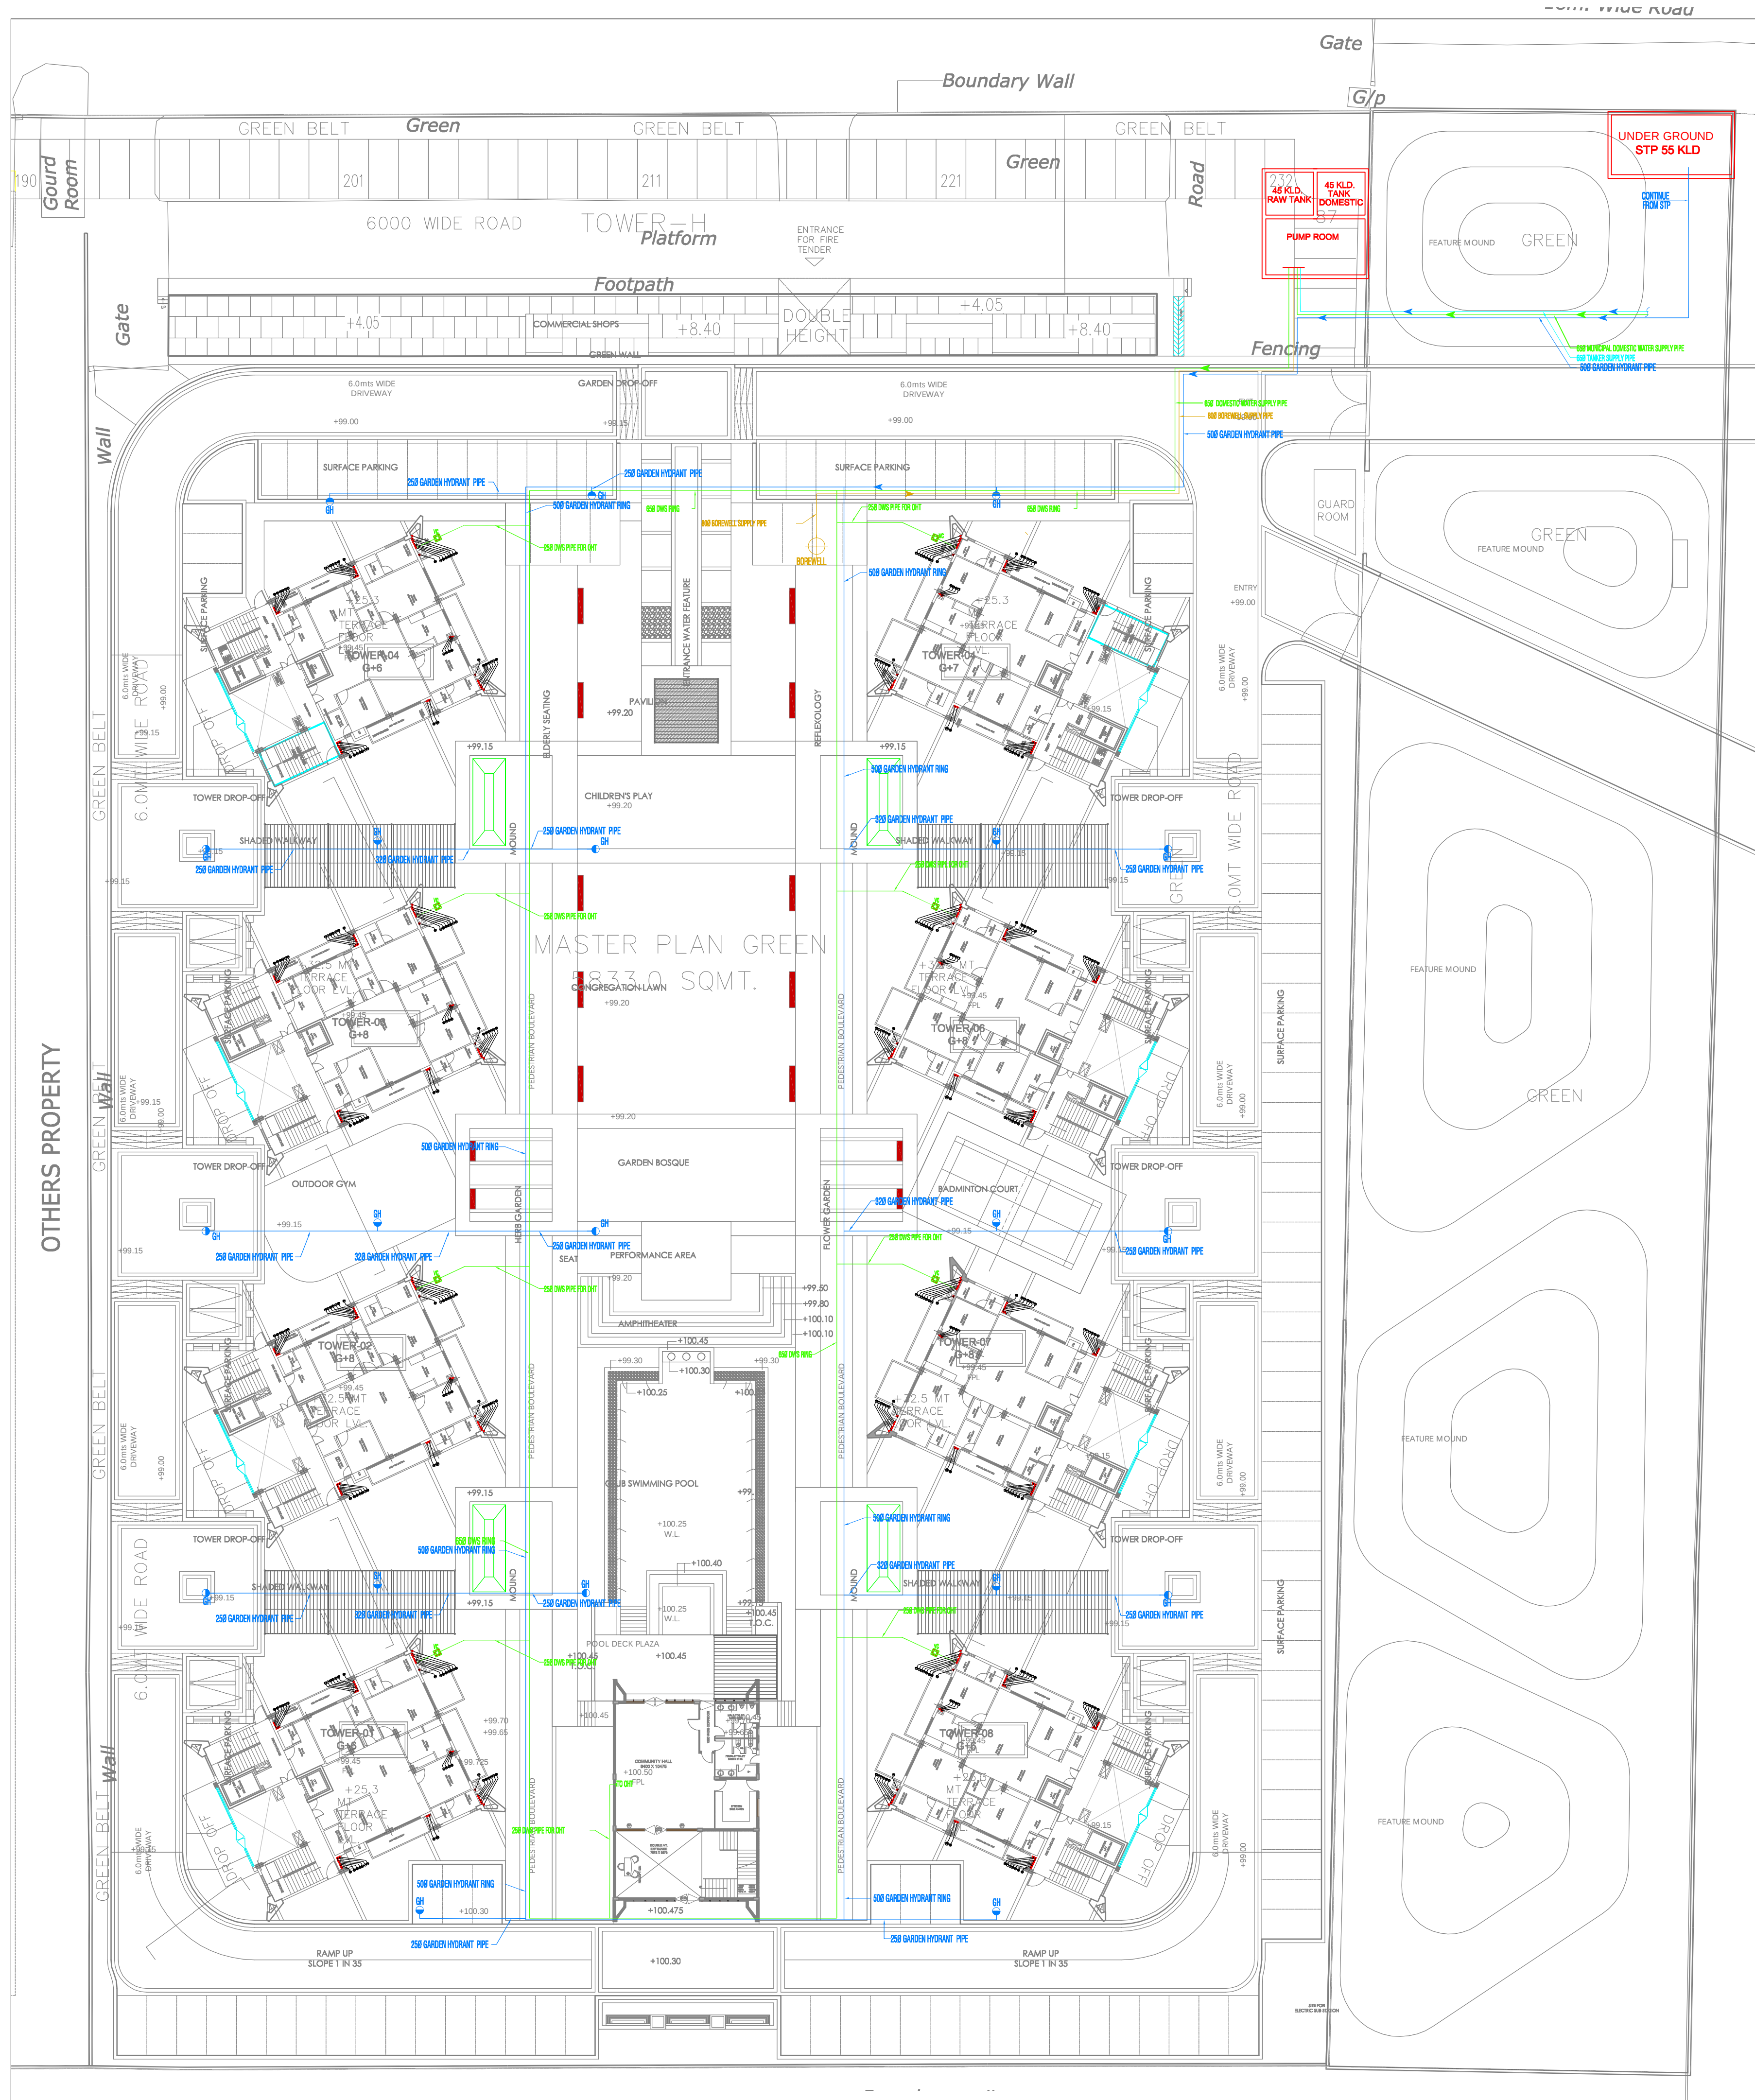

PLUMBING LEGEND :-	
①	1100 SOIL PIPE
②	1100 WASTE PIPE
③	750 VENT PIPE
④	DWS PIPE
⑤	HWS PIPE
⑥	HWR PIPE
⑦	DWS RISER PIPE
⑧	750 RAIN WATER PIPE
⑨	1000 RAIN WATER PIPE
⊠ P1	P1=150X150 MM CUT OUT
⊠ P2	P1=100X100 MM CUT OUT
	SOIL PIPE
	WASTE PIPE
	RAIN WATER PIPE
	FLOOR TRAP
	FLOOR DRAIN
	FLOOR GREETING
	WATER FLOW
DWS = DOMESTIC WATER SUPPLY	
DWR = DOMESTIC WATER RISER	
HWS = HOT WATER SUPPLY	
HWR = HOT WATER RETURN	

CLIENT
M/s AGARWAL ASSOCIATES PROMOTERS LTD.
10, NEW RAJDHANI ENCLAVE, VIKAS MARG
NEW DELHI-110092

MEP CONSULTANT:
MULTIPLE SERVICE CONSULTANT
**253/B, Rajpur Khurd Extension,
Chattarpur, New Delhi-110068.
Ph. no. -8920225677/8920228058
mscibc@gmail.com**

PROJECT- SUBMISSION DRAWINGS FOR
GROUP HOUSING AT PLOT NO GH-1
ADITYA WORLD CITY, INTEGRATED TOWNSHIP,
SHAHPUR-BAMHETA, GHAZIABAD, (U.P.)
KHASRA NO= 1910,1911,1912/2m,1912/1m,1915,
1916,1917,1918,1919,1920,1921,1922,
1930,1938,2285,2286m,2286m,2287
2288,2289,2295

SHEET TITLE
SITE PLAN
WATER SUPPLY LAYOUT

DEALT	SCALE 1:325	DRG. NO MSC/AWCIT/ESP/WS-03
CHECKED	DATE 28-01-2022	

ARCHITECT

DESIGN FORUM INTERNATIONAL
K-47, KAILASH COLONY, NEW DELHI-110048
PH. NO.- 011-46556600, FAX:- 011-46556601
www.designforuminternational.com