


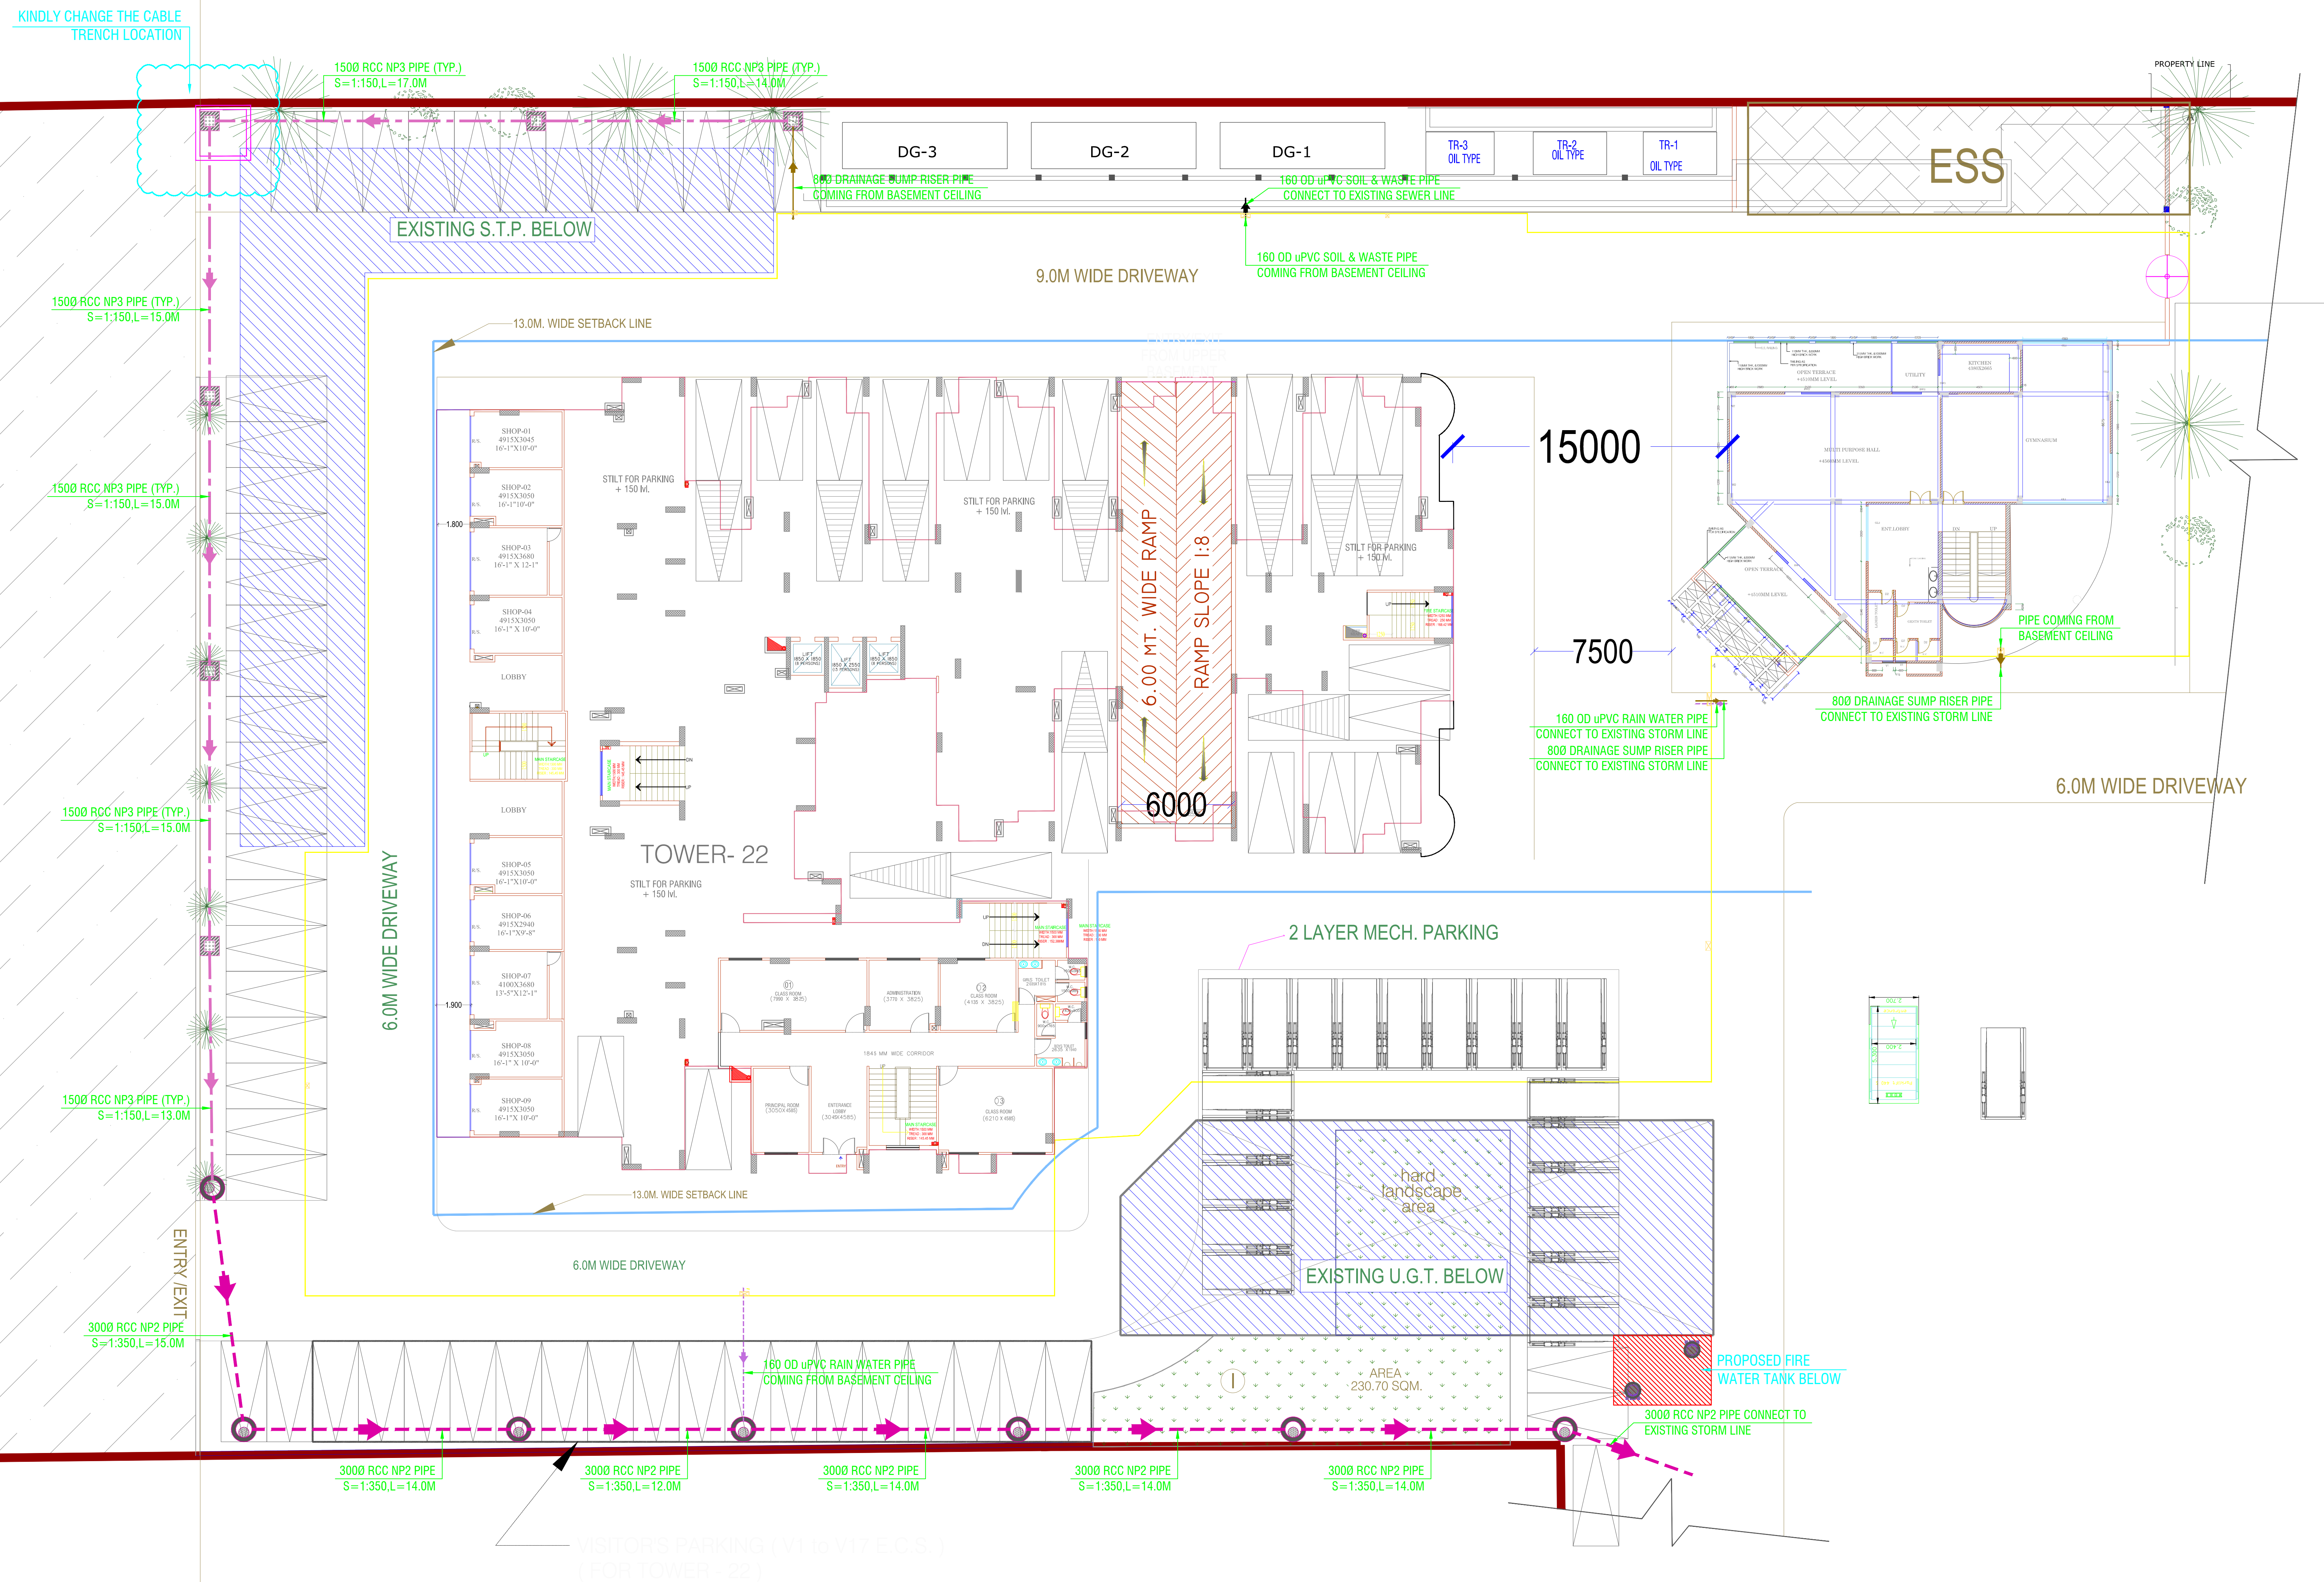

PLUMBING LEGEND:-	
	EXTERNAL STORM WATER LINE
	IRRIGATION WATER SUPPLY LINE
	EXTERNAL FIRE HYDRANT LINE
	STORM WATER MANHOLE WITH 5600 PERFORATED MANHOLE COVER.
(I)	910 DIA MANHOLE UPTO 1.67 M DEPTH
(II)	1220 DIA MANHOLE UPTO 2.29 M DEPTH
(III)	1520 DIA MANHOLE ABOVE 2.29 M DEPTH
	CATCH BASIN (600 x 600) MM
 EFH	EXTERNAL FIRE HYDRANT
 GH	GARDEN HYDRANT
G.L.	GROUND LEVEL
I.L.	INVERT LEVEL
C.L.	CONNECTION LEVEL
D.C.	DESILTING CHAMBER (1000 x 2000 MM DIA)
COP	CLEAN OUT PLUG
	VALVE WITH CHAMBER

ISSUES				
NO.	DATE	BY	DESCRIPTION	PRINTS
..		...		


[illegible]

TENDER DRAWING

PROJECT

PROPOSED GROUP HOUSING
(GULMOHUR GARDEN) AT KHASRA NO-
1133,1143,1139 VILLAGE NOOR NAGAR,
PARGANA LONI TEHSIL & DISTT.
GHAZIABAD (U.P.)

CLIENT
M/s S.V.P. BUILDERS INDIA LTD.

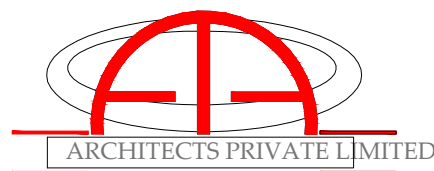

architects. engineers. landscape & interior designers
ANUJ AGARWAL ARCHITECTS P. LTD
 A - 244, Kaushambi
 (near angel Mega Mall), Ghaziabad
 Ph: +91 120 6454184
 Ph: +91 120 2691486
 e-mail : arch_anujagarwal@yahoo.co.in

PARADISE CONSULTANTS
Plot No. 96, Basement,
Near Living Style Mall, Jasola Vihar
Landline +91-11-29943601, 26943216
New Delhi - 110025
E-mail: paradiseconsultants@gmail.com
website: www.paradiseconsultants.com


TYPE : TOWER - 22 (B+G+13)

DRAWING TITLE :
**EXTERNAL SITE PLAN SEWER & STORM
WATER PLUMBING LAYOUT**

scale :	1:200 (A1)	drawn by :	MAN SINGH
date :	31.03.20	checked by :	ANIL
project no :	11-104	approved by :	NAFEES
drawing no :			

PL-PC-SVP-GG-T(22)-SITE-101

[illegible]

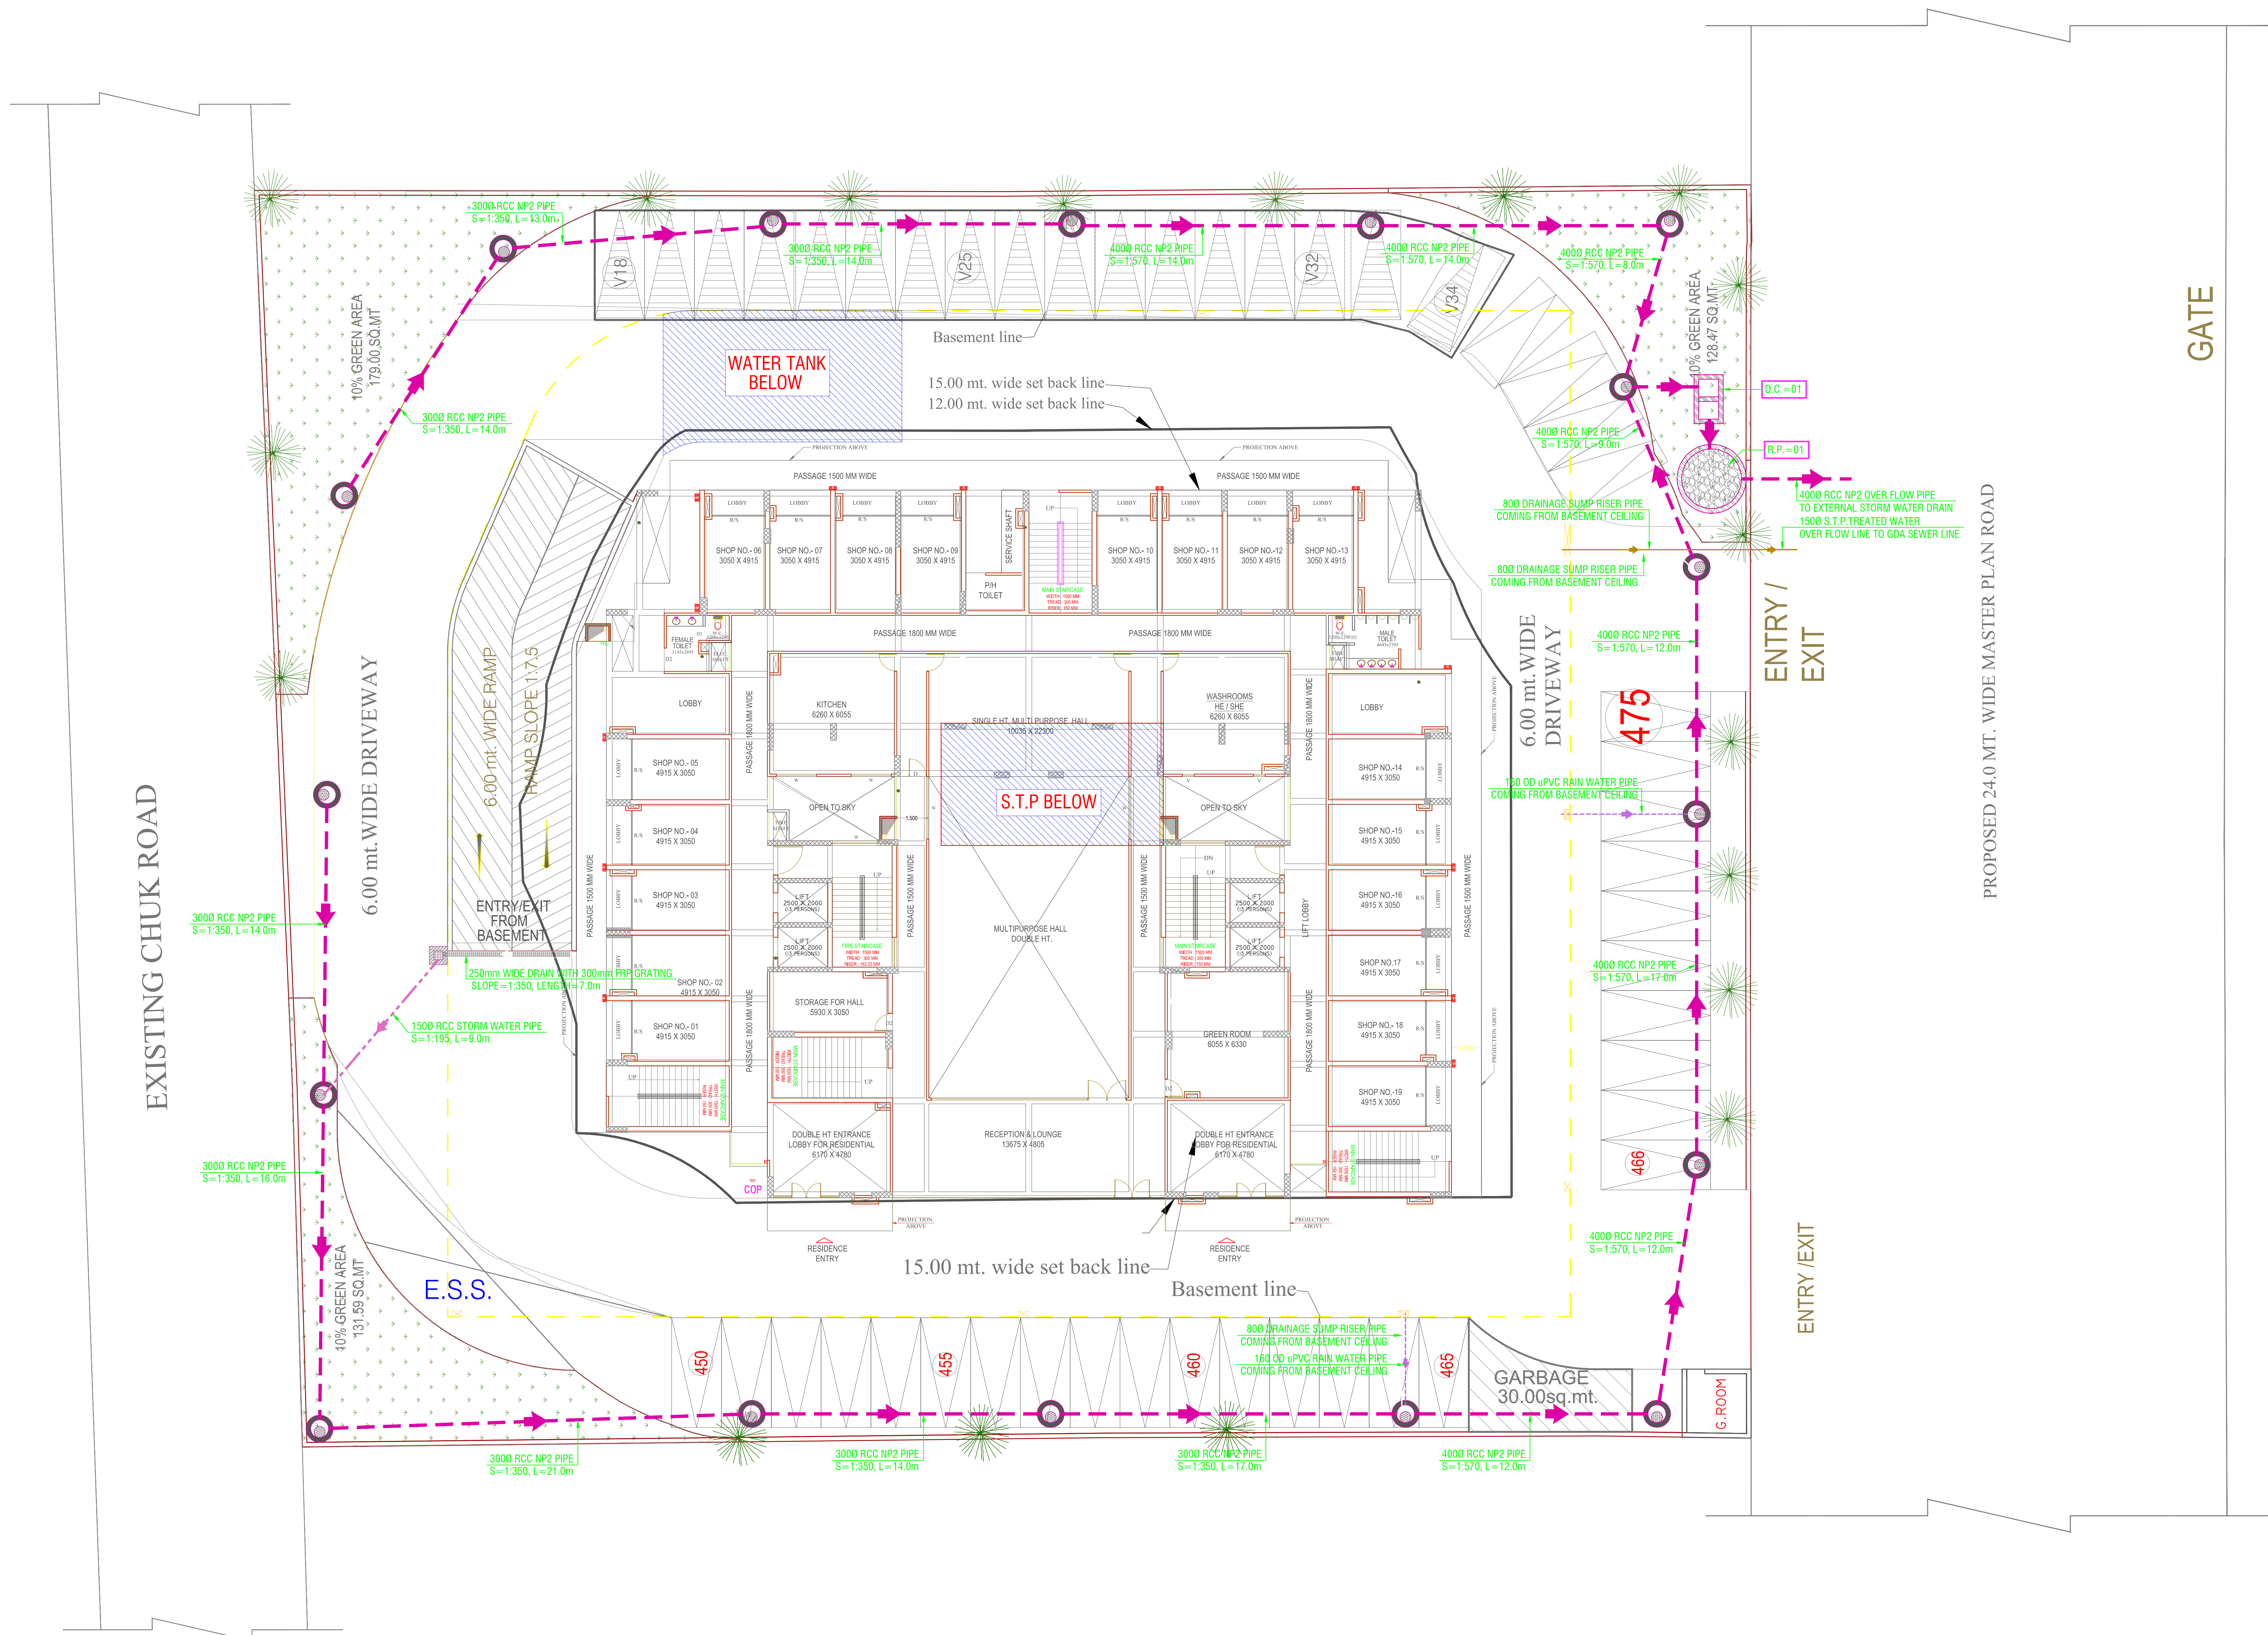

PLUMBING LEGEND:-	
	EXTERNAL STORM WATER LINE
	DOMESTIC WATER SUPPLY FILLING LINE FROM MUNICIPAL / TANKER LINE.
	IRRIGATION WATER SUPPLY LINE
	TUBE WELL WATER SUPPLY LINE
	EXTERNAL FIRE HYDRANT LINE
	STORM WATER MANHOLE WITH 5600 PERFORATED MANHOLE COVER.
(I)	910 DIA MANHOLE UPTO 1.67 M DEPTH
(II)	1220 DIA MANHOLE UPTO 2.29 M DEPTH
(III)	1520 DIA MANHOLE ABOVE 2.29 M DEPTH
	CATCH BASIN (600 x 600) MM
	EXTERNAL FIRE HYDRANT
	GARDEN HYDRANT
G.L.	GROUND LEVEL
I.L.	INVERT LEVEL
C.L. R.P.	CONNECTION LEVEL RECHARGE PIT (3000 MM DIA)
D.C.	DESILTING CHAMBER (1000 x 2000 MM DIA)
COP	CLEAN OUT PLUG
	VALVE WITH CHAMBER

ISSUES				
NO.	DATE	BY	DESCRIPTION	PRINTS
..	..	..	..	..

REVISIONS				
NO.	DATE	BY	DESCRIPTION	

TENDER DRAWING

PROJECT
PROPOSED GROUP HOUSING (GULMOHUR GARDEN) AT KHASRA NO-1133,1143,1139 VILLAGE NOOR NAGAR, PARGANA LONI TEHSIL & DISTT. GHAZIABAD (U.P.)

CLIENT
M/s S.V.P. BUILDERS INDIA LTD.

ARCHITECTS :

ANUJ AGARWAL ARCHITECTS P. LTD.
A - 244, Kaushambi
(near angel Mega Mall), Ghaziabad
Ph: +91 120 6454184
Ph: +91 120 2691486
e-mail : arch_anujagarwal@yahoo.co.in

SERVICES CONSULTANTS:
PARADISE CONSULTANTS
Plot No. 103, Basement,
Near Living Style Mall, Jasola Vihar
Landline : +91-11-29943601, 26943216
New Delhi - 110025
E-mail: paradiseconsultants@gmail.com
website: www.paradiseconsultants.com

TYPE :	TOWER - 25 (B + G + 17)		
DRAWING TITLE :	SITE PLAN STORM WATER PLUMBING LAYOUT		
scale :	1:150 (A1)	drawn by :	MAN SINGH
date :	03.03.20	checked by :	ANIL
project no :	11-104	approved by :	NAFEES
drawing no :	PL-PC-SVP-GG-SITE-T(25)-101		
REVISION	RO		