


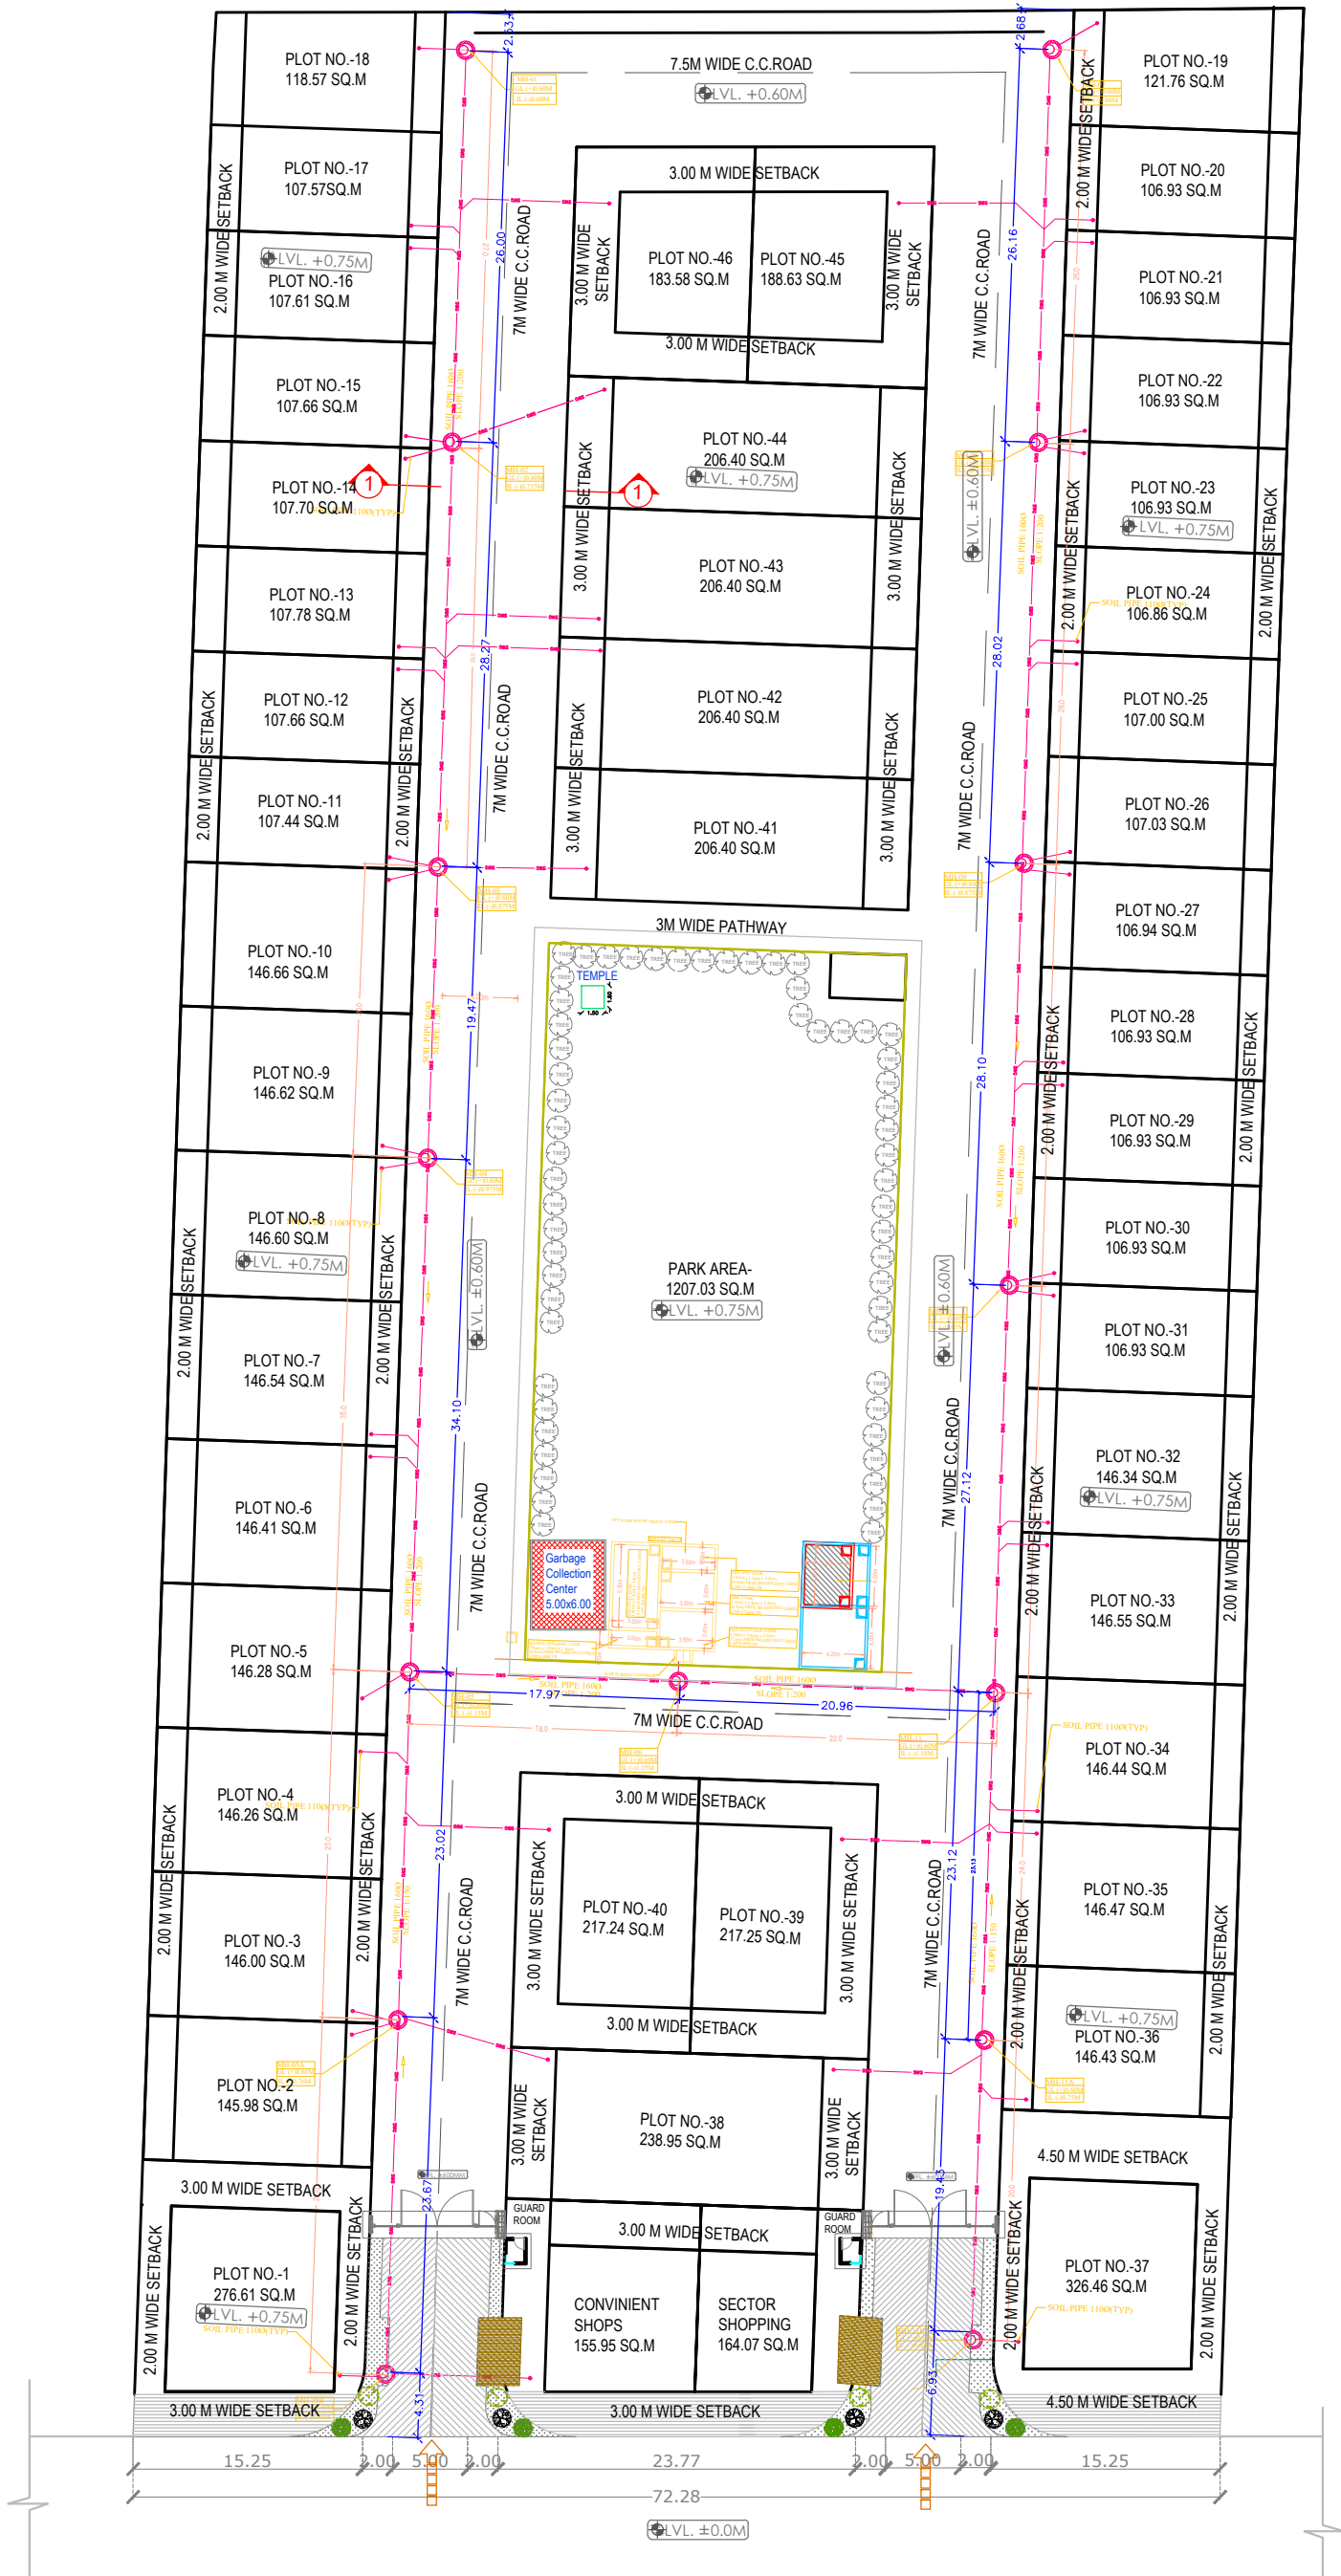

LEGEND		
1.	IL	INVERT LEVEL
2.	GL	GROUND LEVEL
3.		450 X 450MM VALVE CHAMBER
4.		HIGH TENSION WIRE
5.		LOW TENSION WIRE
6.		TELEPHONE CABLE
7.		150Ø ECODRAIN PIPE
8.		TREATED WATER SUPPLY PIPE LINE
9.		1200Ø DIA MANHOLE CHAMBER
10.		600X700MM ELECTRIC CHAMBER
11.		RAIN-WATER SOAK PIT
12.		STREET LIGHT
13.		RAIN WATER DRAIN
14.		GARBAGE COLLECTION CENTER

ARCHITECTURE CONSULTANT	
Drawn By	SONAL GUPTA
Checked By	AR. ANKUR CHHABRA / AR. PREETI BHATNAGAR
Drawing Status	IN PROCESS

PROJECT TITLE
GROUP HOUSING

CLIENT NAME	DWG. REFERENCE	DRAWING NUMBER	REV
MR.	SS-104	12	ORIENTATION
DRAWING TITLE			
SITE PLAN DRAINAGE LAYOUT			
DATE	SCALE	UNIT	STATUS
26.07.2021	1:100	MILLIMETERS	IN PROCESS