
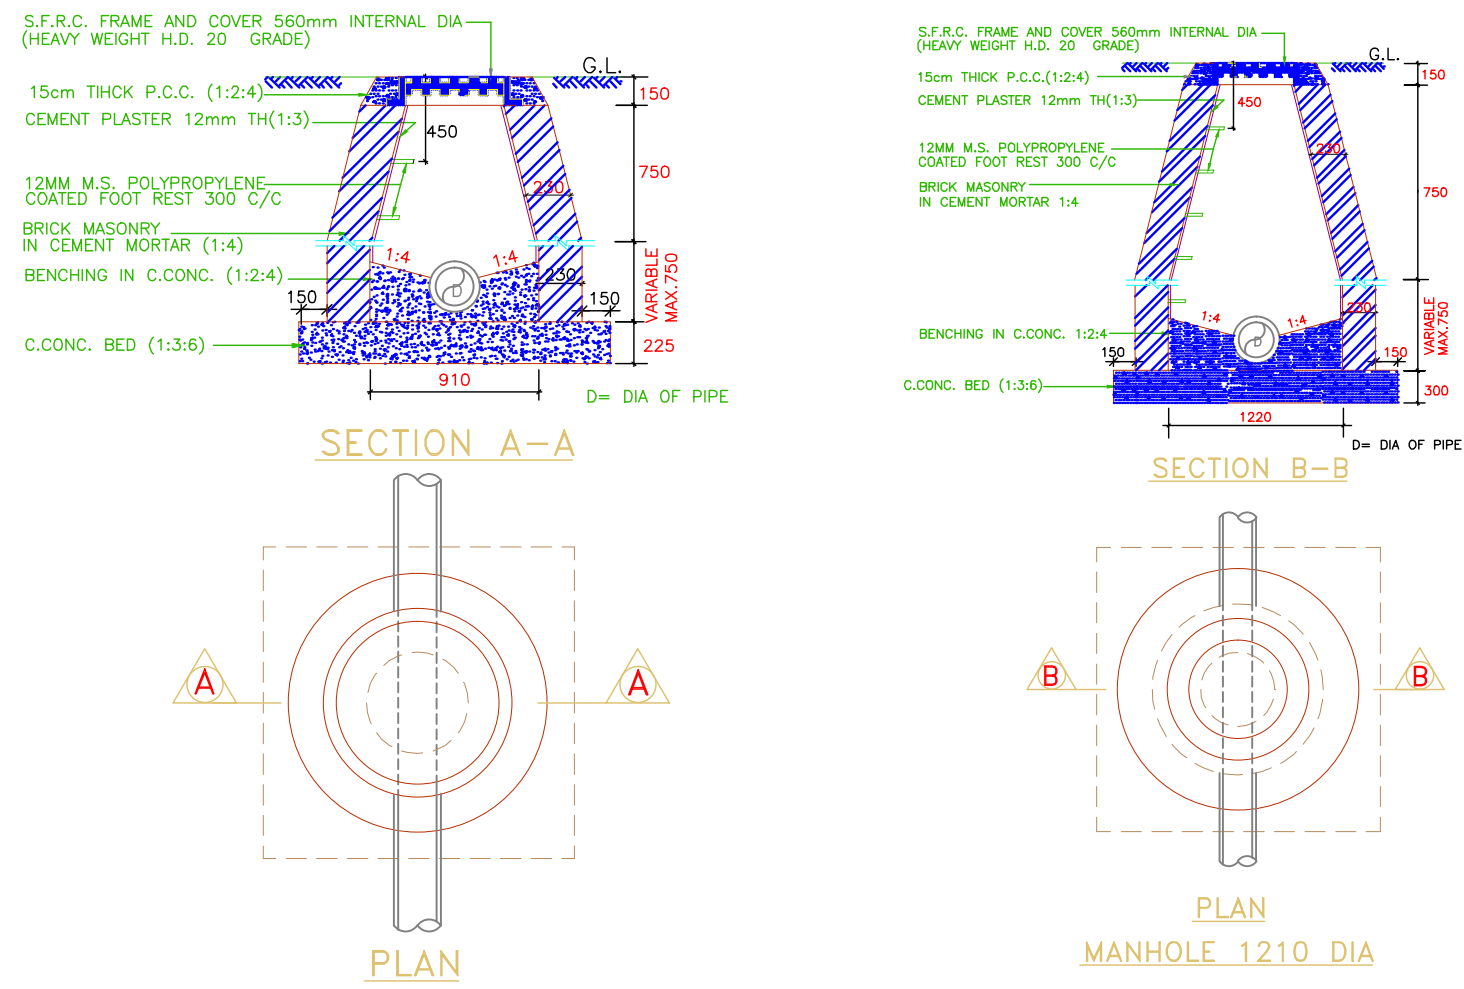


SERVICES PLAN

STANDARD MANHOLE SIZE & DEPTH	
MANHOLE SIZE	DEPTH
MH-900x800MM	0.6M-0.9M
MH-910Ø	0.9M-1.65M
MH-1220Ø	1.65M-2.3M
MH-1520Ø	ABOVE-2.3M

PLUMBING LEGEND:	
	RAIN WATER HARVESTING
	SPACE FOR SOLAR PANEL

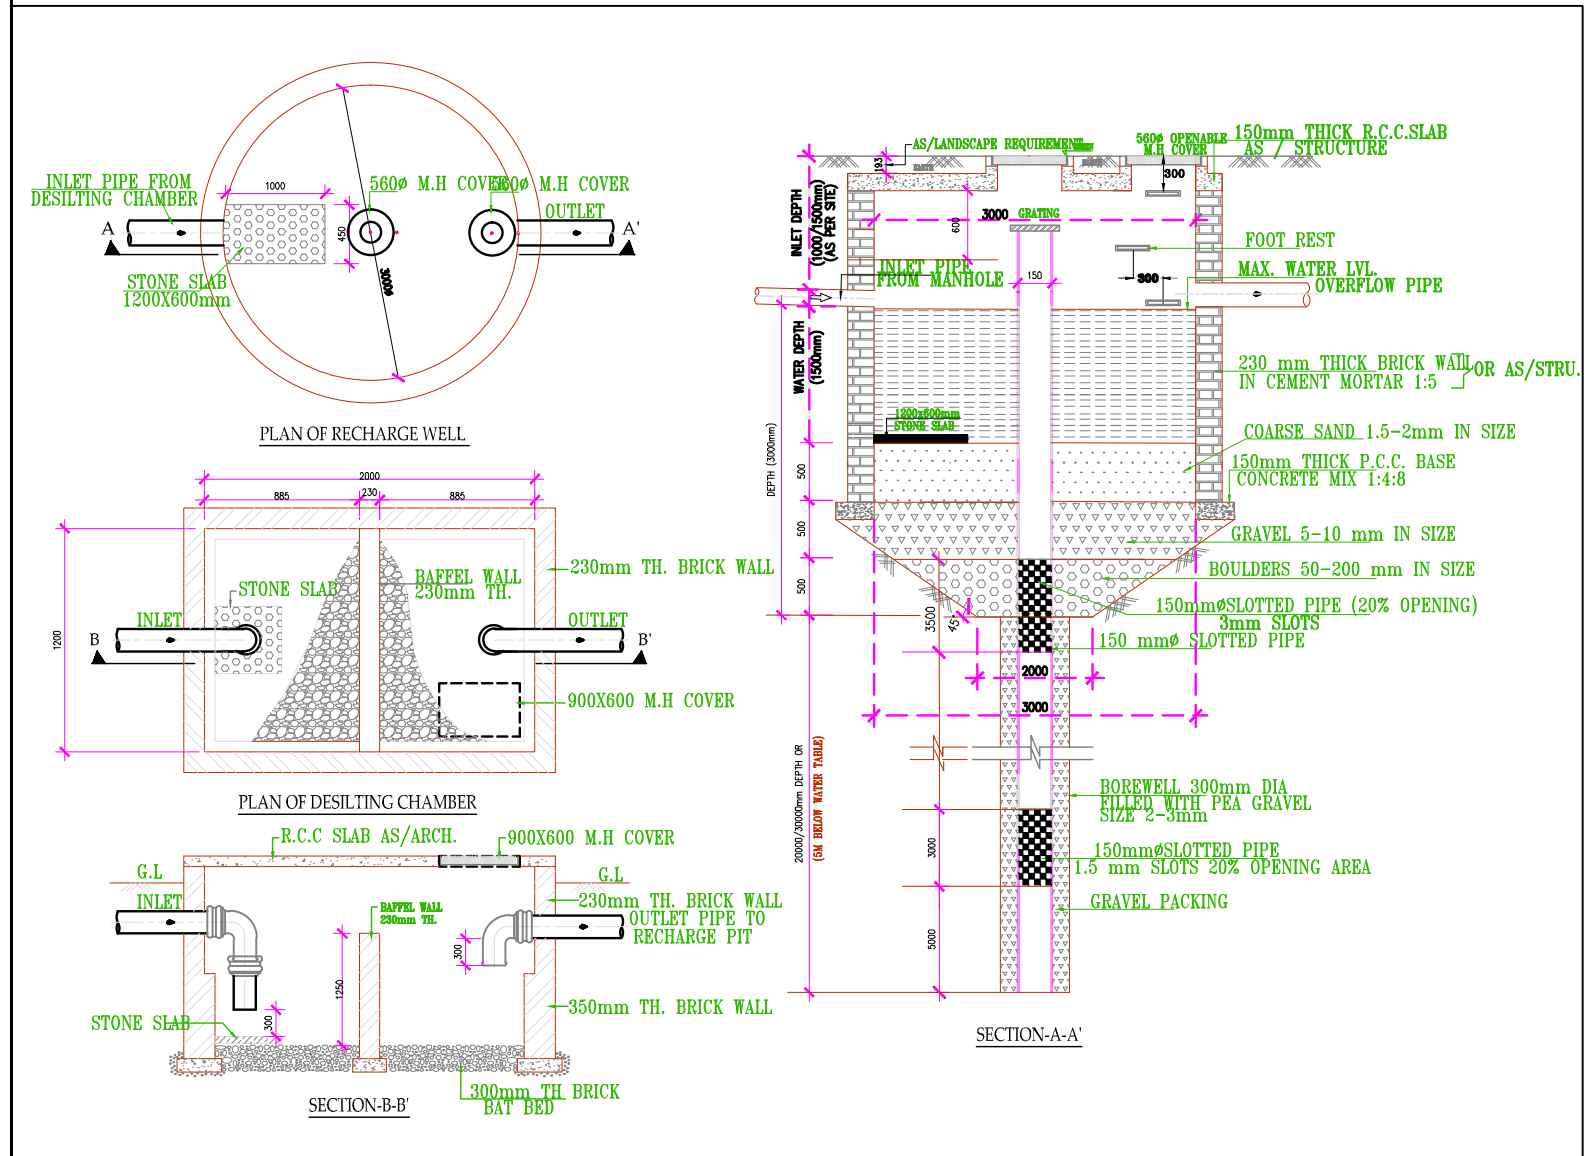

LEGEND

SYMBOL	DESCRIPTION
	EXTERNAL SEWER LINE
	EXTERNAL STORM LINE
	80Ø GARDEN HYDRANT SUPPLY LINE
	DOMESTIC WATER SUPPLY LINE
	EXTERNAL SEWER LINE MANHOLE
	EXTERNAL STORM LINE MANHOLE
	FIRE HYDRANT (80Ø TO FH)
	GARDEN HYDRANT (25Ø TO GH)

PROJECT: DRAWING FOR THE GROUP HOUSING AT KHASRA NO. 1726 M/1, 1725 M/2, 1724 M, 1056M, 1060/1 AT VILLAGE PASONDA, PARGANA LONI DISTT. GZB.	
PROJECT NAME: NIPUN SAFFRON VALLEY OWNER: M/s. NIPUN BUILDERS & DEVELOPERS (P) LTD. DIRECTOR: MR. RAKESH SINGLA	
DRAWING TITLE: SERVICES PLAN (SEWER, DRAINAGE, WATER HARVESTING, SOLAR, FIRE FIGHTING, WATER SUPPLY)	
OWNER'S SIGN	ARCHITECT'S SIGN
ARCHITECT: ANUJ AGARWAL ARCHITECTS OFFICE: A-244 KAUSHAMBI GHAZIABAD (U.P.) Ph-0120-6454182, 4165716, TEL. FAX- 2773592 e-mail: arch.anujagarwal@gmail.com	
SCALE: DESIGN BY	DATE: CHECKED BY DG-01