


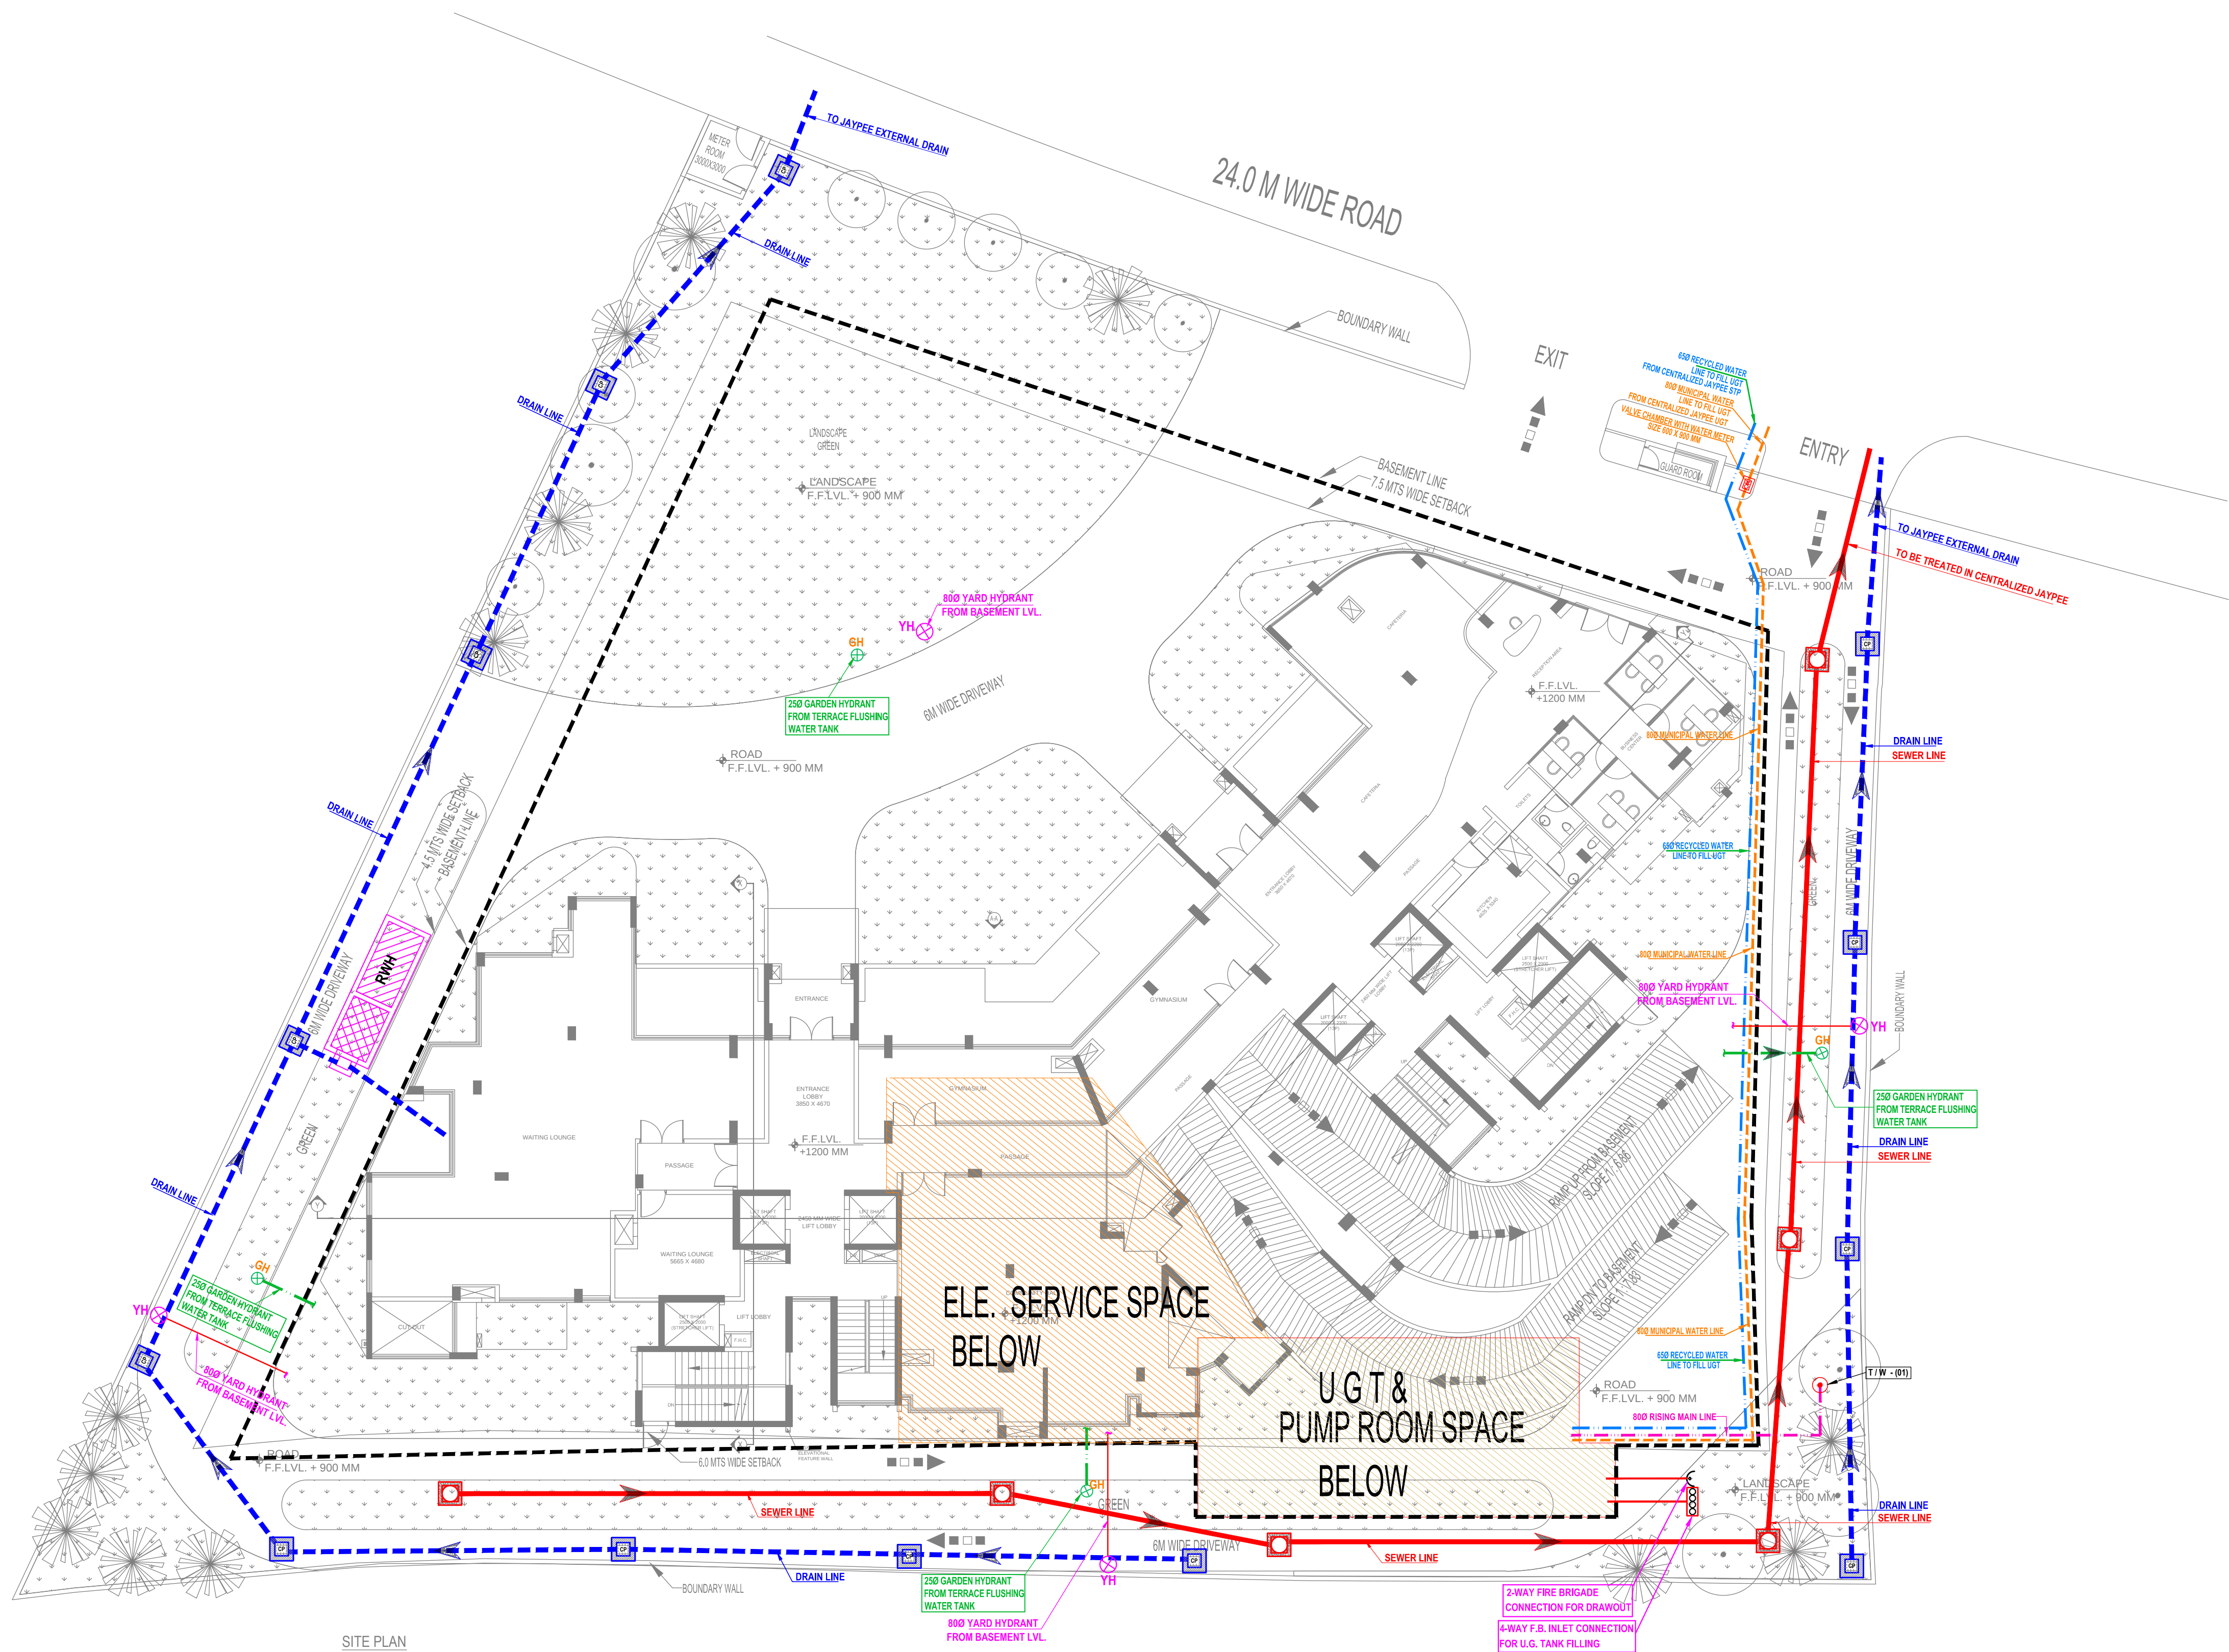

LEGEND :		
S. No.	SYMBOL	DESCRIPTION
1.	M.H.	MANHOLE
2.		SEWER LINE
3.		BYPASS SEWER LINE
4.		CATCH PIT
5.		UNDER GROUND DRAIN
6.		RAIN WATER HARVESTING
7.		RECYCLED WATER SUPPLY PIPE LINE.
8.		RISING MAIN WATER PIPE LINE.
9.		MUNICIPAL WATER SUPPLY PIPE LINE.
10.		ISOLATING VALVE
11.		PROPOSED TUBE WELL
12.		BASEMENT LINE
13.	GH	GARDEN HYDRANT

LEGEND : FIRE SYSTEM		
S. No.	SYMBOL	DESCRIPTION
1.		FIRE LINE
2.	YH	YARD HYDRANT 63 M.M. DIA. SINGLE HEADED HYDRANT VALVE WITH 2 NOS. 15 M. LONG, 63 M.M. DIA. FIRE HOSE PIPE & 1 NO. BRANCH PIPE WITH NOZZLE
3.		FIRE BRIGADE CONNECTION
4.		BUTTERFLY VALVE
5.		NONRETURN VALVE (CHECK VALVE)
6.		ISOLATING VALVE WITH MASONARY CHAMBER

R-00	12.01.2022	FOR RERA SUBMISSION
Rev. no.	Date	Revision

Project
PAGE THREE, GROUP HOUSING
AT RESIDENTIAL POCKET B-56,
SECTOR-128, NOIDA (U.P.)

Title
SITE PLAN

Subtitle
EXTERNAL COMBINED SERVICES

Drawing released for
☐ APPROVAL ☒ SUBMISSION
☐ ADVANCE COPY ☐ CONSTRUCTION

Drg. no. **PAGE THREE / EX / S-05** Drawn by **Kulwant**

Scale **1 : 170** Designed by **R.K.**

Date **Jan. 2022** Checked by **Anand Havelia**

Architects
Confluence
B-421, NTC, N.D-65, NOIDA
architecture urban design interiors
Ph: +91-11-29216006
Pb: +91-11-40564768
www.inconfluence.com
ISO - 9001 : 2008

Services Consultant
Consummate Engineering Services (P) Ltd.
Noida Office : B - 57, Sector - 67, Noida - 201 301
Tel : (0120)6943500 (23 Lines)
Lko. Office : R 006, Rohtas Plumeria, Gomti Nagar, Lucknow
e mail : mail@cespl.in, website : www.cespl.in