

P/O OTHER'S

NO	DESCRIPTION	SYMBOL	FROM FTL
1	CILING FAN		CILING
2	EXHAUST		6'-0"
3	WALL FAN POINT		6'-0"
4	A.C POINT(WINDOW AC)		1'-0"
5	A.C POINT(SPLIT AC)		AS PER SITE
6	PHONE POINT		AS PER SITE
7	A.C SOCKET		AS PER SITE
8	5 AMP POWER PLUG POINT(GENERAL)		1'-0"
9	GYSEK SOCKET 16 AMP		6'-0"
10	5 AMP POWER PLUG POINT(SIDE)		AS PER SITE
11	5 AMP SOCKET		AS PER SITE
12	5 AMP PLUG POINT (BED SIDE)		2'-0"
13	5 AMP SOCKET (CORNER)		7'-0"
14	5 AMP SOCKET		AS PER SITE
15	250V AMP POWER PLUG POINT (FRUIT)		1'-0"
16	3 NOS 5 AMP SOCKET		1'-0"
17	5 AMP PLUG POINT GENERAL		1'-0"
18	NOTIF LAMP		1'-0"
19	KEY TAG		4'-0"
20	INVERTOR SOCKET		1'-0"
21	SWITCH BOARD WITH OUTLET 16 AMP POINT		4'-0"
22	SWITCH BOARD WITH IN AMP POINT		4'-0"
23	BULB H		4'-0"
24	GYSEK SWITCH 16 AMP		4'-0"
25	PROJECTOR POINT		3'-0"
26	TELEPHONE POINT(BED)		2'-0"
27	TELEPHONE POINT GENERAL		1'-0"
28	TV POINT GENERAL		2'-0"
29	LAN POINT		2'-0"
30	CILING LIGHT 2X2		CILING
31	CILING LIGHT		CILING
32	CHANDLER		CILING
33	40W TUBE LIGHT ON CILING		CILING
34	BULB HOLDER ON SIDE WALL		7'-3"
35	TUBE LIGHT ON WALL		7'-3"
36	BULB HEAD		2'-0"
37	DISTRIBUTION BOX		5'-0"
38	BELL		7'-3"
39	CONDUIT CIRCUIT (25MM)		CILING
40	CONDUIT POINT WIRING (25MM)		CILING
41	CONDUIT FOR MAIN WIRING (25MM)		CILING

12.19M WIDE EXISTING ROAD




P/O OTHER'S  
**SITE PLAN**

**GROUND FLOOR PLAN**

For Shanti Lal Nirman Pvt. Ltd.  
*Anshu Mittal*  
Director

*Ashok Mishra*  
ASHOK MISHRA Ph. 2229771  
B.Arch., M.C.A.  
C.A./91/13916  
95, Shivaji Nagar, Civil Lines  
JAIPUR

<b>GENERAL NOTES :-</b> 1. All dimensions are in feet and inches. 2. Do not scale this drawing follow written dimensions only. 3. This drawing shall be read in conjunction with other architectural, structural and services drawings. 4. Any discrepancy in the drawing should be immediately brought to the notice of architect prior to construction.	5. Architectural Drawings should be followed for the Location of structural and masonry members however size & reinforcement shall be followed as structural or other relevant drawings. 6. Coordination with other services drawings such as electrical, hvac, plumbing etc. is the sole responsibility of the contractor. 7. For details follow large scale detailed drawings. 8. All drawings/measurements must be checked & verified by the contractor at site.	9. Architect's responsibility is limited to the soundness of its design only. 10. Bad workmanship will be sole responsibility of client & contractor.  <b>WARNING :-</b> 1. This drawing is the sole copyright of Architects Mishra Garg & Associates and should be used for the purpose expressly issued.	<b>DRAWING TITLE</b>  <b>GROUND FLOOR ELECTRICAL PLAN</b>	<b>PROJECT TITLE</b>  <b>RESIDENTIAL APARTMENT "ORCHID BOUNTY" AT FIROZABAD</b>	<b>ARCHITECTS :</b>  <b>SHRESTHA ARCH GROUP</b> ENGINEERS & INTERIOR DESIGNER JAIN NAGAR, FIROZABAD MOB. : 8267832492	<b>MISHRA GARG &amp; ASSOCIATES</b> ARCHITECTS, PLANNERS & INTERIOR DESIGNER C-25 LAPOUT, MARLE C-SOCHE, JAIPUR TEL. : (0141) 2373274 Email-id : mishra.garg@gmail.com												
			<table border="1"> <tr> <td>DESIGN BY</td> <td>PROJECT</td> <td>DATE</td> <td rowspan="3">NORTH</td> </tr> <tr> <td>CHECKED</td> <td>ARCHITECT</td> <td></td> </tr> <tr> <td>ASHOK MISHRA</td> <td>JITENDRA</td> <td>05-05-2024</td> </tr> <tr> <td>SCALE</td> <td>JOB NO.</td> <td>DRG. NO.</td> <td></td> </tr> <tr> <td>N.T.S</td> <td></td> <td>3101</td> <td></td> </tr> </table>	DESIGN BY	PROJECT	DATE	NORTH	CHECKED	ARCHITECT		ASHOK MISHRA	JITENDRA	05-05-2024	SCALE	JOB NO.	DRG. NO.		N.T.S
DESIGN BY	PROJECT	DATE	NORTH															
CHECKED	ARCHITECT																	
ASHOK MISHRA	JITENDRA	05-05-2024																
SCALE	JOB NO.	DRG. NO.																
N.T.S		3101																

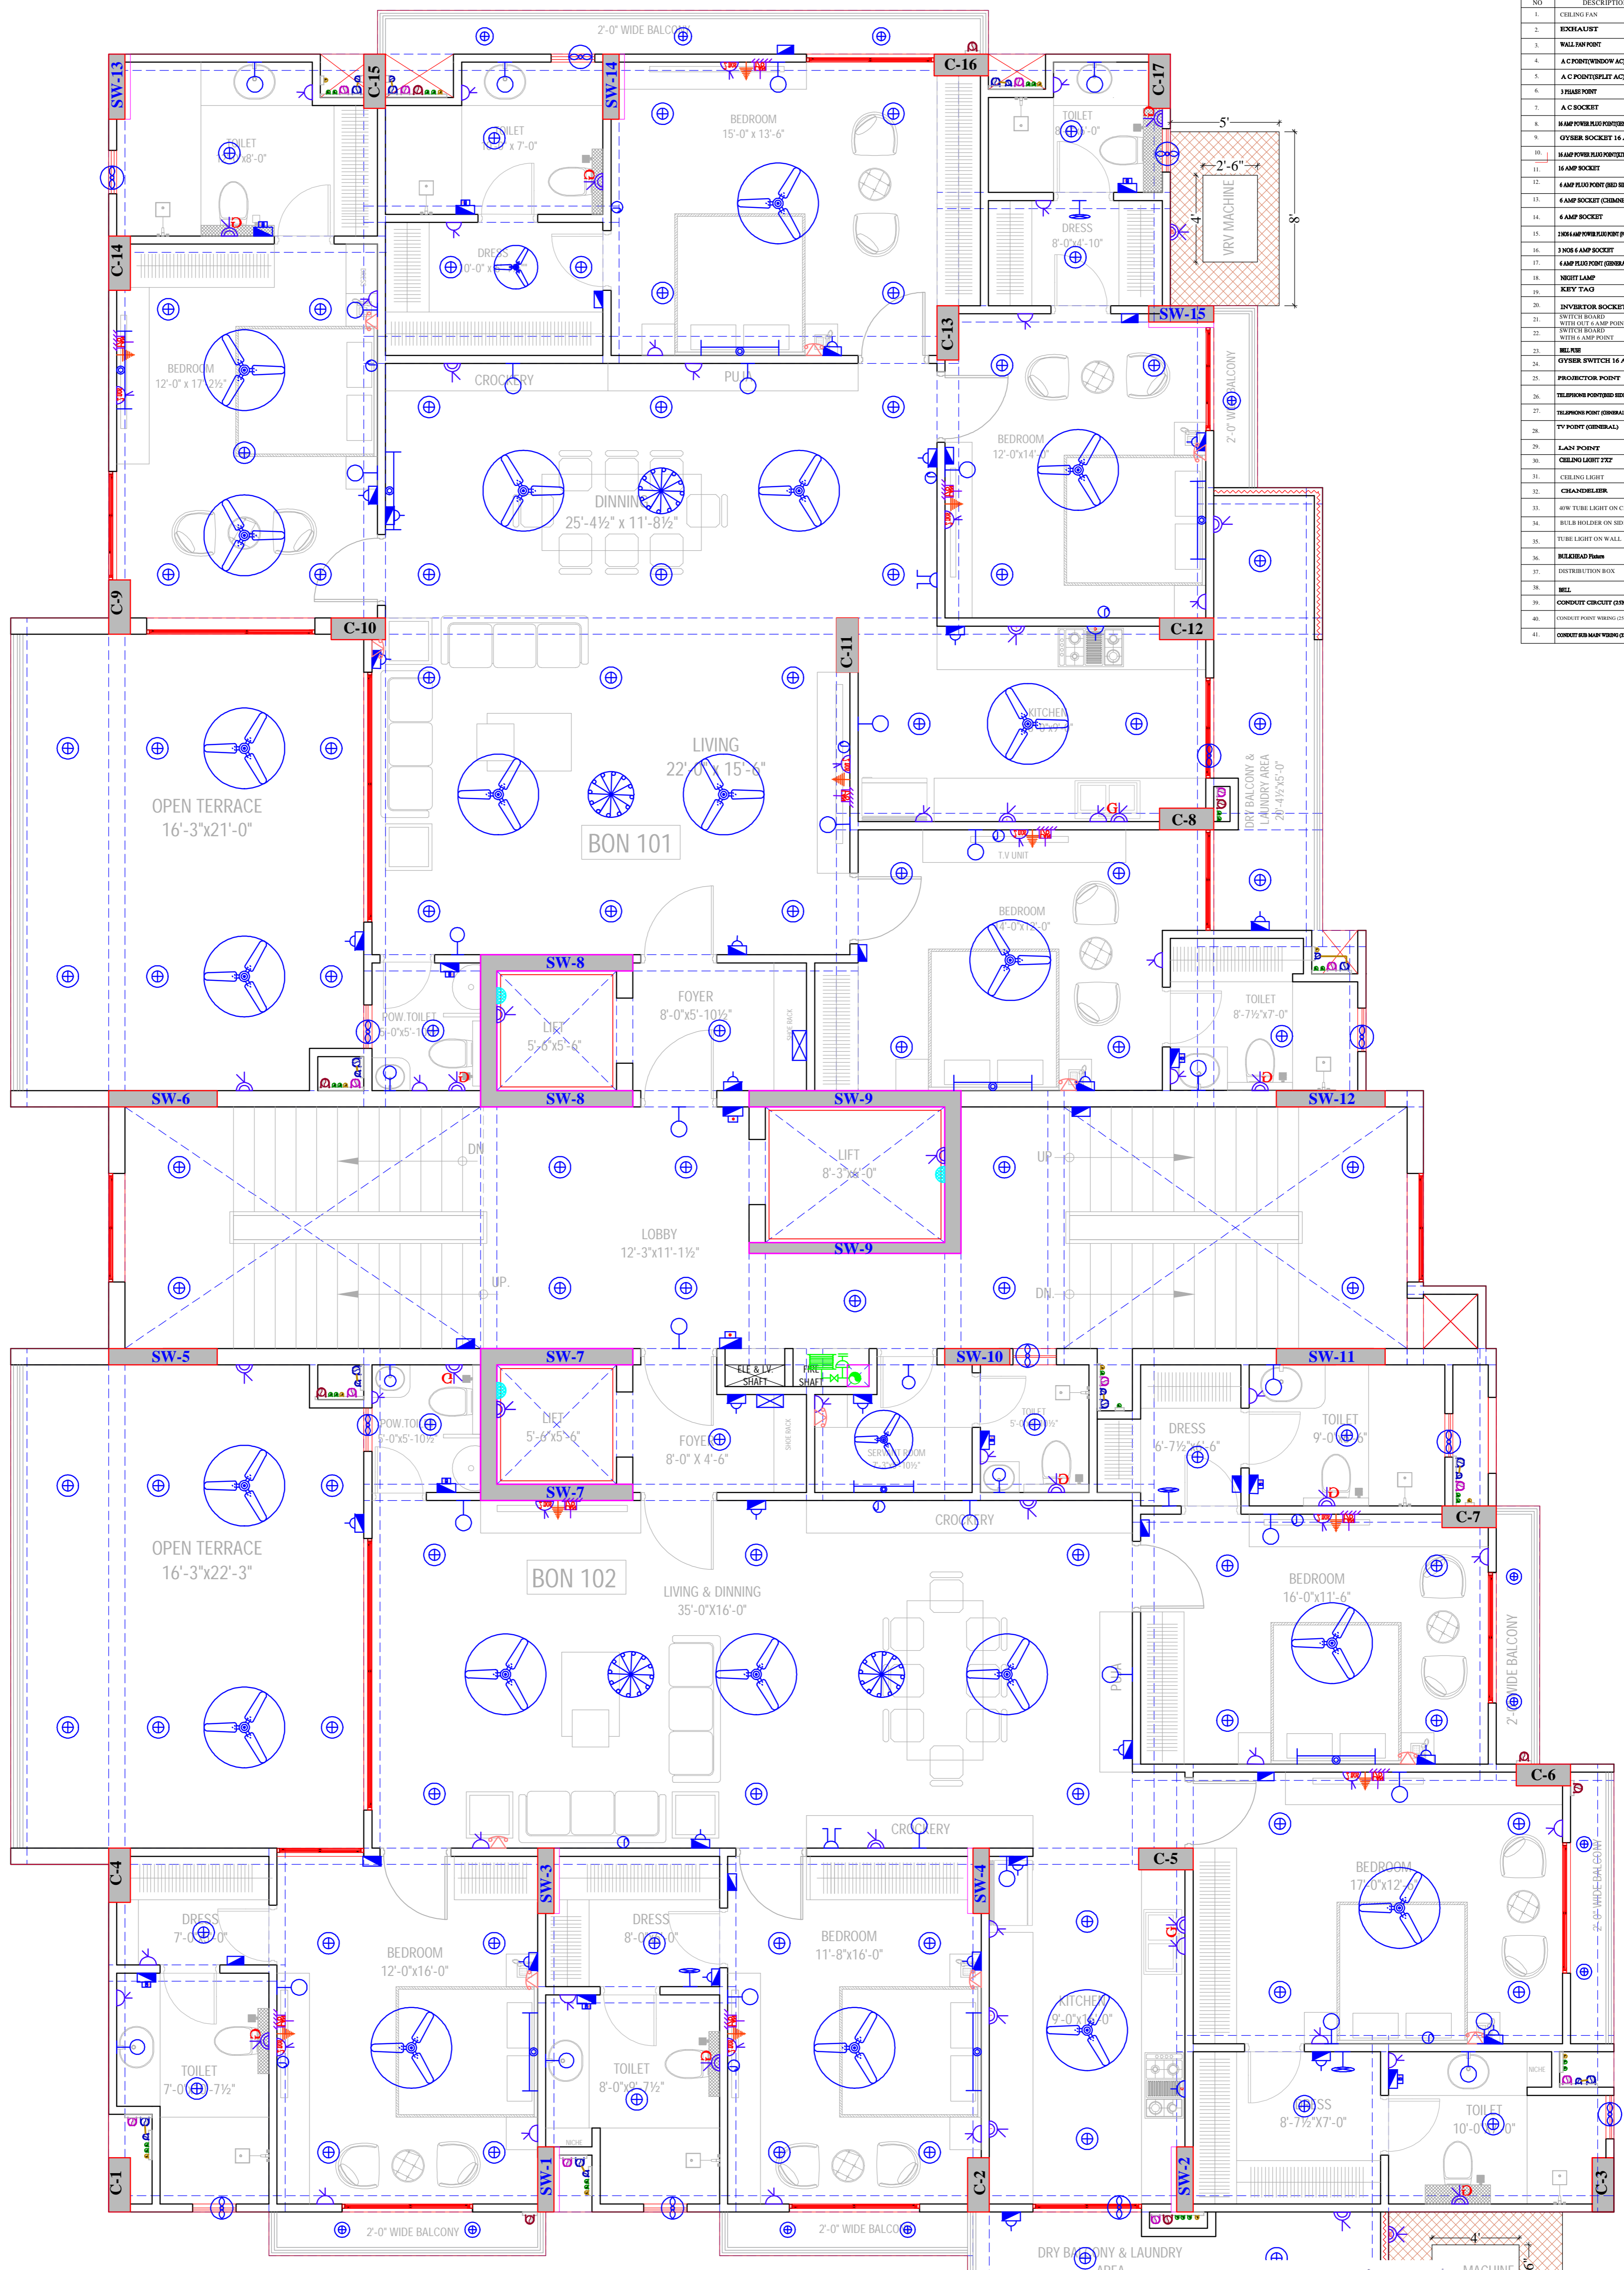


NO	DESCRIPTION	SYMBOL	FROM PFL
1	CILING FAN	(Symbol)	CILING
2	RECALUFT	(Symbol)	6'-0"
3	WALL POINT	(Symbol)	6'-0"
4	A.C POINT (WINDOW AC)	(Symbol)	1'-0"
5	A.C POINT (WALL AC)	(Symbol)	ASB ETR
6	3 PHASE POINT	(Symbol)	ASB ETR
7	A.C SOCKET	(Symbol)	ASB ETR
8	1/2 AMP POINT (GENERAL)	(Symbol)	1'-0"
9	1/2 AMP POINT (16 AMP)	(Symbol)	6'-0"
10	1/2 AMP POINT (KITCHEN)	(Symbol)	ASB ETR
11	1/2 AMP POINT	(Symbol)	ASB ETR
12	1/2 AMP POINT (BED ROOM)	(Symbol)	2'-6"
13	1/2 AMP POINT (CLOSET)	(Symbol)	7'-0"
14	1/2 AMP POINT	(Symbol)	ASB ETR
15	1/2 AMP POINT (BATHROOM)	(Symbol)	1'-0"
16	3/4 AMP POINT	(Symbol)	1'-0"
17	1/2 AMP POINT (GENERAL)	(Symbol)	1'-0"
18	1/2 AMP POINT	(Symbol)	1'-0"
19	KEY TAG	(Symbol)	4'-0"
20	INVERTOR SOCKET	(Symbol)	1'-0"
21	SWITCH BOARD WITH FUSE & AMP POINT	(Symbol)	4'-0"
22	SWITCH BOARD WITH AMP POINT	(Symbol)	4'-0"
23	BELLS	(Symbol)	4'-0"
24	OYBER SWITCH 16 AMP	(Symbol)	4'-0"
25	PROTECTOR POINT	(Symbol)	3'-0"
26	TELEPHONE POINT (BED)	(Symbol)	2'-6"
27	TELEPHONE POINT (GENERAL)	(Symbol)	1'-0"
28	TV POINT (GENERAL)	(Symbol)	2'-6"
29	LAMP POINT	(Symbol)	2'-6"
30	CILING LIGHT TFF	(Symbol)	CILING
31	CILING LIGHT	(Symbol)	CILING
32	CHANDLER	(Symbol)	CILING
33	40W TUBE LIGHT ON CILING	(Symbol)	CILING
34	BULB HOLDER ON SIDE WALL	(Symbol)	7'-3"
35	TUBE LIGHT ON WALL	(Symbol)	7'-3"
36	RELEASD FAN	(Symbol)	2'-6"
37	DISTRIBUTION BOX	(Symbol)	5'-0"
38	BELL	(Symbol)	7'-3"
39	CORRECT CIRCUIT (GND)	(Symbol)	CILING
40	CORRECT POINT WIRING (GND)	(Symbol)	CILING
41	CORRECT FOR WIRE WIRING (GND)	(Symbol)	CILING

**TYPICAL FLOOR PLAN**  
**1st To 9th FLOOR PLAN**

<b>GENERAL NOTES :-</b> 1. All dimensions are in feet and inches. 2. Do not scale this drawing follow written dimensions only. 3. This drawing shall be read in conjunction with other architectural, structural and services drawings. 4. Any discrepancy in the drawing should be immediately brought to the notice of architect prior to construction. 5. Architectural Drawings should be followed for the location of structural and masonry members however size & reinforcement shall be followed as structural or other relevant drawings. 6. Coordination with other services drawings such as electrical, HVAC, plumbing etc. is the sole responsibility of the contractor. 7. For details follow large scale detailed drawings. 8. All drawings/measurements must be checked & verified by the contractor at site.	<b>WARNING :-</b> 1. This drawing is the sole copyright of Architects Mishra Garg & Associates and should be used for the purpose expressly issued.	<b>9.</b> Architect's responsibility is limited to the soundness of its design only. <b>10.</b> Bad workmanship will be sole responsibility of client & contractor.	<b>DRAWING TITLE</b>  <b>TYPICAL FLOOR</b> <b>1st To 9th FLOOR</b> <b>ELECTRICAL PLAN</b>	<b>PROJECT TITLE</b>  <b>RESIDENTIAL</b> <b>APARTMENT</b> <b>"ORCHID BOUNTY"</b> <b>AT FIROZABAD</b>	<b>ARCHITECTS :</b>  <b>SHRESTHA ARCH GROUP</b> <b>ENGINEERS &amp; INTERIOR DESIGNER</b> <b>JAIN NAGAR, FIROZABAD</b> <b>MOB. : 8267832492</b>	<b>MSHRA GARG &amp; ASSOCIATES</b> <b>ARCHITECTS, PLANNERS &amp; INTERIOR DESIGNER</b> <b>C-35, LAJPAT MARG, G-5 SCHEME, JAINPUR</b> <b>TEL. (0143) 2212474</b> <b>Email id : mshra.garg@gmail.com</b>
			<b>DESIGN BY / CHECKED</b> ASHOK MISHRA RAJEEV GARG SCALE N.T.S	<b>PROJECT ARCHITECT</b> JIENDRA <b>JOB NO.</b> DRG. NO.	<b>DATE</b> 05-03-2024 <b>DRG. NO.</b> 3.102	<b>NORTH</b> 

For Shanti Lal Nirman Pvt. Ltd.  
*Ankit Mittal* Director  
**ASHOK MISHRA** Ph. 22259771  
**B. Arch., M.C.A.**  
**C.A./91/13916**  
**95, Shivaji Nagar, Civil Lines**  
**JAIPUR**

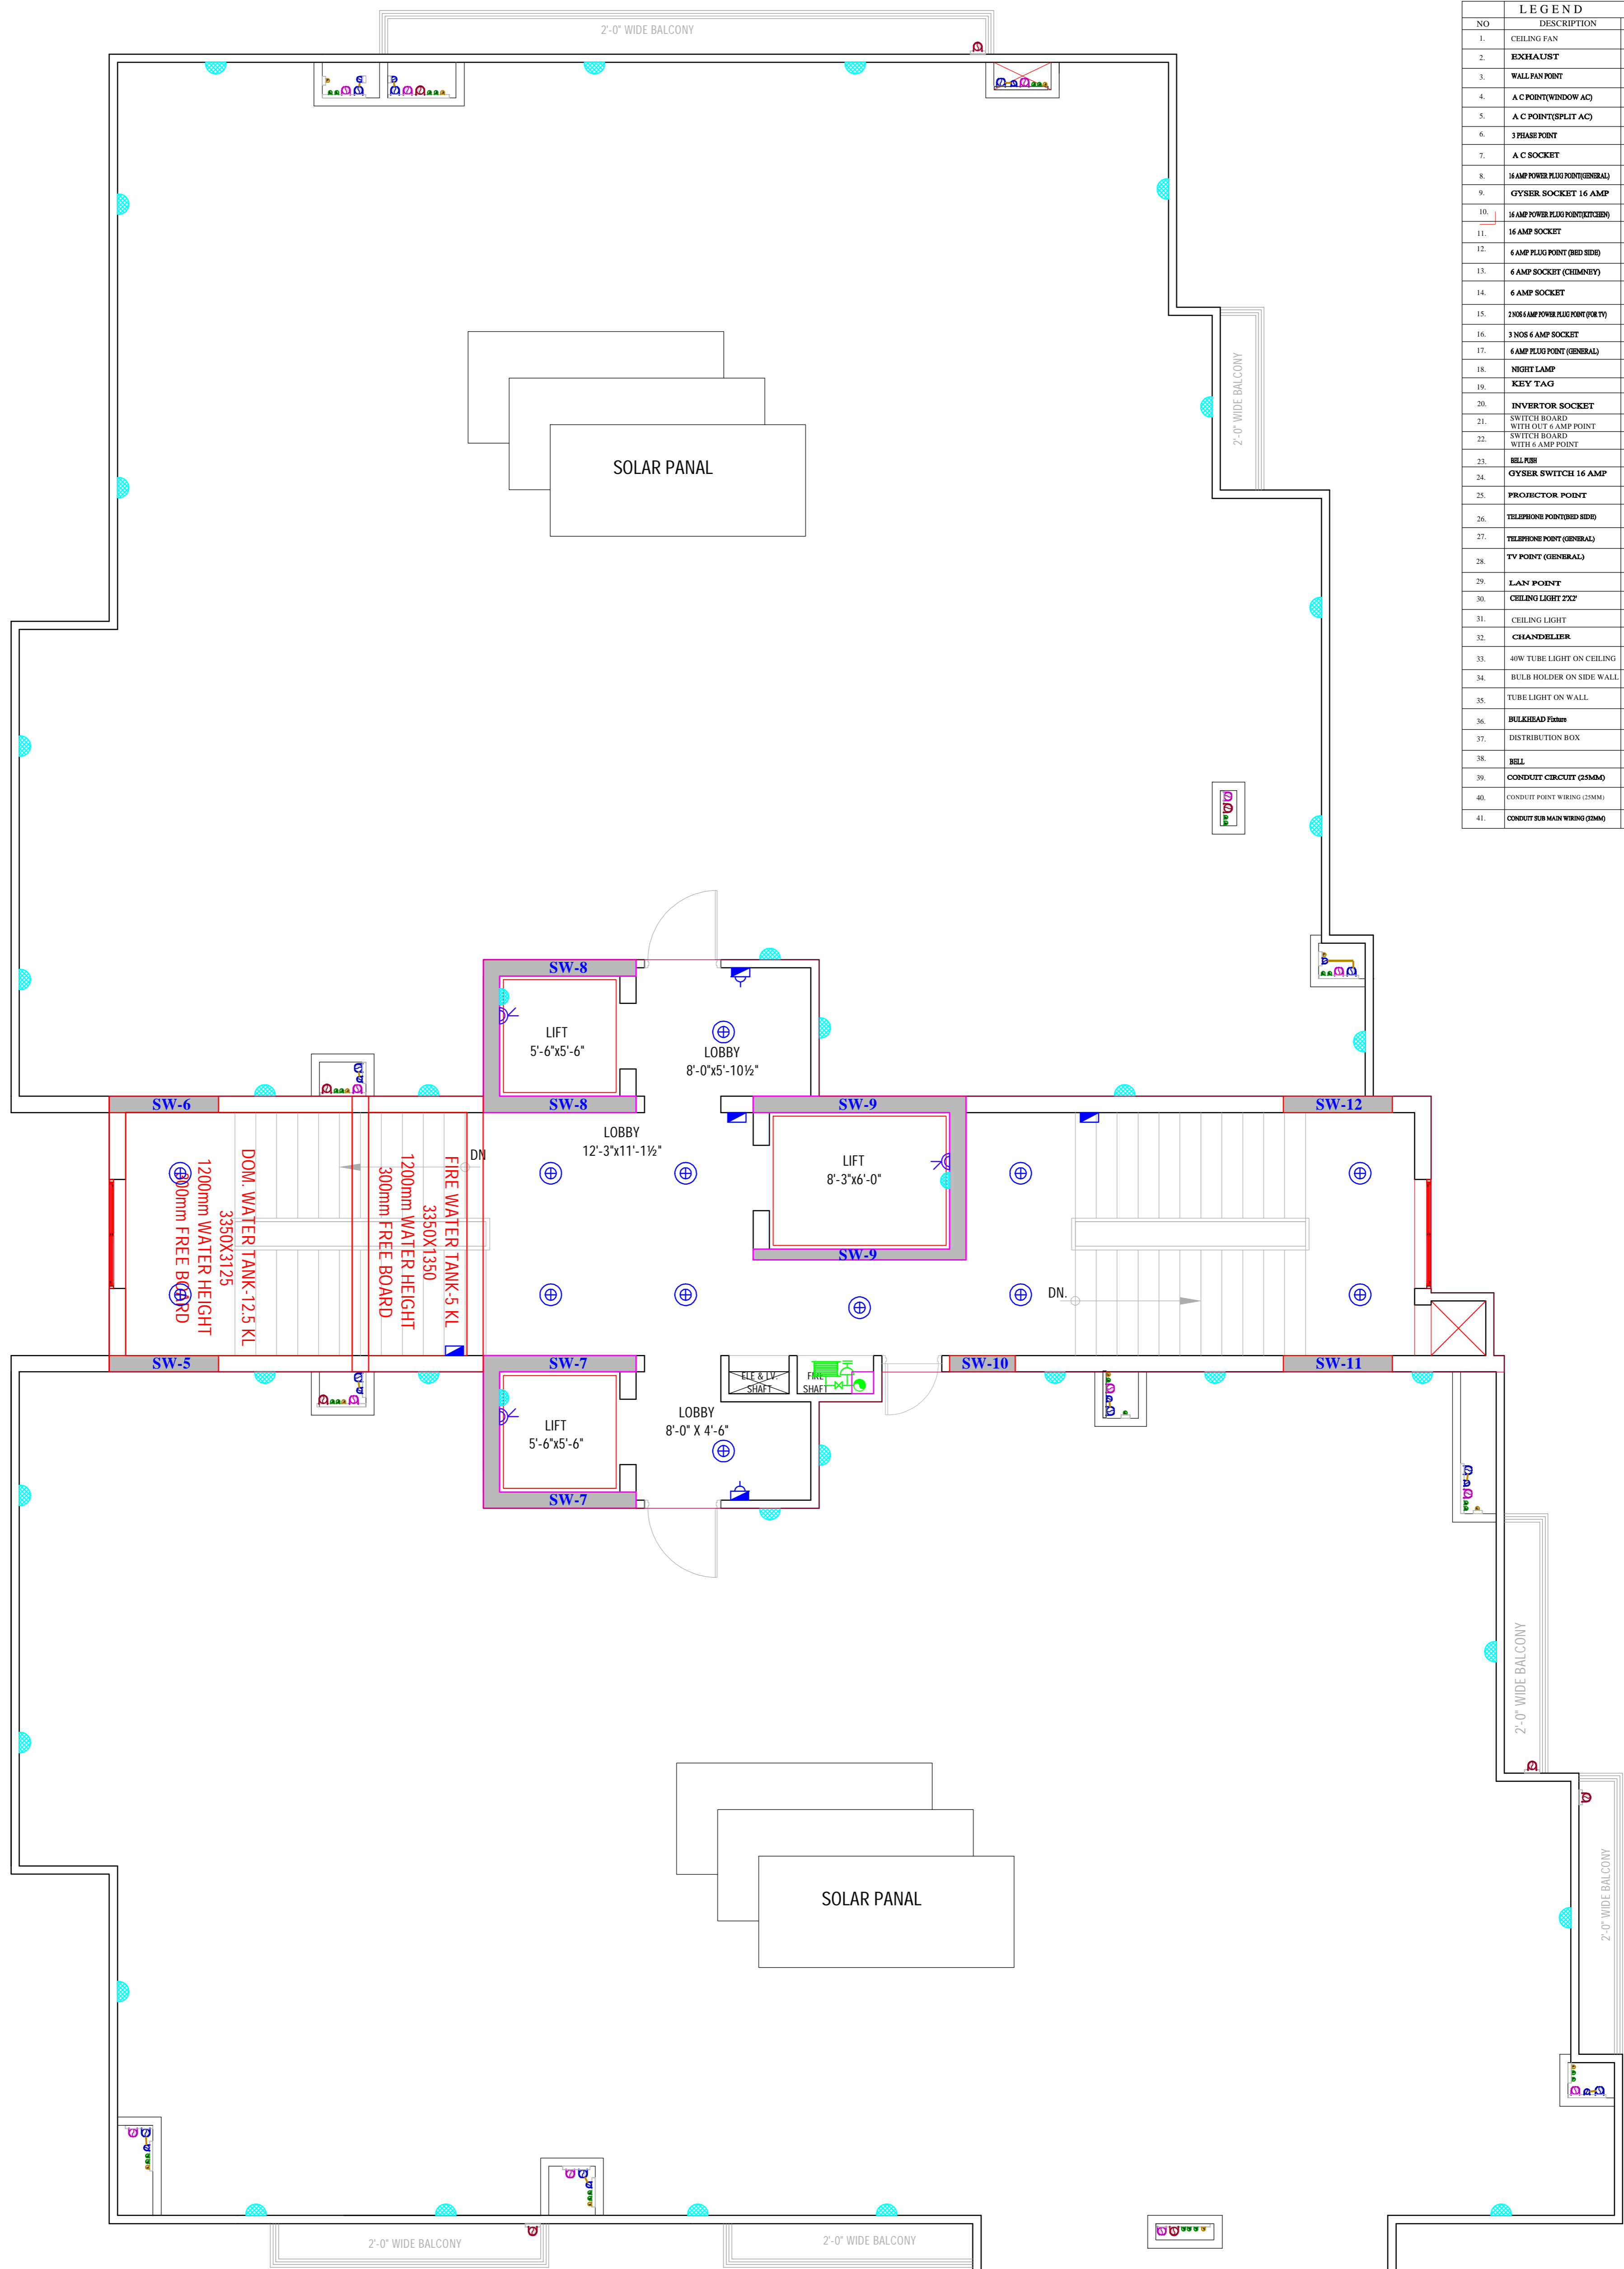

LEGEND			
NO	DESCRIPTION	SYMBOL	FROM FTL
1.	CEILING FAN		CEILING
2.	EXHAUST		6'-0"
3.	WALL FAN POINT		6'-0"
4.	A C POINT(WINDOW AC)		1'-0"
5.	A C POINT(SPLIT AC)		AS PER SITE
6.	3 PHASE POINT		AS PER SITE
7.	A C SOCKET		AS PER SITE
8.	4 AMP POWER PLUG POINT(GENERAL)		1'-0"
9.	GYSER SOCKET 16 AMP		6'-0"
10.	4 AMP POWER PLUG POINT(CBIB)		12' ABOVE FINISHED SLAB
11.	16 AMP SOCKET		AS PER SITE
12.	4 AMP PLUG POINT (BED SIDE)		2'-6"
13.	6 AMP SOCKET (CHIMNEY)		7'-0"
14.	6 AMP SOCKET		AS PER SITE
15.	1 NOS 4 AMP POWER PLUG POINT (PORT)		1'-6" @ 6"
16.	3 NOS 6 AMP SOCKET		1'-6" @ 6"
17.	4 AMP PLUG POINT (GENERAL)		1'-0"
18.	NIGHT LAMP		1'-6"
19.	KEY TAG		4'-0"
20.	INVERTOR SOCKET		1'-6"
21.	SWITCH BOARD WITH OUT 6 AMP POINT		4'-0"
22.	SWITCH BOARD WITH 6 AMP POINT		4'-0"
23.	BELLBUB		4'-0"
24.	GYSER SWITCH 16 AMP		4'-0"
25.	PROJECTOR POINT		3'-6"
26.	TELEPHONE POINT(BED SIDE)		2'-6"
27.	TELEPHONE POINT (GENERAL)		1'-0"
28.	TV POINT (GENERAL)		2'-6"
29.	LAN POINT		2'-6"
30.	CEILING LIGHT 2X2		CEILING
31.	CEILING LIGHT		CEILING
32.	CHANDRIELER		CEILING
33.	40W TUBE LIGHT ON CEILING		CEILING
34.	BULB HOLDER ON SIDE WALL		7'-3"
35.	TUBE LIGHT ON WALL		7'-3"
36.	BULKHEAD Fitter		2'-6"
37.	DISTRIBUTION BOX		5'-0"
38.	BELL		7'-3"
39.	CONDUIT CIRCUIT (25MM)		CEILING
40.	CONDUIT POINT WIRING (25MM)		CEILING
41.	CONDUIT BUS MAIN WIRING (25MM)		CEILING

**TERRACE FLOOR PLAN**

For Shanti Lal Nirman Pvt. Ltd.  
*Amit Mittal*  
 Director

*Ashok Mishra*  
 ASHOK MISHRA Ph. 2229771  
 S. Archt., M.C.A.  
 C.A./91/13916  
 95, Shivaji Nagar, Civil Lines  
 JAIPUR

<b>GENERAL NOTES :-</b> 1. All dimensions are in feet and inches. 2. Do not scale this drawing follow written dimensions only. 3. This drawing shall be read in conjunction with other architectural structural and services drawings. 4. Any discrepancy in the drawing should be immediately brought to the notice of architect prior to construction.	5. Architectural Drawings should be followed for the Location of structural and masonry members however size & reinforcement shall be followed as structural or other relevant drawings. 6. Coordination with other services drawings such as electrical hvac plumbing etc. is the sole responsibility of the contractor. 7. For details follow large scale detailed drawings. 8. All drawings/measurements must be checked & verified by the contractor at site.	9. Architect's responsibility is limited to the soundness of its design only. 10. Bad workmanship will be sole responsibility of client & contractor.  <b>WARNING :-</b> 1. This drawing is the sole copyright of Architects Mishra Garg & Associates and should be used for the purpose expressly issued.	<b>DRAWING TITLE</b>  <b>TERRACE FLOOR ELECTRICAL PLAN</b>	<b>PROJECT TITLE</b>  <b>RESIDENTIAL APARTMENT "ORCHID BOUNTY" AT FIROZABAD</b>	<b>ARCHITECTS :</b>  <b>SHRESTHA ARCH GROUP</b> ENGINEERS & INTERIOR DESIGNER JAIN NAGAR, FIROZABAD MOB. : 8267832492	<b>MISHRA GARG &amp; ASSOCIATES</b> ARCHITECTS, PLANNERS & INTERIOR DESIGNER C-35, LAPATI MARKET, SCHEME, JAIPUR. TEL. : (0141) 2373274 Email id : mishra.garg@gmail.com													
			<table border="1"> <tr> <th>DESIGN BY</th> <th>PROJECT ARCHITECT</th> <th>DATE</th> <th>NORTH</th> </tr> <tr> <td>ASHOK MISHRA</td> <td>JITENDRA</td> <td>05-03-2024</td> <td rowspan="2"></td> </tr> <tr> <td>RAJEEV GARG</td> <td>JOB NO.</td> <td>DRG. NO.</td> </tr> <tr> <td>SCALE</td> <td></td> <td></td> <td></td> </tr> <tr> <td>N.T.S.</td> <td></td> <td>3/102</td> <td></td> </tr> </table>	DESIGN BY	PROJECT ARCHITECT	DATE	NORTH	ASHOK MISHRA	JITENDRA	05-03-2024		RAJEEV GARG	JOB NO.	DRG. NO.	SCALE				N.T.S.
DESIGN BY	PROJECT ARCHITECT	DATE	NORTH																
ASHOK MISHRA	JITENDRA	05-03-2024																	
RAJEEV GARG	JOB NO.	DRG. NO.																	
SCALE																			
N.T.S.		3/102																	