


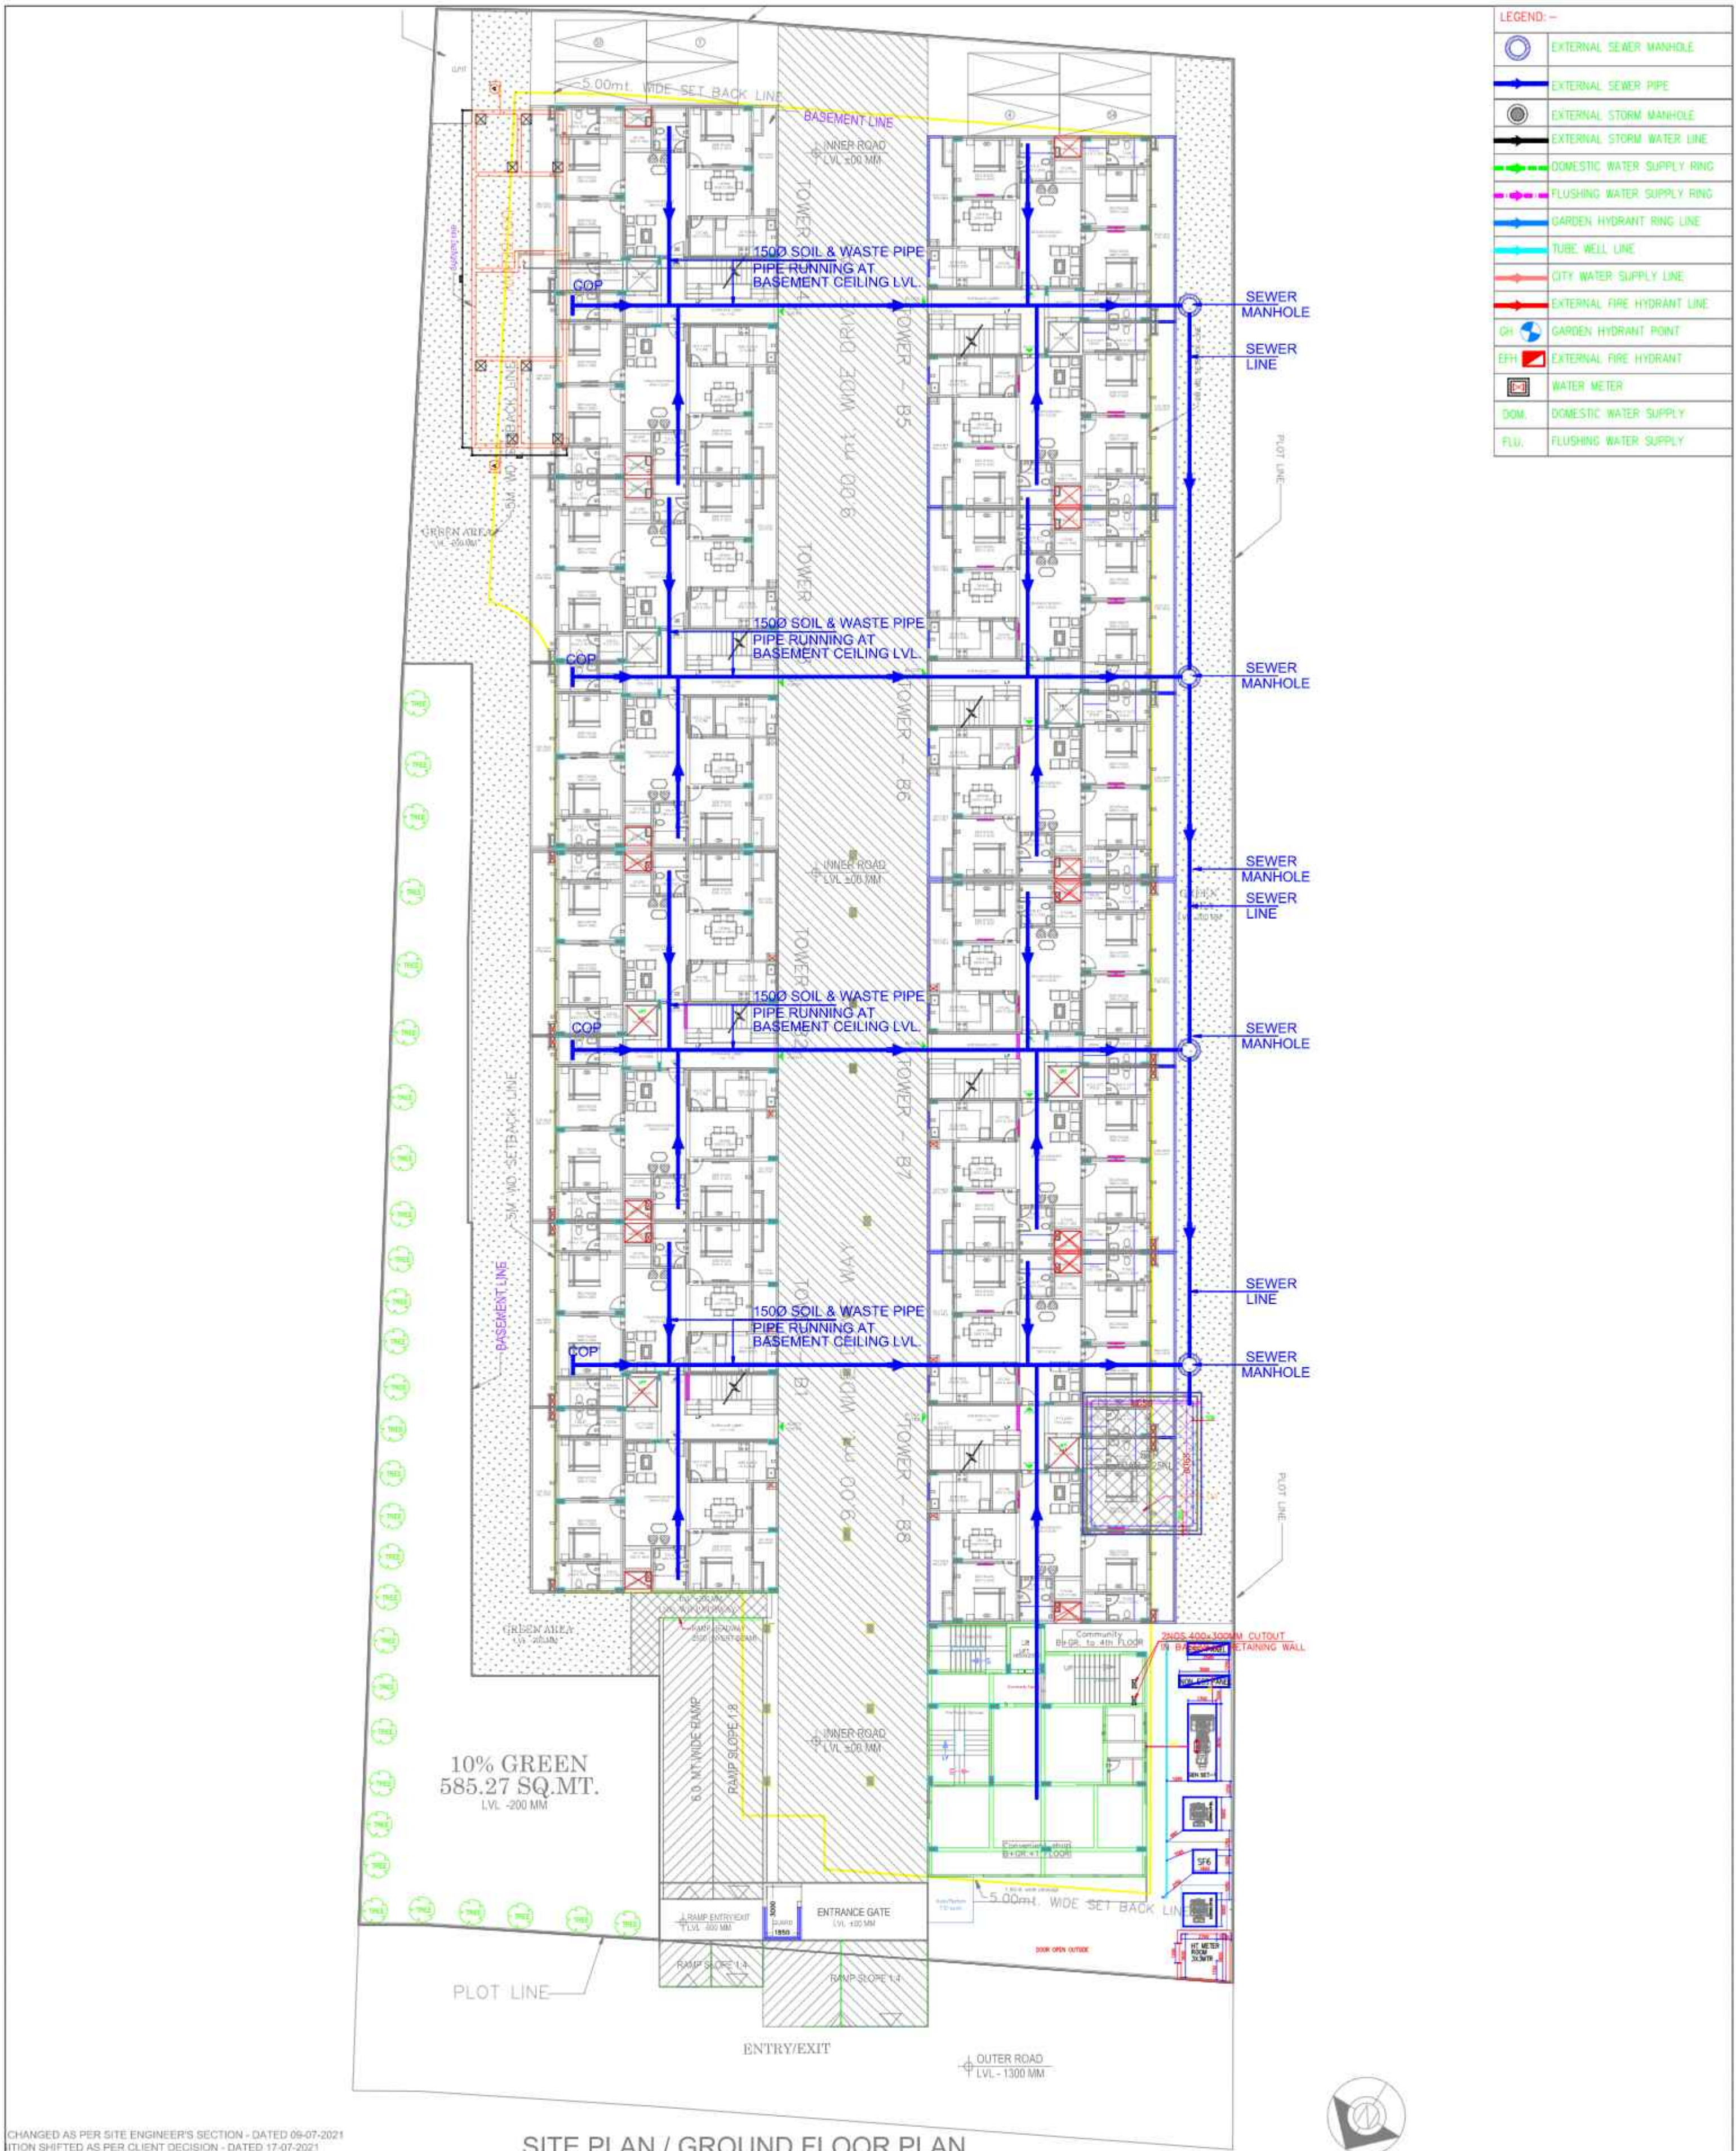


CHANGED AS PER SITE ENGINEER'S SECTION - DATED 09-07-2021
ITION SHIFTED AS PER CLIENT DECISION - DATED 17-07-2021
EL REVISED TO +00 - DATED 31-07-2021

SITE PLAN / GROUND FLOOR PLAN

PROJECT:
" UNINAV EDEN " AT KHASRA NO - 1104 M AT
VILLAGE NOOR NAGAR GHAZIABAD (U.P.)
M/s. - UNINAV DEVELOPER'S PVT. LTD.

DRG. TITLE:-
SEWER DRAINAGE LAYOUT
SITE PLAN

DRG/. NO.
UN/EDEN/SITE/SW-01

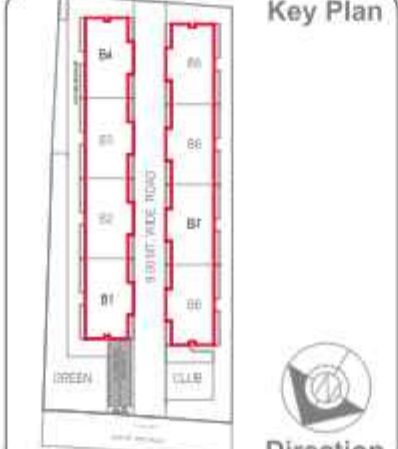

PLUMBING & FIRE CONSULTANT:-
BEHERA & ASSOCIATES PVT. LTD.
F-623a, BEHIND, CNG FILLING STATION,
LADO SARAI, NEW DELHI 110030
PH:- 011-40583898, 09811911853
E mail:- behera.associates@gmail.com

drawing released for
☐ APPROVAL ☐ G.F.C.
☐ ADVANCE COPY ☐ CONSTRUCTION

Design Studio
ANUJ AGARWAL ARCHITECTS
OFFICE:- A-244 KAUSHAMBI GHAZIABAD (U.P.)
Ph:-0120 - 4165716 , 4563716 , 6454182
e-mail : arch.anujagarwal@gmail.com

scale:- A1 - 1:175 date:- 22-10-2021
design by:- RAJ checked by:- S.BEHERA