


Proposed Project
(PRATEEK AURELIA)
EWS & LIG

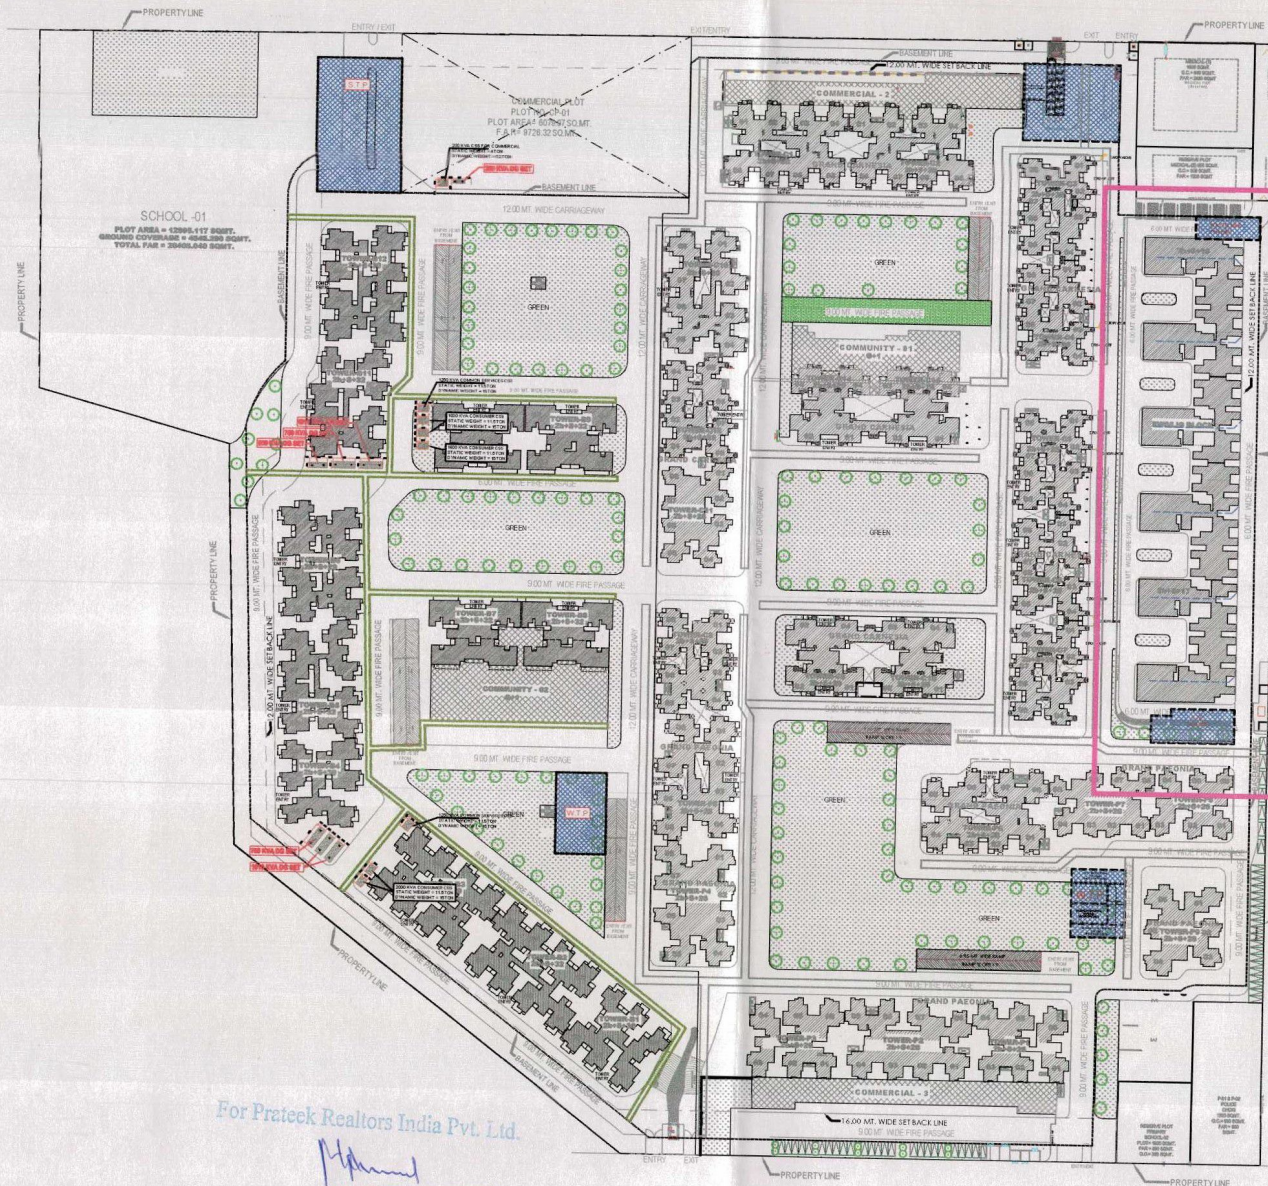

Authorized Signatory

75.00 M Wide Road

Rmr. No.	Date	Revision
project PRATEEK GRAND CITY SIDDHARTH VIHAR , GHAZIABAD		
title SITE PLAN		
subtitle EXTERNAL ELECTRICAL DRAWING		
drawing released for ☐ APPROVAL ☒ SUBMISSION ☐ ADVANCE COPY ☐ CONSTRUCTION		
drg. no. PSC / SP / PL -04 Drawn by Samsher Singh		
scale 1:800 @ AI designed by M Manroor		
date 02-06-2022 checked by ANAND HAVELIA		
architects Architect Hafeez Contractor 29 Basm Street Ewbury St. Tel: +91 22 22818171 Fax: +91 22 22641573 www.architect-hafiez.com email: hofiaz@hafiezhc.com		
services consultant Consummate Engineering Services (P) Ltd. BSE Office : B-87, Sector-17, Noida - 201301 Tel.: (0120) 2903050 / (30 Lines) Fax: Office : 0120, Rajendra Place Metro, Grand Nagar, Lucknow E mail : info@cesps.in web site : www.cesps.in		