


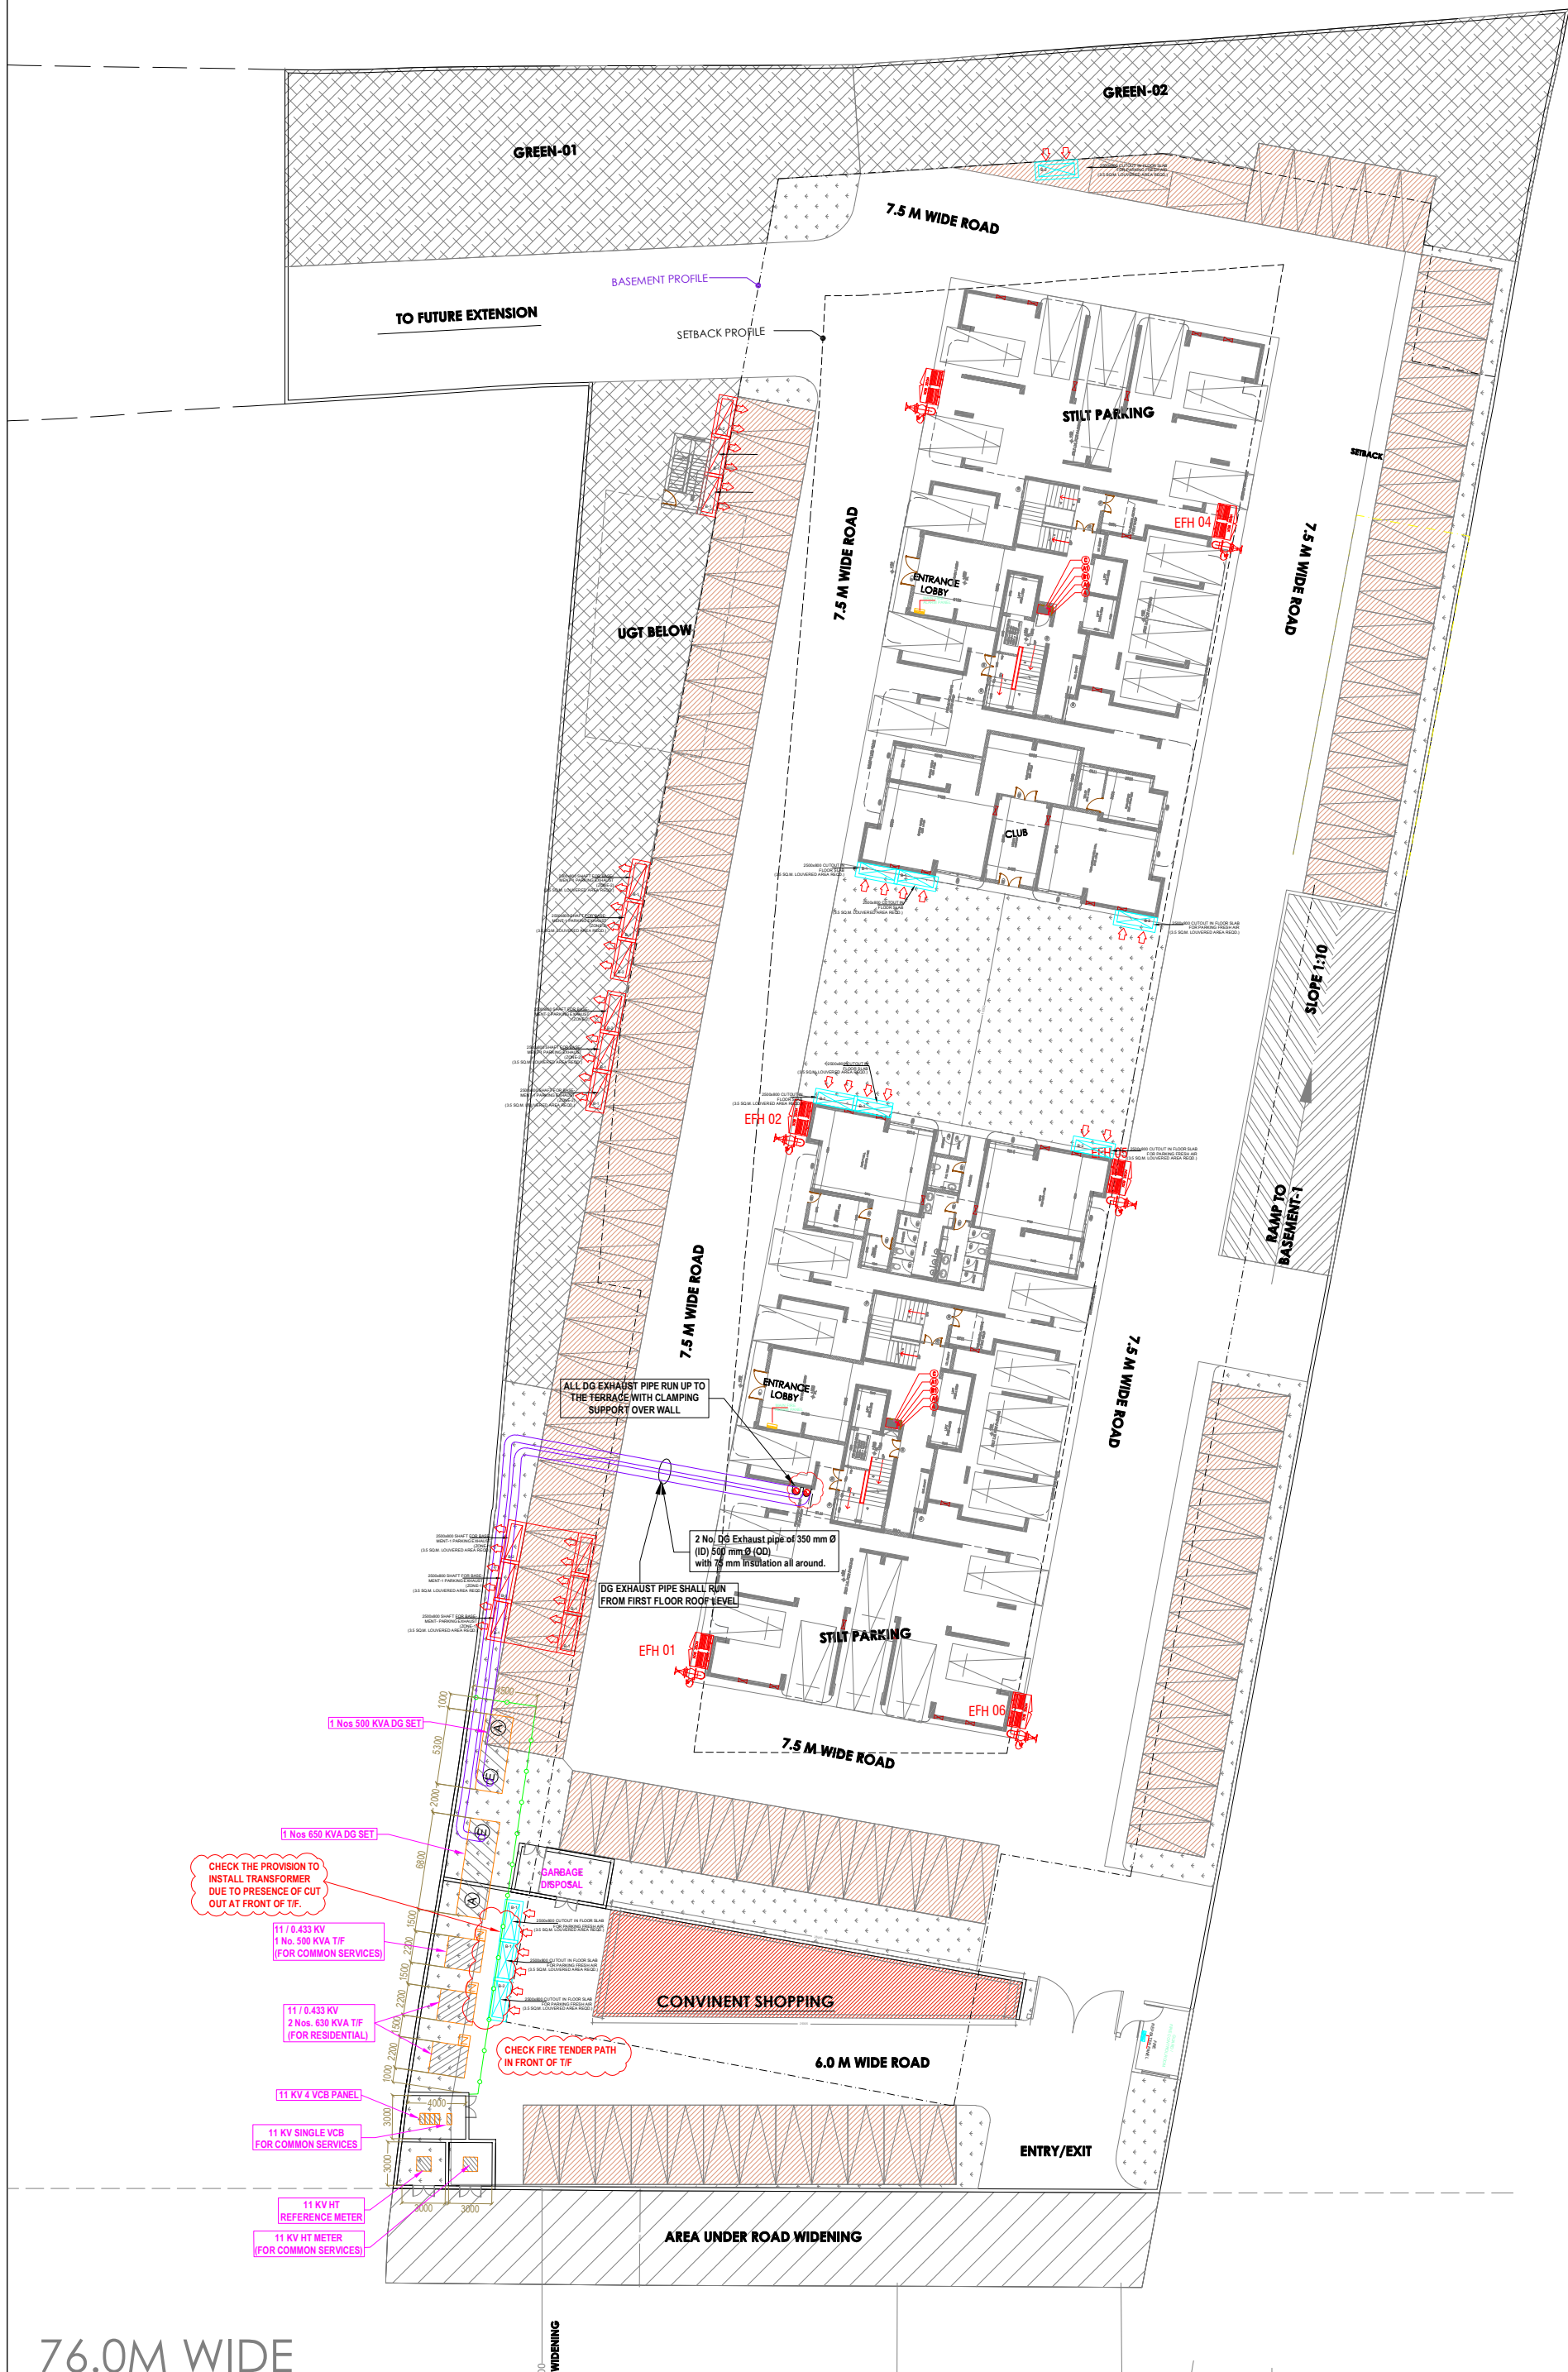

76.0M WIDE

project
**ORO ARJUNANJ
GROUP-HOUSING AT LUCKNOW**

title
ELECTRICAL DRAWING
sub title
ESS LAYOUT AT SITE PLAN

drawing released for
☒ APPROVAL
☐ ADVANCE COPY
☐ SUBMISSION
☐ CONSTRUCTION

drg. no.
ORO / ELEC. / EXT- 01
scale
1:225 @ A1
date
Sep. 2024

drawn by
Surjeet
designed by
Ateeq Ur Rehman
checked by
Anand Havelia

architects
K-DESIGN
405, AVALON APARTMENT
NEW MANGALAPURI, NEW DELHI- 110030
E mail - architectrakeshsharma@gmail.com, royat07@gmail.com

services consultant
Cespl Consultants Pvt. Ltd.
B - 67, Sector - 67, Noida - 201 301
Tel : (0120) 3225400 / 3225401
e mail : mail@cespl.in, website : www.cespl.in