


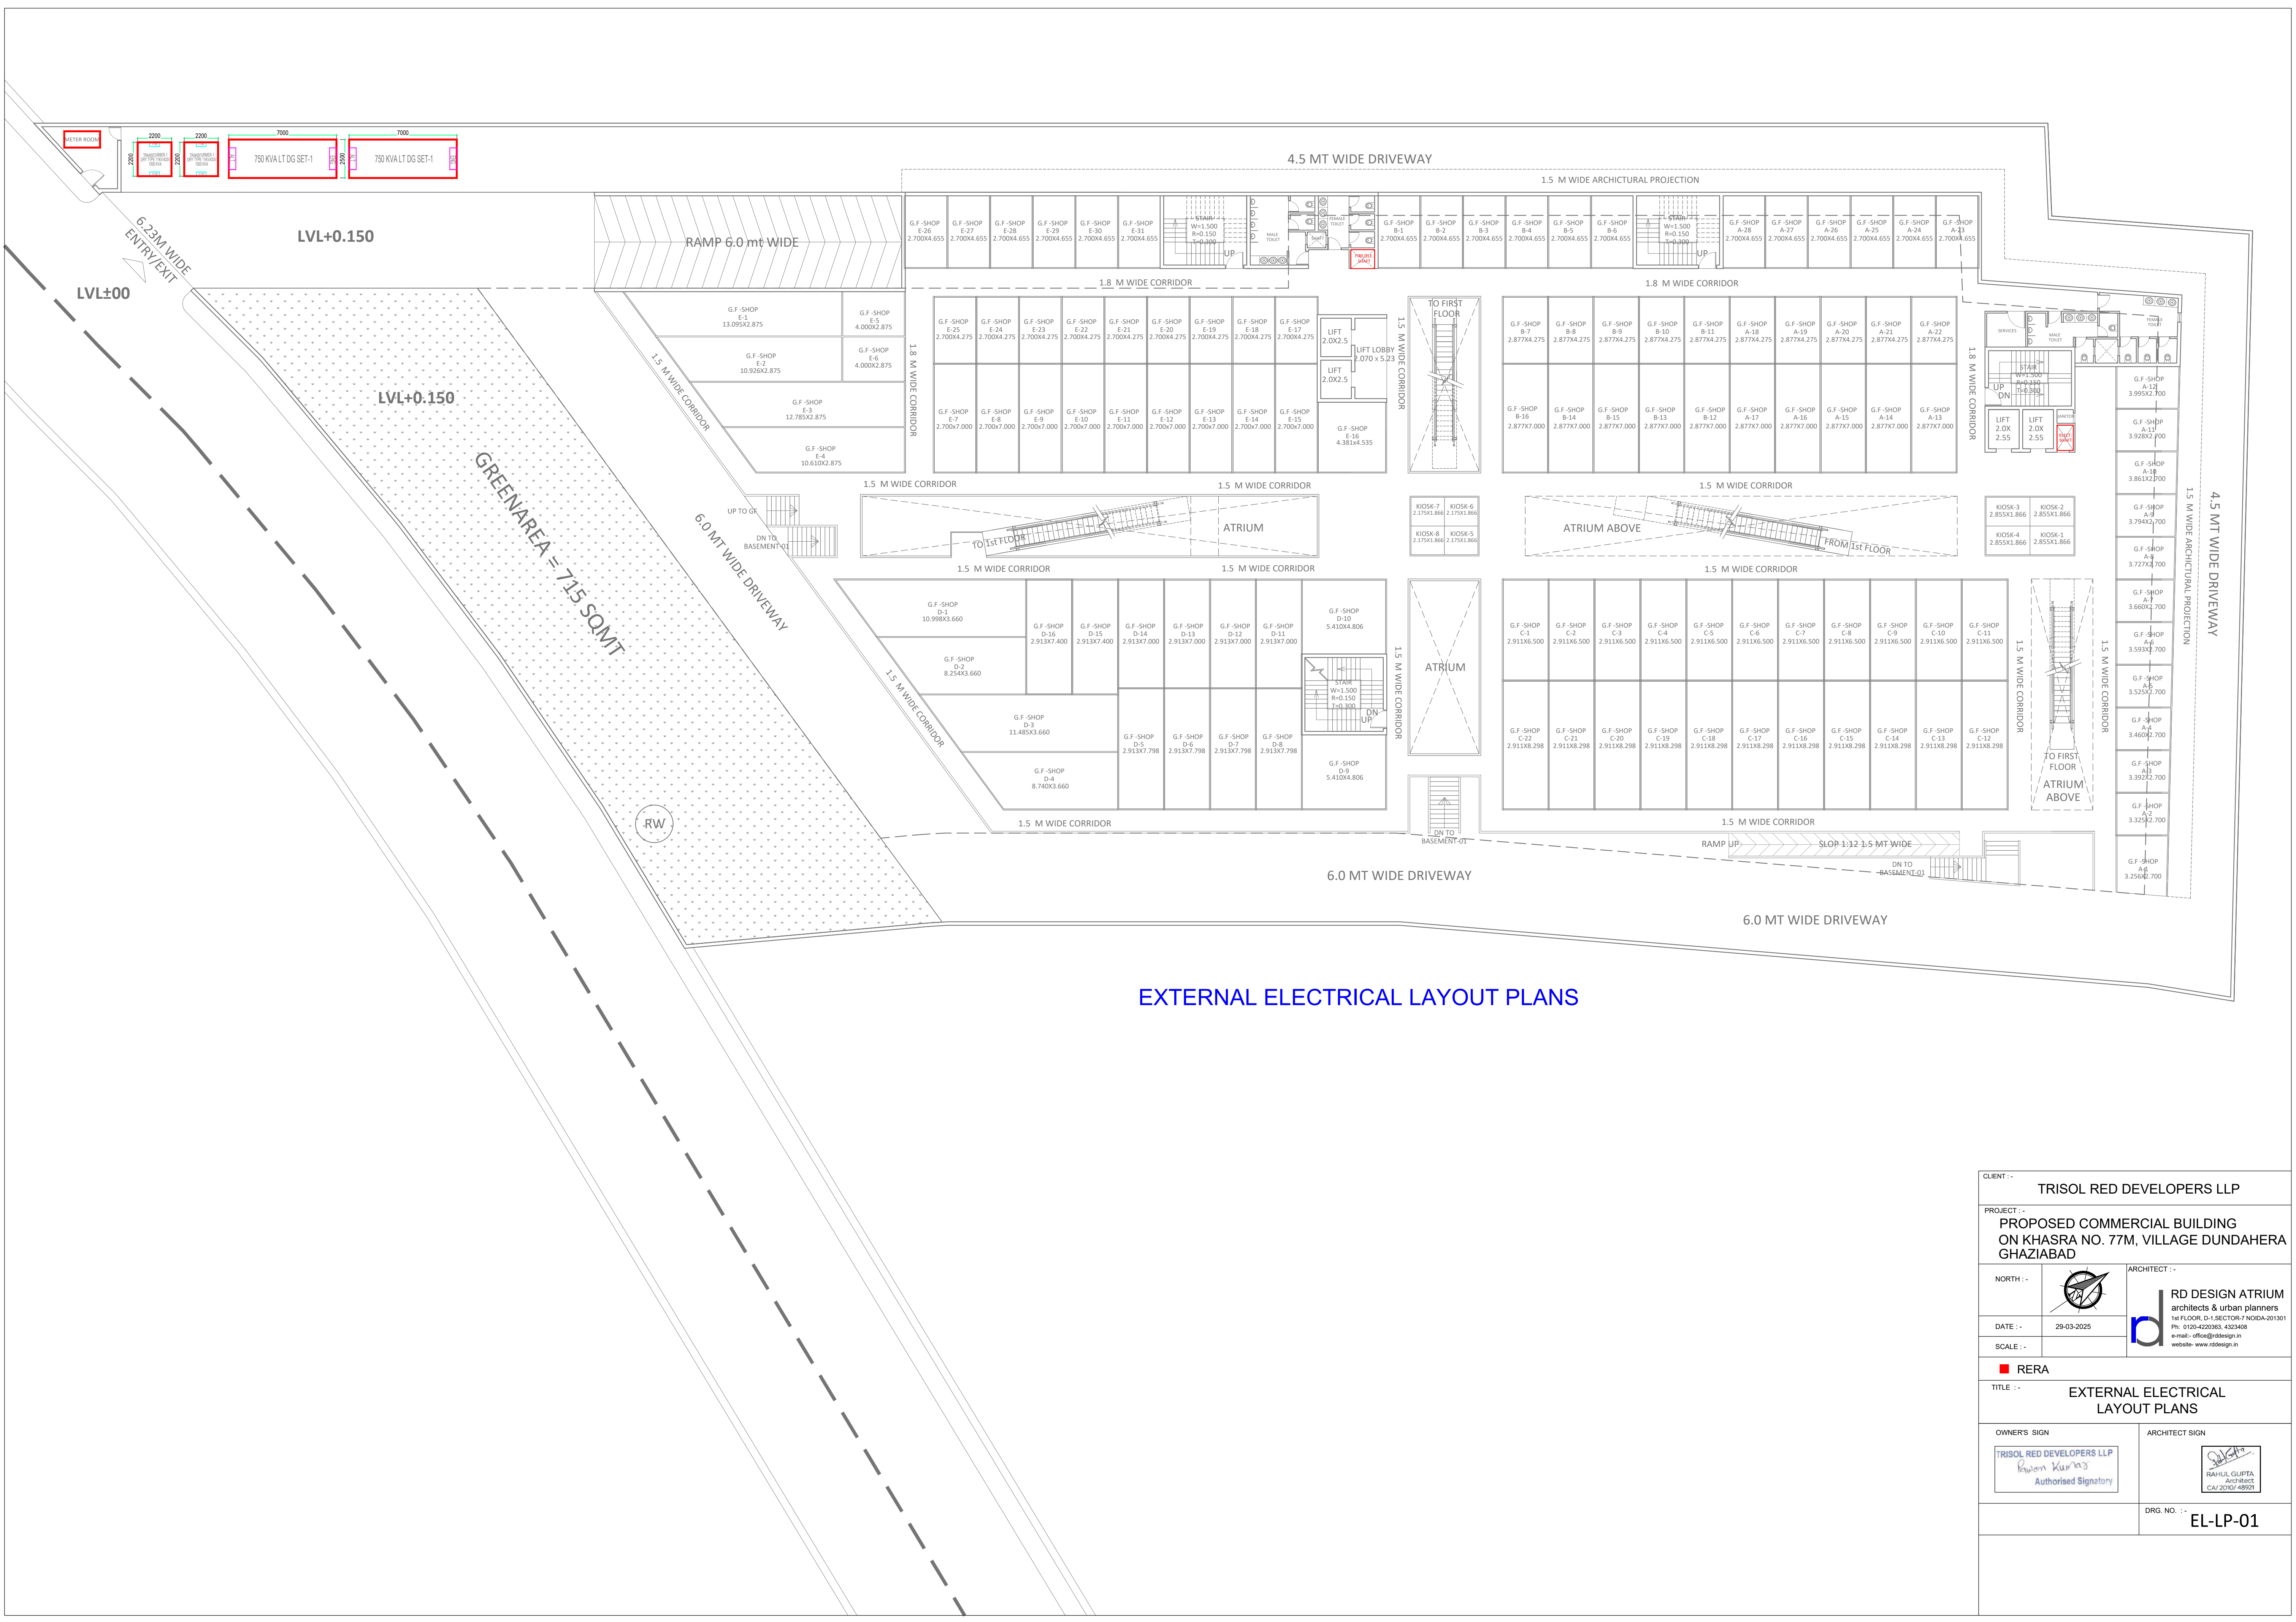

EXTERNAL ELECTRICAL LAYOUT PLANS

CLIENT :-

TRISOL RED DEVELOPERS LLP

PROJECT :-

PROPOSED COMMERCIAL BUILDING  
ON KHASRA NO. 77M, VILLAGE DUNDAHERA  
GHAZIABAD

 
NORTH :-

DATE :-

29-03-2025

SCALE :-

OWNER'S SIGN

  
Ravi Kumar  
Authorised Signatory

ARCHITECT SIGN


  
RAHUL GUPTA  
EAV 2020/48921

TITLE :-

EXTERNAL ELECTRICAL  
LAYOUT PLANS

DRG. NO. :-

EL-LP-01

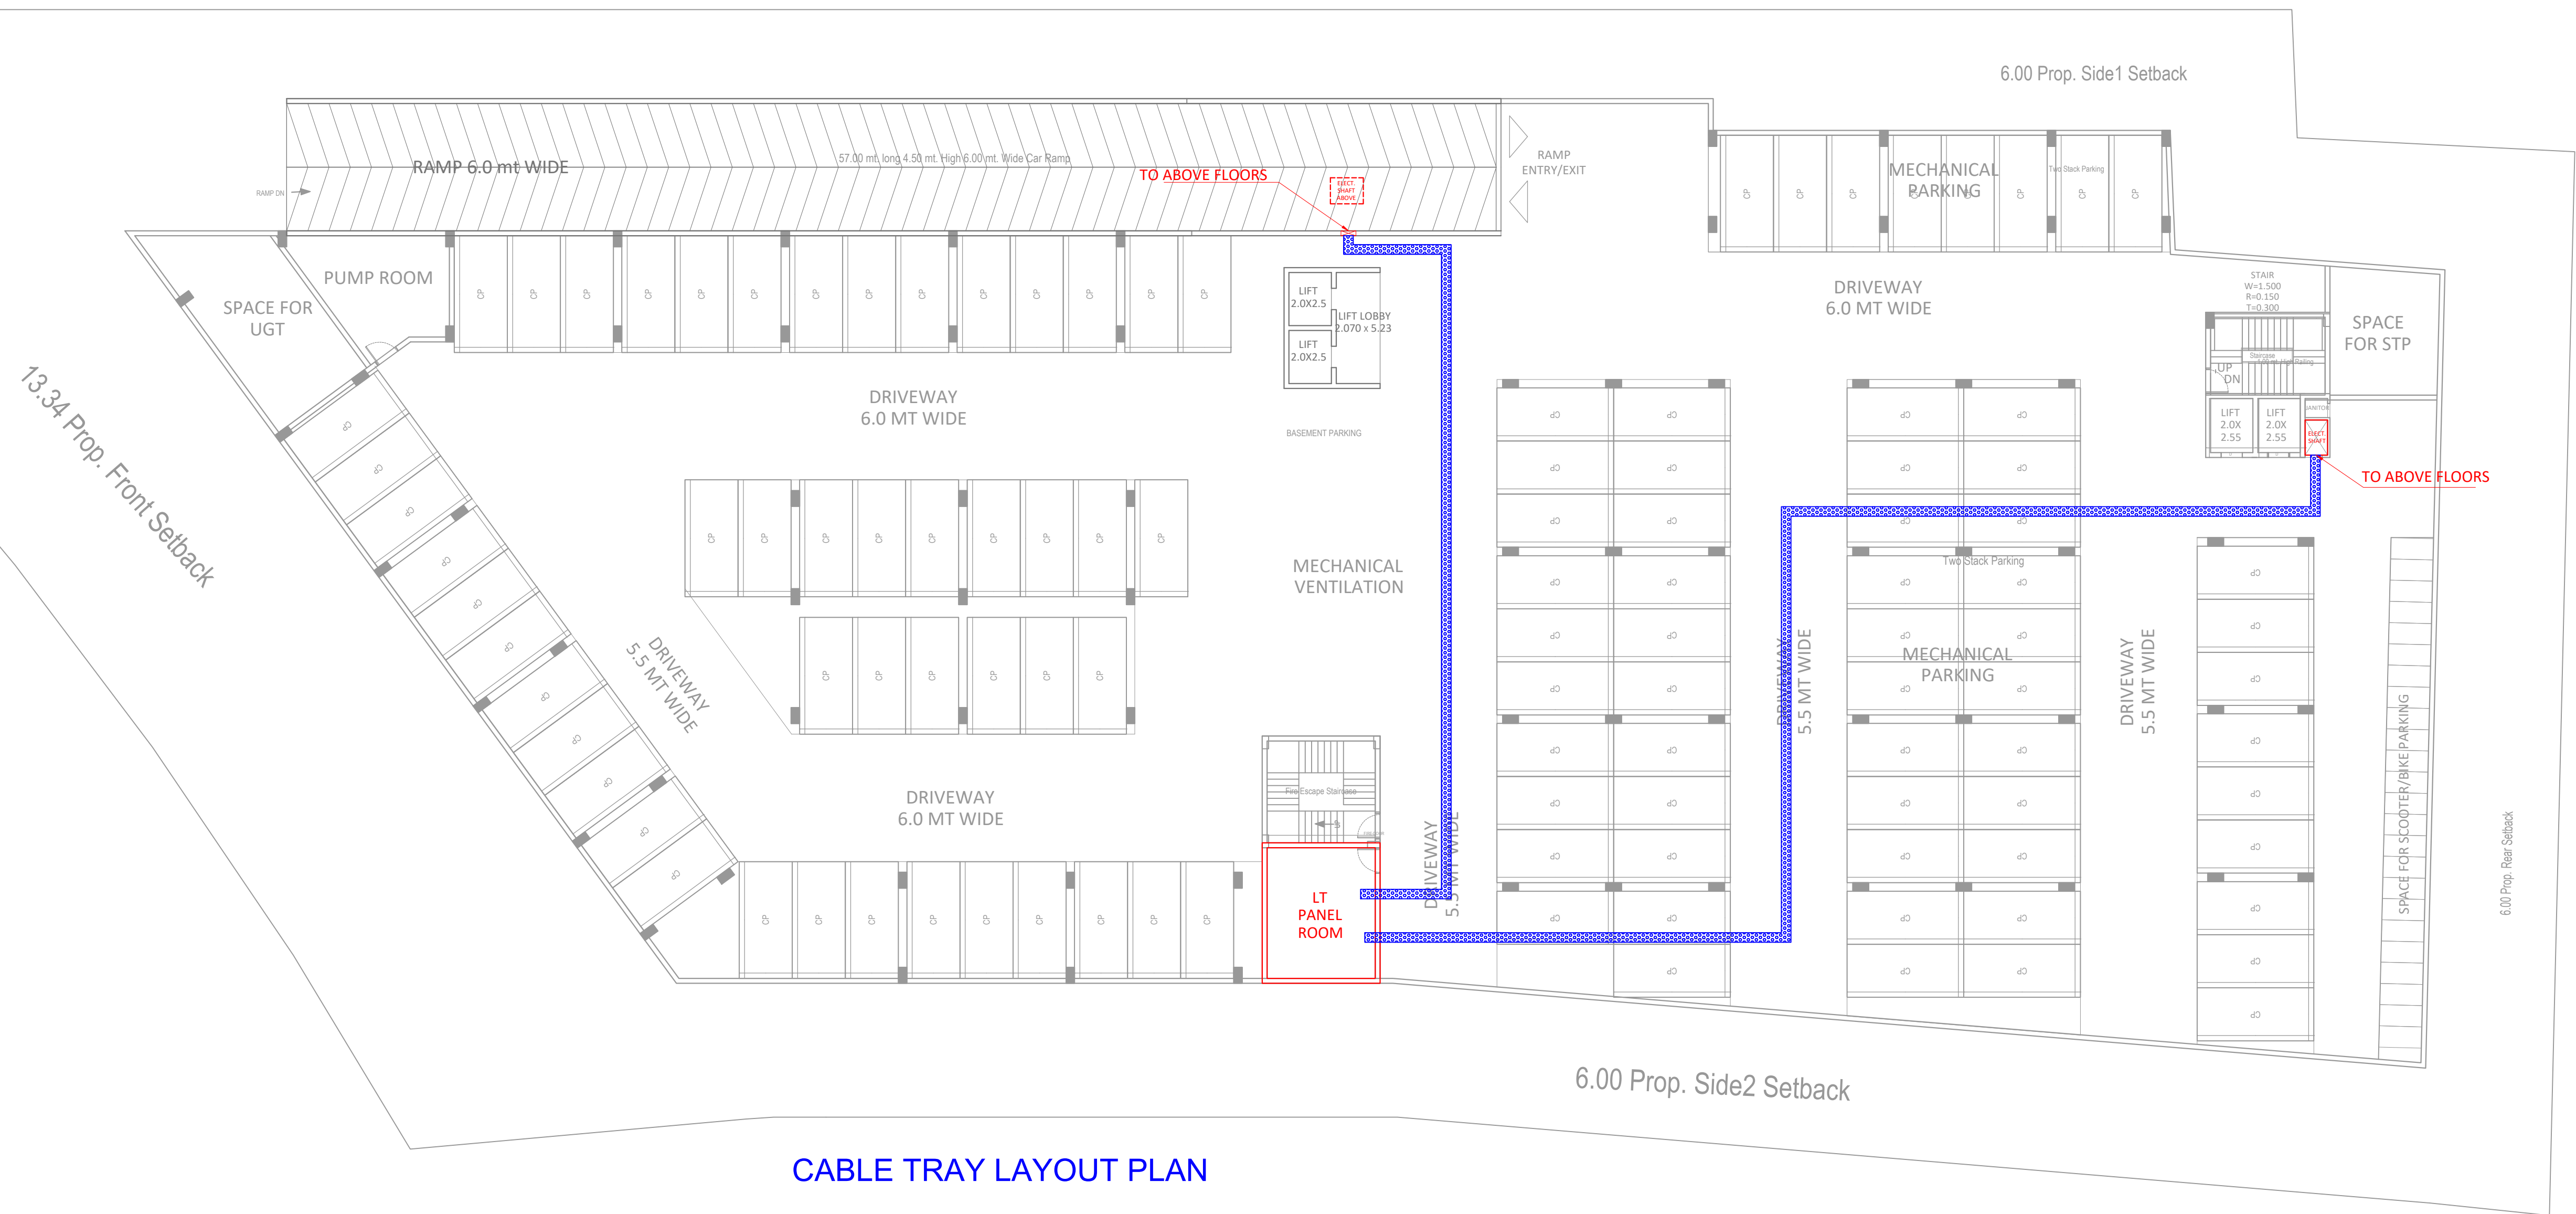

CABLE TRAY LAYOUT PLAN

|              |            |                                                                                   |                                                                                                                                                                                   |
|--------------|------------|-----------------------------------------------------------------------------------|-----------------------------------------------------------------------------------------------------------------------------------------------------------------------------------|
| CLIENT :-    |            | TRISOL RED DEVELOPERS LLP                                                         |                                                                                                                                                                                   |
| PROJECT :-   |            | PROPOSED COMMERCIAL BUILDING<br>ON KHASRA NO. 77M, VILLAGE DUNDAHERA<br>GHAZIABAD |                                                                                                                                                                                   |
| NORTH :-     |            | ARCHITECT :-                                                                      | RD DESIGN ATRIUM<br>architects & urban planners<br>1st FLOOR, D-1, SECTOR-7 NOIDA-201301<br>Ph: 0120-4220363, 4324808<br>e-mail - office@rddesign.in<br>website - www.rddesign.in |
| DATE :-      | 29-03-2025 |                                                                                   |                                                                                                                                                                                   |
| SCALE :-     |            |                                                                                   |                                                                                                                                                                                   |
| RERA         |            |                                                                                   |                                                                                                                                                                                   |
| TITLE :-     |            | BASEMENT CABLE TRAY<br>LAYOUT PLAN                                                |                                                                                                                                                                                   |
| OWNER'S SIGN |            | ARCHITECT SIGN                                                                    |                                                                                                                                                                                   |
|              |            |                                                                                   |                                                                                                                                                                                   |
|              |            | DRG. NO. :-                                                                       |                                                                                                                                                                                   |
|              |            | EL-LP-02                                                                          |                                                                                                                                                                                   |