


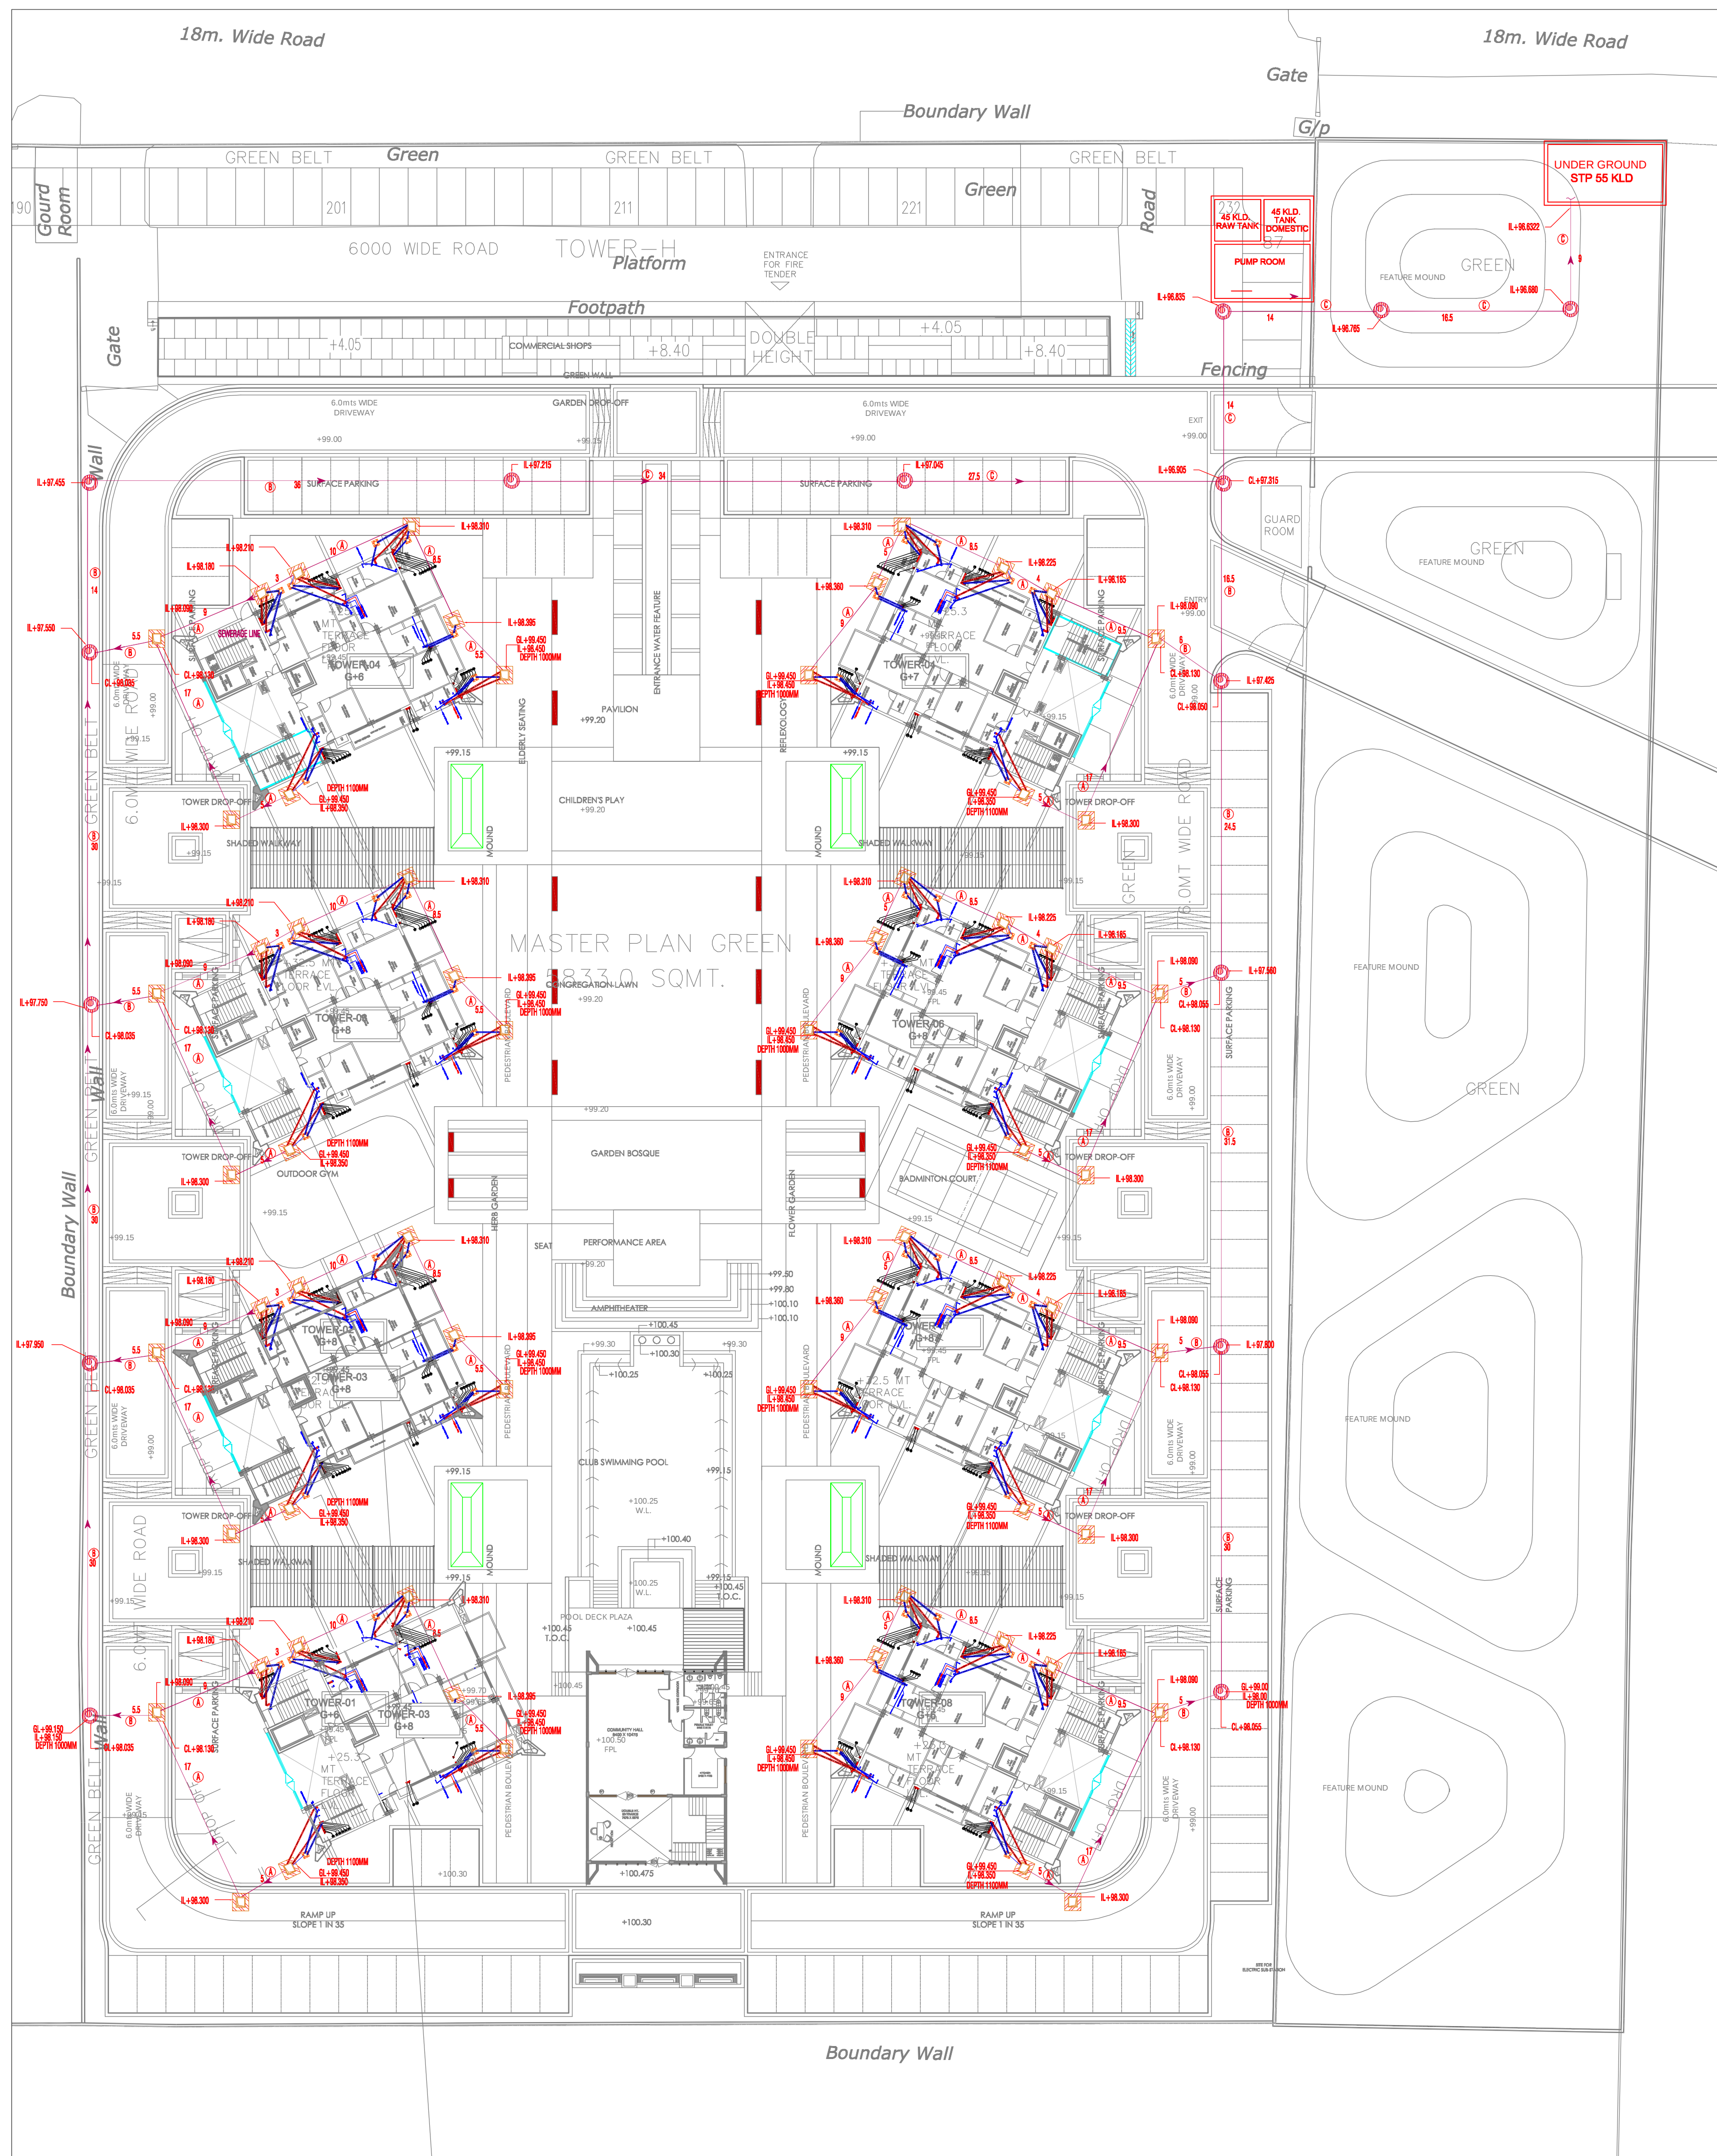

SR-NO	SEWERAGE PIPE DIA
(A)	1500 SEWAGE PIPE SLOPE 1:100
(B)	2000 SEWAGE PIPE SLOPE 1:150
(C)	2500 SEWAGE PIPE SLOPE 1:200

LEGEND FOR SEWERAGE LINE	
	SEWERAGE PIPE
	900X800 SEWERAGE MANHOLE
	300X300 MM GULLY TRAP
	SEWERAGE MANHOLE=9100

CLIENT
M/s AGARWAL ASSOCIATES PROMOTERS LTD.
10, NEW RAJDHANI ENCLAVE, VIKAS MARG
NEW DELHI-110092

MEP CONSULTANT :-
MULTIPLE SERVICES CONSULTANTS
253/B, Rajpur Khurd Extension,
Chattarpur, New Delhi-110068,
Ph. no. -8920225677/8920228058
msc@msc-mep.com

PROJECT- SUBMISSION DRAWINGS FOR
GROUP HOUSING AT PLOT NO GH-1
ADITYA WORLD CITY, INTEGRATED TOWNSHIP,
SHAHPUR-BAMHETA, CHAZIABAD, (U.P)
KHASRA NO= 1910,1911,1912/2m,1912/1m,1915,
1916,1917,1918,1919,1920,1921,1922,
1930,1938,2285,2286m,2286m,2287
2288,2289,2295

SHEET TITLE
SITE PLAN
SEWAGE LAYOUT

DEALT	SCALE 1:325	DRG. NO
CHECKED	DATE 5-05-2022	MSC/AWCIT/ESP/SW-01

ARCHITECT

DESIGN FORUM INTERNATIONAL
K-47, KAILASH COLONY, NEW DELHI-110048
PH. NO:- 011-46556600, FAX:- 011-46556601
www.designforuminternational.com.