


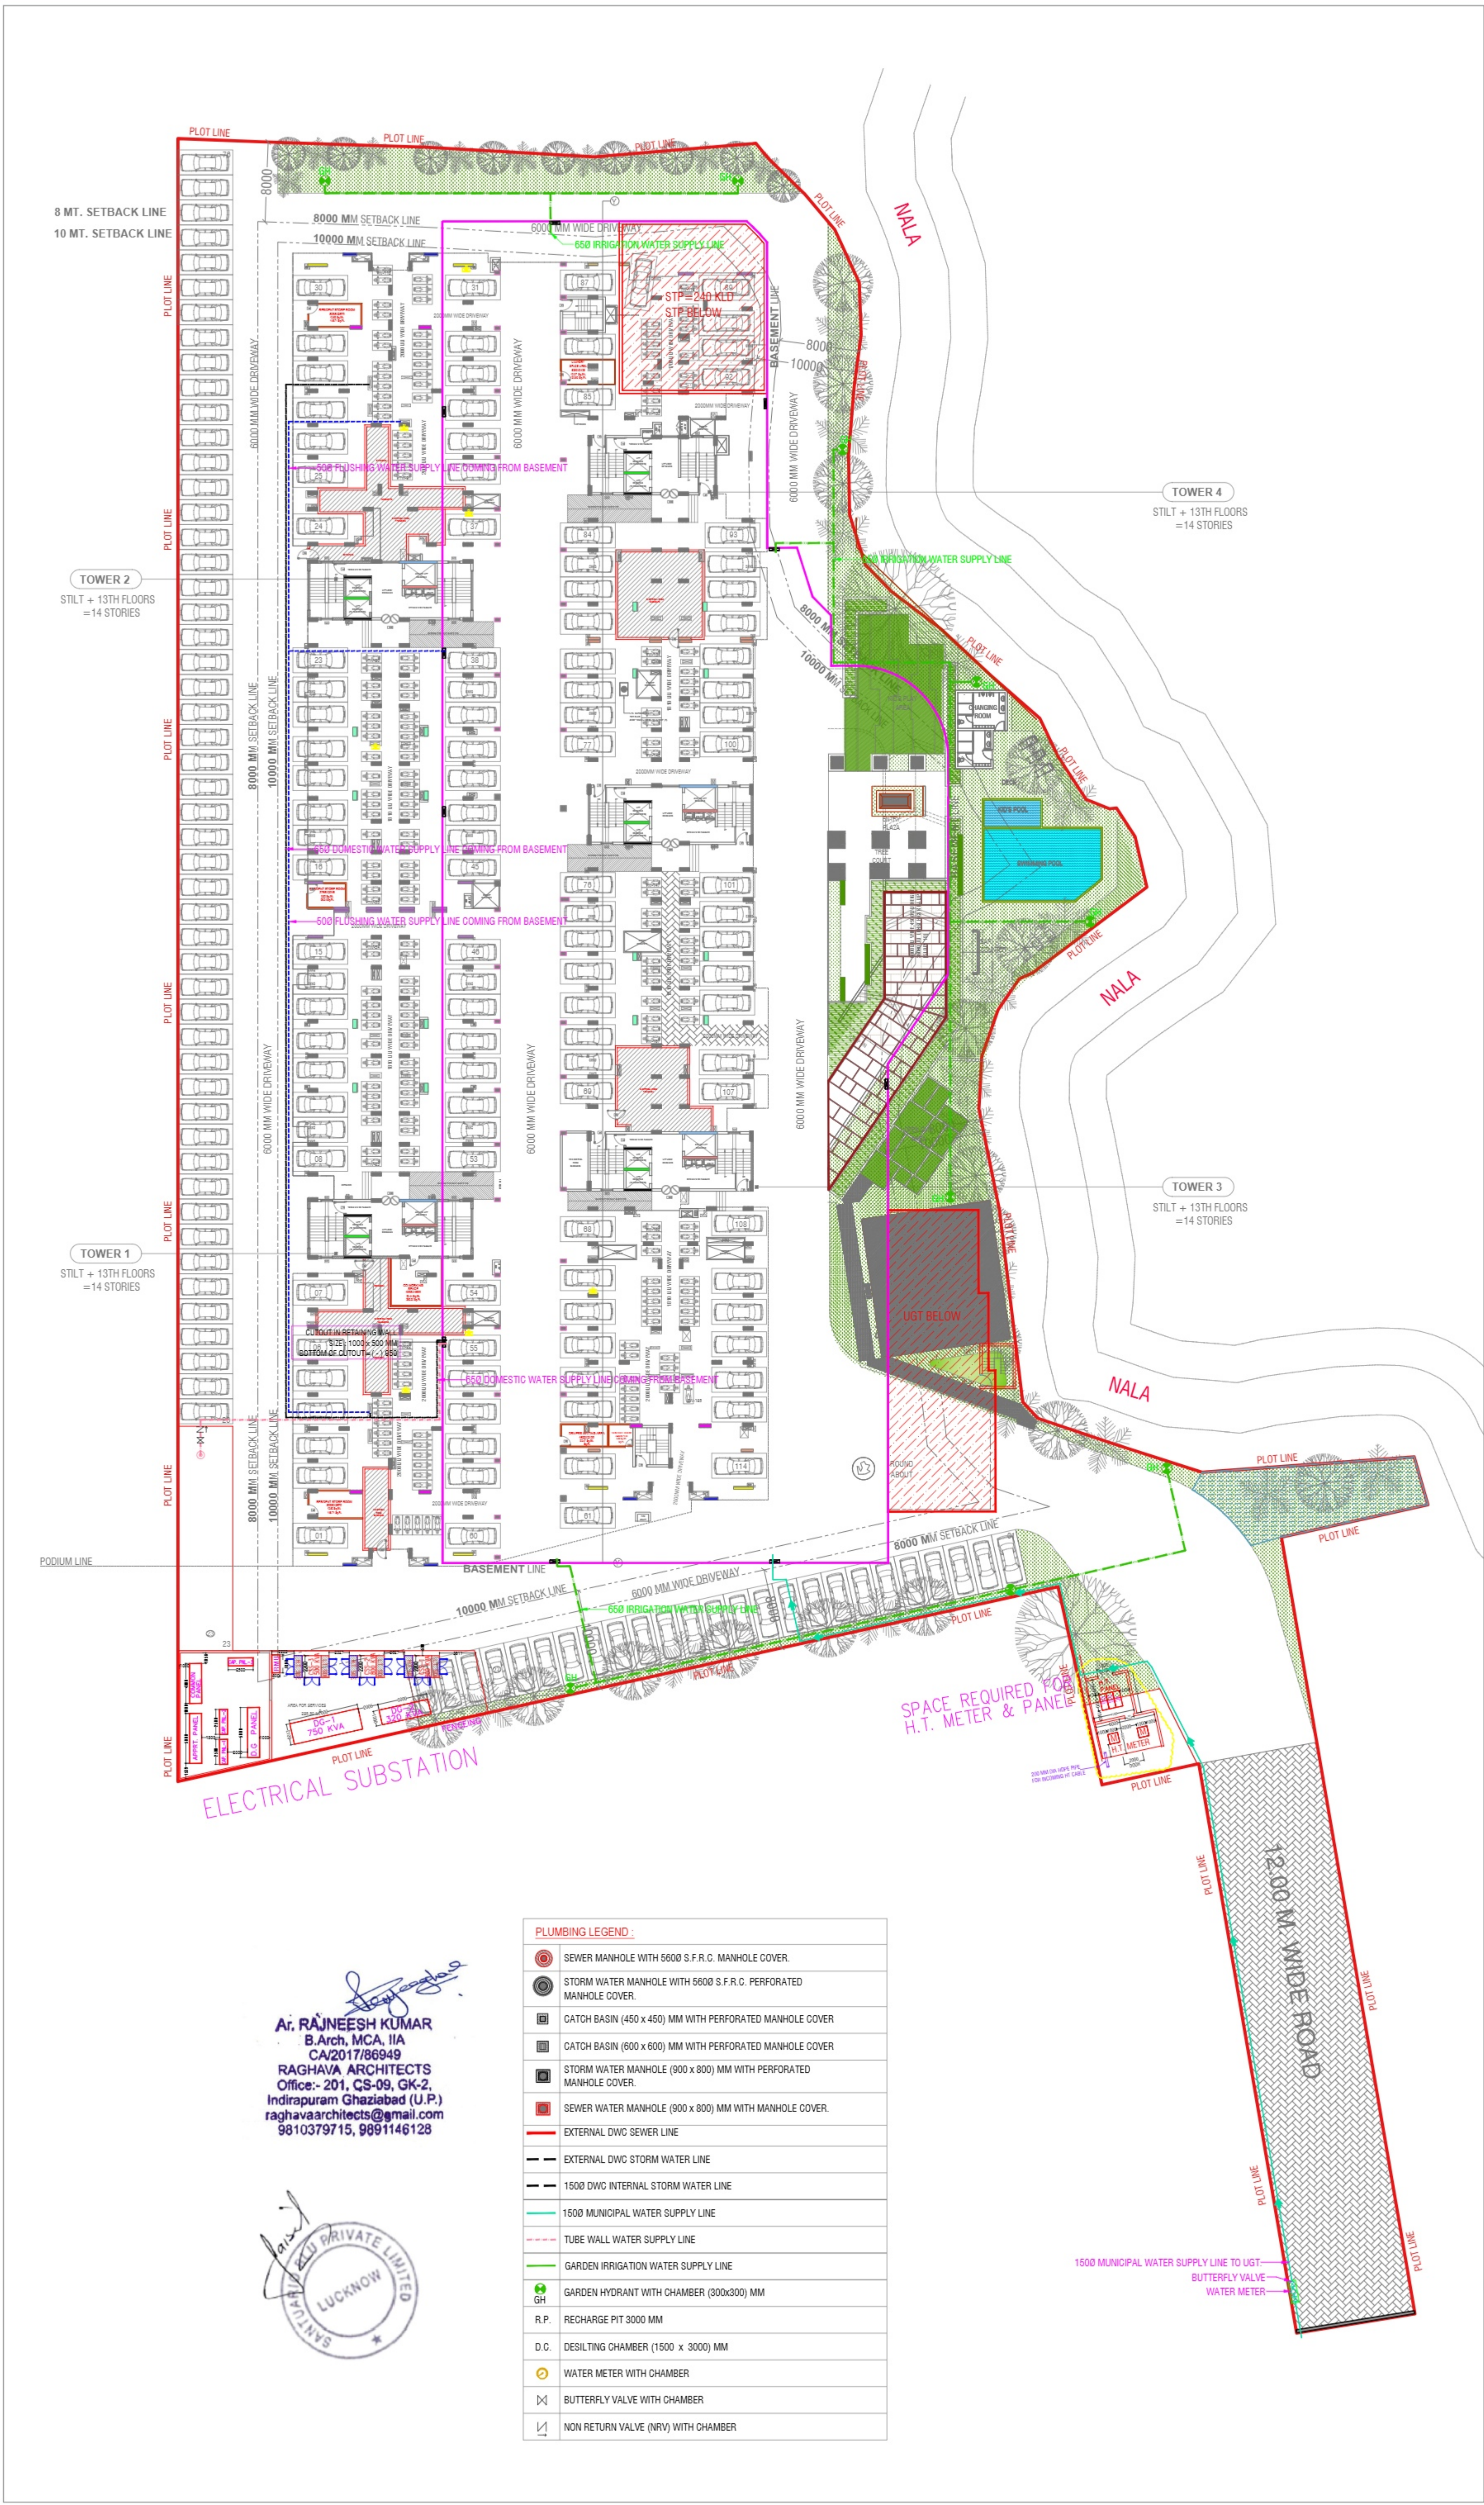

- SPECIAL NOTES :**
1. ALL DIMENSIONS ON THIS DRAWING ARE IN MM.
  2. ONLY WRITTEN DIMENSIONS ARE TO BE FOLLOWED. DRAWINGS SHOULD NOT BE SCALED UNDER ANY CIRCUMSTANCES.
  3. ALL MEASUREMENTS MUST BE CHECKED AND VERIFIED BY THE CONTRACTORS PRIOR TO EXECUTION OF WORK AT THE SITE.
  4. THIS DRAWING IS TO BE READ IN CONJUNCTION WITH ALL RELEVANT STRUCTURAL, SERVICES & FACILITY PLANNING DRAWINGS.
  5. ARCHITECTURAL DRAWINGS ARE TO BE FOLLOWED FOR THE LOCATION OF ALL STRUCTURAL MEMBERS & MASONRY WALLS. FOR SIZES & REINFORCEMENT DETAILS OF STRUCTURAL MEMBERS RELEVANT STRUCTURAL DRAWINGS ARE TO BE REFERRED.
  6. ANY DISCREPANCIES BETWEEN ARCHITECTURAL, STRUCTURAL AND SERVICES DRAWINGS MUST BE BROUGHT TO THE NOTICE OF THE ARCHITECTS IMMEDIATELY & PRIOR TO EXECUTION AT SITE.
  7. CO-ORDINATION WITH MEP SERVICES SUCH AS HVAC, PLUMBING, FIRE & ELECTRICAL ETC. IS THE RESPONSIBILITY OF THE CONTRACTORS.
  8. ALL MASONRY WALLS SHOULD BE ALIGNED WITH THE COLUMNS AS INDICATED ON THE PLAN IRRESPECTIVE OF THE POSITION AS CALCULATED WITH THE DIMENSIONING.
  9. CONTRACTOR WILL BE TAKEN THE APPROVAL OF SHOP DRAWING & ALL THE NECESSARY DOCUMENT FROM THE CONSULTANT.
  10. CONTRACTOR WILL BE WORKOUT THE QUANTITY AS APPROVED DRAWING & WILL BE TAKE THE NECESSARY APPROVAL BEFORE ORDER THE MATERIAL IF ANY EXTRA ITEM COMES.
  11. FOR DETAILS, REFER RELEVANT LARGE SCALE DETAIL DRGS. AS INDICATED.

| ISSUES |      |    |             |        |
|--------|------|----|-------------|--------|
| NO.    | DATE | BY | DESCRIPTION | PRINTS |
|        |      |    |             |        |
|        |      |    |             |        |
|        |      |    |             |        |

| REVISIONS |      |             |
|-----------|------|-------------|
| NO.       | DATE | DESCRIPTION |
|           |      |             |
|           |      |             |
|           |      |             |

| PURPOSE OF DRAWING |        |        |
|--------------------|--------|--------|
| G.F.C.             | F.I.O. | TENDER |

**PROJECT**  
PROPOSED AFFORDABLE GROUP HOUSING PROJECT  
OF Sri. Arvind Singh S/O Sri Sardaman Singh,  
Sri Ajay Singh S/O Sri Saurdhan Singh & Sri Aman Singh  
S/O Sri Saurdhan Singh for M/S YCL Infratech Private Limited  
Ref off MRL EAST DELHI, DELHI, 110092 at Khasra no.  
239,240,241,242,279/1,280/1,281/2,282/2 of  
village Karampur chaudhary & Khasra no.4/1, 6/1, 6/2,  
7/1,7/2,8/1,10,5 nagaria kaam, Dist. & Tehsil Bareilly, U.P.

**CLIENT**  
**ONE OAK GROUP HOUSING**

**ARCHITECT :**  
  
**VASTULIPI**  
ARCHITECTS, DESIGNERS & PLANNERS  
vastulipi@gmail.com, 07800396999  
www.vastulipi.com

**SERVICES CONSULTANT:**  
  
**PARADISE CONSULTANT**  
PLOT NO. 129, POCKET-2, BASEMENT  
JASOLA VIHAR, NEW DELHI-110025  
PH : 011- 46132800, 41030619  
E-mail: mep@paradiseconsultants.com

**DRAWING TITLE :**

**EXTERNAL SITE PLAN**  
**WATER SUPPLY LAYOUT**

Scale : 1:250 (A1) Drawn by : SHIV CHARAN  
Date : 11/11/2025 Checked by : KULDEEP  
Project no : ----- Approved by : NAFEEES

Drawing no : **PL-PC-GH-ONE OAK-WS-101**

REVISION **RO**

| PLUMBING LEGEND :                                                                   |                                                                   |
|-------------------------------------------------------------------------------------|-------------------------------------------------------------------|
|  | SEWER MANHOLE WITH 5600 S.F.R.C. MANHOLE COVER.                   |
|  | STORM WATER MANHOLE WITH 5600 S.F.R.C. PERFORATED MANHOLE COVER.  |
|  | CATCH BASIN (450 x 450) MM WITH PERFORATED MANHOLE COVER          |
|  | CATCH BASIN (600 x 600) MM WITH PERFORATED MANHOLE COVER          |
|  | STORM WATER MANHOLE (900 x 800) MM WITH PERFORATED MANHOLE COVER. |
|  | SEWER WATER MANHOLE (900 x 800) MM WITH MANHOLE COVER.            |
|  | EXTERNAL DWG SEWER LINE                                           |
|  | EXTERNAL DWG STORM WATER LINE                                     |
|  | 1500 DWG INTERNAL STORM WATER LINE                                |
|  | 1500 MUNICIPAL WATER SUPPLY LINE                                  |
|  | TUBE WALL WATER SUPPLY LINE                                       |
|  | GARDEN IRRIGATION WATER SUPPLY LINE                               |
|  | GARDEN HYDRANT WITH CHAMBER (300x300) MM                          |
|  | R.P. RECHARGE PIT 3000 MM                                         |
|  | D.C. DESILTING CHAMBER (1500 x 3000) MM                           |
|  | WATER METER WITH CHAMBER                                          |
|  | BUTTERFLY VALVE WITH CHAMBER                                      |
|  | NON RETURN VALVE (NRV) WITH CHAMBER                               |

**Ar. RAJNEESH KUMAR**  
B.Arch, MCA, IIA  
CA/2017/86949  
**RAGHAVA ARCHITECTS**  
Office: 201, CS-09, GK-2,  
Indirapuram Ghaziabad (U.P.)  
raghavaarchitects@gmail.com  
9810379715, 9891146128

