
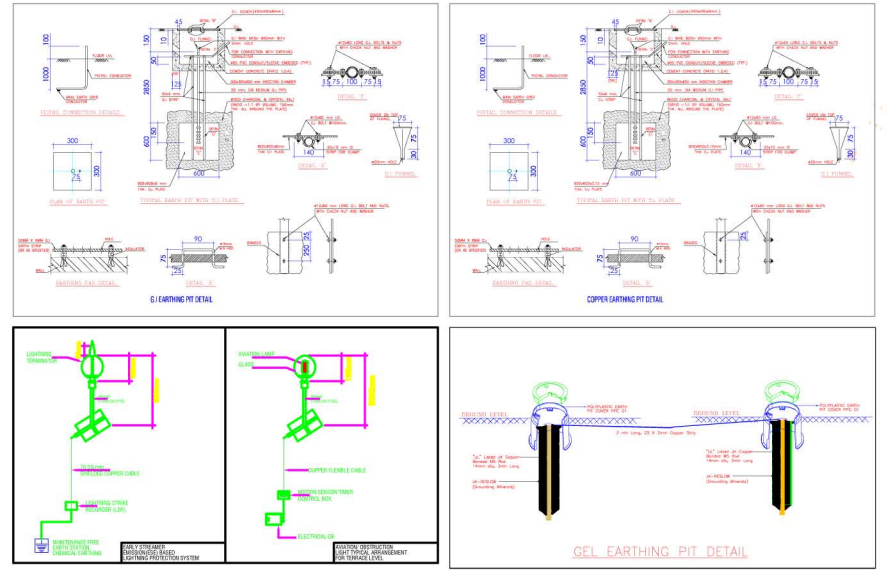


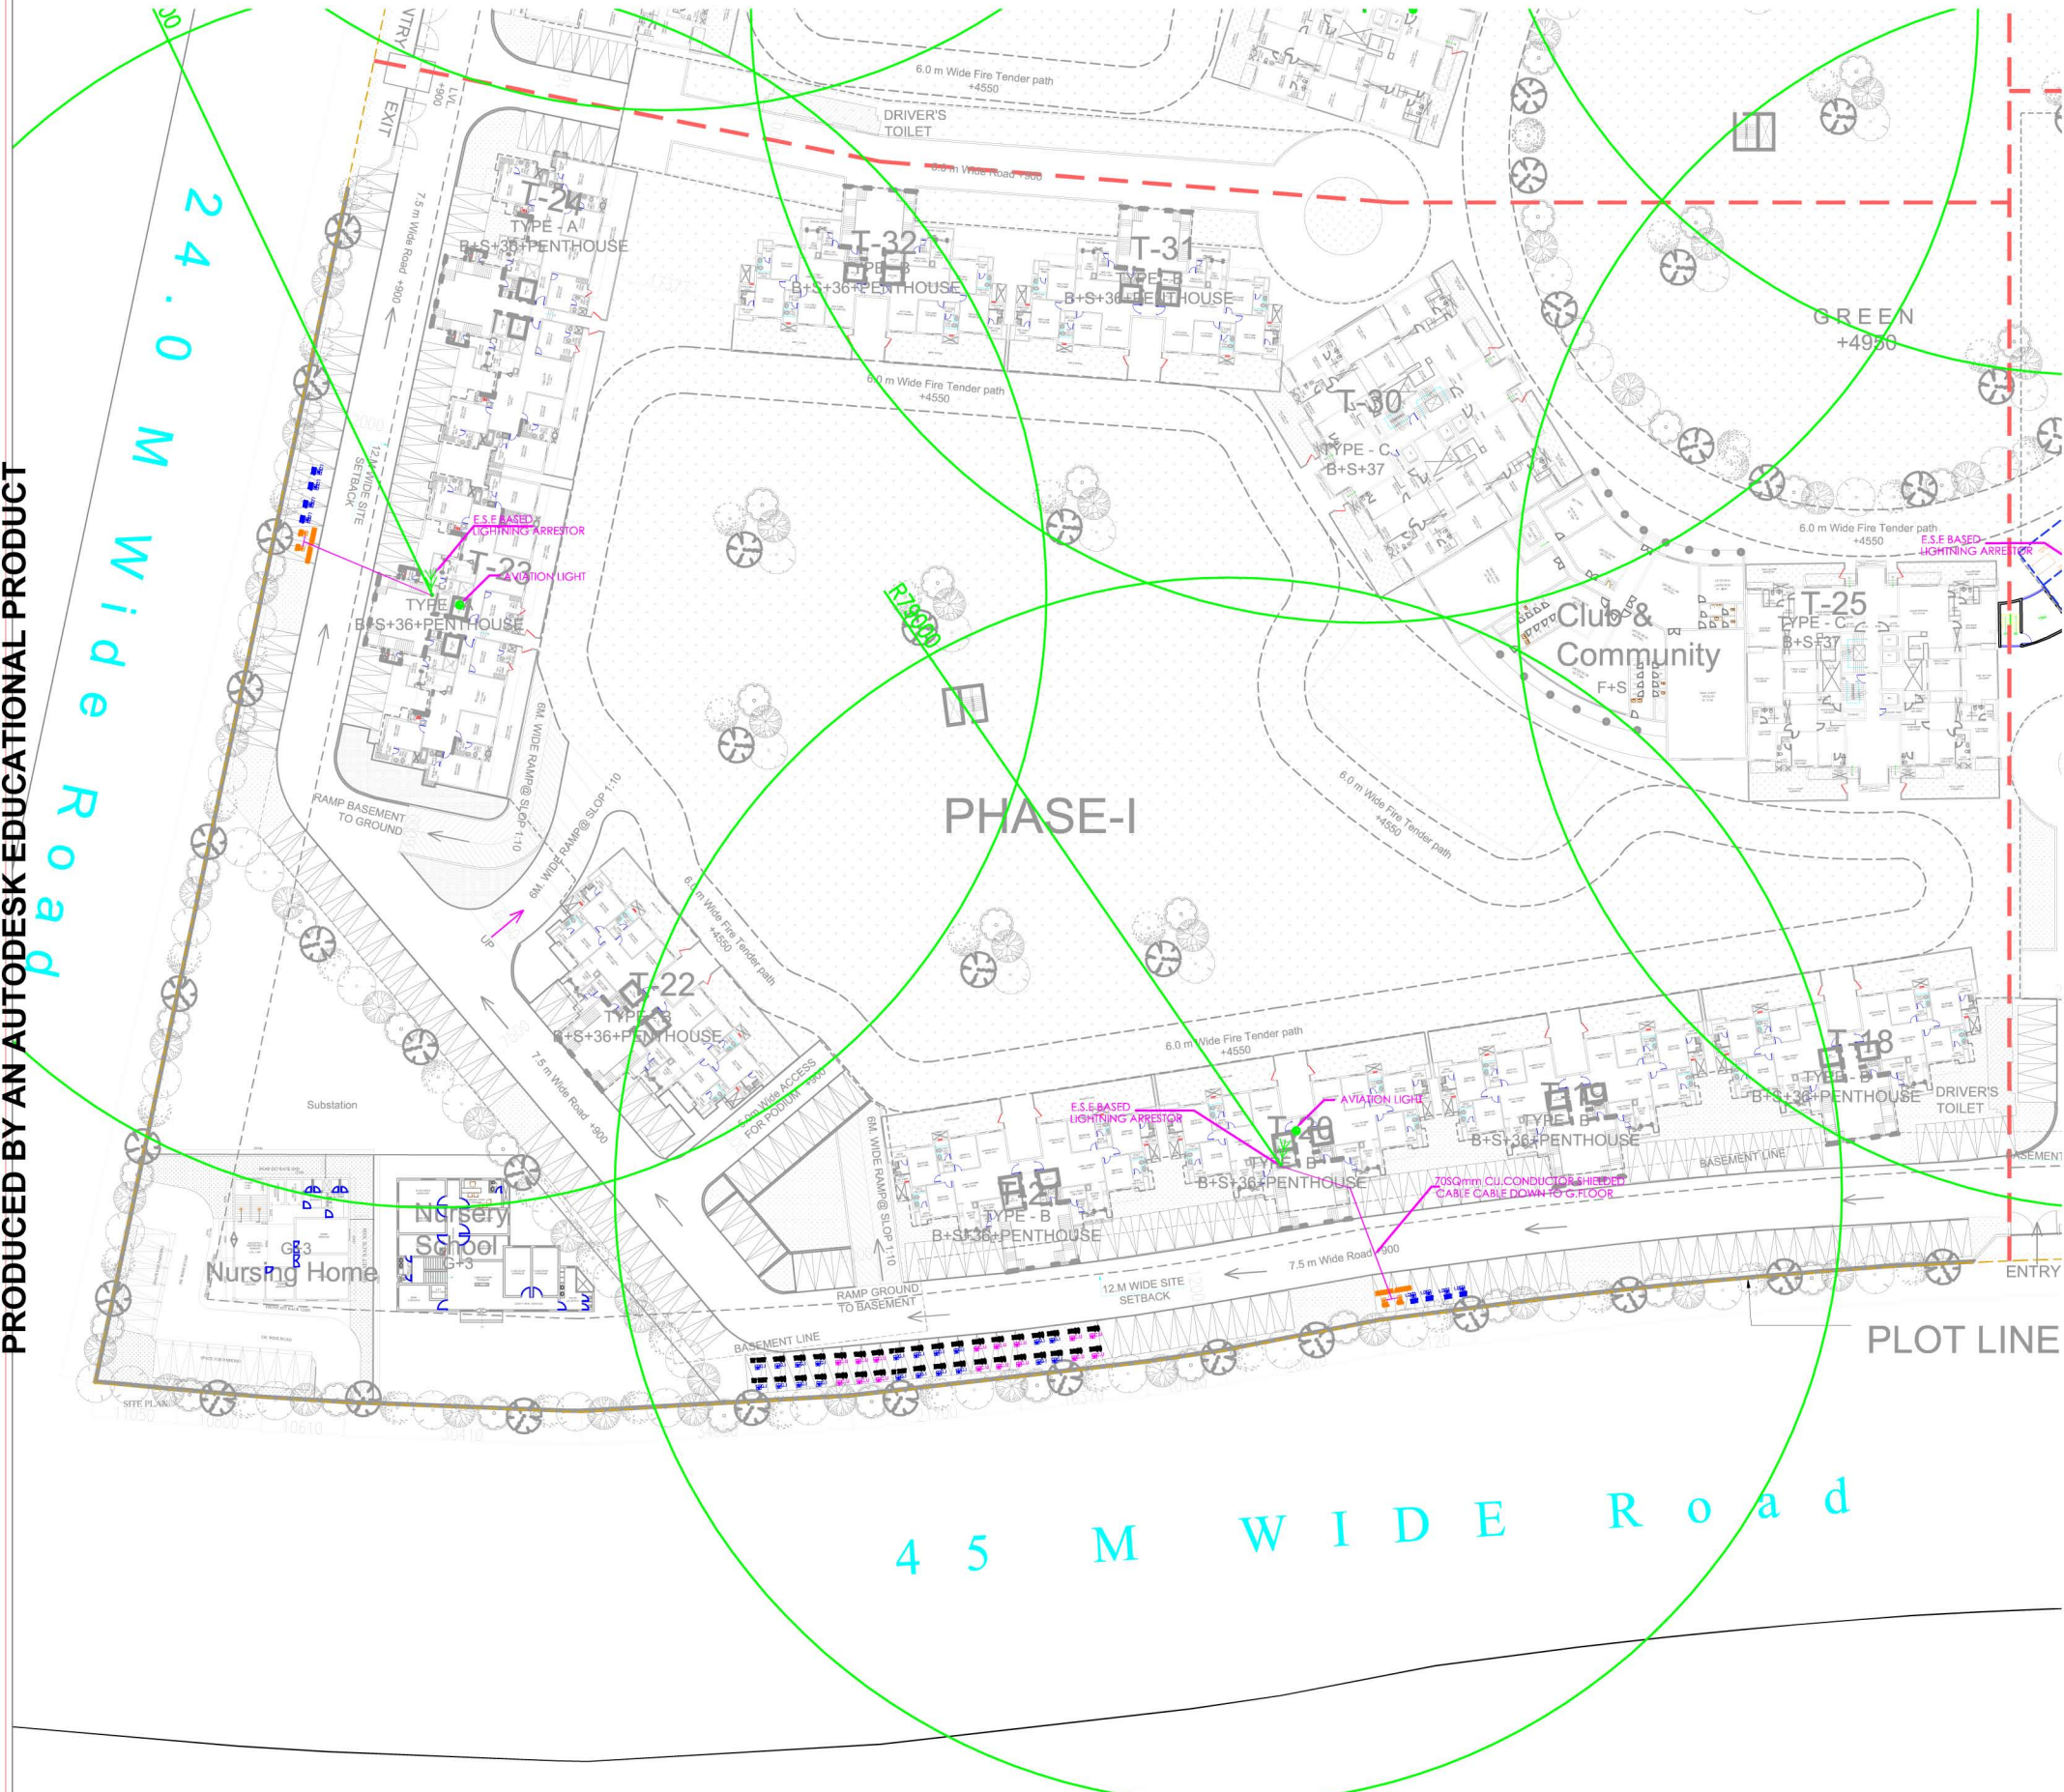

ELECTRICAL LEGEND	
SYMBOL	DESCRIPTION
	G.I. EARTHING PIT
	C.U. EARTHING PIT
	GEL/CHEMICAL EARTHING PIT
	LIGHTNING ARRESTOR
	70S Qmm CU CONDUCTOR SHIELDED CABLE
	AVIATION LIGHT

MEP Services Consultants
PARADISE CONSULTANTS
Plot No. 103, Basement,
Near Living Style Mall, Jasola Vihar
LANDLINE+91-11-29943601, 461332800, 41030619
New Delhi - 110025
E-mail: paradiseconsultants@gmail.com
website: www.paradiseconsultants.com

ELECTRICAL SITE PLAN

SCALE -	DATE -	DRW NO -
1:500@A0	16.08.16	
DRAWN BY	CHECKED BY	
T.S.RAWAT	ANIL	

