


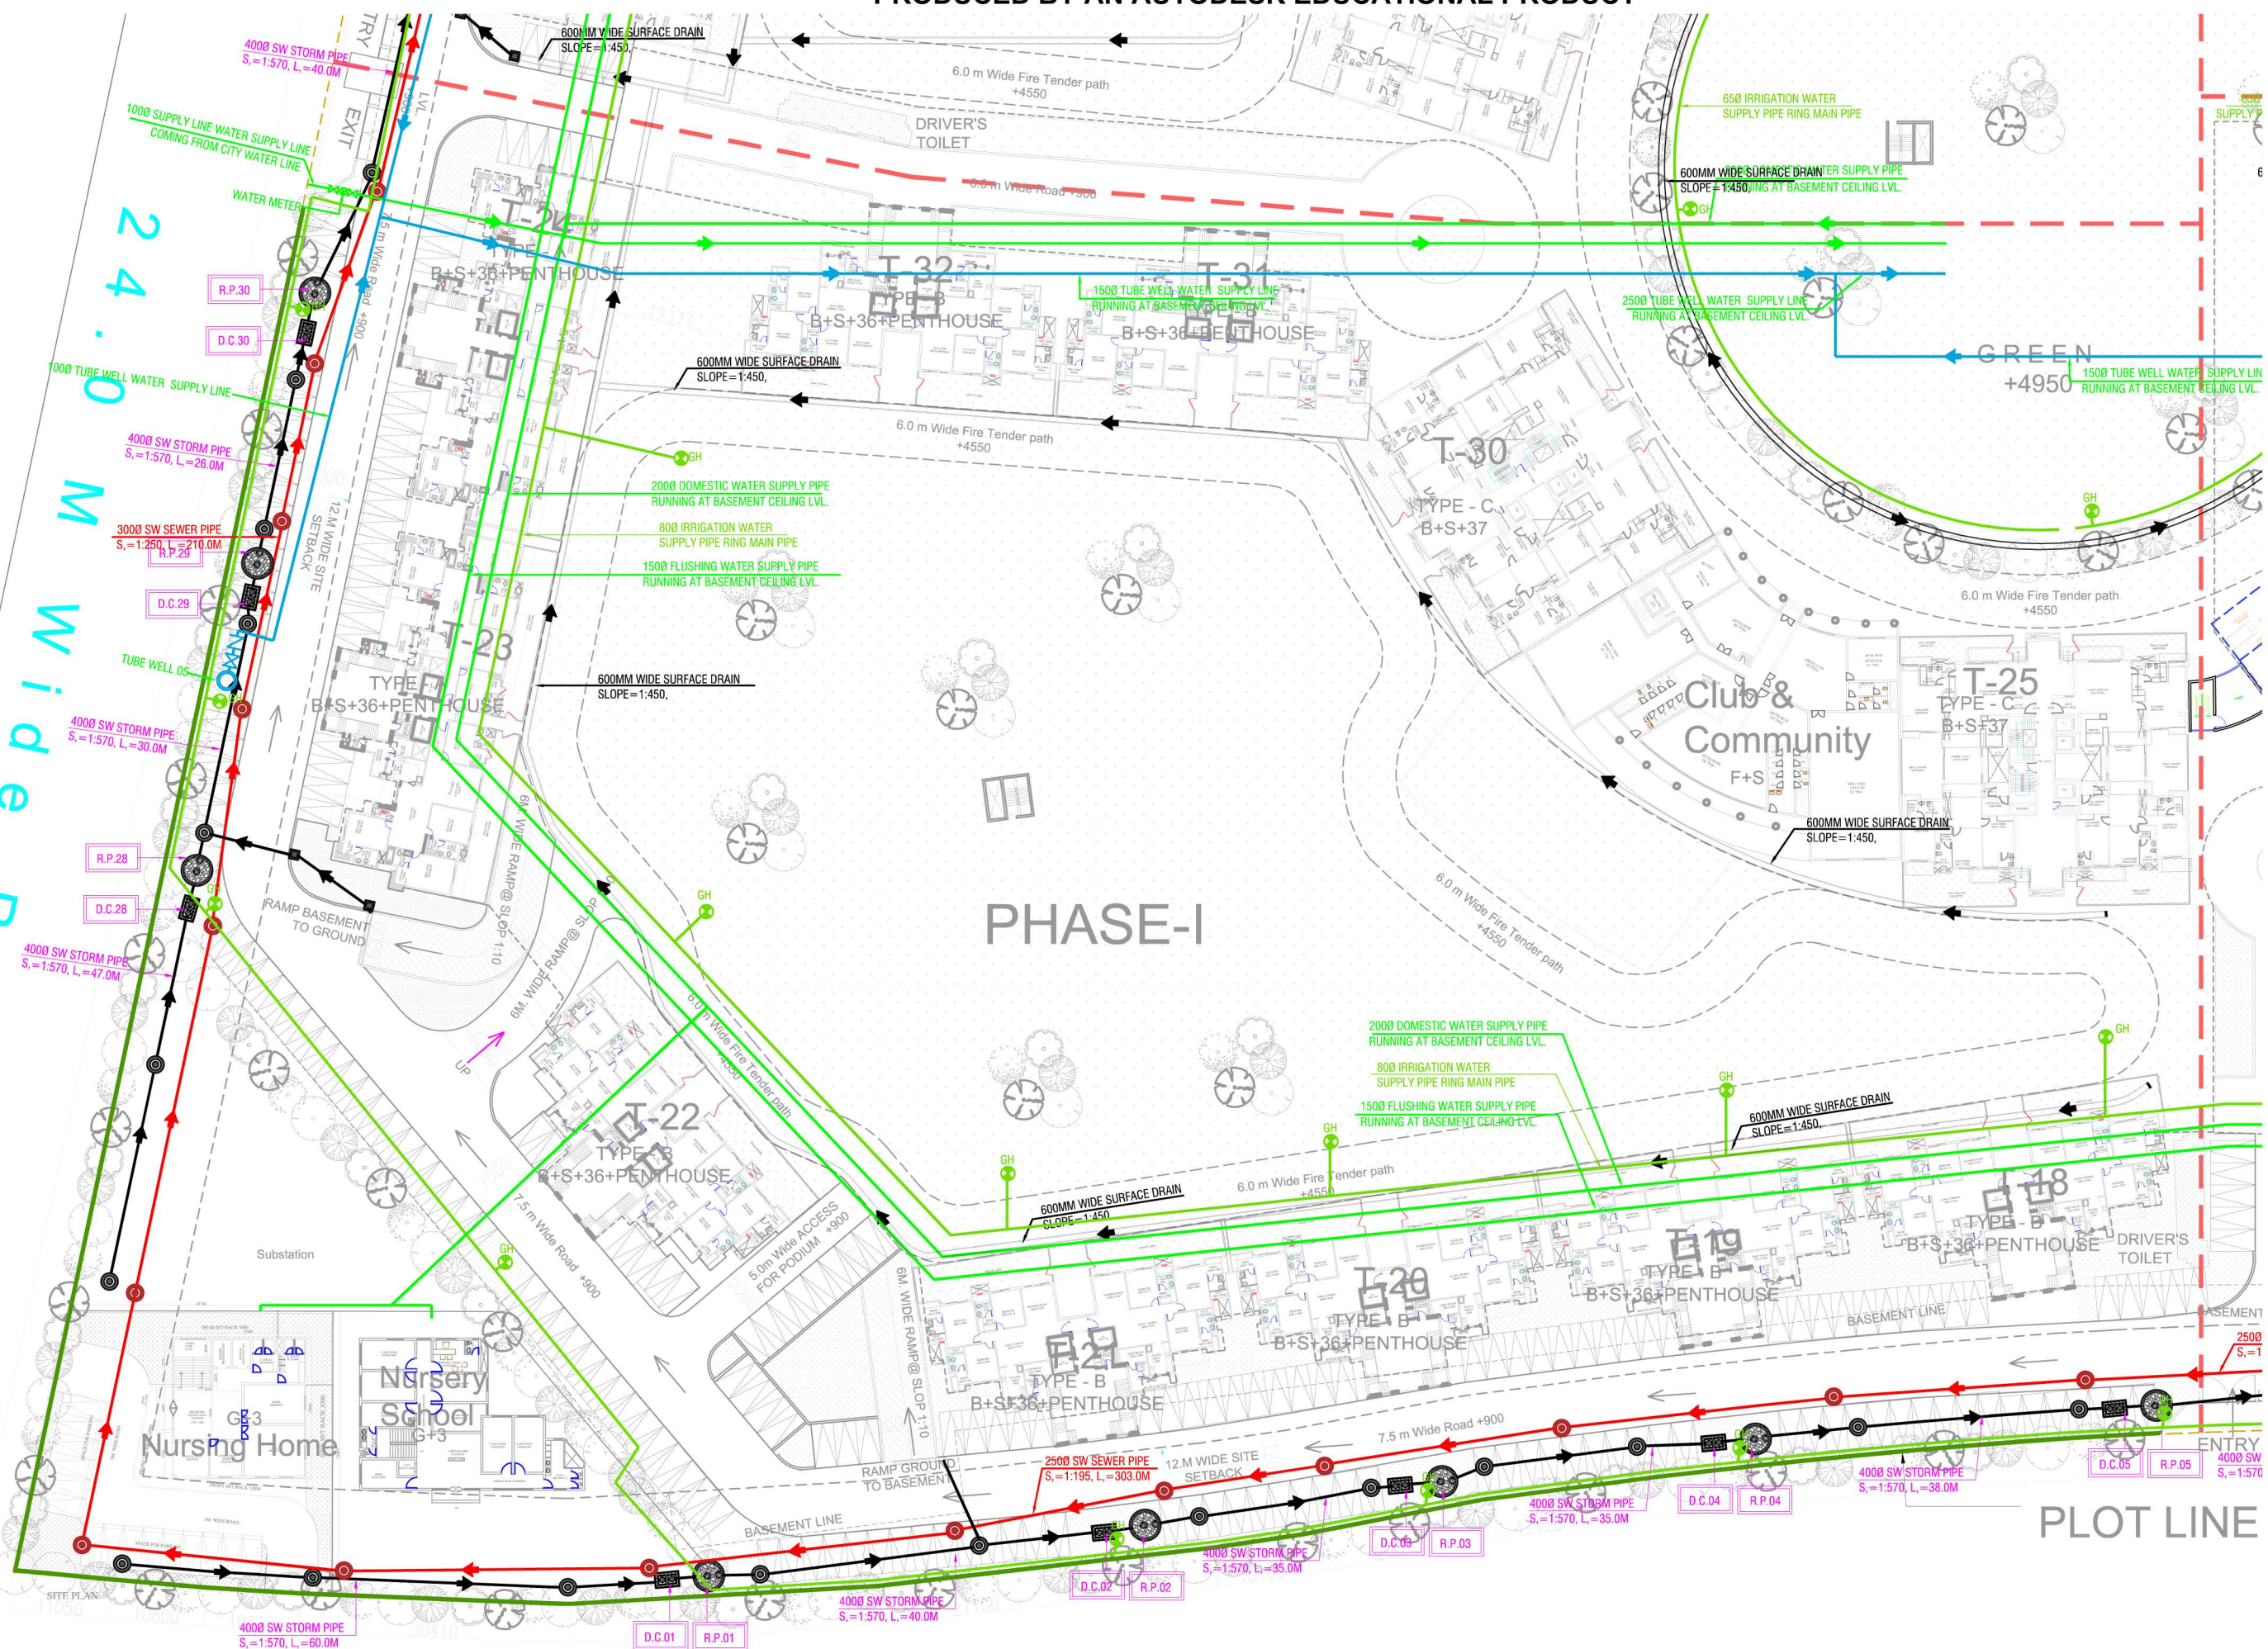

1. ALL DIMENSIONS ON THIS DRAWING ARE IN MM.
2. ONLY THIN WALL DIMENSIONS ARE TO BE FOLLOWED. DRAWINGS SHOULD NOT BE SCALED UNDER ANY CIRCUMSTANCES.
3. ALL MEASUREMENTS MUST BE CHECKED AND VERIFIED BY THE CONTRACTORS PRIOR TO EXECUTION OF WORK AT THE SITE.
4. THIS DRAWING IS TO BE READ IN CONJUNCTION WITH ALL RELEVANT STRUCTURAL, SERVICES & FACILITY PLANNING DRAWINGS.
5. ARCHITECTURAL DRAWINGS ARE TO BE FOLLOWED FOR THE LOCATION OF ALL STRUCTURAL MEMBERS & MASONRY WALLS. FOR SIZES & REINFORCEMENT DETAILS OF STRUCTURAL MEMBERS RELEVANT STRUCTURAL DRAWINGS ARE TO BE REFERRED.
6. ANY DISCREPANCIES BETWEEN ARCHITECTURAL, STRUCTURAL AND SERVICES DRAWINGS MUST BE BROUGHT TO THE NOTICE OF THE ARCHITECT IMMEDIATELY & PRIOR TO EXECUTION AT SITE.
7. CO-ORDINATION WITH THE SERVICES SUCH AS HVAC, PLUMBING & ELECTRICAL ETC. IS THE RESPONSIBILITY OF THE CONTRACTORS.
8. ALL MASONRY WALLS SHOULD BE ALIGNED WITH THE COLUMNS AS INDICATED ON THE PLAN IRRESPECTIVE OF THE POSITION AS CALCULATED WITH THE DIMENSIONING.
9. FOR DETAILS, REFER RELEVANT LARGE SCALE DETAIL DRGS. AS INDICATED.

NEW SYMBOLS LEGEND	
	SEWER MANHOLE WITH SADD MANHOLE COVER.
	CATCH BASIN BOX X 600
	STORM WATER MANHOLE WITH SADD PERFORATED MANHOLE COVER
	GARDEN FOUNTAIN
	EXTERNAL FIRE HYDRANT (75x60x250) MM
	EXTERNAL SEWER LINE
	EXTERNAL STORM WATER LINE (GSA AS / DESIGN CHART)
	GENERAL IRRIGATION WATER SUPPLY LINE (GSA MENTION IN LAYOUT)
	EXTERNAL FIRE HYDRANT LINE (GSA MENTION IN LAYOUT)
	DOMESTIC WATER SUPPLY
	FLUSHING LINE WATER SUPPLY
	MUNICIPAL LINE WATER SUPPLY
	TIRE WELL WATER SUPPLY LINE
	RECHARGE PIT (GROUND / MM)
	DEAL TWO-CHAMBER (TPOO X 2000MM)

MEP Services Consultants
PARADISE CONSULTANTS
Plot No. 103, Basement,
Near Living Style Mall, Jasola Vihar
LANDLINE +91-11-29943601,461332800,41030619
New Delhi - 110025
E-mail: paradiseconsultants@gmail.com
website: www.paradiseconsultants.com

EXTERNAL SITE PLAN

WATER SUPPLY LAYOUT

SCALE - 1:500@A0	DATE - 16.08.16	DRG NO.	
DRAWN BY T S RAWAT	CHECKED BY ANIL		