


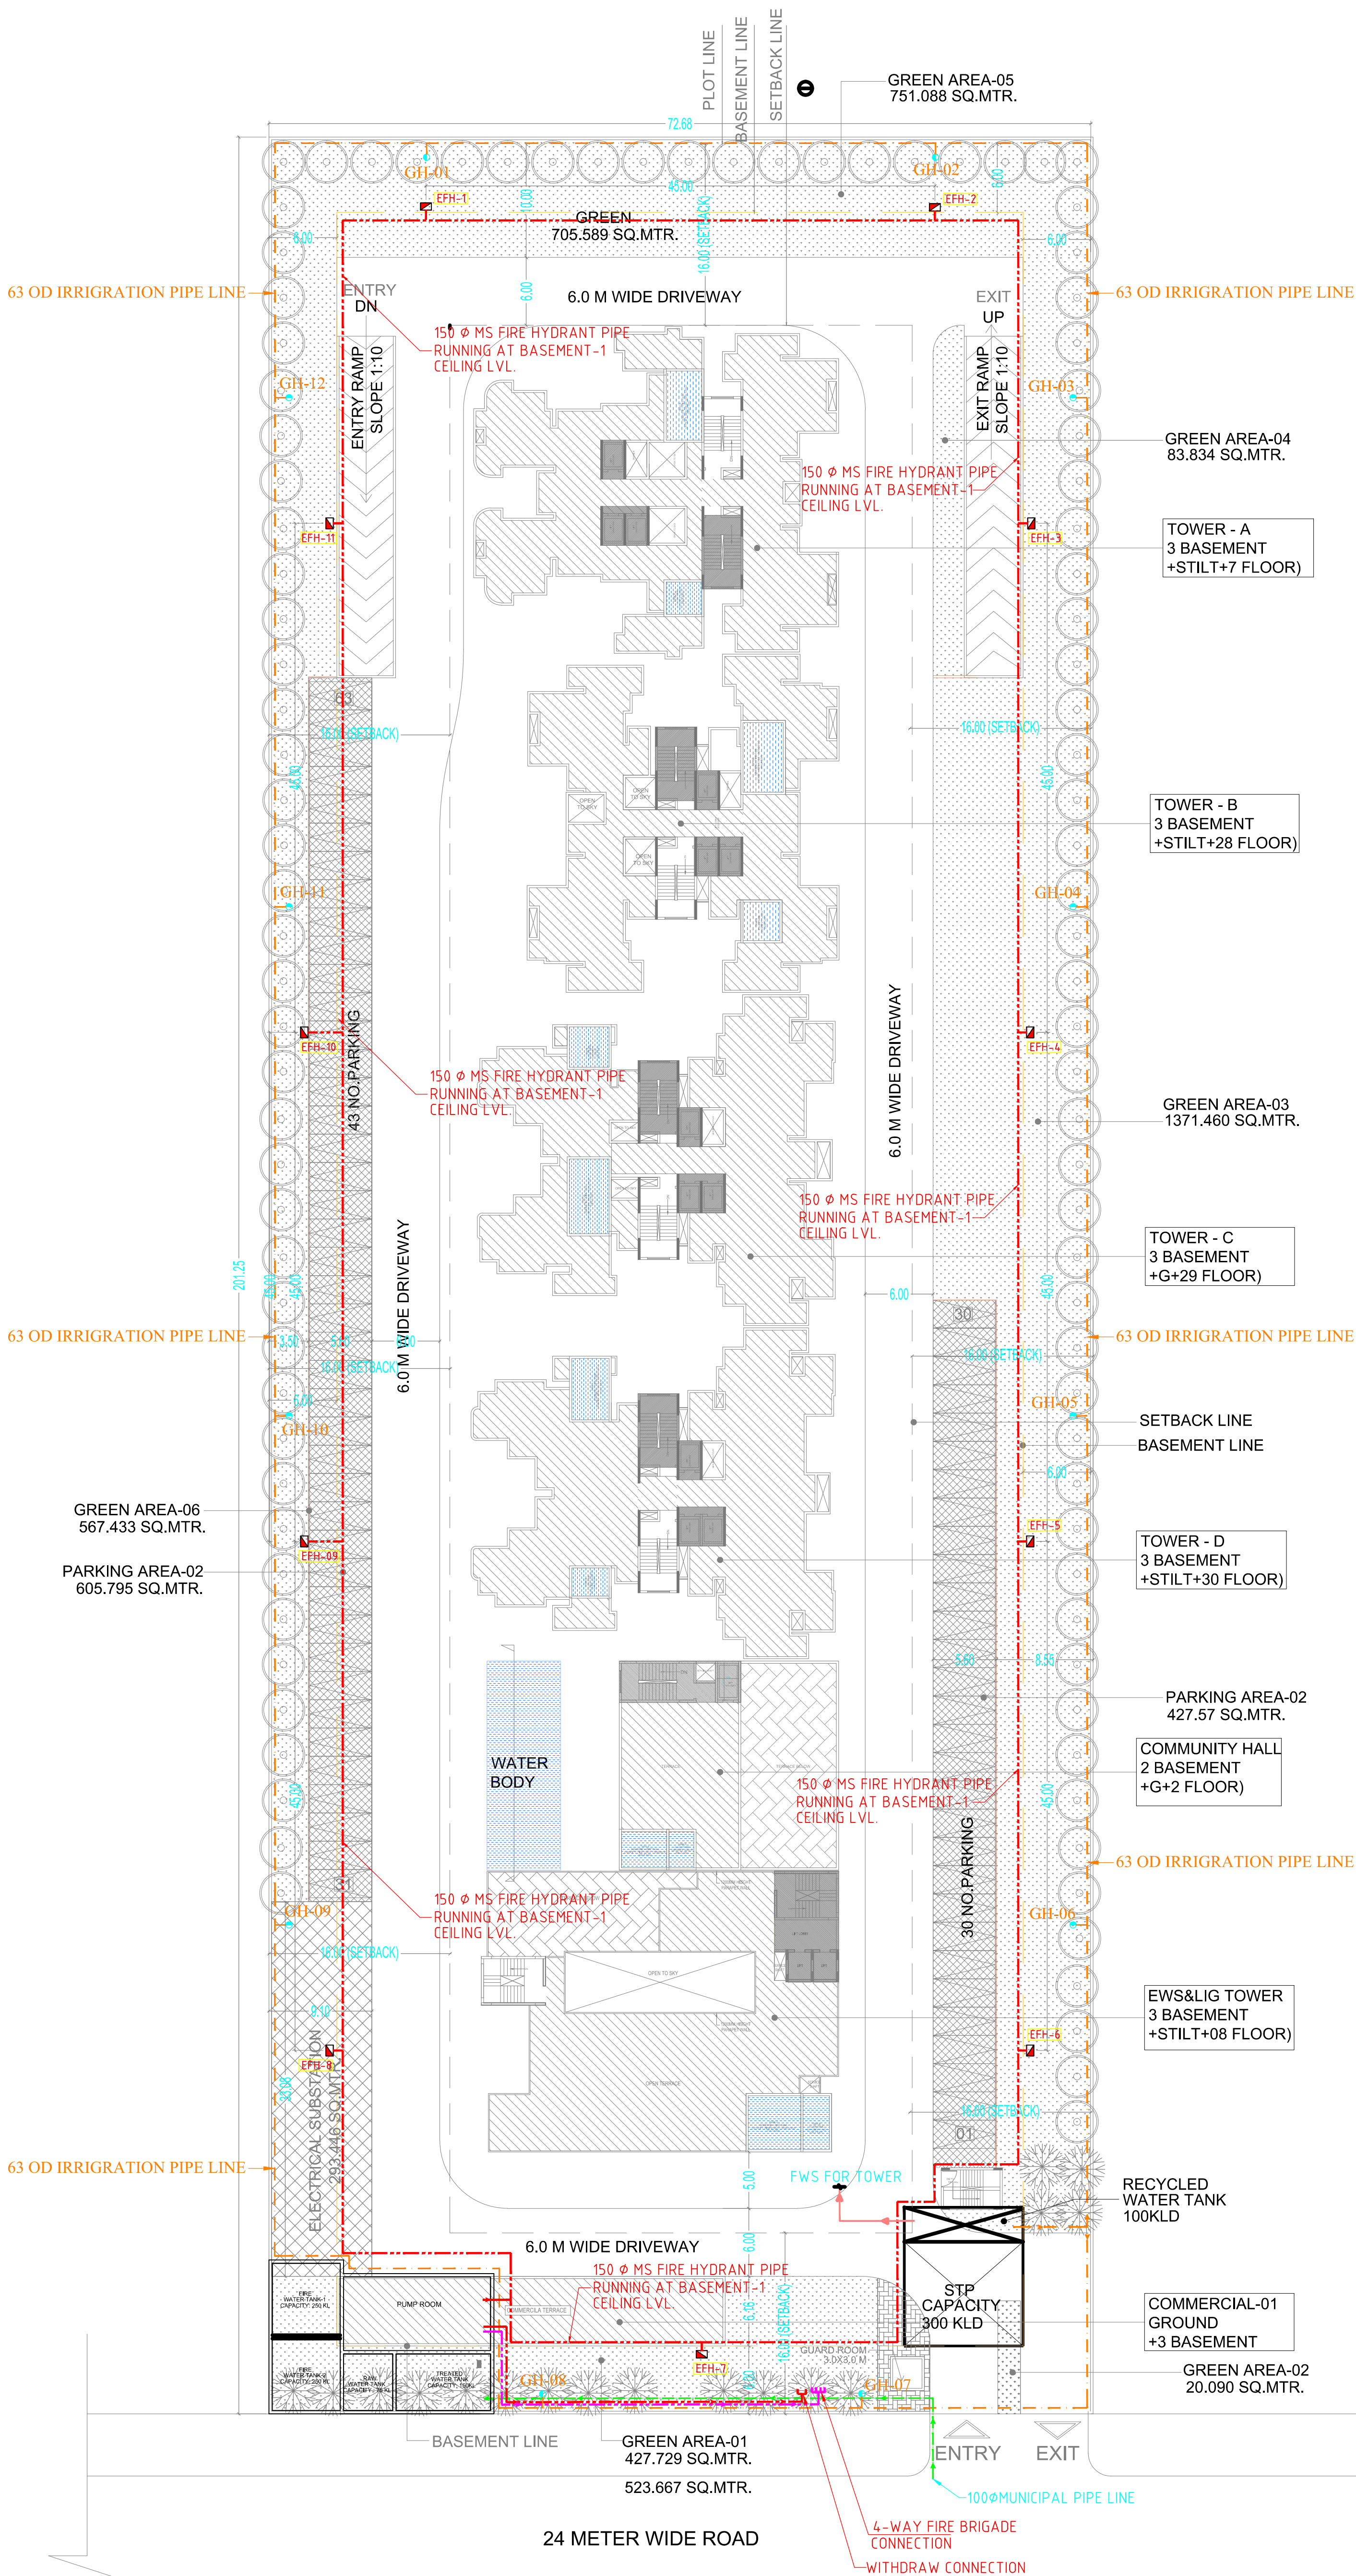

WATER SUPPLY LEGEND		
S.NO.	DESCRIPTION	LEGEND
1.	GARDEN IRRIGATION LINE	---
2.	EXTERNAL FIRE HYDRANT LINE	---
5.	MUNICIPAL WATER SUPPLY LINE	---
8.	GARDEN HYDRANT	GH
9.	EXTERNAL FIRE HYDRANT	EFH

SITE PLAN
WATER SUPPLY DRAWING (DUAL PLUMBING)

DRAWING NO. : PL-SP05-602

SERVICES CONSULTANTS :-

SAVIRAM

ENGINEERING CONSULTANTS PRIVATE LIMITED

Regd off : 22, Duplex-I, Rajat Vihar, Sector-62, Noida-201301

Telephone:(+91-120)-2494877, 4261877,4261878 Fax:(+91-120)-2494877

E-mail: saviramnoida@gmail.com