
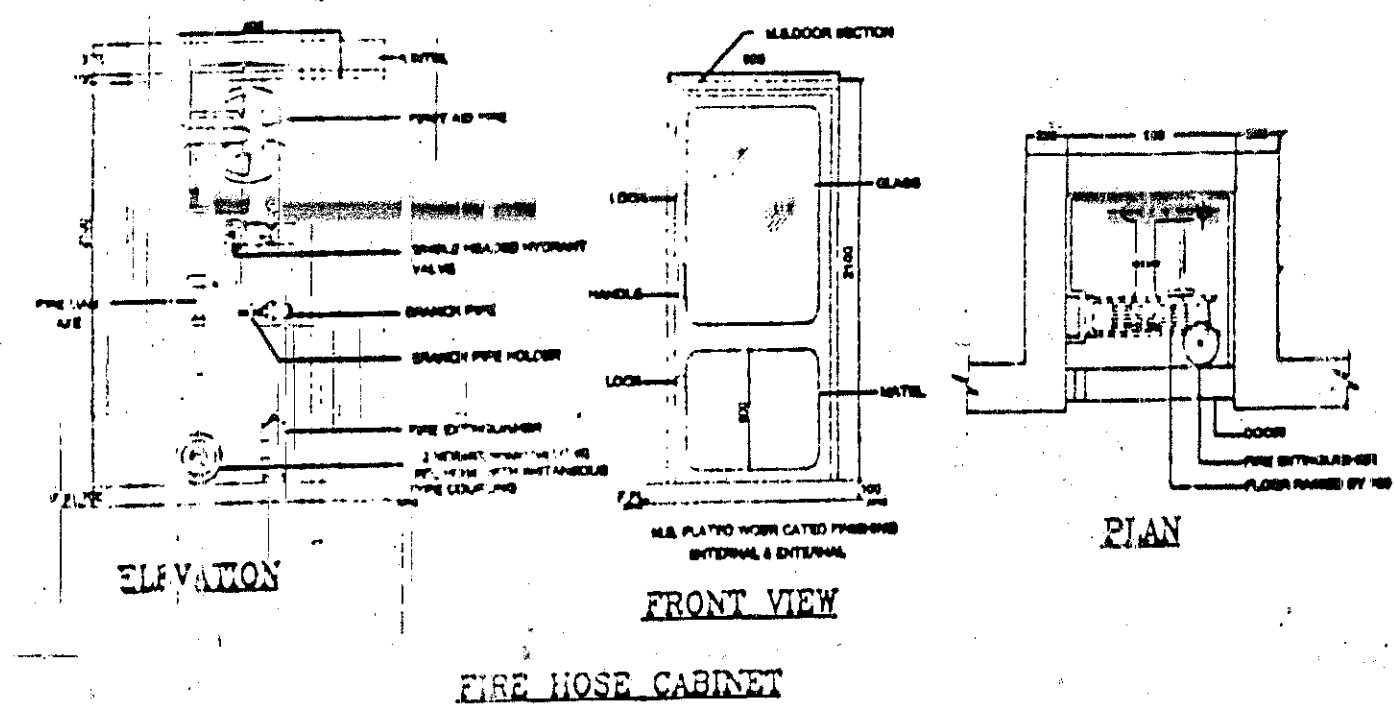
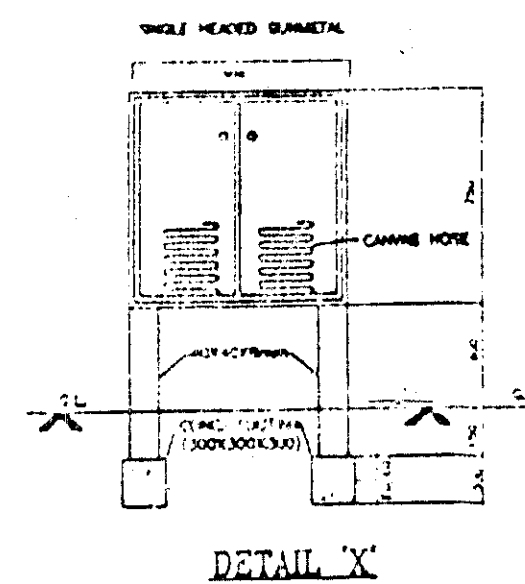


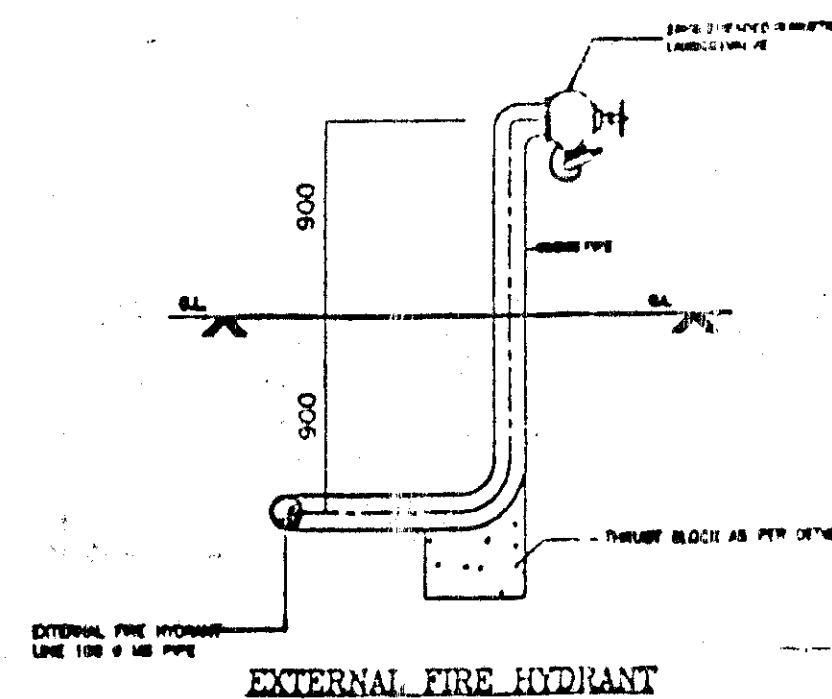

LEGEND

SYMBOL	DESCRIPTION
	5Ltr fire valve
	9Ltr fire valve
	13kg capacity water CO2 type fire extinguisher
	9Ltr capacity CO2 type fire extinguisher
	MANUAL FIRE ALARM BELL
	FIRE ALARM BELL
	2-WAY FIRE BRIGADE INLET CONNECTION

FIRE FIGHTING NOTES

NOTE :- AS PER NATIONAL BUILDING CODE OF INDIA PART-4, FIRE AND LIFE SAFETY REVISED NOV.-2005

- TYPE-OF BUILDING
RESIDENTIAL BUILDING
1. FIRE EXTINGUISHER
4.5 Kg CO2
9 Ltrs Cap. Water Co2
 2. HOSE REEL
 3. DN-COMMER SYSTEM
 4. MANUALLY OPERATED ELCTRIC FIRE ALARM SYSTEMS
 5. OVER HEAD FIRE TANK CAP.=25,000 Ltrs
- P-1- TERRACE PUMP
CAP.=900Lpm
HEAD=35M
6. 100mm AS SINGLE OUTLET LINDING VALVES

सी एच ओ
माजियाबाद

सी एच ओ
माजियाबाद

architects:-

architects combine


ARCHITECTS, ENGINEERS AND PLANNERS,
41 - COMMUNITY CENTRE, EAST OF KAILASH,
NEW DELHI -110065

owner:-
OFFICE OF CHIEF ENGINEER
GHAZIABAD DEVELOPMENT
AUTHORITY



E.W.S HOUSING
AT PRATA P VIHAR, SECTOR-11
GHAZIABAD

title:
FIRE FIGHTING DRAWING
STILT FLOOR & TYPICAL FLOOR


DATE:- MARCH-2009 SCALE: 1: 200
PROJ. EP:- P.S. SAHNI CHACKER- PUNAI
DRG. NO:- FF-01

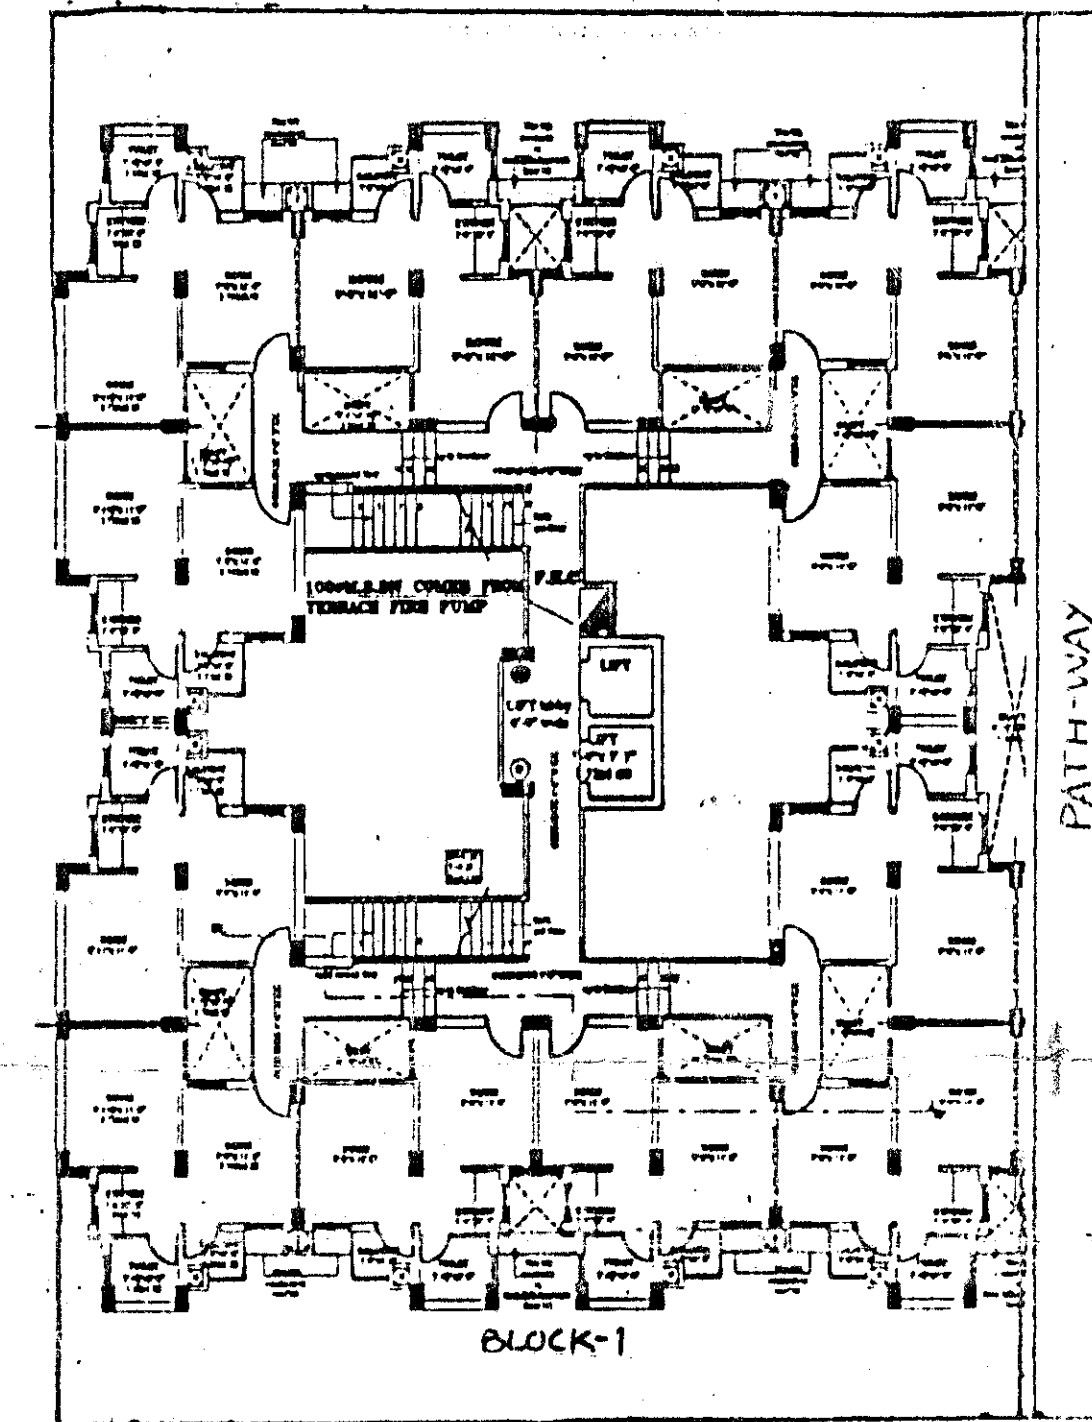

PARK

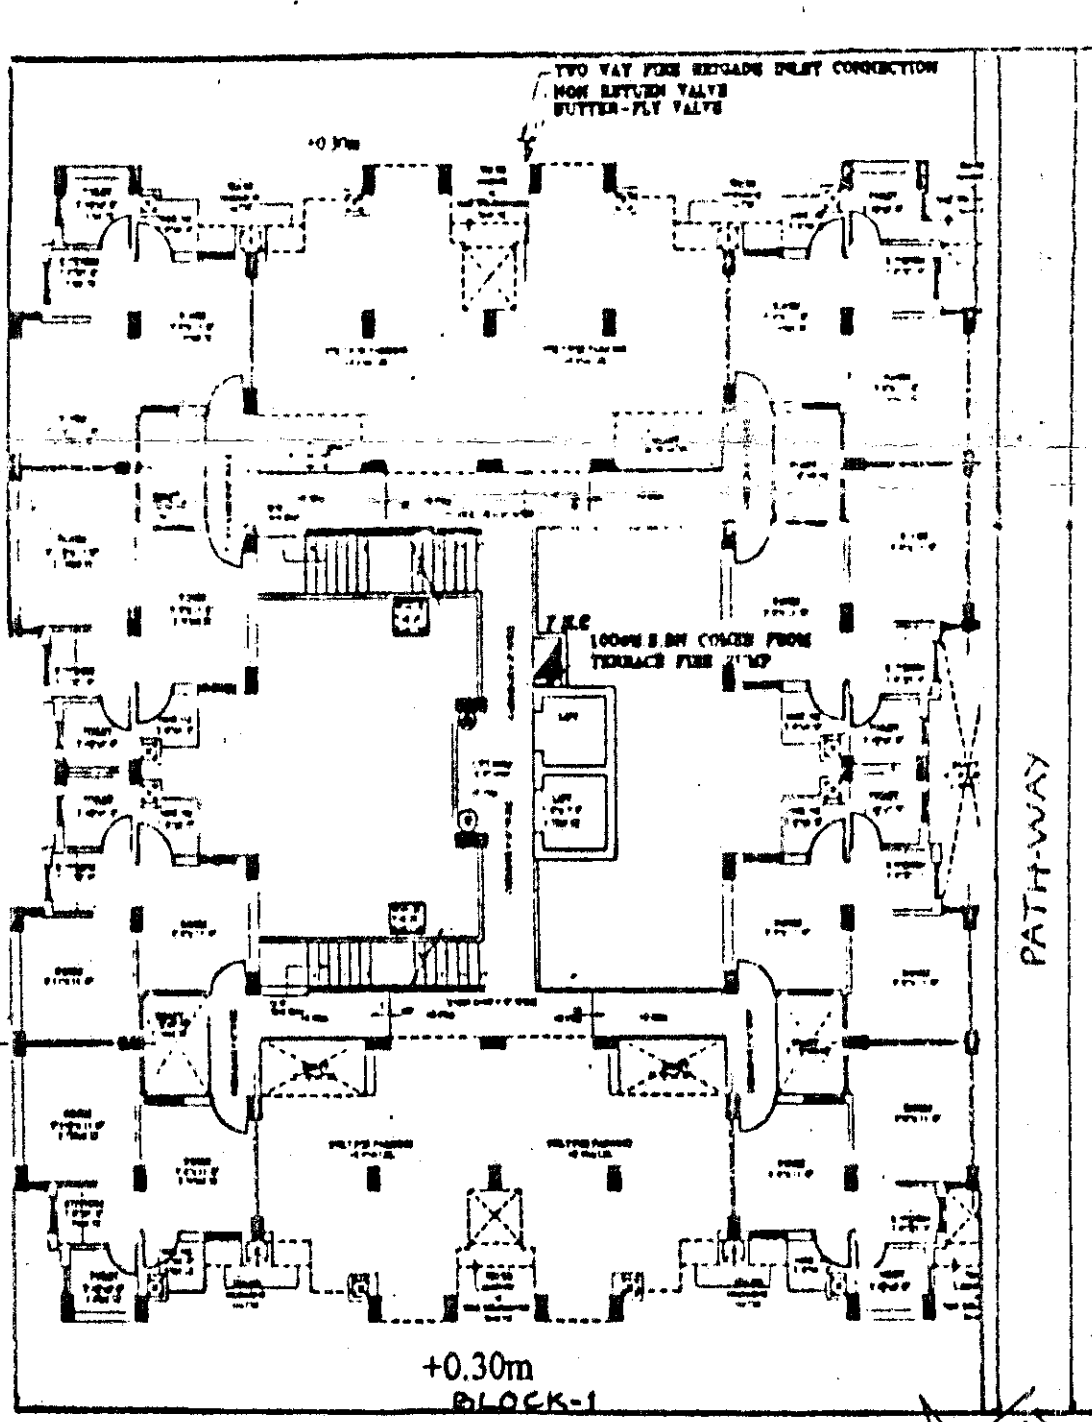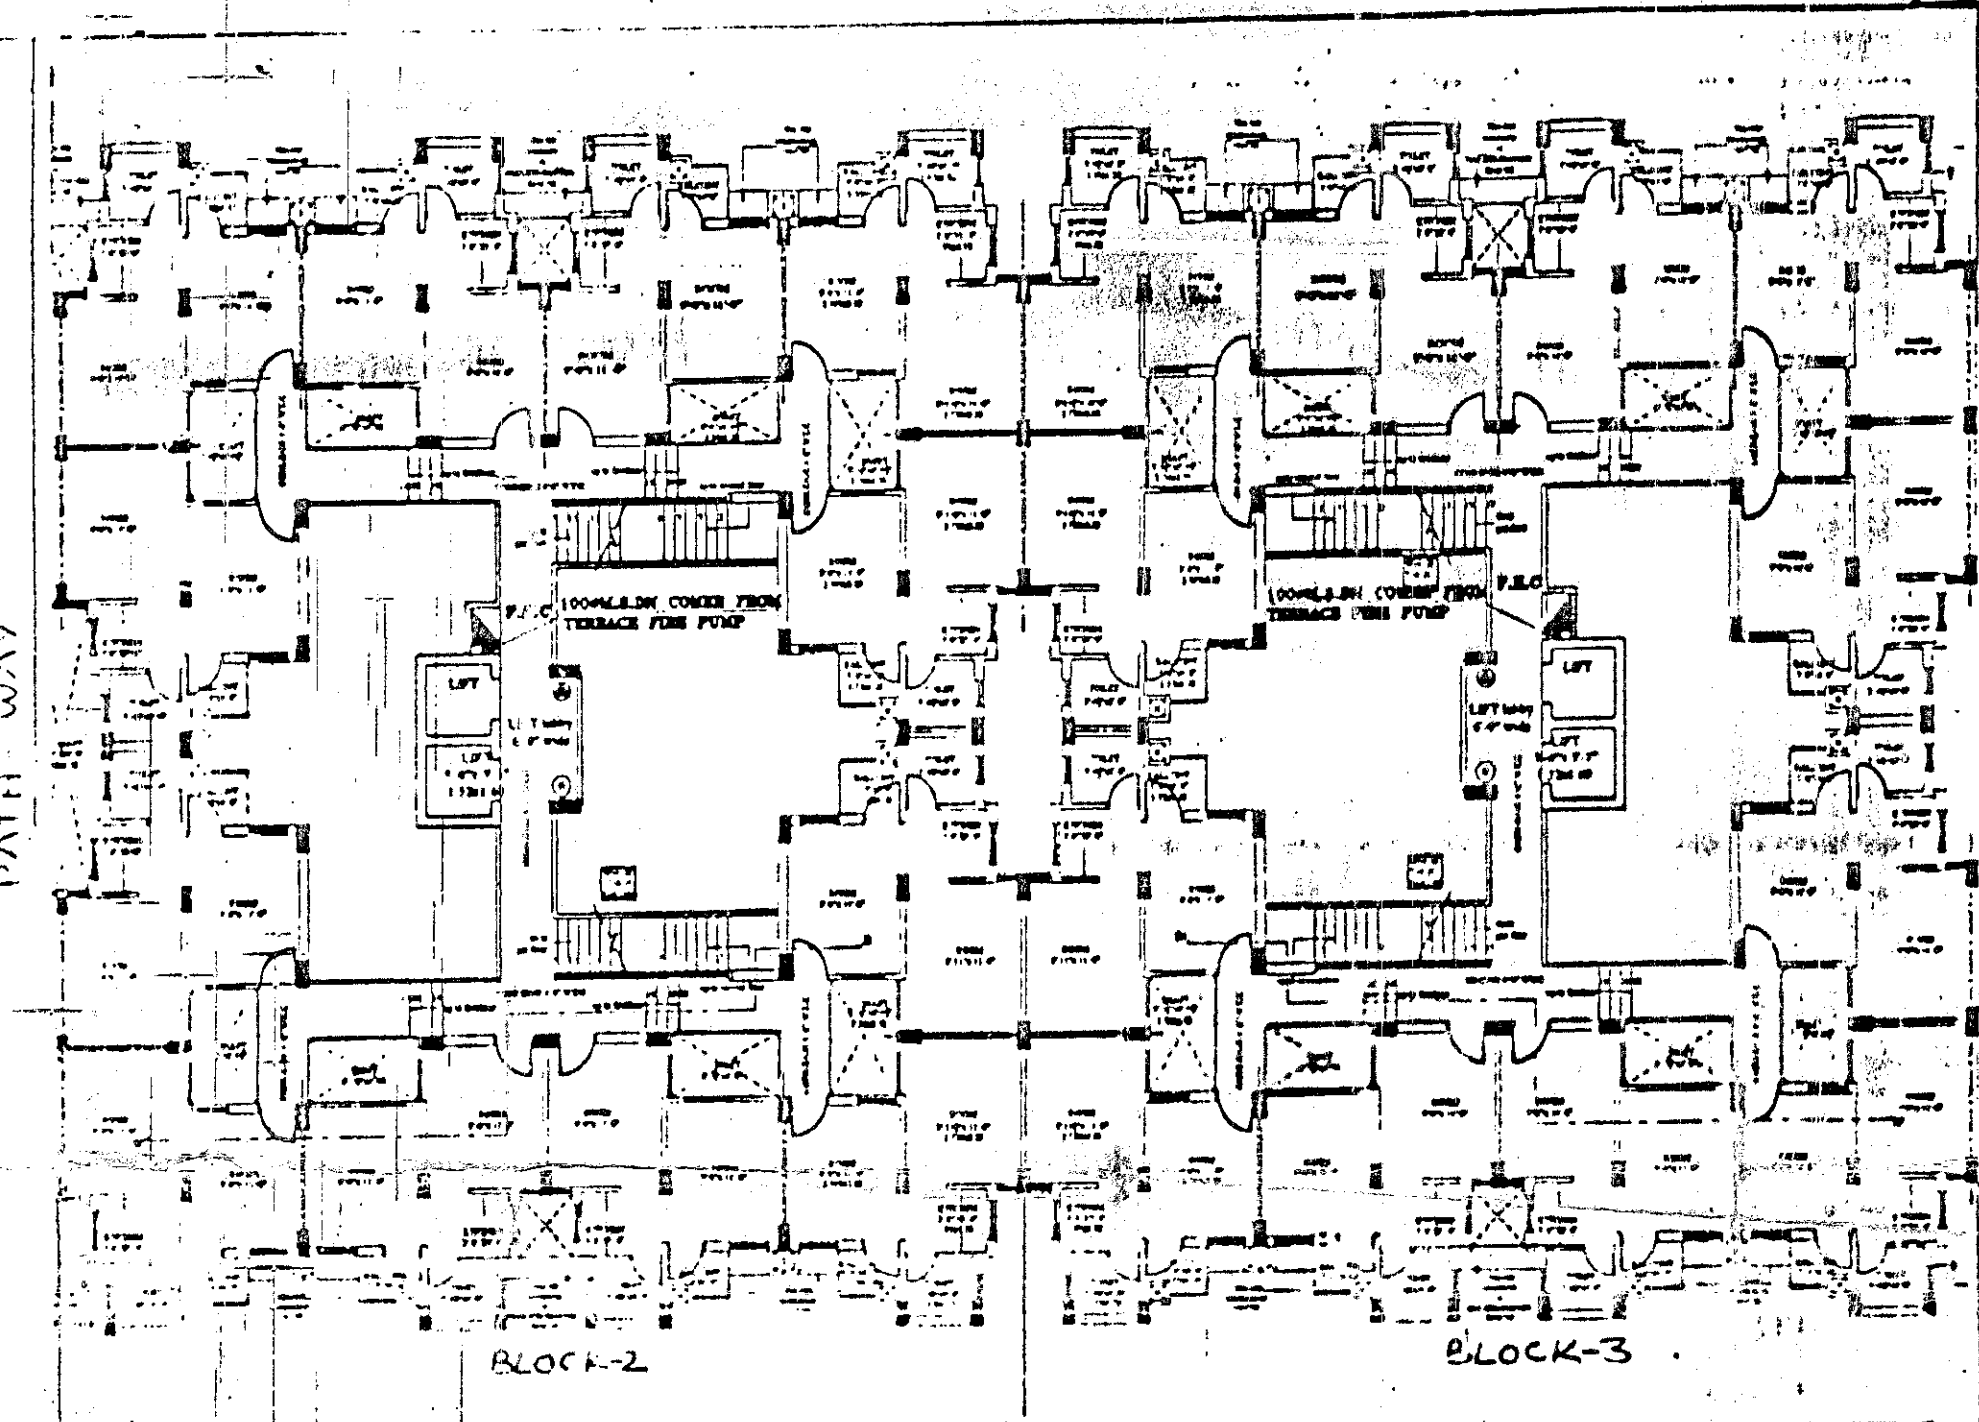

PARK

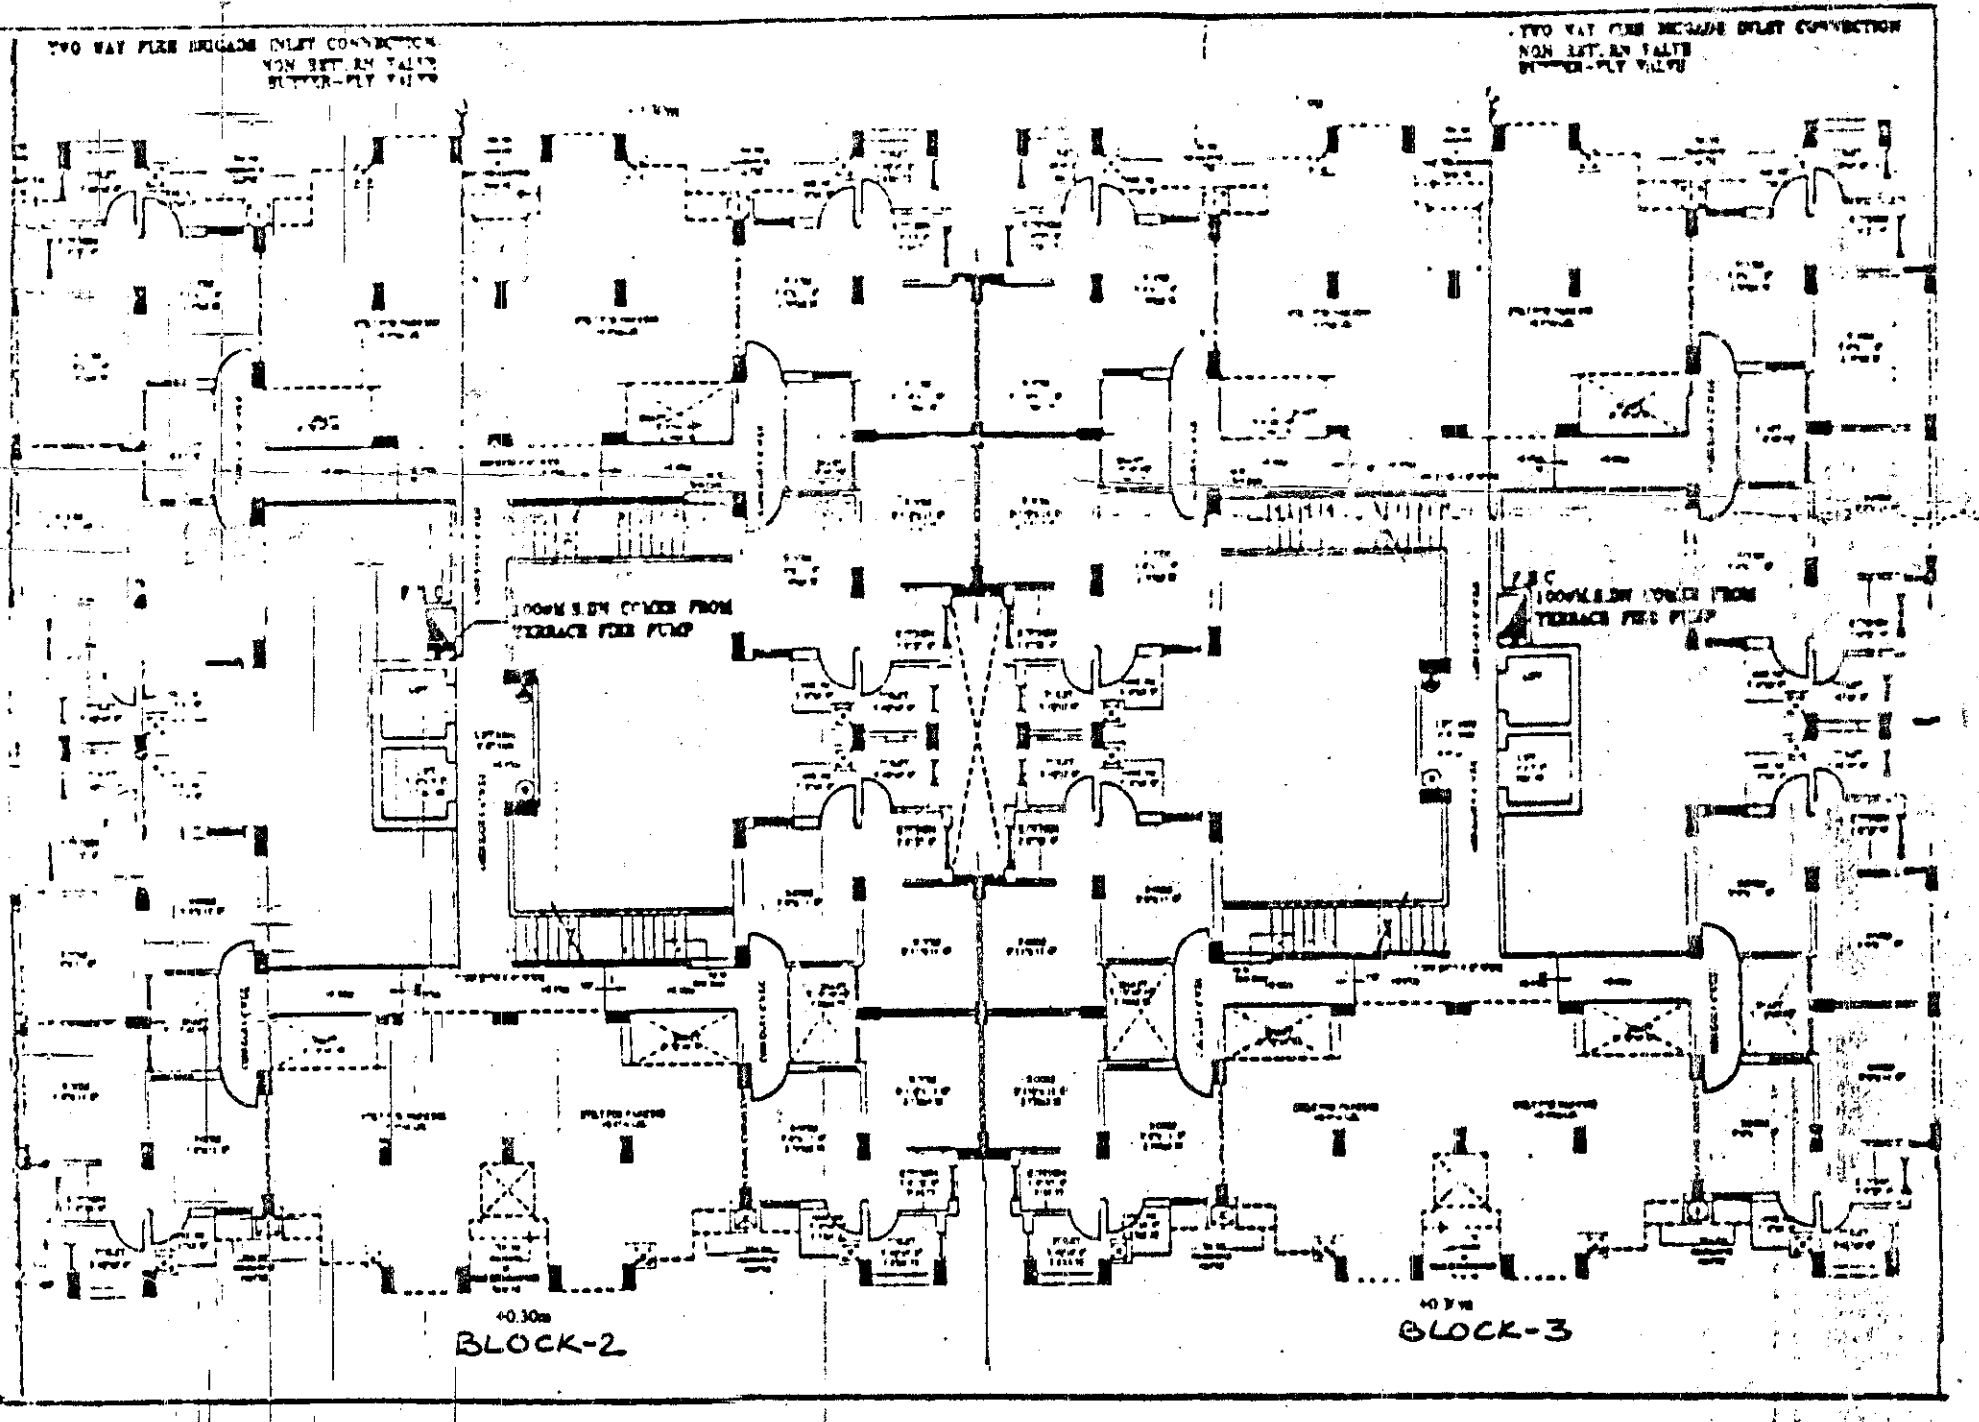

Handwritten notes and signatures at the bottom left of the page.